


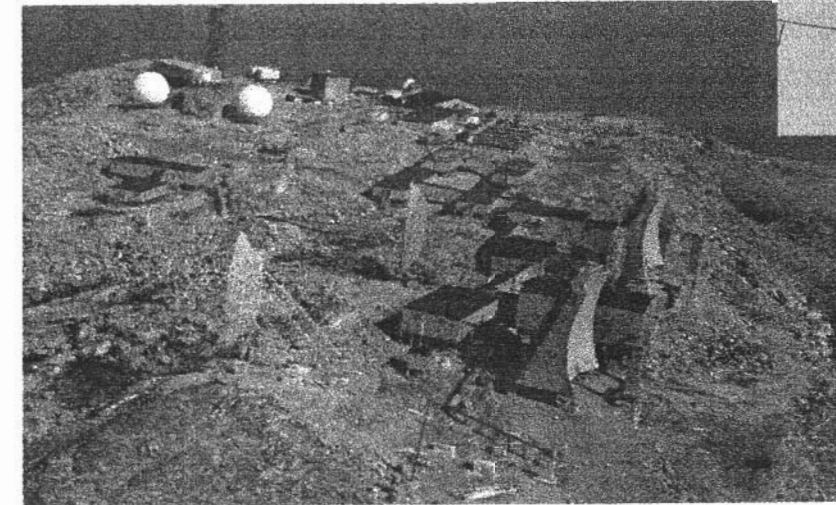


DÉPARTEMENT DES AFFAIRES INDIENNES
ET DU DÉVELOPPEMENT DU NORD

AS-BUILT DRAWING INDEX	
DRAWING NUMBER	TITLE
	SITING
AB-2001-102-01	LOCATION OF BORROW PITS USED DURING THE 2001 WORK SEASON
AB-2001-102-02	DETAILS OF UPPER SITE
AB-2001-102-03	DETAILS OF MAIN PCB STORAGE FACILITY AND SURROUNDING AREA
AB-2001-102-04	DETAILS OF THE RADIO HILL AREA
AB-2001-102-05	DETAILS OF BEACH AREA
AB-2001-102-06	WATER FILTRATION SYSTEM DETAILS
AB-2001-102-07	S1/S4 BUILDING AND DRAINAGE AREA - GRIDDING SYSTEM
RI-2001-102-FSM	FIRE SAFETY PLAN - CORE CAMP LAYOUT
RI-2001-102-FS1	FIRE SAFETY PLAN - CORE CAMP
RI-2001-102-FS2	FIRE SAFETY PLAN - REC. ROOM/LAUNDRY ROOM / DIAND SITE OFFICE / WORKSHOPS
RI-2001-102-FS3	FIRE SAFETY PLAN - WAREHOUSE / MEDIC OFFICE / FIRST AID ROOM / HEALTH & SAFETY OFFICE / ROOM
RI-2001-102-FS4	FIRE SAFETY PLAN - GARAGE
RI-2001-102-FS5	FIRE SAFETY PLAN - TRAINING CENTER




Sinanni inc.

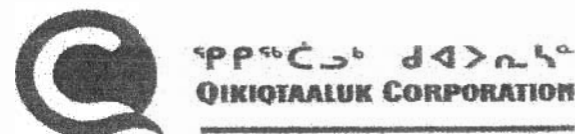[illegible]

$\rho \dot{\sigma}$
 $\rho \rho^b C^b \quad d \langle \rangle \dot{h}^a$

DECEMBER, 2001

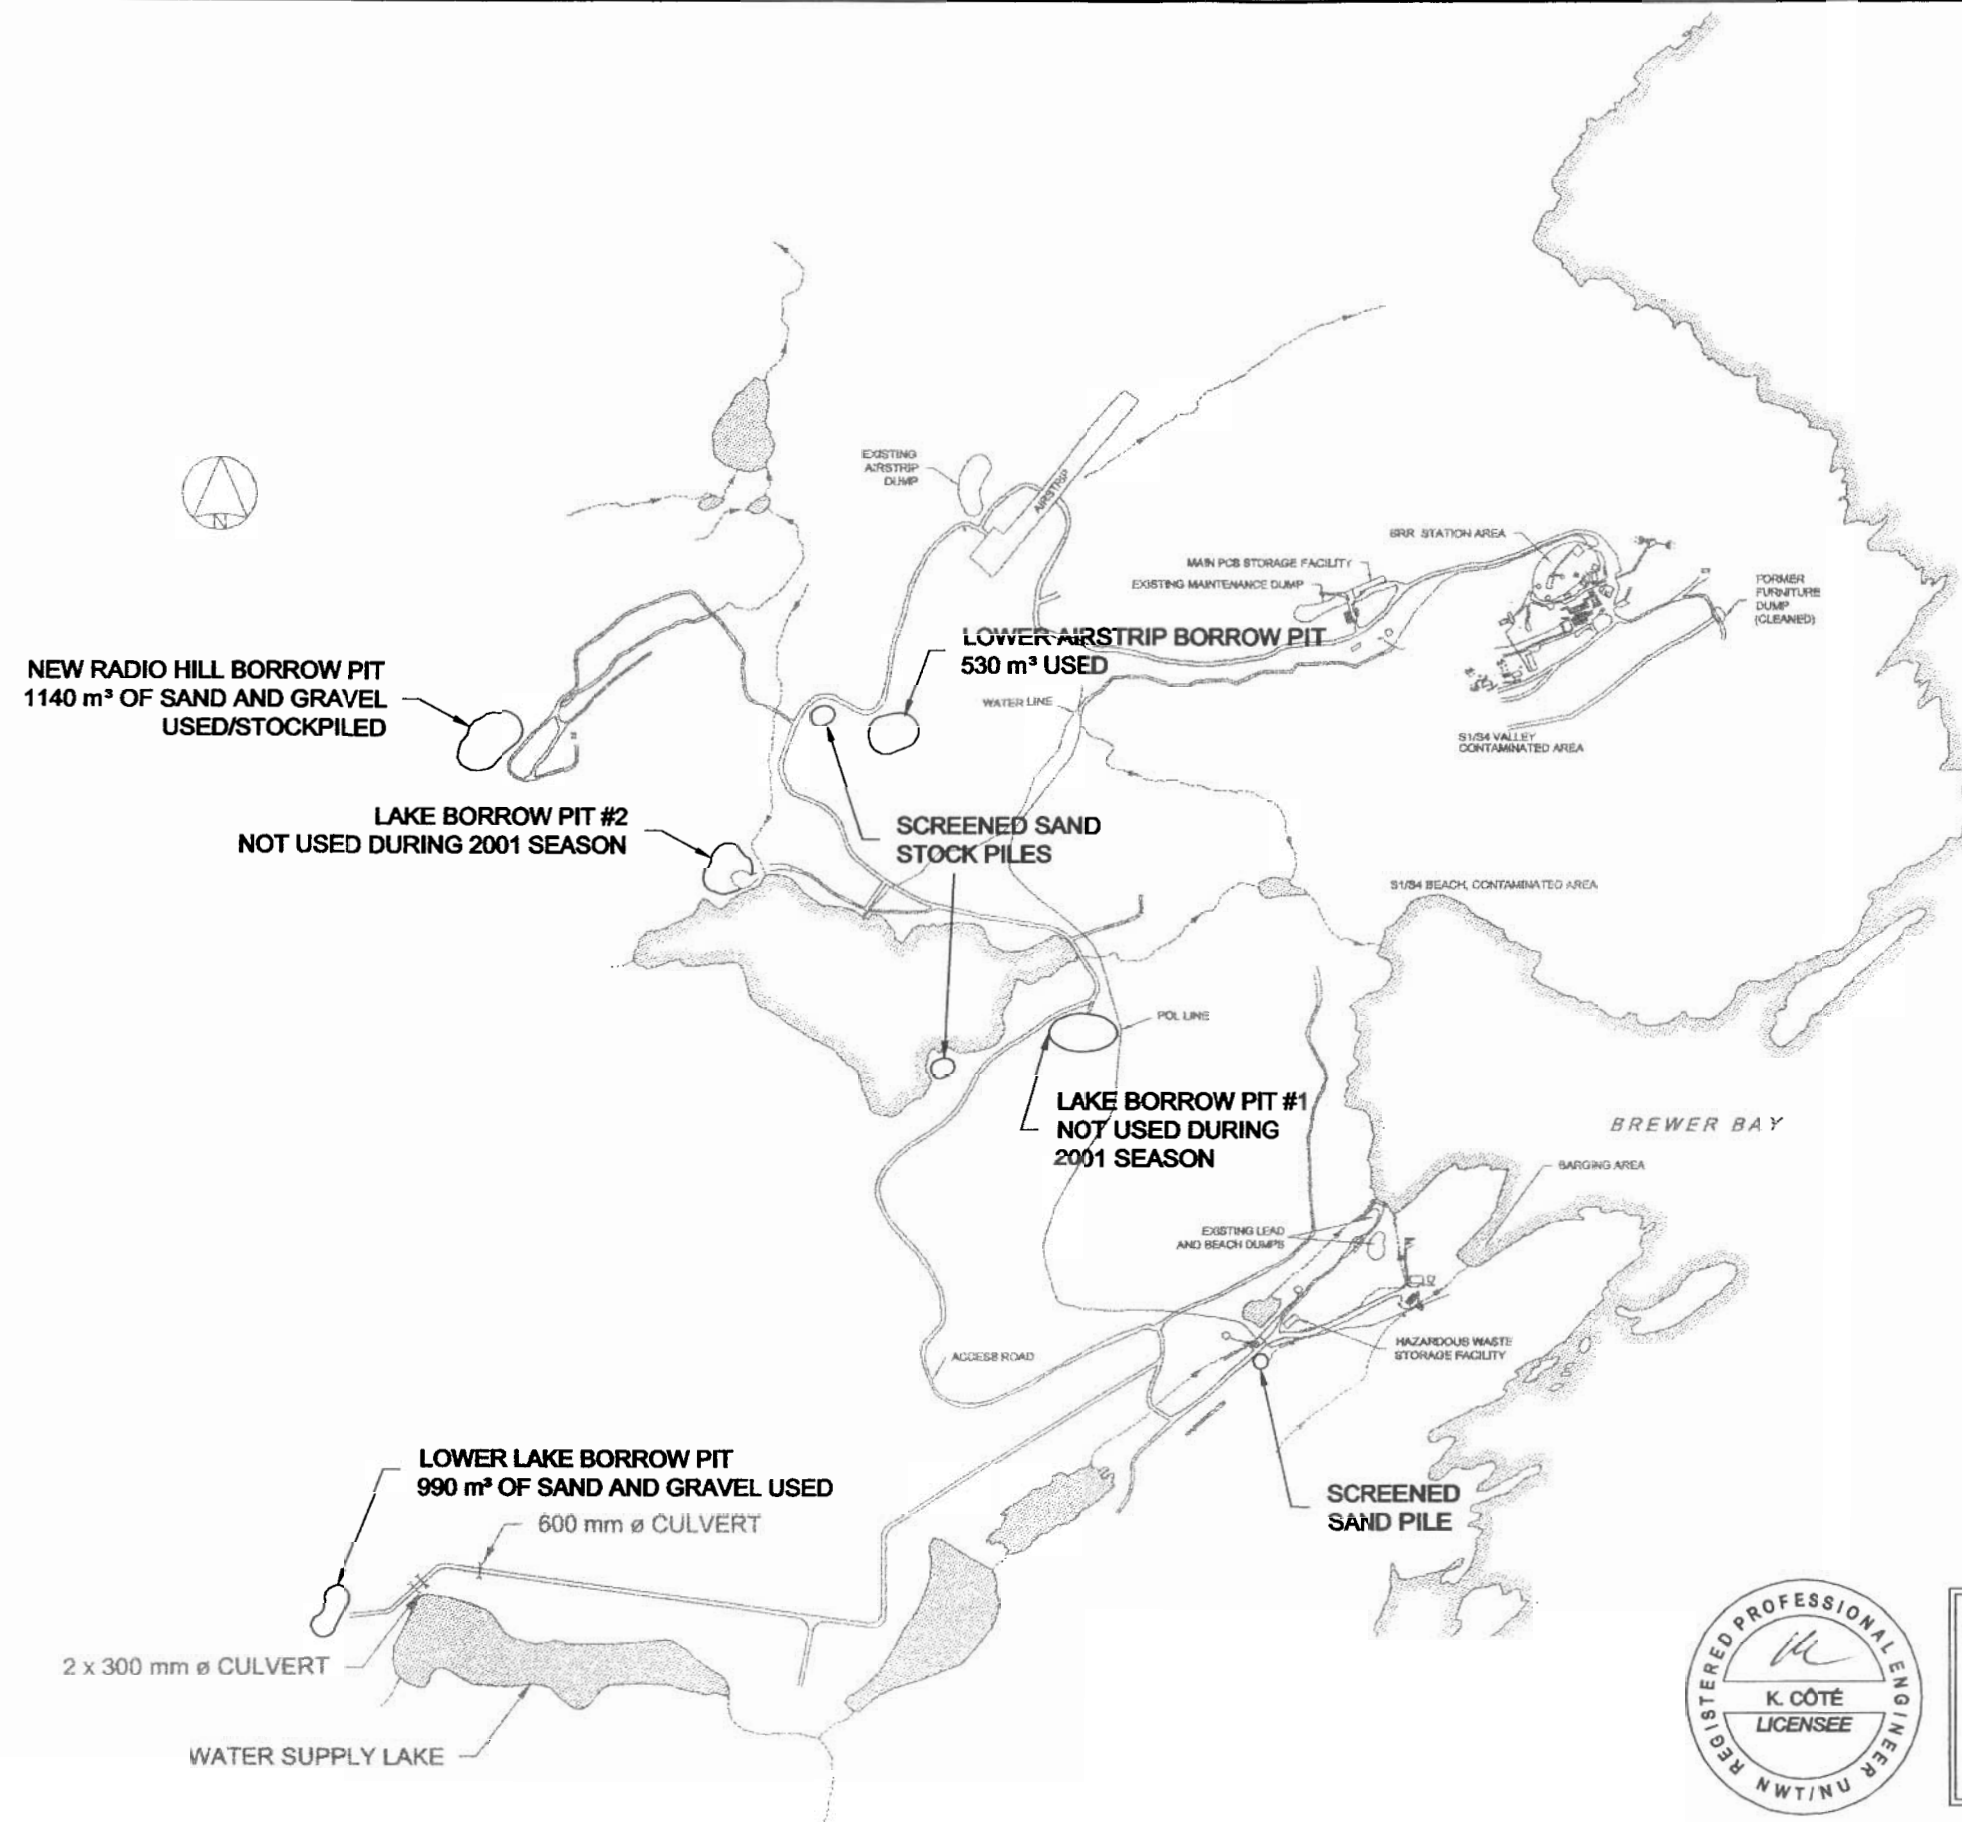

CONTAMINATED SITES OFFICE

GENERAL NOTES:
1. LOCATIONS OF BORROW AREAS AND NEW
ROADS ARE APPROXIMATE AND NOT
SURVEYED.

LEGEND:

No.	DATE	REVISION	REVISION	APPR.
-----	------	----------	----------	-------



SCALE - ÉCHELLE 1:500

PROJECT - PROJET
BAF-5 RESOLUTION ISLAND

© COPYRIGHT HER MAJESTY THE QUEEN
IN THE RIGHT OF CANADA 2001.
AS REPRESENTED BY THE DEPARTMENT OF
INDIAN AFFAIRS AND NORTHERN
DEVELOPMENT

TRADE - MÉTIER
SITING
DATE
2001-12-19

SUBJECT - SUJET


LOCATION OF BORROW PITS USED DURING
THE 2001 WORK SEASON

PRODUCTION	CONCURRENCE - ASSENTMENT
DESIGNED ETUDIÉ	P.S.
DRAWN DRESSÉ	G.J.
CHECKED VÉRIFIÉ	K.C.
COORDINATION	REVIEWED - REVU
DWG. NO. - DESIGN NO. AB-2001-102-01	

Canada



PERMIT TO PRACTICE
SINANNI INC.
Signature *[Signature]*
Date 01/12/20
PERMIT NUMBER: P 410
The Association of Professional Engineers,
Geologists and Geophysicists of the NWT/NU

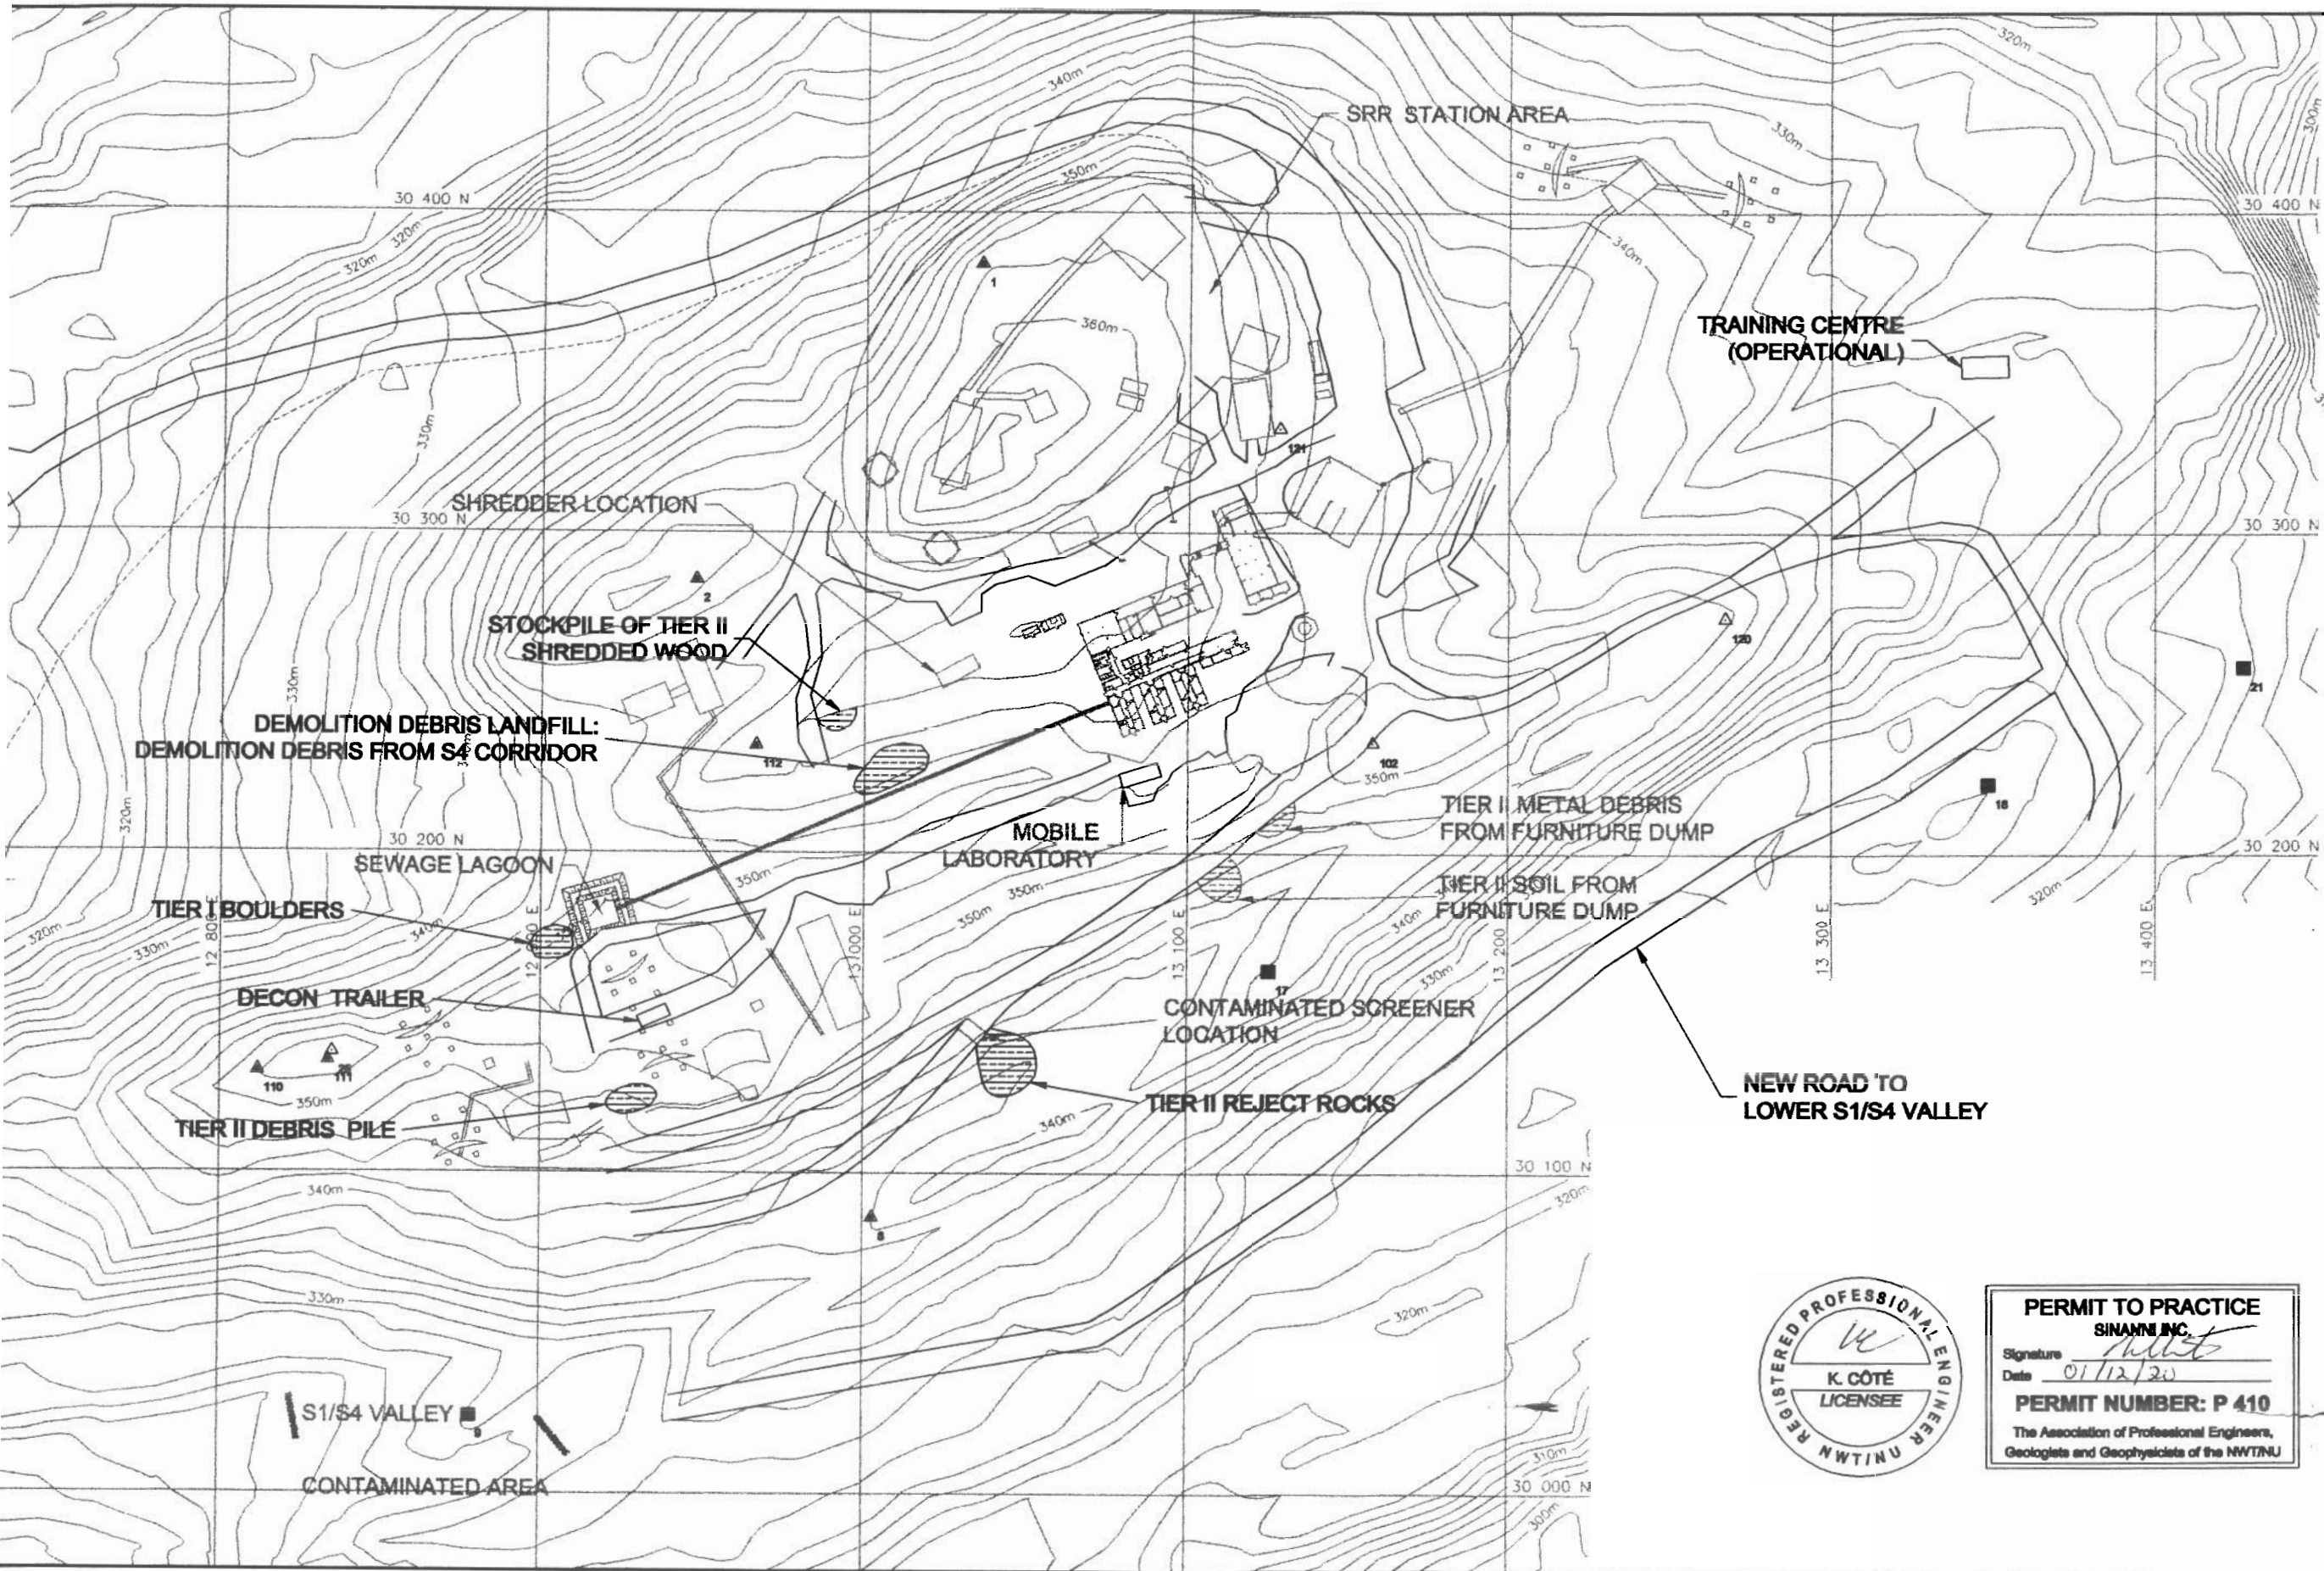

DEPARTMENT OF INDIAN AFFAIRS
AND NORTHERN DEVELOPMENT

CONTAMINATED SITES OFFICE

GENERAL NOTES:

1. NEW ROAD LOCATION IS APPROXIMATE AND NOT SURVEYED.

LEGEND:

BENCHMARK

MEDALLION

TEMPORARY BENCHMARK

LANDFILL LOCATIONS

NO.	DATE	REVISION	REVISION	APPROVAL
1				

Sinanni

SCALE - METERS 0 10 20 30 40

PROJECT - PROJECT

BAF-5 RESOLUTION ISLAND

© COPYRIGHT HER MAJESTY THE QUEEN
IN THE RIGHT OF CANADA 2001,
AS REPRESENTED BY THE DEPARTMENT OF
INDIAN AFFAIRS AND NORTHERN
DEVELOPMENT

TIME - METERS

SITING

DATE

2001-12-19

SUBMIT - SUBMIT

DETAILS OF UPPER SITE

PRODUCTION	CONCURRENCE - AGREEMENT
DESIGNED ALICE	P.S.
DRAWN ALICE	G.J.
CHECKED VERONICA	K.C.
COORDINATION	REVIEWED - REVIEW

DATE - DATE

DATE NO.

AB-2001-102-02

Canada

TEMPORARY BENCH MARKS				
NO.	COORDINATES		ELEVATION	DESCRIPTION
	NORTH	EAST		
6	6830318.2305	412587.1830	319.795	NAIL
103	6830283.2766	412652.8304	316.768	NAIL

STORAGE OF CEPA SOIL
AND CONCRETE DRUMS

CEPA SOIL
CONTAINER
STORAGE AREA
(64 CONTAINERS)

MAIN PCB STORAGE FACILITY
- 1465 m³ OF CEPA SOIL STOCKPILED
- 9 CONTAINERS OF CEPA SOIL

STAGING AREA FOR DRUMS
TO BE PROCESSED

STORAGE SEA CANS

INCINERATION
PLATFORM

WASHED DRUM
STAGING AREA

DEPARTMENT OF INDIAN AFFAIRS
AND NORTHERN DEVELOPMENT

CONTAMINATED SITES OFFICE

General Notes:
1. ALL DRUM PILES AT THE IMPOLOD TANK AREA
WERE REMOVED AND MANAGED AT THE POL
INCINERATION PLATFORM

Legend:
△ BENCHMARK
△ MEDALLION
■ TEMPORARY BENCHMARK
— BURIED ELECTRICAL LINE

NO.	DATE	REVISION	REVISION	APPR.
-----	------	----------	----------	-------



SCALE - METERS

PROJECT - PROJECT
BAF-5 RESOLUTION ISLAND

© COPYRIGHT HER MAJESTY THE QUEEN
IN THE RIGHT OF CANADA 2001,
AS REPRESENTED BY THE DEPARTMENT OF
INDIAN AFFAIRS AND NORTHERN
DEVELOPMENT

WIDE-METER SITING DATE
2001-12-19

SUBJECT-SUBJECT

DETAILS OF THE MAIN PCB STORAGE FACILITY AND
SURROUNDING AREA


PRODUCTION	CONCURRENCE - AGREEMENT
DRAWN ETUDE	P.S.
CHECKED DESIGN	G.J.
CHECKED VERIFICATION	K.C.
COORDINATION	REVISIONS - REVU

DATE, NO. - DESIGN NO.
AB-2001-102-03

Canada



PERMIT TO PRACTICE
SINANNI INC.
Signature *[Signature]*
Date 01/12/20
PERMIT NUMBER: P 410
The Association of Professional Engineers,
Geologists and Geophysicists of the NWT/NU

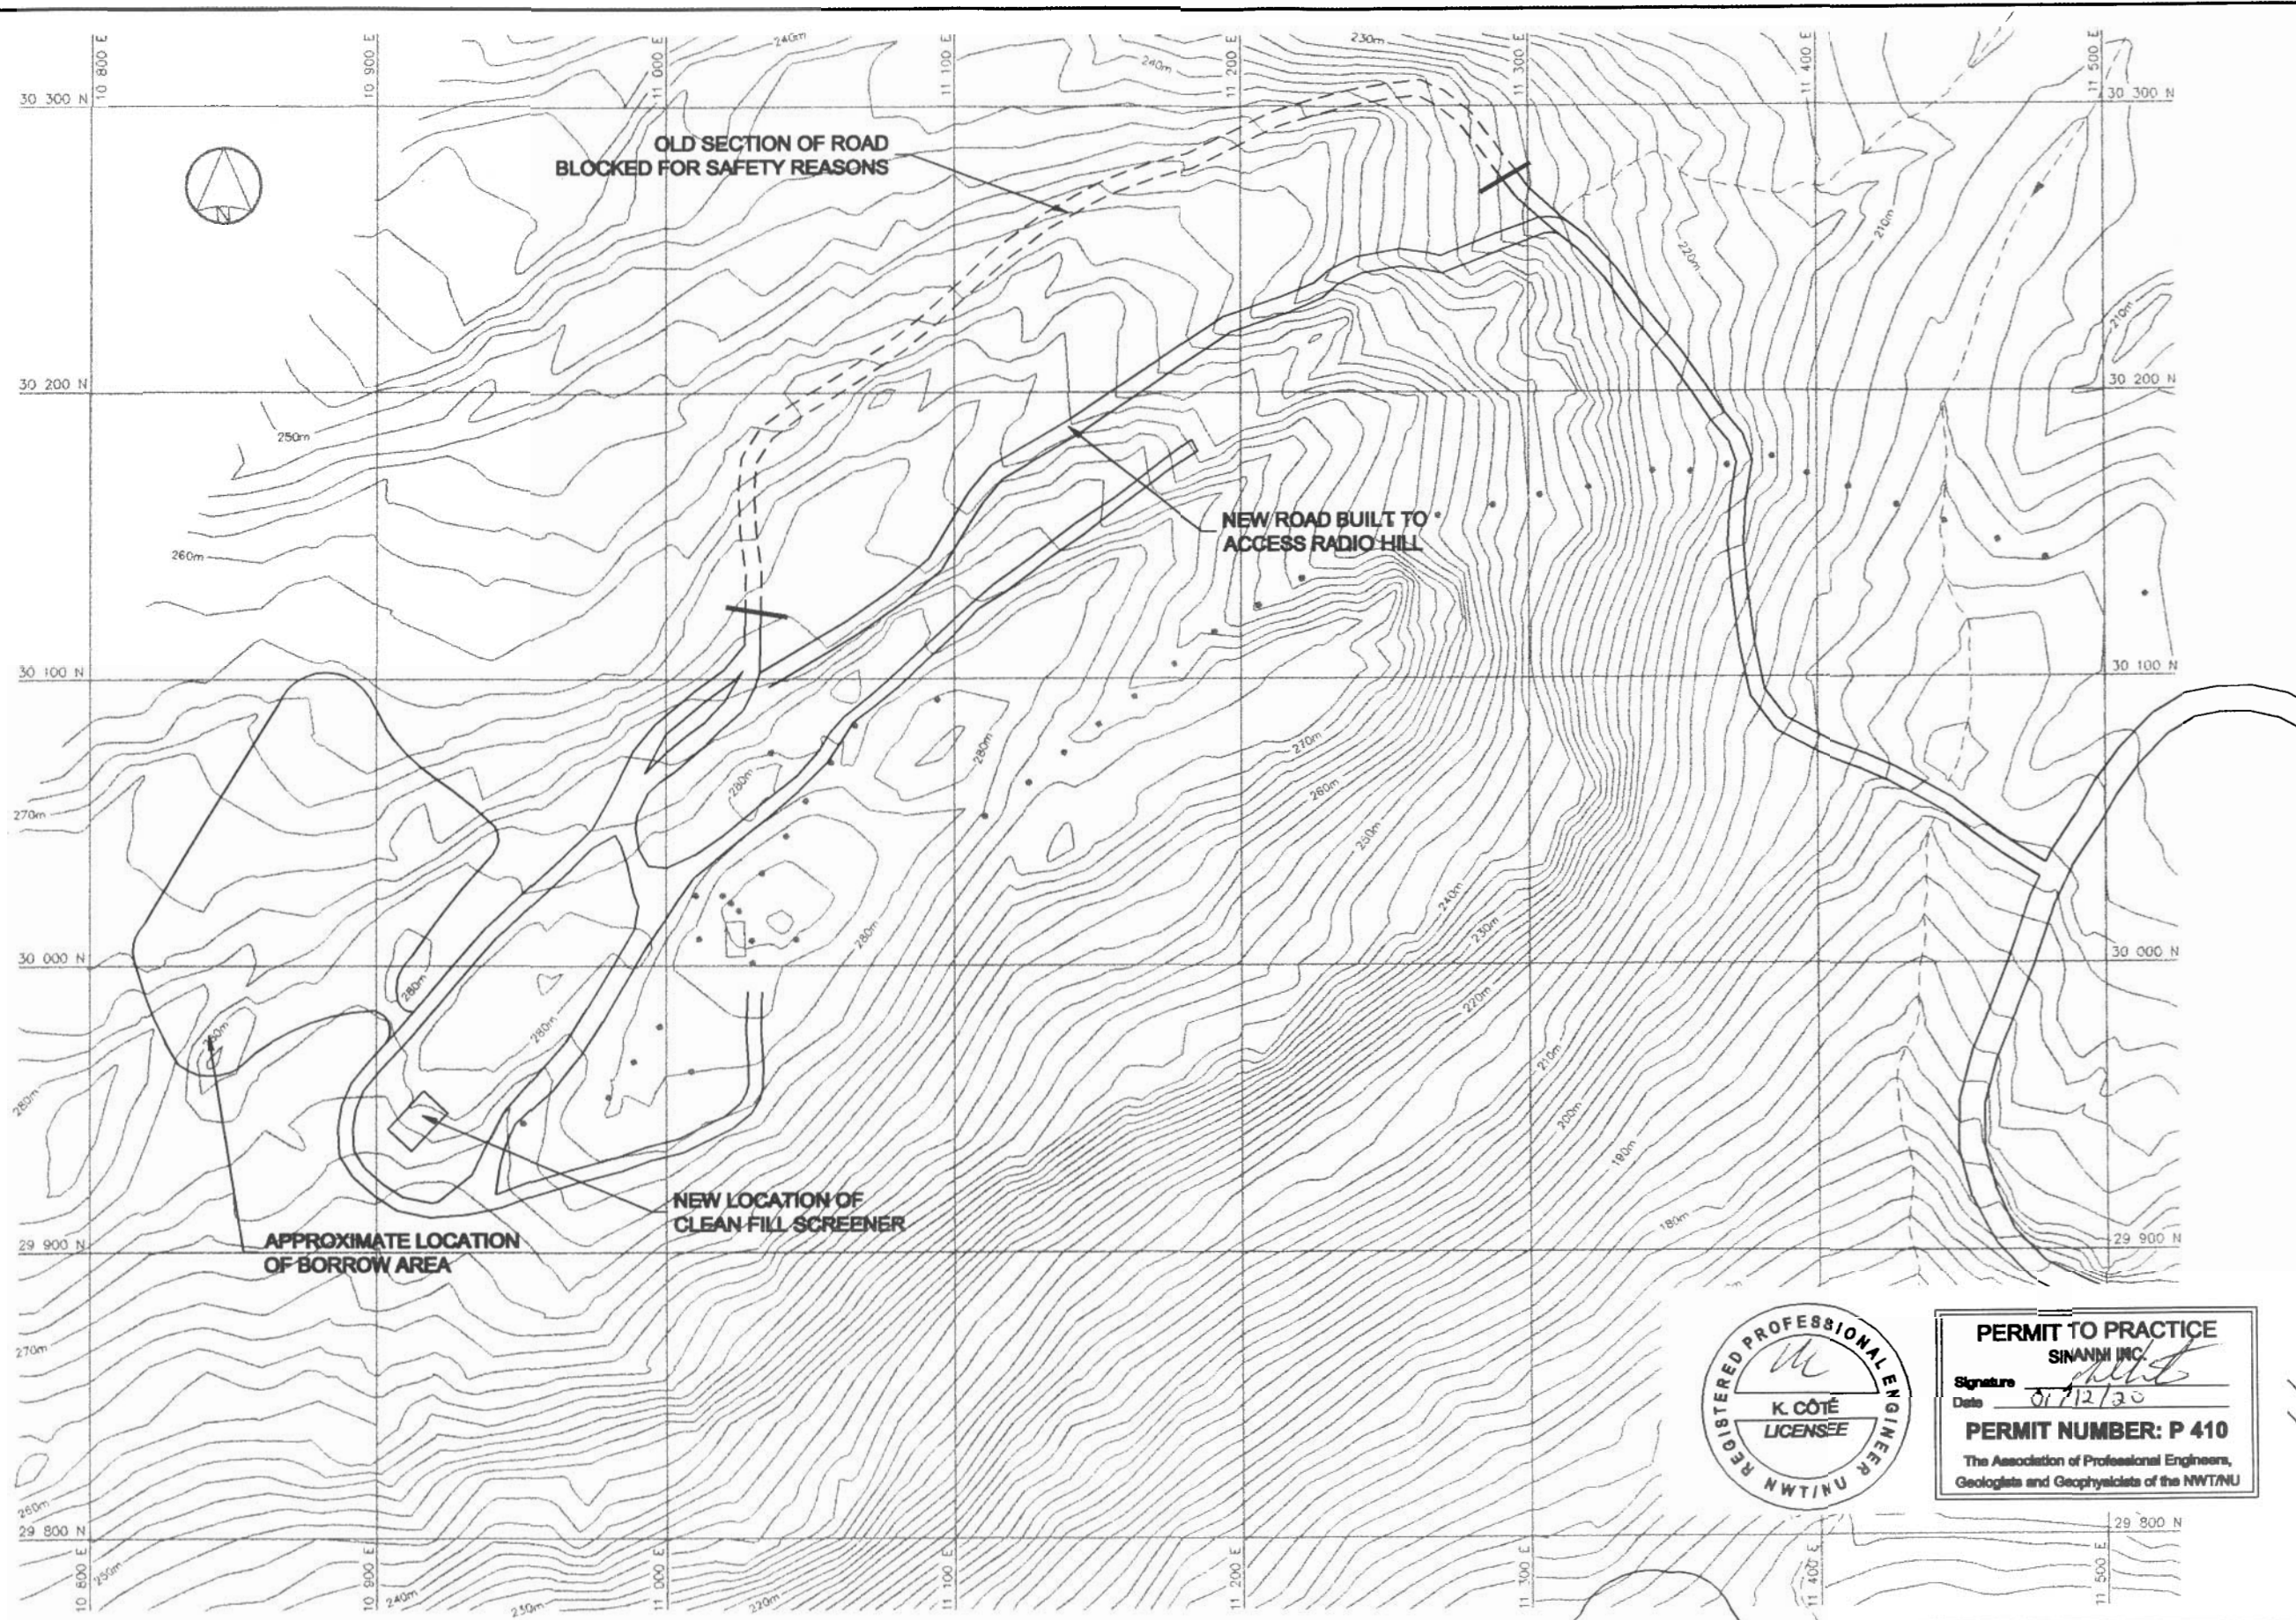

DEPARTMENT OF INDIAN AFFAIRS
AND NORTHERN DEVELOPMENT

CONTAMINATED SITES OFFICE

General Notes:

1. ALL SCATTERED DRUMS AT RADIO HILL WERE REMOVED AND MANAGED AT THE POL INCINERATION PLATFORM.

Legend:

- LOCATION OF ELECTRICAL POLES

No.	DATE	REVISION	REVISION	APPR.

SINANNI CORPORATION

Sinanni INC.

SCALE - ECHELLE 1:5000

PROJECT - PROJET
BAF-5 RESOLUTION ISLAND

© COPYRIGHT HER MAJESTY THE QUEEN
IN THE RIGHT OF CANADA 2001,
AS REPRESENTED BY THE DEPARTMENT OF
INDIAN AFFAIRS AND NORTHERN
DEVELOPMENT

TRACÉ - SECTEUR
SITING

DATE
2004-12-18

SUBJECT - SUJET

DETAILS OF THE RADIO HILL AREA

PRODUCTION	CONCURRENCE - AMBLEMENT
DRAWN BY DATE	P.S.
DRAWN BY DATE	G.J.
CHECKED BY DATE	K.C.
COORDINATION	REVIEWED - REVU

DRAWN NO. - DESIGNE NO.
AS-2001-102-04



PERMIT TO PRACTICE
SINANNI INC.
Signature: *[Signature]*
Date: 01/12/20
PERMIT NUMBER: P 410
The Association of Professional Engineers,
Geologists and Geophysicists of the NWT/NU

CONTAMINATED SITES OFFICE

General Notes:

Legend:

- NON-HAZARDOUS WASTE
- ASBESTOS LANDFILL
- BENCH MARK
- MEDALLION
- TEMPORARY BENCHMARK

NO.	DATE	REVISION	REVISION	APPR.



SCALE - ECHELLE

PROJECT - PROJET
BAF-5 RESOLUTION ISLAND

© COPYRIGHT HER MAJESTY THE QUEEN
IN THE RIGHT OF CANADA 2001,
AS REPRESENTED BY THE DEPARTMENT OF
INDIAN AFFAIRS AND NORTHERN
DEVELOPMENT

TITLE - TITRE
SITING
DATE
2011-12-19

SUBJECT - SUJET
DETAILS OF THE BEACH AREA

PRODUCTION
CONCURRENCE - ASSENTMENT

DESIGNED
ETUDE
P.S.


DRAWN
DESINÉ
G.J.

CHECKED
VÉRIFIÉ
K.C.

COORDINATION
COORDINATION
REVIEWED - REVU

NO. - DESIGN NO.
AB-2001-102-06

Canada

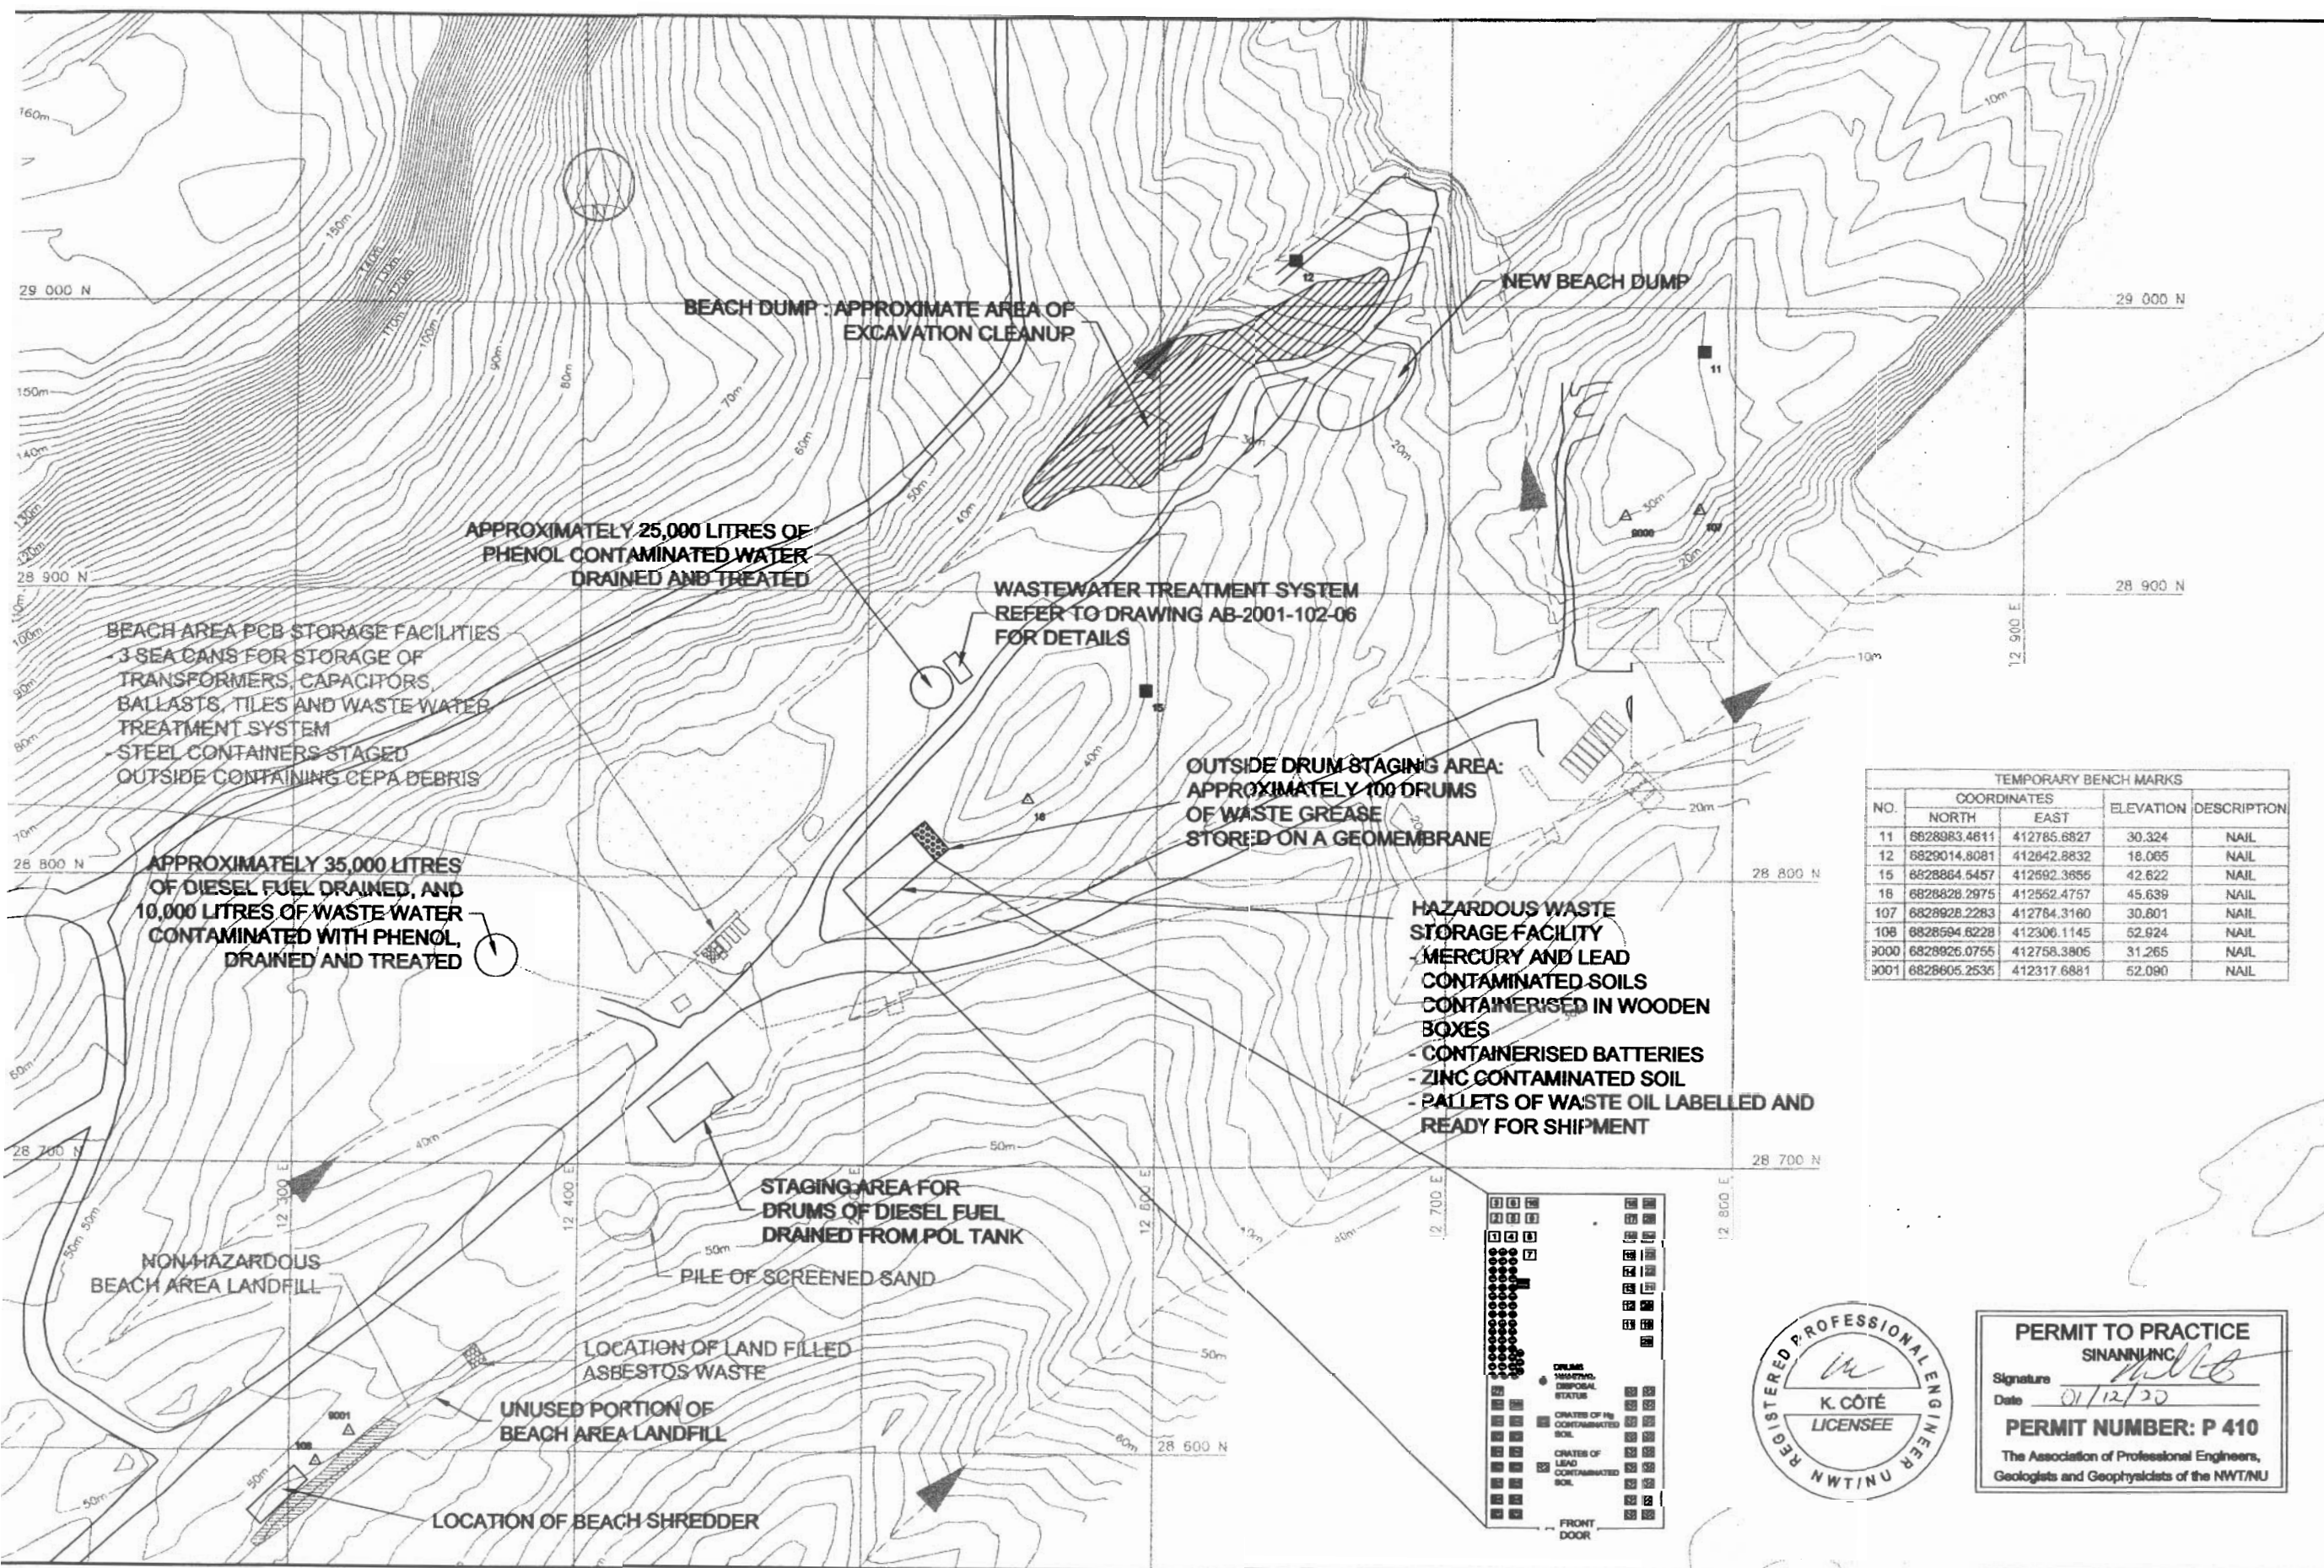

TEMPORARY BENCH MARKS				
NO.	COORDINATES		ELEVATION	DESCRIPTION
	NORTH	EAST		
11	6828983.4811	412785.6827	30.324	NAIL
12	6829014.8081	412842.8832	18.065	NAIL
15	6828864.5457	412592.3655	42.622	NAIL
16	6828828.2975	412552.4757	45.639	NAIL
107	6828928.2283	412784.3160	30.801	NAIL
108	6828594.6228	412306.1145	52.924	NAIL
3000	6828926.0755	412758.3805	31.265	NAIL
3001	6828605.2535	412317.6881	52.090	NAIL




PERMIT TO PRACTICE
SINANNI INC.


Signature: *[Signature]*
Date: 01/12/20

PERMIT NUMBER: P 410


The Association of Professional Engineers,
Geologists and Geophysicists of the NWT/NU

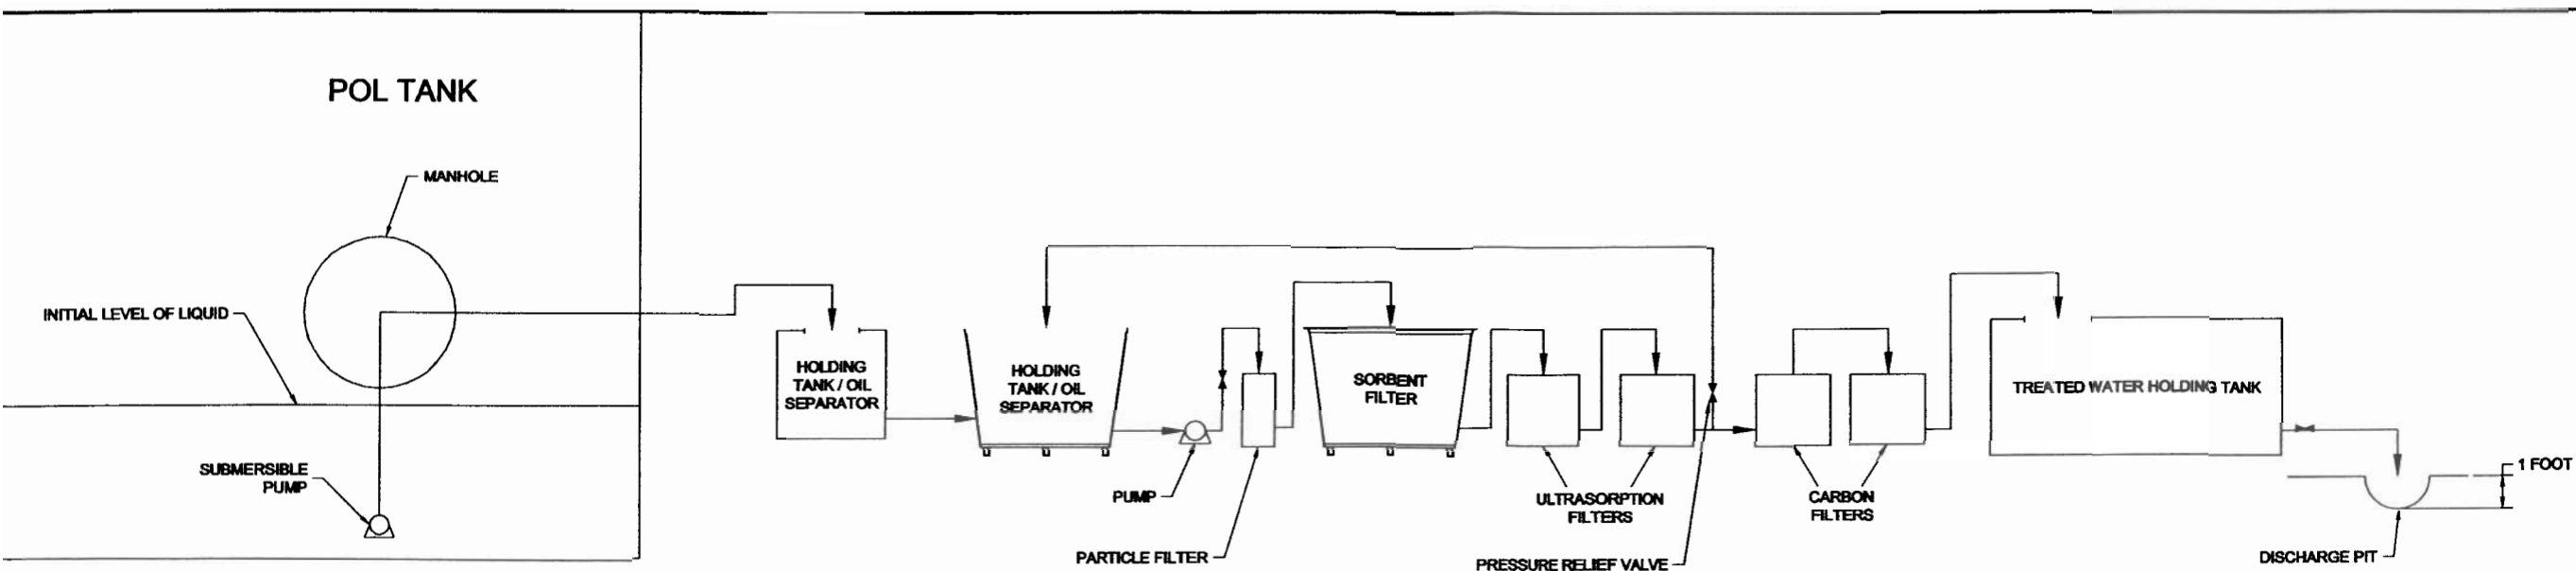

PROCESS FLOW DIAGRAM

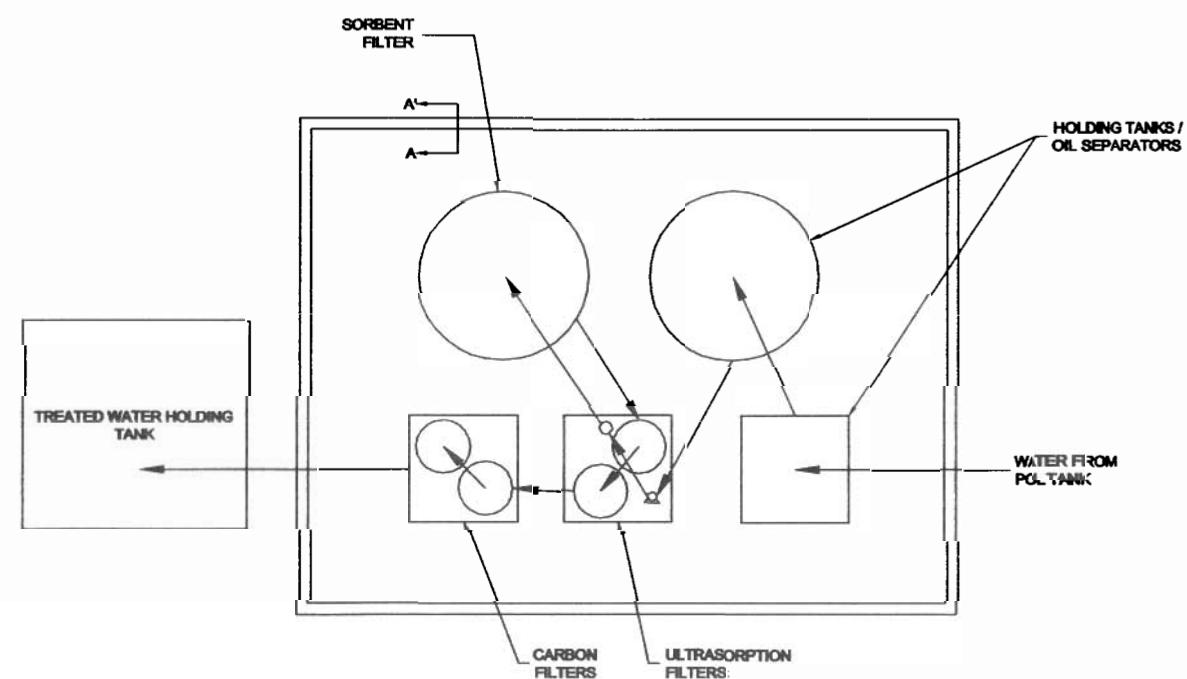

LAYOUT

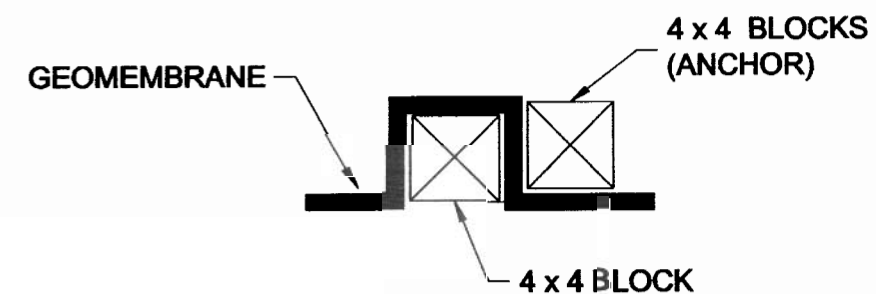

CROSS SECTION A-A'



PERMIT TO PRACTICE	
SINANNI INC.	
Signature	<i>[Signature]</i>
Date	01/12/20
PERMIT NUMBER: P 410	
The Association of Professional Engineers, Geologists and Geophysicists of the NWT/NU	

CONTAMINATED SITES OFFICE				
GENERAL NOTES:				
1.				
LEGEND:				
No.	DATE	REASON	REVISION	APPR.
SCALE - ÉCHELLE NOT TO SCALE				
PROJECT - PROJET BAF-5 RESOLUTION ISLAND				
© COPYRIGHT HER MAJESTY THE QUEEN IN THE RIGHT OF CANADA 2001, AS REPRESENTED BY THE DEPARTMENT OF INDIAN AFFAIRS AND NORTHERN DEVELOPMENT				
TRADE - MÉTIER	SITING		DATE: 20/01-12-19	
SUBJECT - SUJET				
WATER FILTRATION SYSTEM DETAILS				
PRODUCTION		CONCURRENCE - ASSÉNTIMENT		
DESIGNED ÉTUDE	K.C.			
DRAWN Dessin	G.J.			
CHECKED VÉRIFIÉ	P.S.			
COORDINATION	REVIEWED - REVU			
DWG. NO. - Dessin NO. AB-2001-102-08				