

FINAL COVER PLAN

0 4 8 12 m SCALE 1:400

SCALE 1:400


0 4 8 12 m

SCALE 1:400

0 4 8 12 m

COORDINATE POINT

PROPOSED MONITORING WELL LOCATION

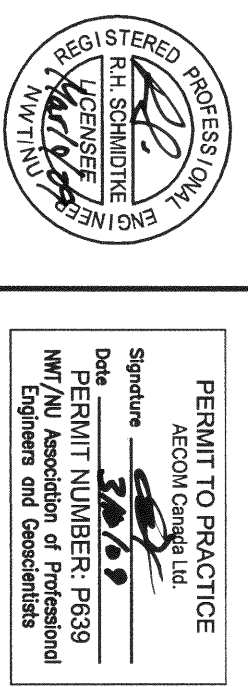

UMA | AECOM

0	ISSUED FOR CONSTRUCTION	09/03/1
REVISIONS	DESCRIPTION	DATE

CAM-D
REMEDICATION PROJECT

NON-HAZARDOUS WASTE LANDFILL PLAN

approved by	T. ESPIRETER	control
drawn by	B. HASSELER	detailed par
approved by	R. SCHMIDTKE	approved par
PMSOC Project Manager	M. MCELWANE	Administrateur de Projets PMSOC
scale	1:200	scale
project no.	416837	project no.
date	MARCH, 2009	date
		C09
		OF 11

 Public Works and
Government Services
Canada

 Travaux publics et
Services gouvernementaux
Canada

REAL PROPERTY SERVICES
Western Region

Client **Indian and Northern Affairs Canada** **Client** **Affaires indiennes et du Nord Canada**

Canada
NUNAVUT REGIONAL OFFICE
IGALUIT, NUNAVUT

GENERAL NOTES

1. ALL DIMENSIONS ARE IN METRES UNLESS NOTED OTHERWISE.

NOTED OTHERWISE.

2. SITE PLANS AND TOPOGRAPHIC INFORMATION ARE BASED ON AIR PHOTOS AND SURVEY PROVIDED BY EARTH TECH AND INAC. CURRENT CONDITIONS MAY NOT BE EXACTLY AS SHOWN.

CONDITIONS MAY NOT BE EXACTLY AS SHOWN

3. ALL COORDINATES ARE SITE COORDINATES AND ALL ELEVATIONS ARE BASED ON SITE DATUM.

