


- NOTES:
- FOR GENERAL GROUNDING NOTES
SEE STANDARD DWG. 0000-47DC-9150.
 - FOR GROUNDING LEGEND
SEE STANDARD DWG. 0000-47DA-9004.
 - FOR GROUNDING CONNECTIONS FOR
DIFFERENT ELECTRICAL EQUIPMENT
SEE STANDARD DWG. 0000-47DC-9157.

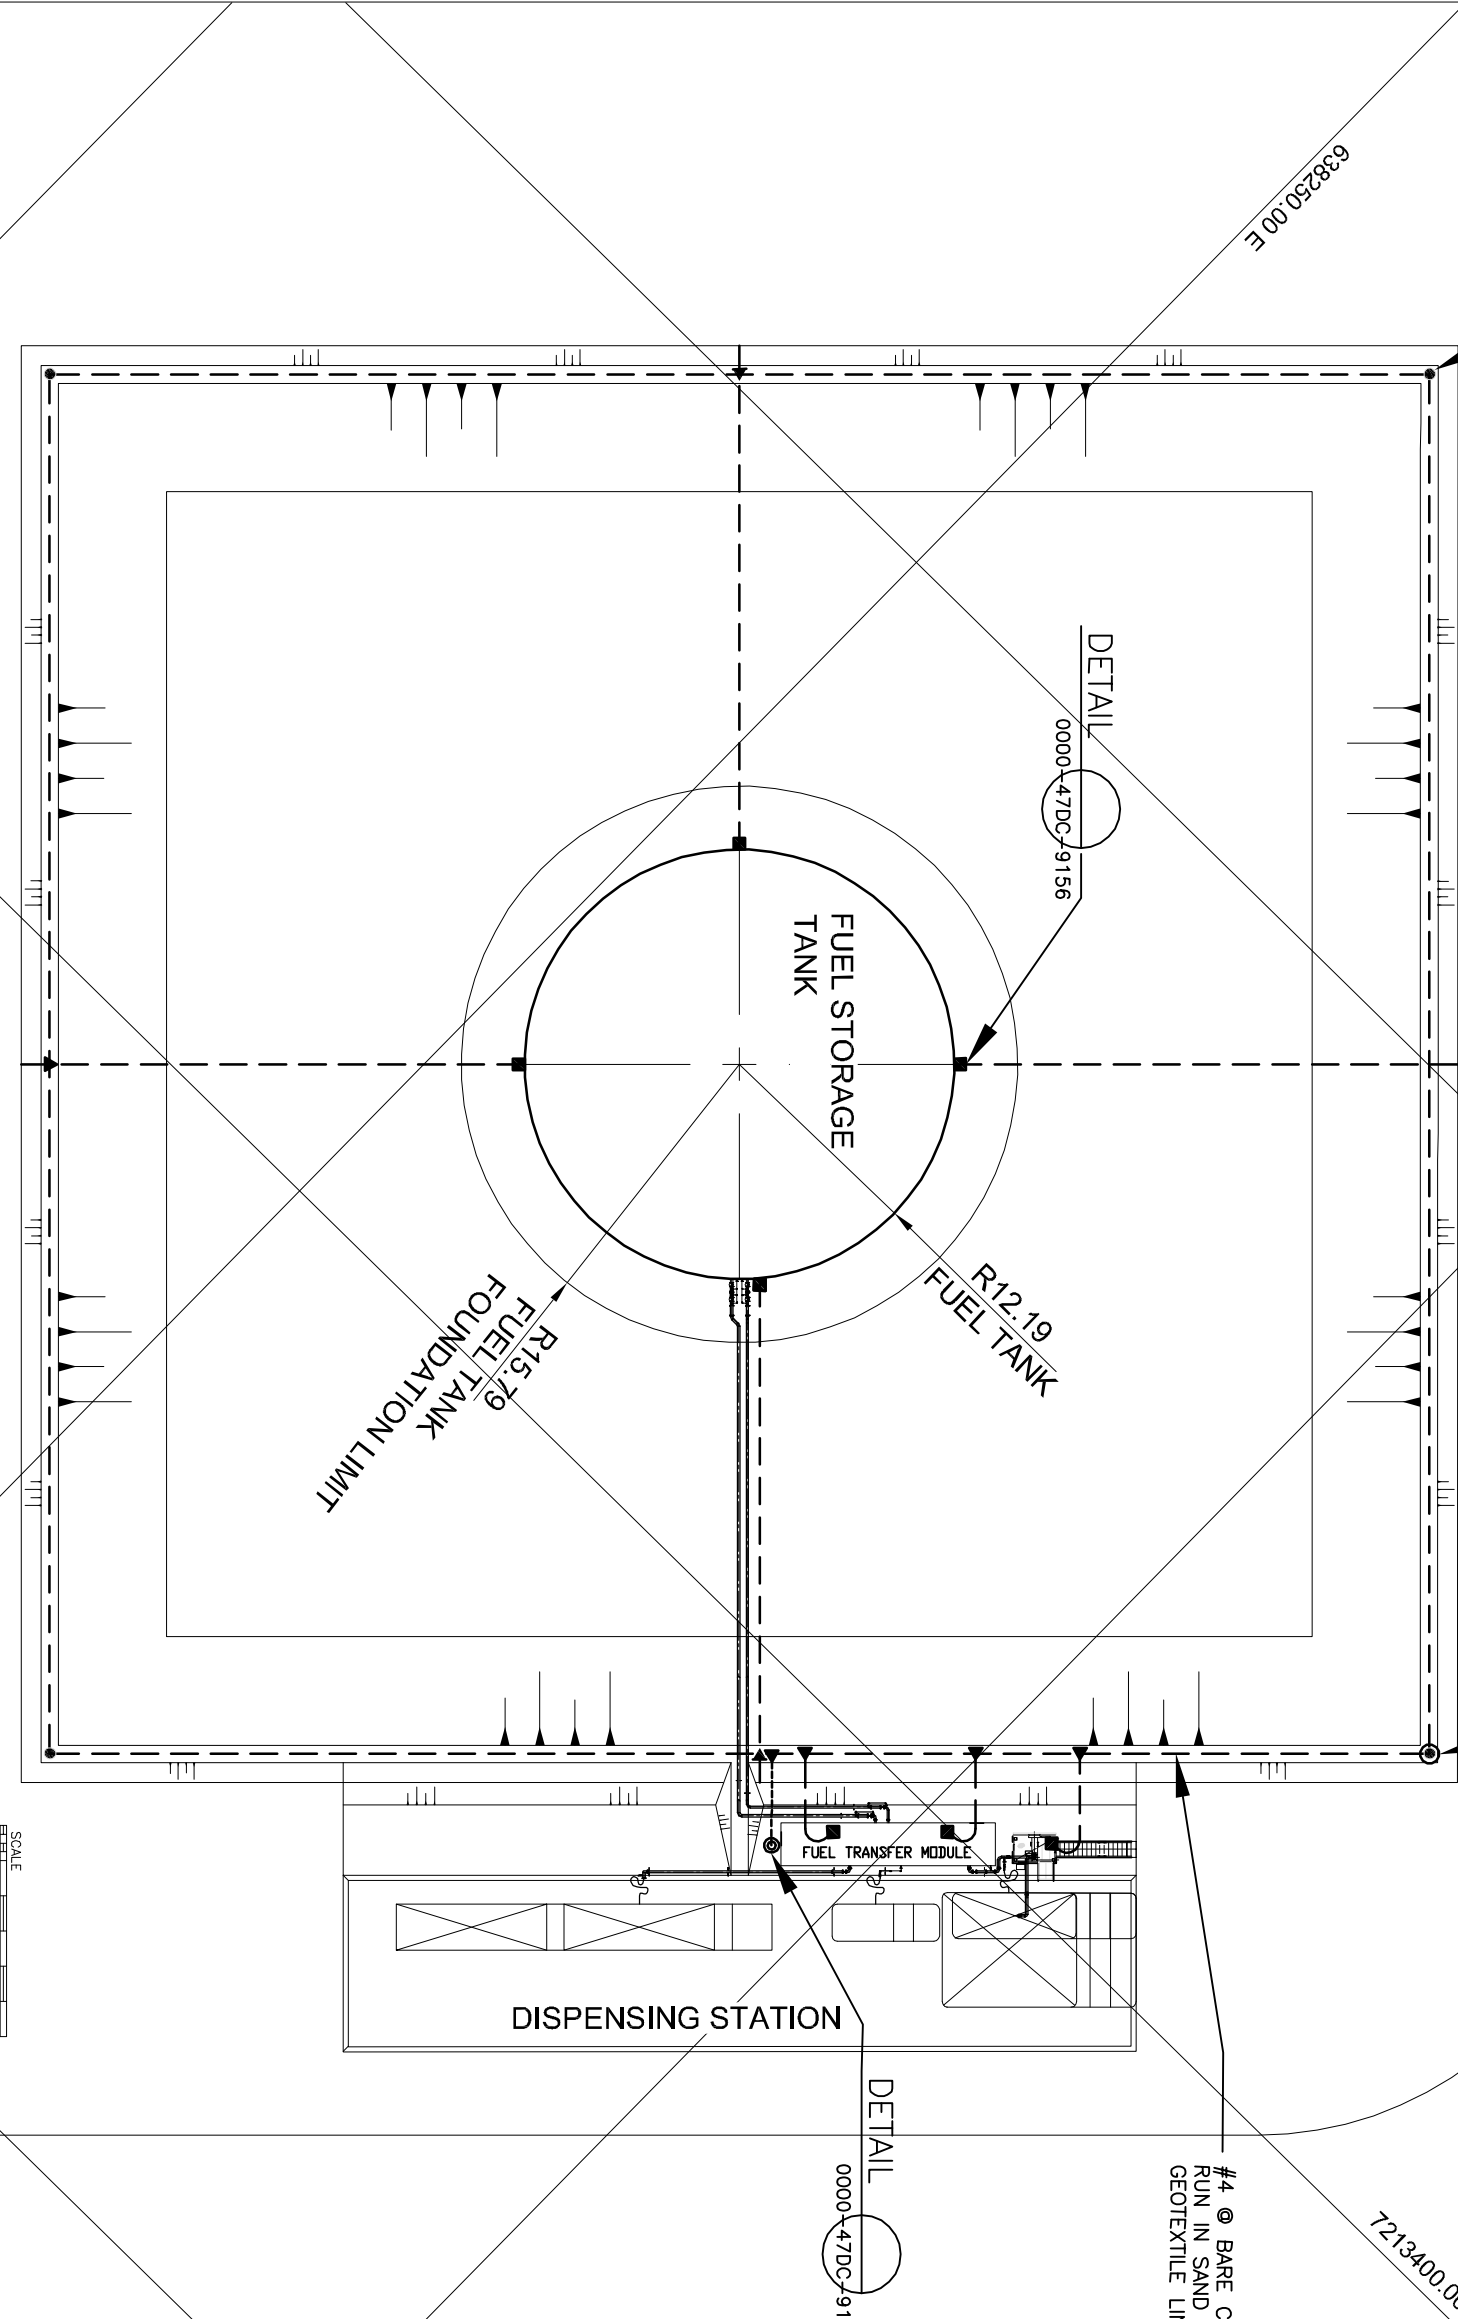

SCALE
0 2 4 6 8 10m

ENGINEER'S STAMP		SECTION: ELECTRICAL	
		SCALE: AS SHOWN	DATE: APR 2006
DESIGNED BY: A.R. WACHMANN		DESIGNED BY: J. MARTINEZ	DATE: APR 2006
CHECKED BY: R. LUEDEN		CHECKED BY: F. REYES	DATE: 1 MAY 2006
APPROVED BY: A.R. WACHMANN		APPROVED BY: R. LUEDEN	DATE: 1 MAY 2006

MEADOWBANK GOLD PROJECT	
DIESEL FUEL TANK FARM GROUNDING LAYOUT PLAN	
PROJECT NUMBER: 017202	DRAWING NUMBER: 2000-47D1-2001
REV: PA	REV: PA