
 
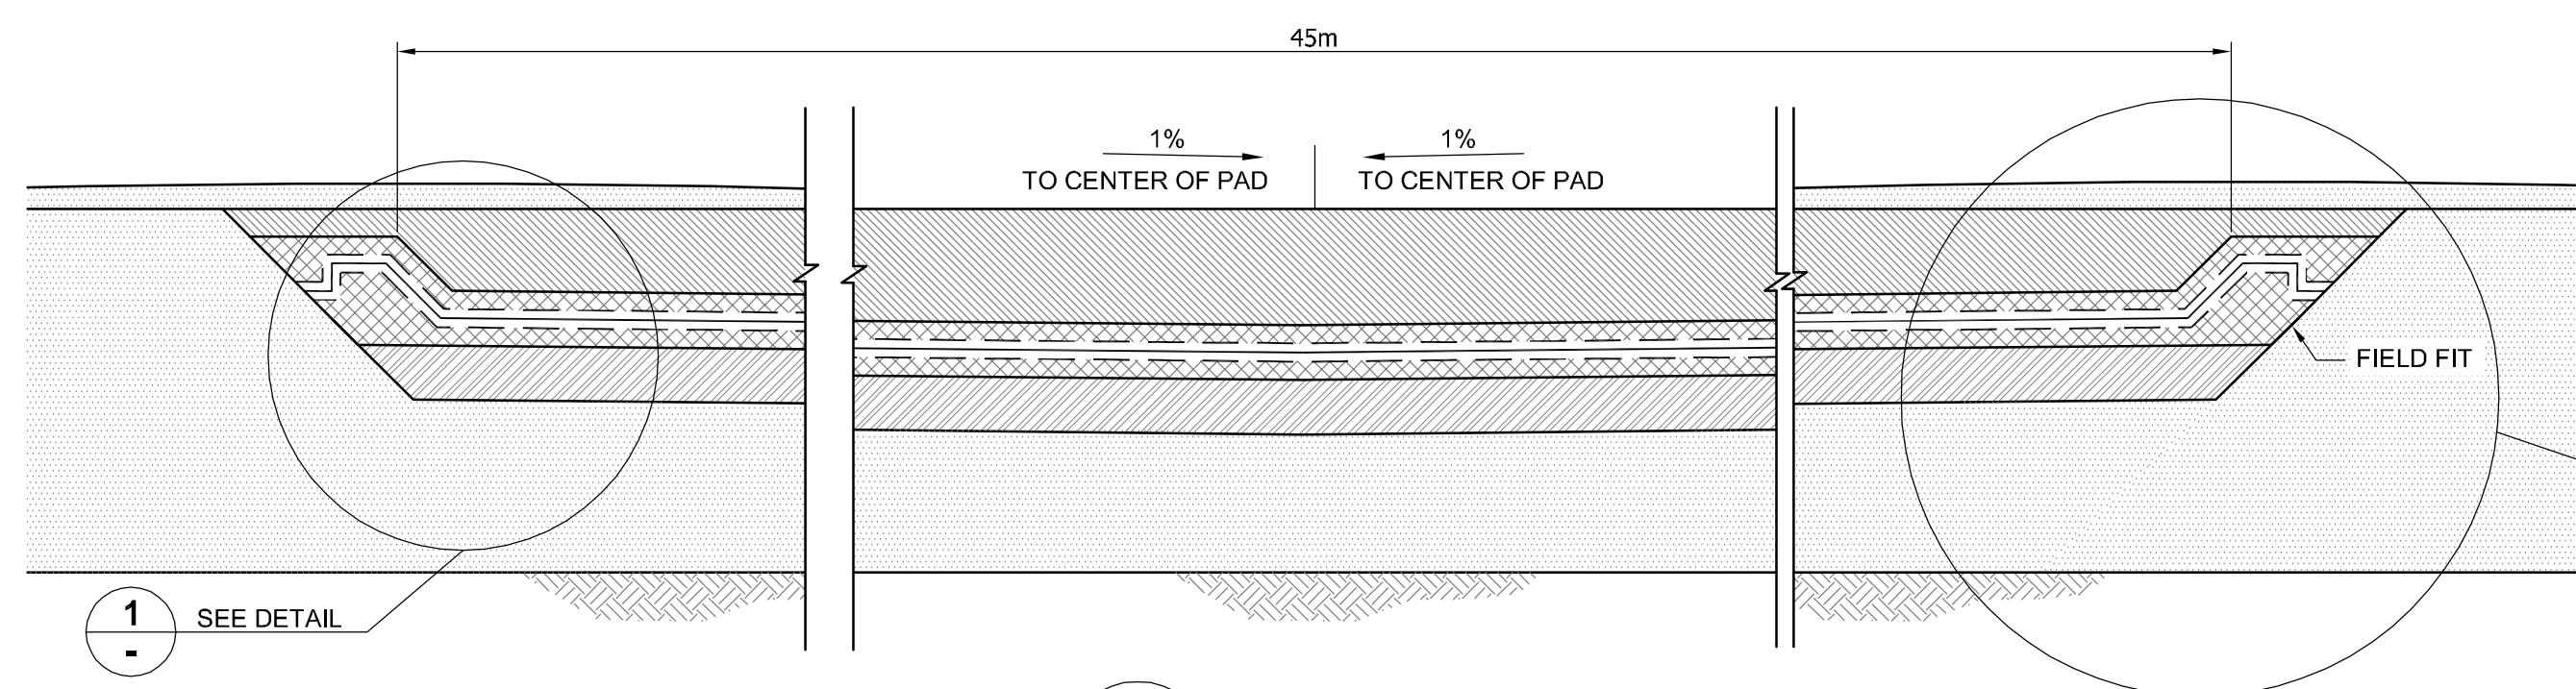
 


The site plan illustrates the layout of the fuel system. At the bottom, a semi-circular **FUEL TANK** is shown. A vertical line representing the **C/L OF FUEL PIPE** runs from the tank to the **FUEL PUMP DISPENSING MODULE** and the **DIESEL GENERATOR MODULE**. The dispensing module is labeled **D** and the generator module is labeled **D'**. Both modules are connected to a network of pipes. Several valves are indicated by circular symbols with a triangle and the number **208**, labeled **A**, **A'**, **B**, **B'**, **C**, and **C'**. The plan also shows **EROSION PROTECTION** measures and various slope percentages (1%, 2%) for the ground surface. Dimensions of 10m, 4m, and 2.4m are provided for specific areas.


 
PLAN

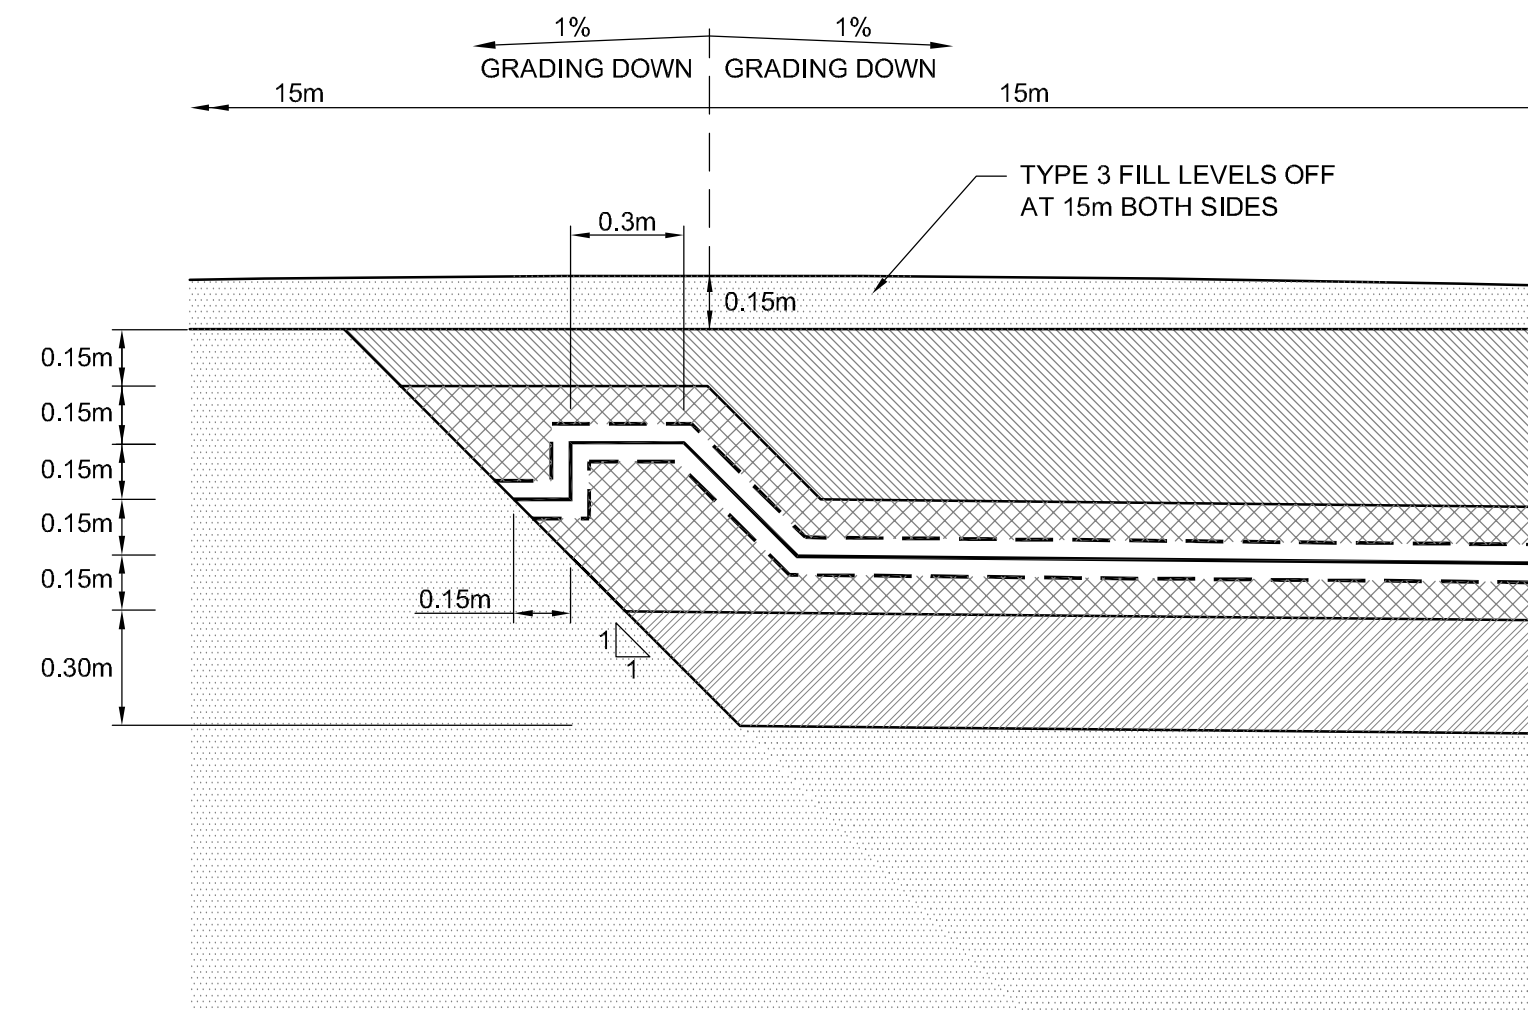


A



1

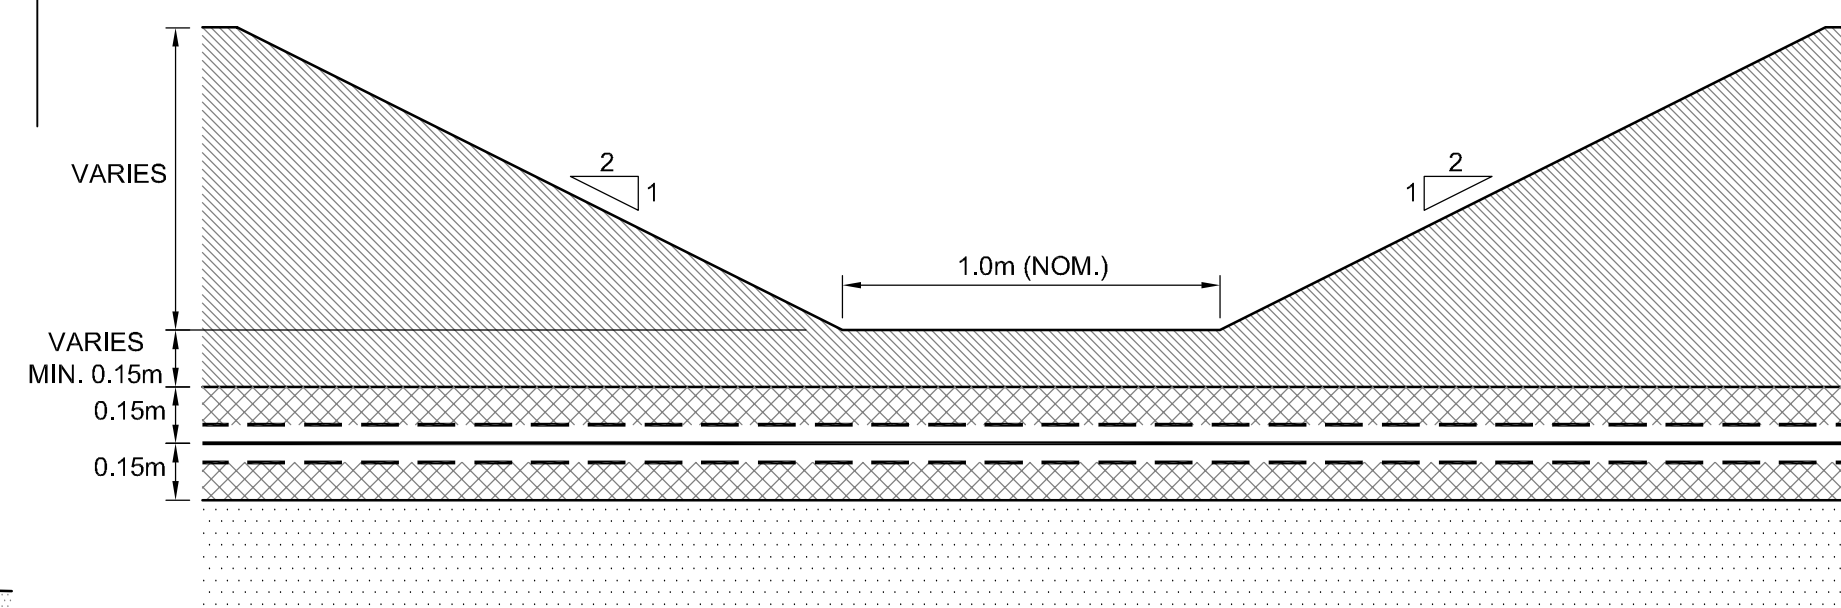

D

 

SEE DETAIL 1

NOTE
MIRROR IMAGE OF DETAIL 1

[illegible]

STAMP/SEAL

THIS DRAWING IS THE PROPERTY OF GOLDER ASSOCIATES LTD.
AND IS NOT TO BE LOANED OR REPRODUCED IN ANY WAY
WITHOUT THE PERMISSION OF GOLDER ASSOCIATES LTD.

APPROVED FOR CONSTRUCTION

CLIENT PROJECT MGR.	ENGINEERING MGR.	PROJECT MGR.
1	1	1
2	2	2
3	3	3
100	100	100

PROJECT NO.	ACTIVITY NO.	PACKAGE CODE
-------------	--------------	--------------

PROJECT PHASE	
---------------	--

	SCALE
--	-------

--	--

BY

--	--

DD

/ MM

M/YY

M/YY
RR C

R	C
PR	0



**Golder
Associates**

PROJECT No.

06-1413-009

DRAWING NO.

3000-C-207

FILE No.

061413009 SK-213

REV.

0