



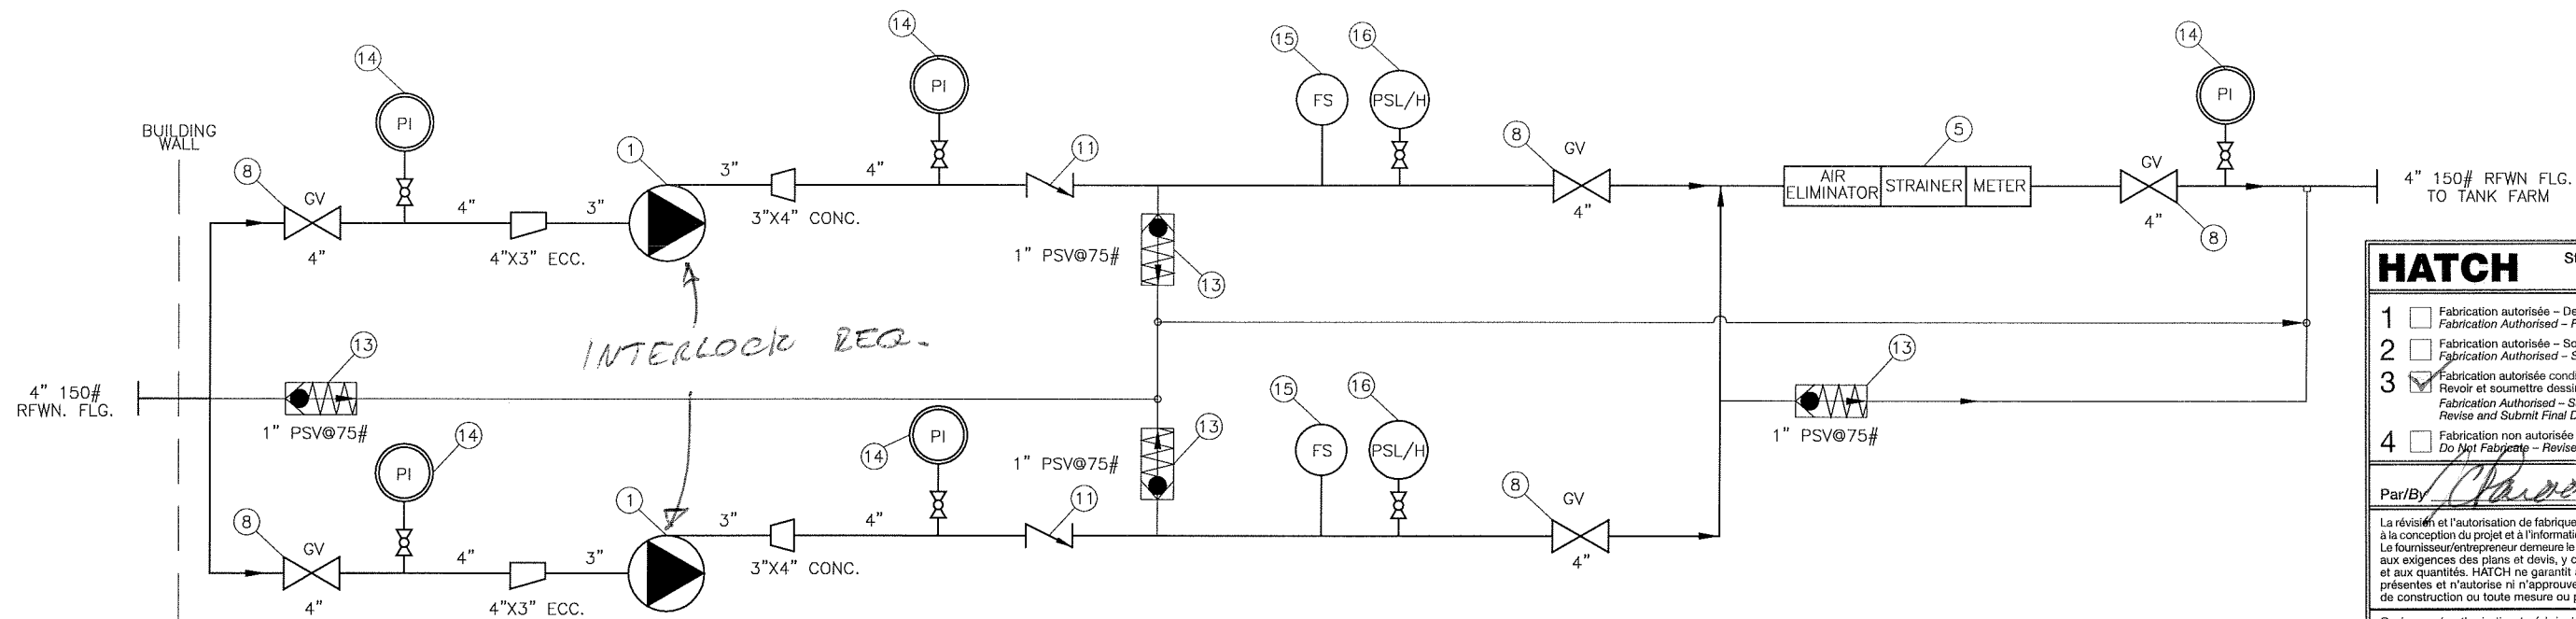


UNLOADING MODULE

HATCH		Statut Dessin / Manuel Fournisseur Vendor Drawing / Manual Status	
1	☐ Fabrication autorisée - Dessin et/ou manuel final reçu Fabrication Authorised - Final Drawing and/or Manual Received		
2	☐ Fabrication autorisée - Soumettre dessin et/ou manuel final Fabrication Authorised - Submit Final Drawing and/or Manual		
3	☒ Fabrication autorisée conditionnelle à l'ajout des changements indiqués; Revoir et soumettre dessin et/ou manuel final Fabrication Authorised - Subject to incorporation of indicated changes; Revise and Submit Final Drawing and/or Manual		
4	☐ Fabrication non autorisée - Revoir et resoumettre Do Not Fabricate - Revise and Resubmit		
Par/By: <i>Chamco</i>		Date: <i>21/01/05</i>	
La révision et l'autorisation de fabriquer portent seulement sur la conformité générale à la conception du projet et à l'information disponible dans les documents contractuels. Le fournisseur/entrepreneur demeure le seul responsable de la conformité du document aux exigences des plans et de devis, y compris mais sans s'y limiter, aux dimensions et aux quantités. HATCH ne garantit aucune des informations contenues dans les présentes et n'autorise ni n'approuve aucun procédé de fabrication ou technique de construction ou toute mesure ou procédure de sécurité.			
Review and authorization to fabricate are only for general conformance with the design concept of the Project as expressed in the Contract Documents. Sole responsibility for the accuracy and completeness of this document, including but not limited to dimensions and quantities, remains with the Vendor/Contractor. HATCH does not warrant the accuracy or completeness of any of the information contained herein, nor does HATCH authorize or approve any construction means, methods, techniques, sequences or any safety precautions or procedures.			
HATCH N°/No. 316996-DF-PM503-001		R:	
CLIENT N°/No.		R:	

INTERLOCK REQUIRED SO THAT BOTH SYSTEM CANNOT BE USED AT THE SAME TIME

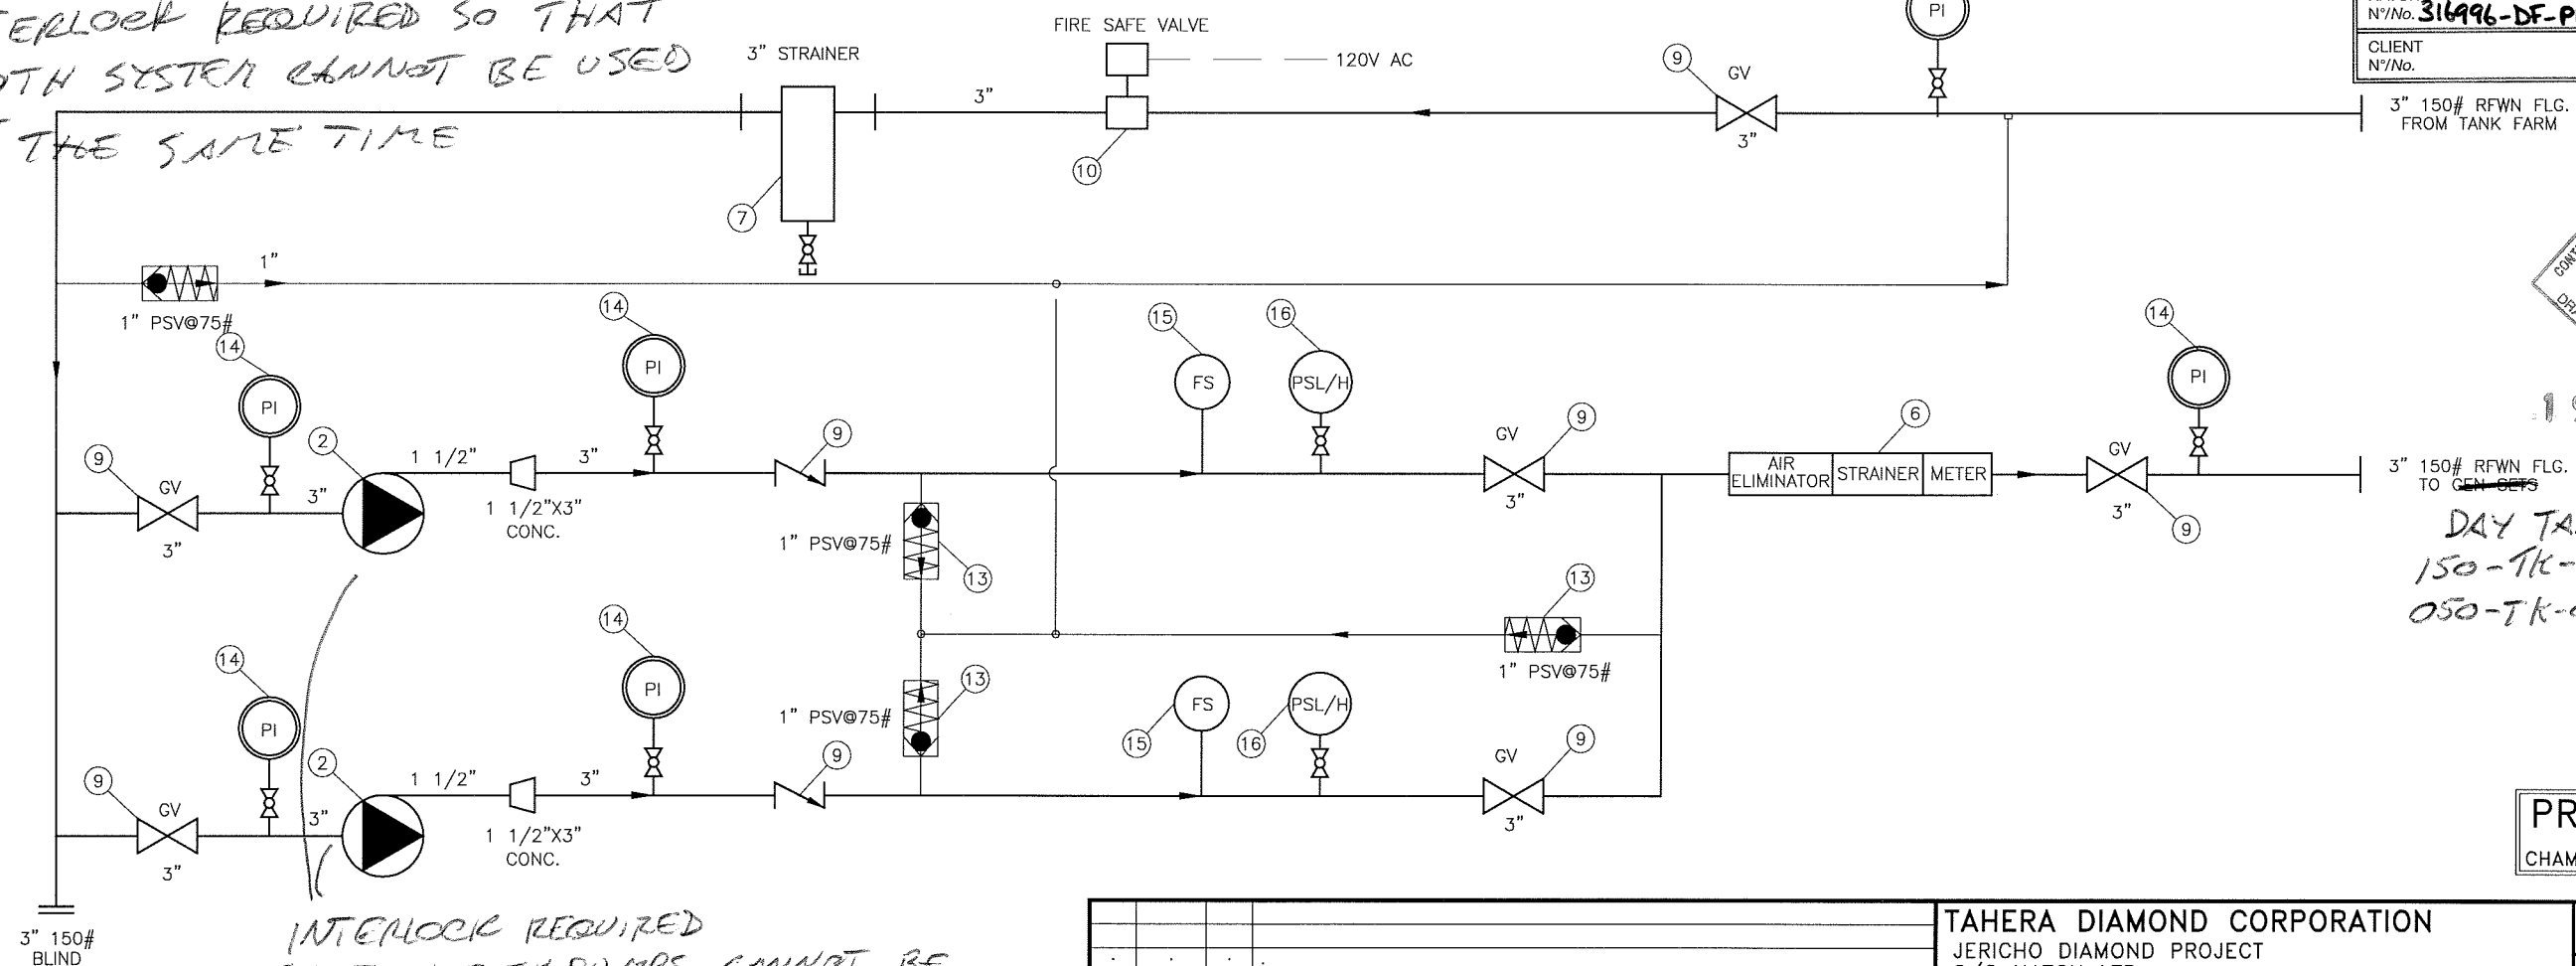

INTERLOCK REQUIRED SO THAT BOTH PUMPS CANNOT BE OPERATED AT THE SAME TIME
TRANSFER MODULE

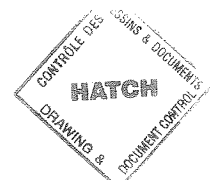

19 JAN 2005

DAY TANKS
150-TK-018 AND
050-TK-019

PRELIMINARY
FOR APPROVAL
CHAMCO INDUSTRIES LTD.

REV.	DATE	BY	DESCRIPTION

THIS PRINT IS THE PROPERTY OF CHAMCO INDUSTRIES LTD., IS CONFIDENTIAL, IS LENT ONLY FOR REFERENCE IN EQUIPMENT MAINTENANCE OR IN DEALING WITH CHAMCO INDUSTRIES LTD. AND IS NOT TO BE COPIED OR REPRODUCED WITHOUT OUR EXPRESS WRITTEN PERMISSION

CHAMCO
CHAMCO INDUSTRIES LTD.
VANCOUVER - CALGARY - EDMONTON - PRINCE GEORGE

TAHERA DIAMOND CORPORATION JERICHO DIAMOND PROJECT C/O HATCH LTD P.O. No. 316996-PM503		DESIGNED BY D.J.C.
Tag No. 150 DM-001 UNLOADING / TRANSFER FUEL MODULE		DRAWN BY B.L.
PROCESS FLOW DIAGRAM		CHECKED BY
DATE DEC. 13, 2004	SCALE N.T.S.	JOB No. 1010069ABS
DWG No. CUP1010074-02	REV. 0	