


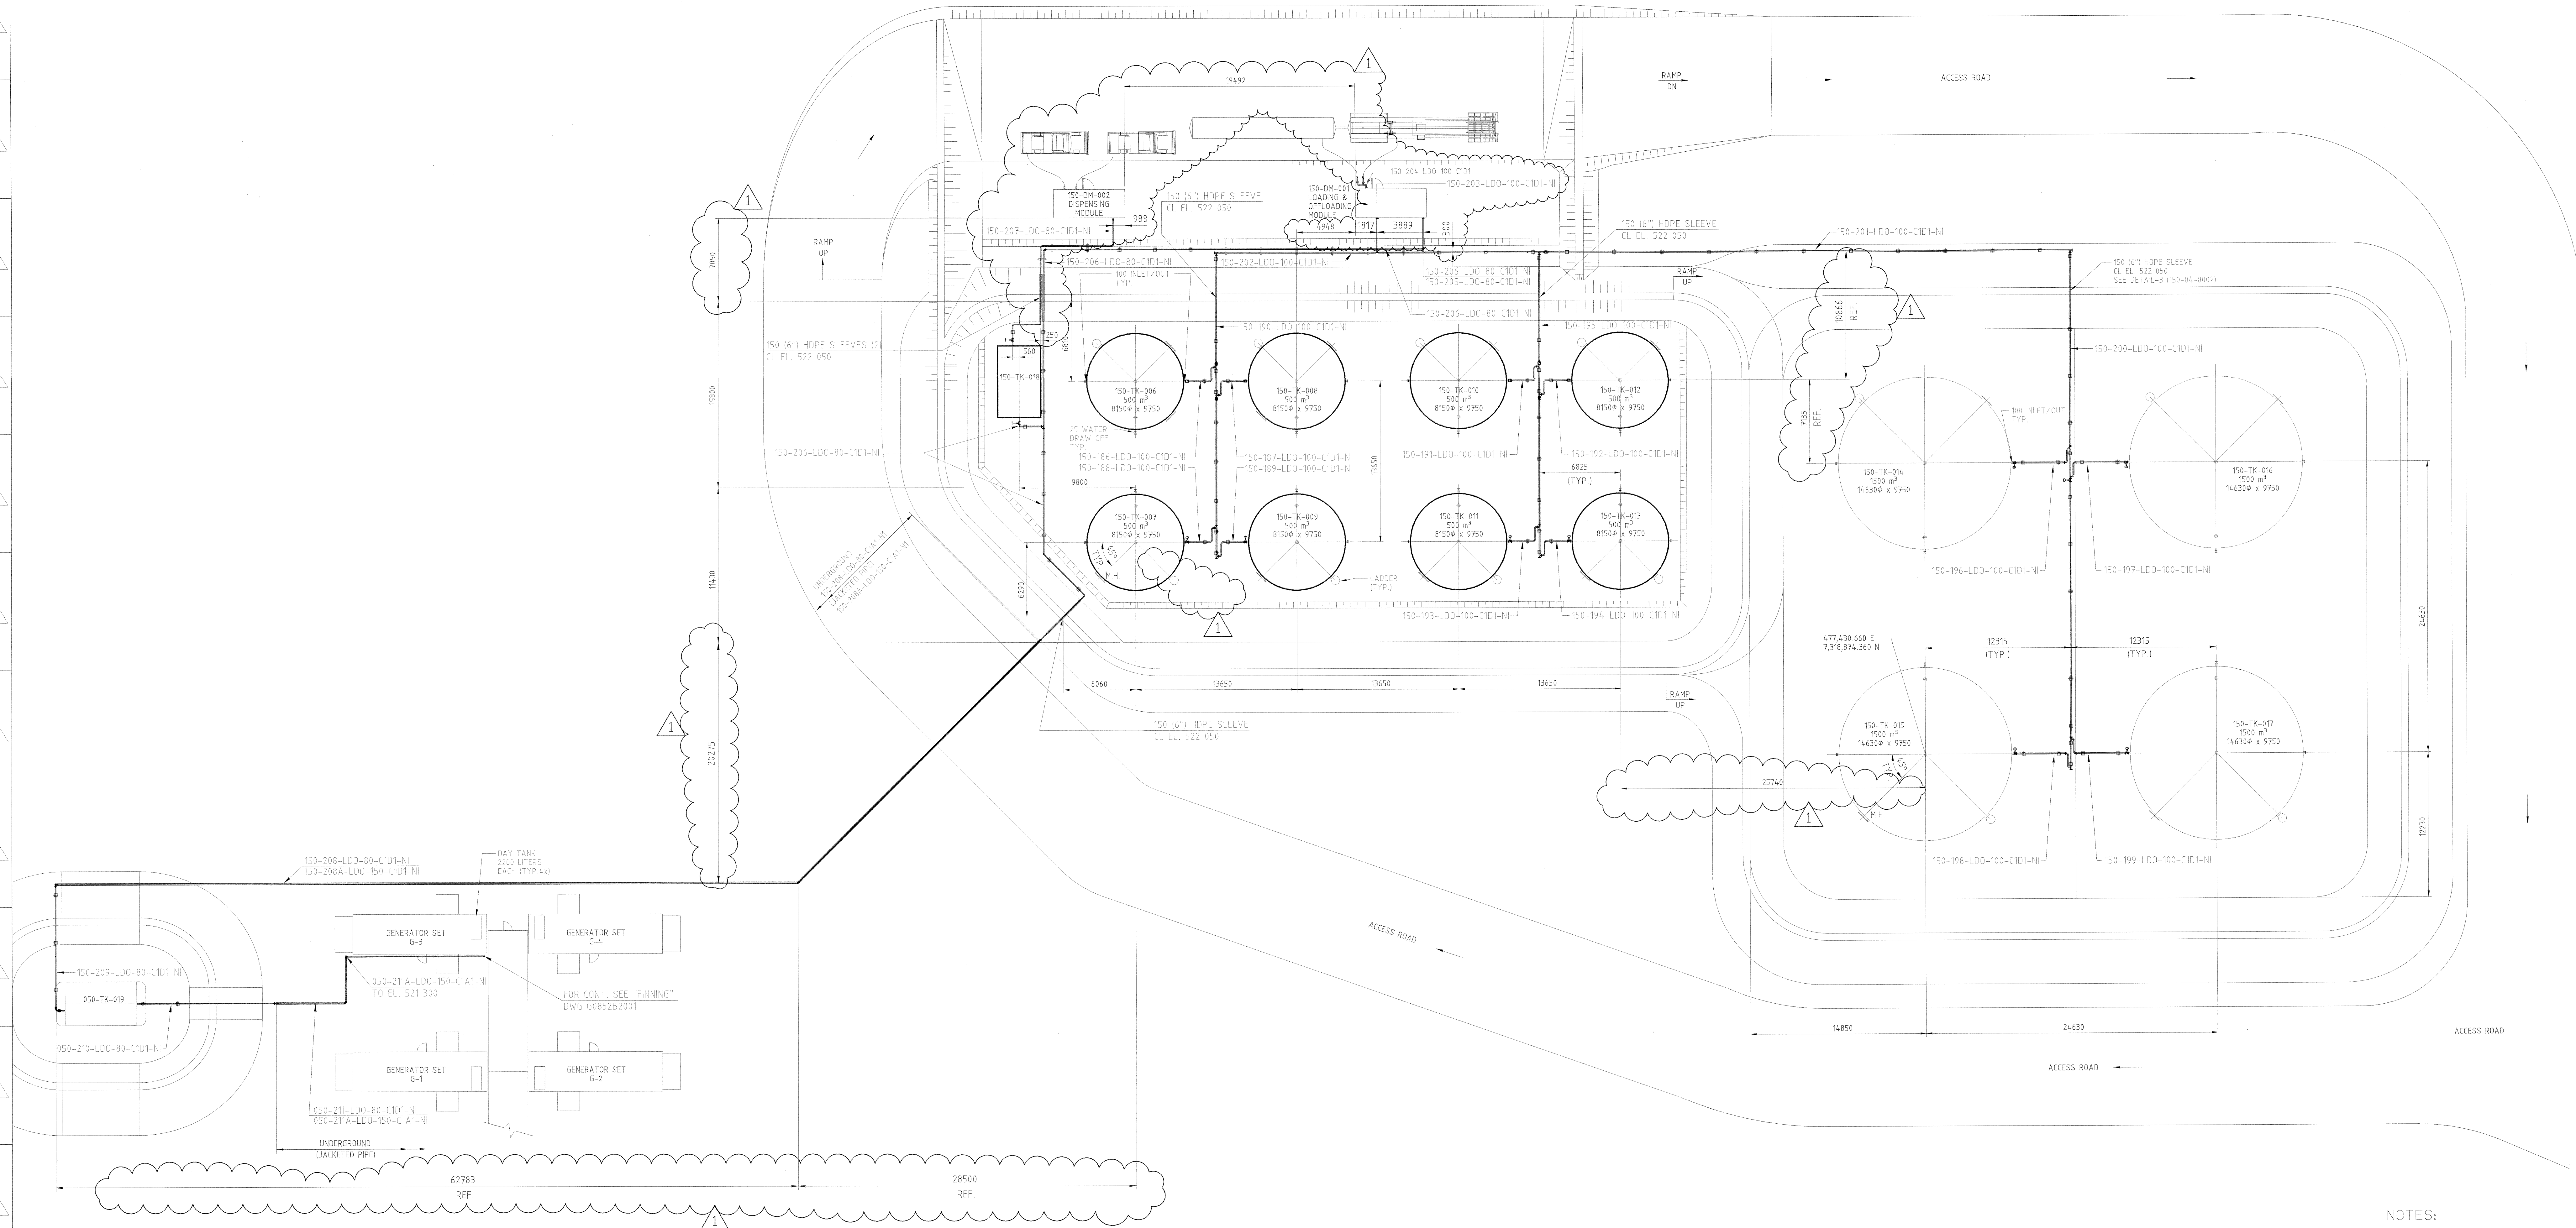


NOTES:

1. TANK SPACING IN ACCORDANCE WITH NFPA 30 AND THE NATIONAL FIRE CODE
2. READ THIS DRAWING WITH PIPING ISOMETRICS.

LEGEND

 SINGLE PIPE SUPPORT
 DOUBLE PIPE SUPPORT

PERMIT TO PRACTICE
HATCH LTD.
Signature K. Korman
Date February 1, 2005
PERMIT NUMBER: P 512
The Association of Professional Engineers,
Geologists and Geophysicists of the NWT / NU

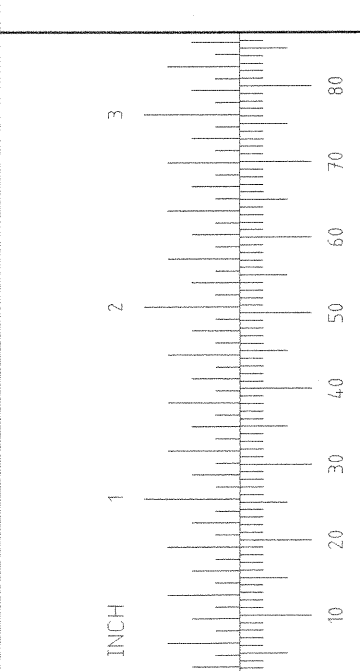[illegible]

PERMIT TO PRACTICE
HATCH LTD.
ORIGINAL SIGNED BY
BERNARD BRUMAN
01/19/05
PERMIT NUMBER: P512
The Association of Professional Engineers,
Geologists and Geophysicists of the NWT/NUN.

[illegible]

NWT/NU
ORIGINAL
SIGNED BY
J.-C. PARADIS
P. Eng.
L1541
01/19/05

[illegible]

HATCH	
DESIGNED BY K. LEMCELLI	DRAWN BY B. KRICKOVIC
DATE:12.10.04	DATE:16.10.04
CHECKED BY H. RUPNIK	DISCIPLINE ENG. J.-C. PARADISI
DATE:01.19.05	DATE:01.19.05
PROJ. DES. COORD. J.-C. PARADISI	PROJECT ENG. M. CAMPANELLI
DATE:01.19.05	DATE:01.19.05
PROJECT MGR.	

TAHERA DIAMOND CORPORATION				
PROJECT TITLE				
JERICHO DIAMOND PROJECT				
DIESEL FUEL FARM				
PIPING LAYOUT				
PLAN				
H/A PROJECT NO.		316996		
SCALE	1:200	DWG. NO.	150-04-0001	SHEET NO.
				REV. 