

SHEET NO.
1000-60-051

ON DWD

1

2

3

100

1

2

3

100

1

2

3

100

1

2

3

100

1

2

3

100

1

2

3

95

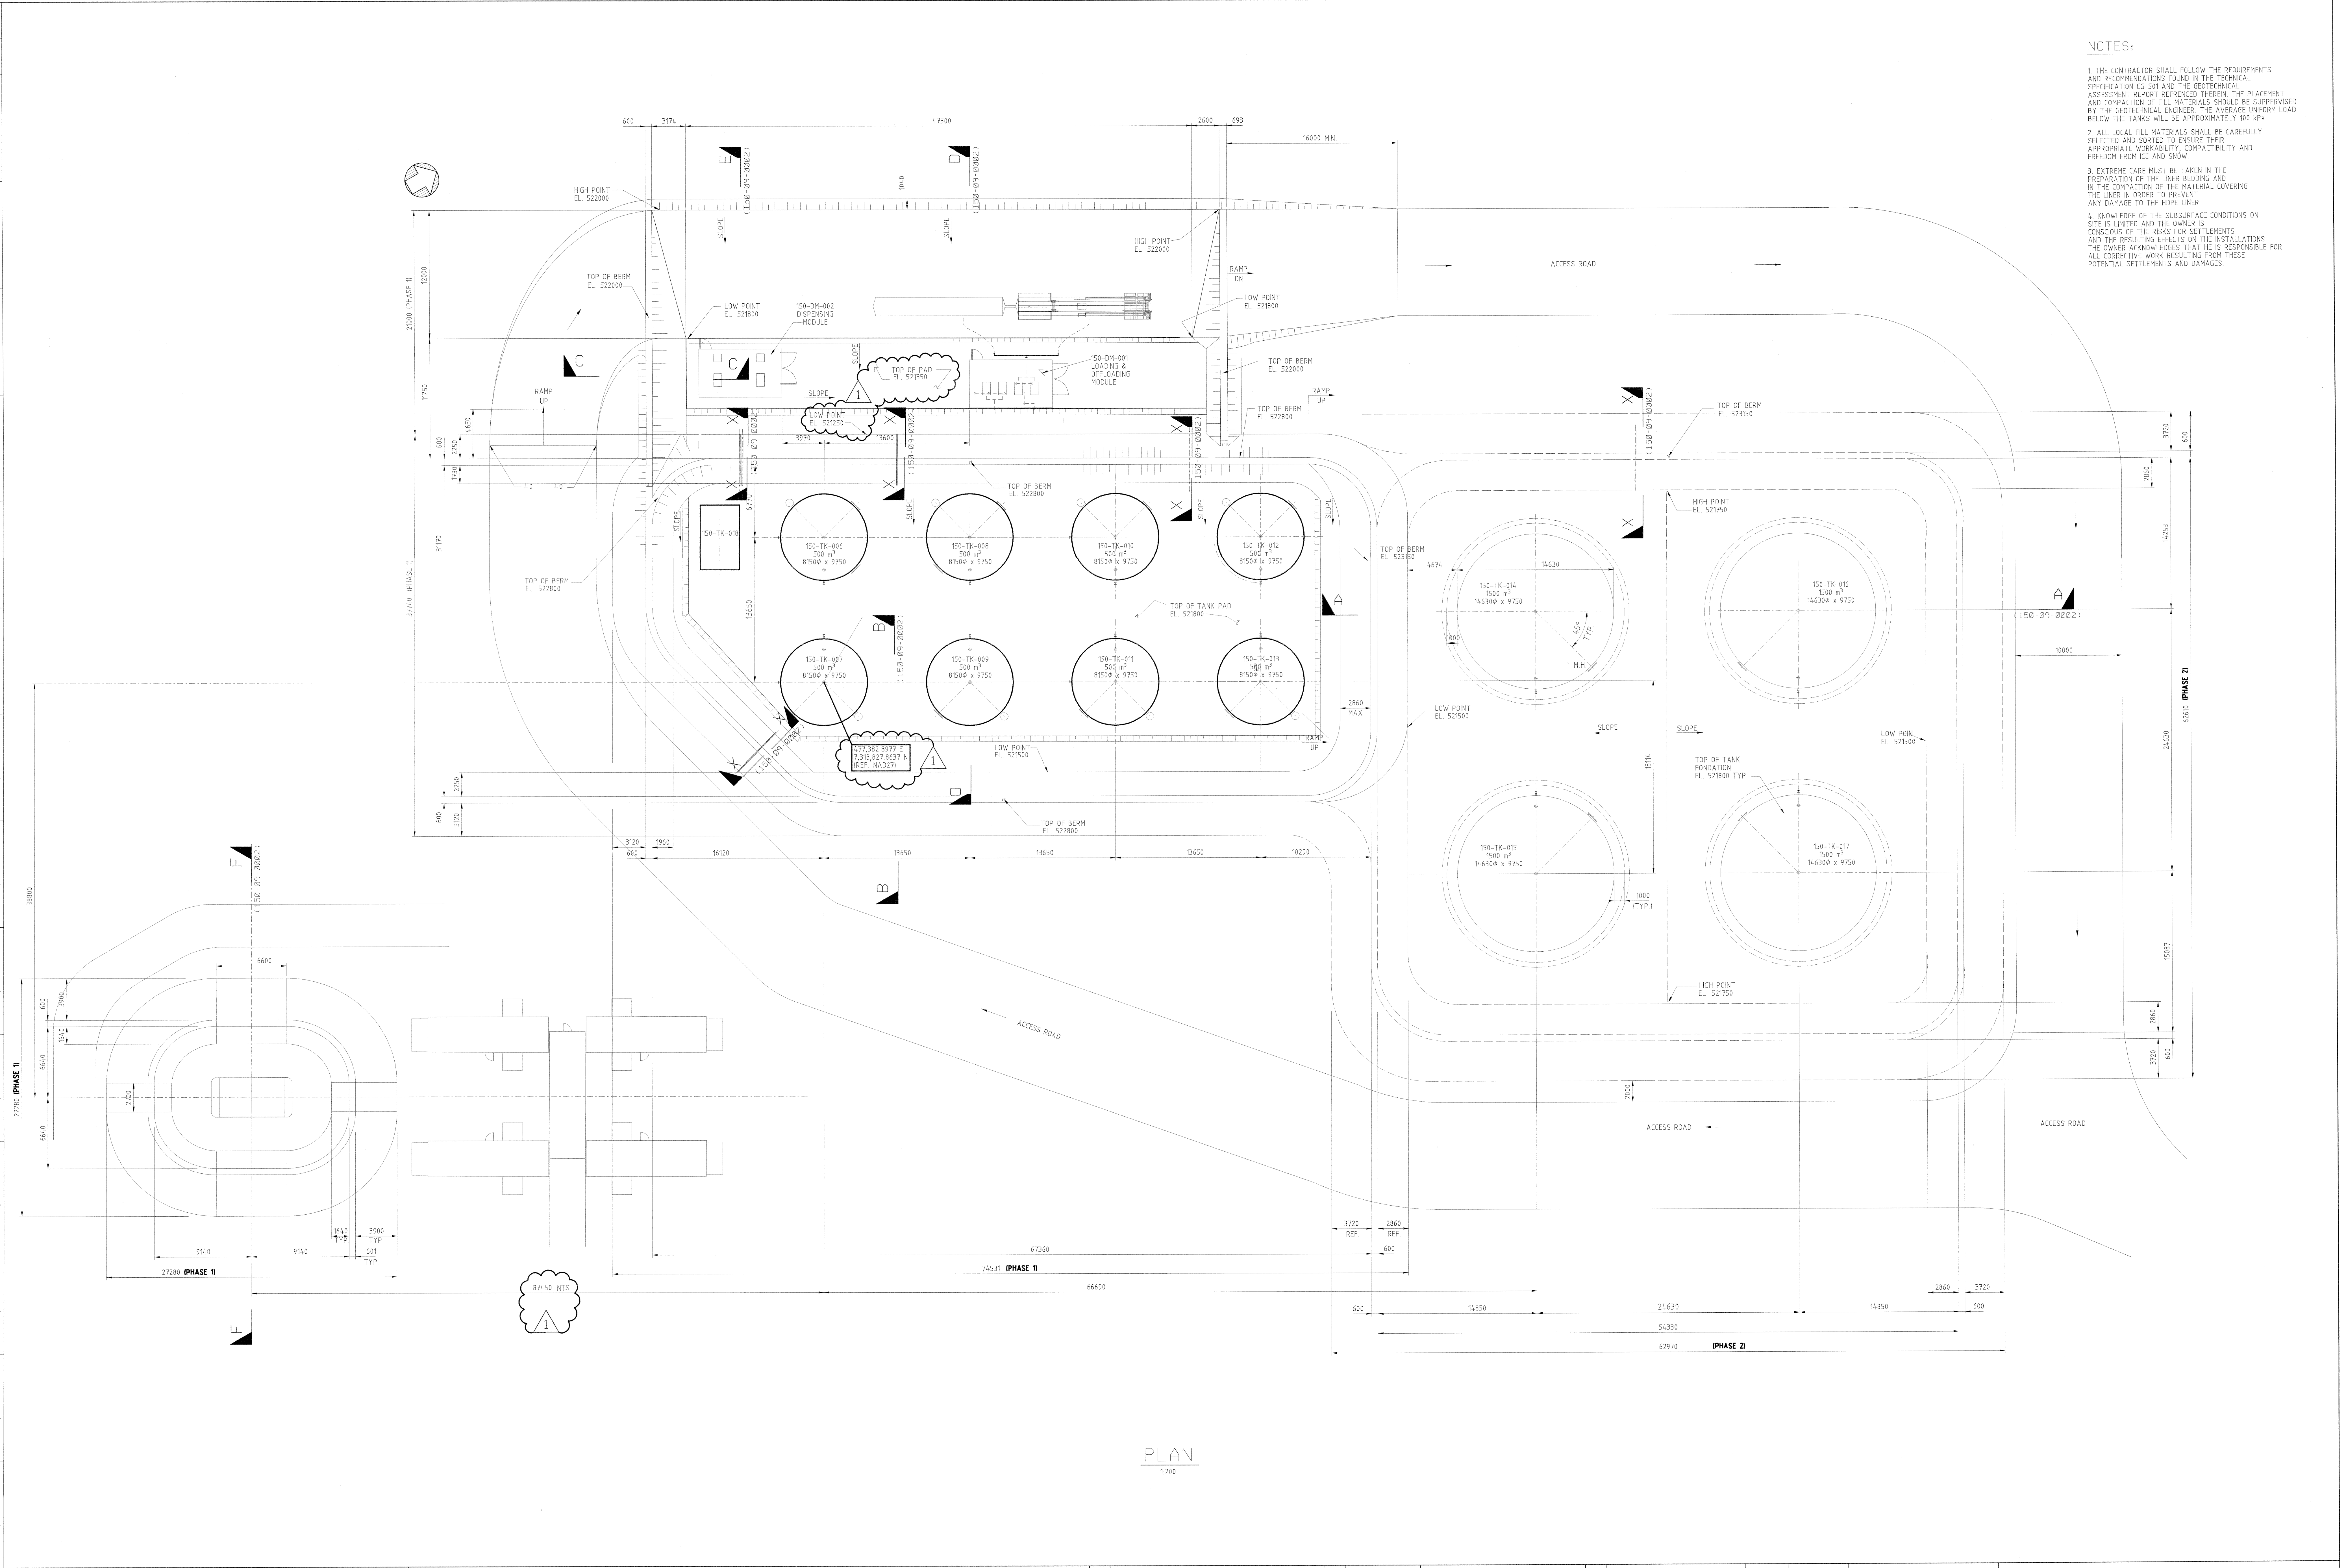
96

97

98

99

100



- NOTES:
1. THE CONTRACTOR SHALL FOLLOW THE REQUIREMENTS AND RECOMMENDATIONS FOUND IN THE TECHNICAL ASSESSMENT REPORT REFERENCED THEREIN. THE PLACEMENT AND COMPACTION OF FILL MATERIALS SHOULD BE SUPERVISED BY THE GEOTECHNICAL ENGINEER. THE AVERAGE UNIFORM LOAD BELOW THE TANKS WILL BE APPROXIMATELY 100 KPA.
 2. ALL LOCAL FILL MATERIALS SHALL BE CAREFULLY SELECTED AND SORTED TO ENSURE THEIR APPROPRIATE WORKABILITY, COMPACTABILITY AND FREEDOM FROM ICE AND SNOW.
 3. EXTREME CARE MUST BE TAKEN IN THE PREPARATION OF THE LINER BEDDING AND IN THE COMPACTION OF THE MATERIAL COVERING THE LINER IN ORDER TO PREVENT ANY DAMAGE TO THE HOPE LINER.
 4. KNOWLEDGE OF THE SUBSURFACE CONDITIONS ON SITE IS LIMITED AND THE OWNER IS CONSCIOUS OF THE RISKS FOR SETTLEMENTS AND THE RESULTING EFFECTS ON THE INSTALLATIONS. THE OWNER ACKNOWLEDGES THAT HE IS RESPONSIBLE FOR ALL CORRECTIVE WORK RESULTING FROM THESE POTENTIAL SETTLEMENTS AND DAMAGES.

PLAN
1:200

150-04-0001 DIESEL FUEL FARM - PIPING LAYOUT

1

PERMIT TO PRACTICE
HATCH LTD.
Signature: *Raymond Smith*
Date: 2 Feb 2005
PERMIT NUMBER: P512
The Association of Professional Engineers
(Geotechnical and Geophysicists of the UK) (UK)

STAMP

NWT/NU
ORIGINAL
SIGNED BY
H. KHALILI
P. Eng.
L1545
08/12/04

NO.	DIMENSIONS	REVISIONS	DATE
1	DIMENSIONS REVISED		08/12/04

REV.	ISSUE FOR	AUTH BY	DATE
1	FOR CONSTRUCTION C0501		
2	FOR CONSTRUCTION C0501		
3	FOR CONSTRUCTION C0501		
100	FOR CONSTRUCTION C0501		

HATCH

DESIGNED BY
R. HILDEBRAND
DATE: 08/12/04
CHECKED BY
R. HILDEBRAND
DATE:
PROJECT ENG.
H. KHALILI
DATE:
PROJECT MGR.
D. LAM
DATE:

DRAWN BY
M. H. / L. L.
DATE: 08/12/04
DISCIPLINE ENG.
H. KHALILI
DATE:
PROJECT ENG.
J.C. PARADIS
DATE:

TAHERA DIAMOND CORPORATION

PROJECT TITLE
JERICHO DIAMOND PROJECT

DIESEL FUEL FARM
CONTAINMENT BASSIN
LAYOUT

NO PROJECT NO.
316996

SCALE
AS NOTED

DWG NO.
150-09-0001

SHEET NO.
1

REV.

02/01/2005 03:38:18 PM P:\Users\A3325555\DWG\150-09-0001.dgn LPE2165