


Appendix B

As built drawing

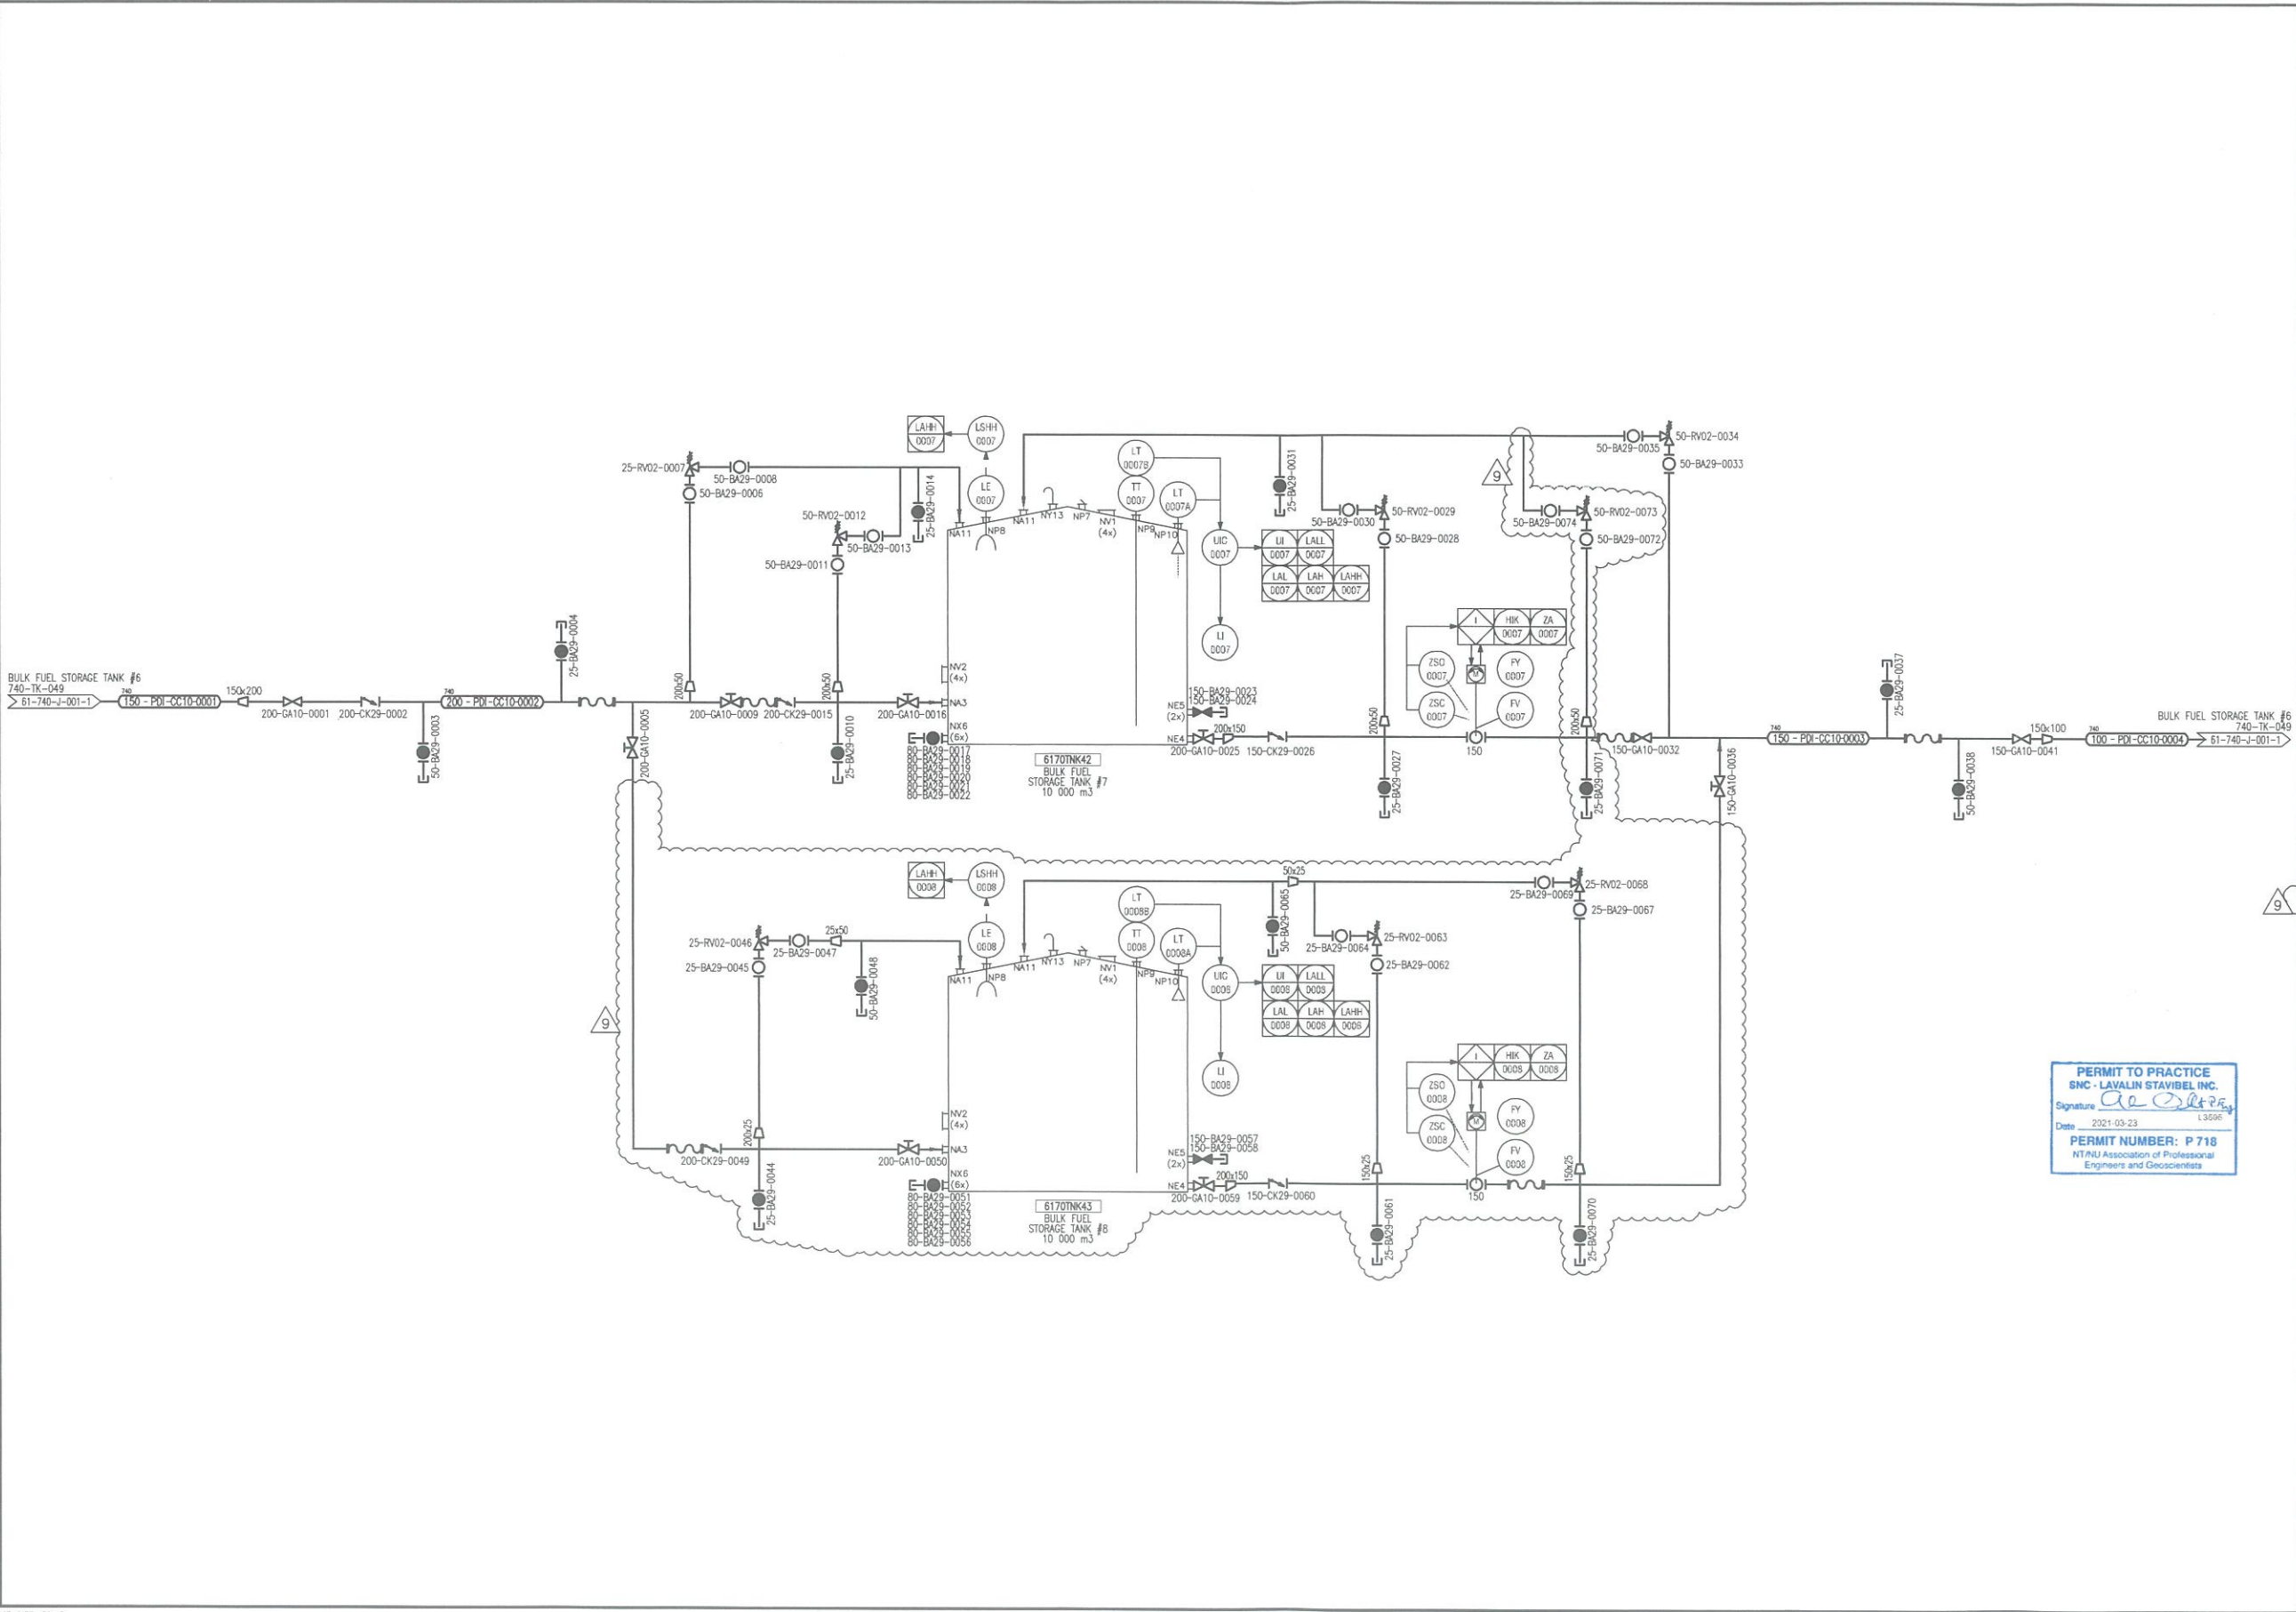

PLAN CLE
KEY PLAN

NOTES GÉNÉRALES / GENERAL NOTES

**POUR CONSTRUCTION
FOR CONSTRUCTION**
DATE : 2021-03-23

SNC-LAVALIN
SNC-Lavalin Stabilité Inc.
532, rue Dufferin, Bureau 107
Auroux (Québec) J8T 2W7
Tél : 819 732-0255 Téléc : 819 732-0259
www.snc-lavalin.com

Projet No. : 617087-0000 REV.: 9

CONTRÔLEUR DE QUALITÉ / QUALITY CONTROL: Ce document est la propriété de SNC-Lavalin. Toute réimpression ou utilisation non autorisée sans la permission écrite de la SNC-Lavalin est formellement interdite. Toute violation de cette interdiction sera poursuivie. Toute reproduction ou utilisation non autorisée sans la permission écrite de la SNC-Lavalin est formellement interdite. Toute violation de cette interdiction sera poursuivie.

DESSINS EN RÉFÉRENCE / REFERENCE DRAWINGS

NO.	TITRE / TITLE	REV.
6	TANK #6 AND #7 - FUEL DIST. PIPING	61-740-M-0100
7	10M LITERS DIESEL TANK #8 (61707NK43)	61-740-270-001
8	10M L. DIESEL TANK #7 & TANK #8 PIPING	61-740-270-200



REV.	DATE	DESCRIPTION	PAR/APP.	LG/MDT
6	2018-12-18	AS BUILT	S.P.	B.J.L.
7	2019-08-03	ISSUED FOR CONSTRUCTION	B.L.	A.O. B.J.R.O.Y.
8	2019-08-03	ADDITIONAL AIR / DRAIN VALVE P.D.C.	A.O.	N.M.N.D.
9	2019-04-25	ISSUED FOR TENDER	B.L.	A.O. N.M.N.D.
4	2018-12-12	FOR COMMENTS	B.L.	M.H. N.M.N.D.
9	2021-03-23	ISSUED FOR CONSTRUCTION	B.L.L.	A.O.U.E. N.M.N.D.

REVISIONS



TITRE / TITLE
AGNICO-EAGLE - MEADOWBANK DIVISION
BAKER LAKE AREA 740
PROCESS AND INSTRUMENTATION DIAGRAM

DESIGNÉ PAR DRAWN BY	FRANCIS ROSE, TECH	DATE 2009/03/27
VÉRIFIÉ PAR CHECKED BY	PATRICK GIARD, P.ENG	-
APPROUVÉ PAR APPROVED BY	PATRICK GIARD, P.ENG	-

ÉCHELLE
SCALE
N.T.S.
DATE
2009-03-27

NO. DESIGN DRAWING NO.	61-740-J-0100
NO. PROJECT PROJECT NO.	6120
REVISION	FEUILLE / SHEET 9 / 2

Panel Ident.: 6174-DP-06

Power source:	120 208 Volts
Feeder :	6174-TX-04
Mount:	Surface
Localisation:	BAKER LAKE SEA CAN
Type:	Schneider QO Series

Encl. Type :	NEMA 1
Main breaker:	N/A
Nb. of circuit:	42
Bars (Amps):	225A
Cap. rupt. (kA):	10


Local and description		TYPE		DISJ.	C	T	CT	DISJ.	WATTS	TYPE		Local and description
		REF	Qty							REF	Qty	
6174-PLC-02 Power		D		15	1	A	2	15		E		Sea Can Lighting
6174-XV-01 - Elect. Actuator valve		M		15	3	B	4	15		P		Sea Can Receptacle
6174-XV-02 - Elect. actuator valve		M		15	5	C	6	15				Spare breaker
6174-XV-03 - Elect. actuator valve		M		15	7	A	8	15				Spare breaker
6174-XV-04 - Elect. actuator valve		M		15	9	B	10	15				Spare breaker
6174-XV-05 - Elect. actuator valve		M		15	11	C	12	15				Spare breaker
6174-XV-06 - Elect. actuator valve		M		15	13	A	14	15				Spare breaker
6174-IOP-003 power		D		15	15	B	16	15				Spare breaker
Spare breaker				15	17	C	18	30				Spare breaker
Spare breaker				15	19	A	20					Spare breaker
6174-XV-07 Res. #7 Valve Actuator		M		15	21	B	22	15	GFI	C		6174-HEA-07 Res. #7 Valve Heating
6174-XV-08 Res. #8 Valve Actuator		M		15	23	C	24	15	GFI	C		6174-HEA-08 Res. #8 Valve Heating
Space					25	A	26					Space
Space					27	B	28					Space
Space					29	C	30					Space
Space					31	A	32					Space
Space					33	B	34					Space
Space					35	C	36					Space
Space					37	A	38					Space
Space					39	B	40					Space
Space					41	C	42					Space

TYPE (REF)	(W) total	Qty
(E) Lighting	0	0
(P) Parking plug	0	0
(C) Heating	0	0
(M) Motor	0	0
(W) Water heater	0	0
(D) Other	0	0
	0	0

TYPE (REF)	Qty (ref)
(L) Spare	0
(S) Space	0

	Watts	Amp
Phase A	0	0,00
Phase B	0	0,00
Phase C	0	0,00
Total R	0	0,00

POUR CONSTRUCTION
FOR CONSTRUCTION
AGNICO EAGLE
DATE : 2021-03-10

PERMIT TO PRACTICE
SNC - LAVALIN STAVIBEL INC.
Signature 
Date 2021-03-17
PERMIT NUMBER: P 718
NT/NU Association of Professional
Engineers and Geoscientists


2021-03-17

—	—	4	ISSUED FOR CONSTRUCTION	2021-03-10	J.BOU
—	—	3	AS BUILT	2020-01-24	S.MAR
—	—	2	ISSUED FOR CONSTRUCTION	2019-06-03	P.LEM.
—	—	1	ISSUED FOR TENDER	2019-05-03	P.LEM.
—	—	0	ORIGINAL DRAWING WAS 6174-E-002	JUNE/16	M.B.
TITRE / TITLE	# DWG	REV	DESCRIPTION	DATE	PAR BY

DESSINS EN RÉFÉRENCE / REFERENCE DRAWINGS

REVISIONS




Project # :
660534-0000
REV:1
SNC • LAVALIN
150, rue Gamble Ouest
Rouyn-Noranda (Québec) J9X 2R7
Tel. : 819 764-5181 Fax : 819 797-0158
www.sncvalin.com

DESSINÉ PAR DRAWN BY	MV	DATE	MAY/16
VÉRIFIÉ PAR CHECKED BY	ST		JUNE/16
APPROUVÉ PAR APPROVED BY	ST		JUNE/16
No. PROJET PROJECT NO.	6120		
DATE	JUNE/16		
L'INFORMATION CI-CONTRE EST LA PROPRIÉTÉ DE AGNICO EAGLE LTD ET DOIT ÊTRE RETENUE PAR AGNICO EAGLE LTD. SANS APPROUVATION ÉCRITE PRÉALABLE, TOUTE REPRODUCTION DE COPIES À TITRE DE REPRODUCTION AVANT QUE CELLE POUR LAQUELLE L'INFORMATION EST PRÉVUE, SOIT INTERDITE. THE INFORMATION HERE ON IS THE PROPERTY OF AGNICO EAGLE LTD. AND MUST BE RETURNED TO AGNICO EAGLE LTD. WITHOUT WRITTEN PERMISSION, ANY COPIES THEREOF, IN WHOLE OR IN PART, FOR WHICH IT IS ISSUED ARE PROHIBITED. © AGNICO EAGLE LTD.			


TITRE / TITLE	AGNICO EAGLE — MEADOWBANK DIVISION BAKER LAKE AREA 740 285 — SERVICE ELECTRICAL — LIGHT AND DISTRIBUTION 6174-DP-06 PANEL SCHEDULE BAKER LAKE SEA CAN — DISTRIBUTION PANEL 120/208VAC		
ECHELLE/ SCALE	N/A	PROJET FILE	61-740-285-200_R4.dwg
No. DESSIN/ DRAWING NO.	61-740-285-200	REVISION	4
		FEUILLE/SHT	1 / 1

POUR CONSTRUCTION
FOR CONSTRUCTION


DATE : 2021-03-10

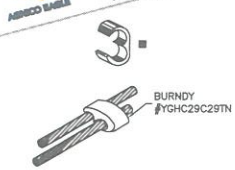

C-TAPS
SCL: NTS
CONDUCTOR TO CONDUCTOR
CONNECTOR

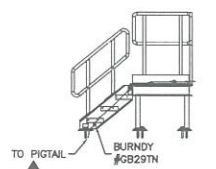

STAIRS
SCL: NTS

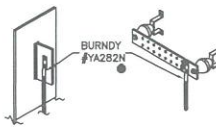


LUG YA-28
SCL: NTS
EQUIPMENT,
CONTAINER, GROUND BAR


COPPER SCREW
CONNECTOR: GB29
SEE NOTE 2



CABLE TRAY
SCL: NTS

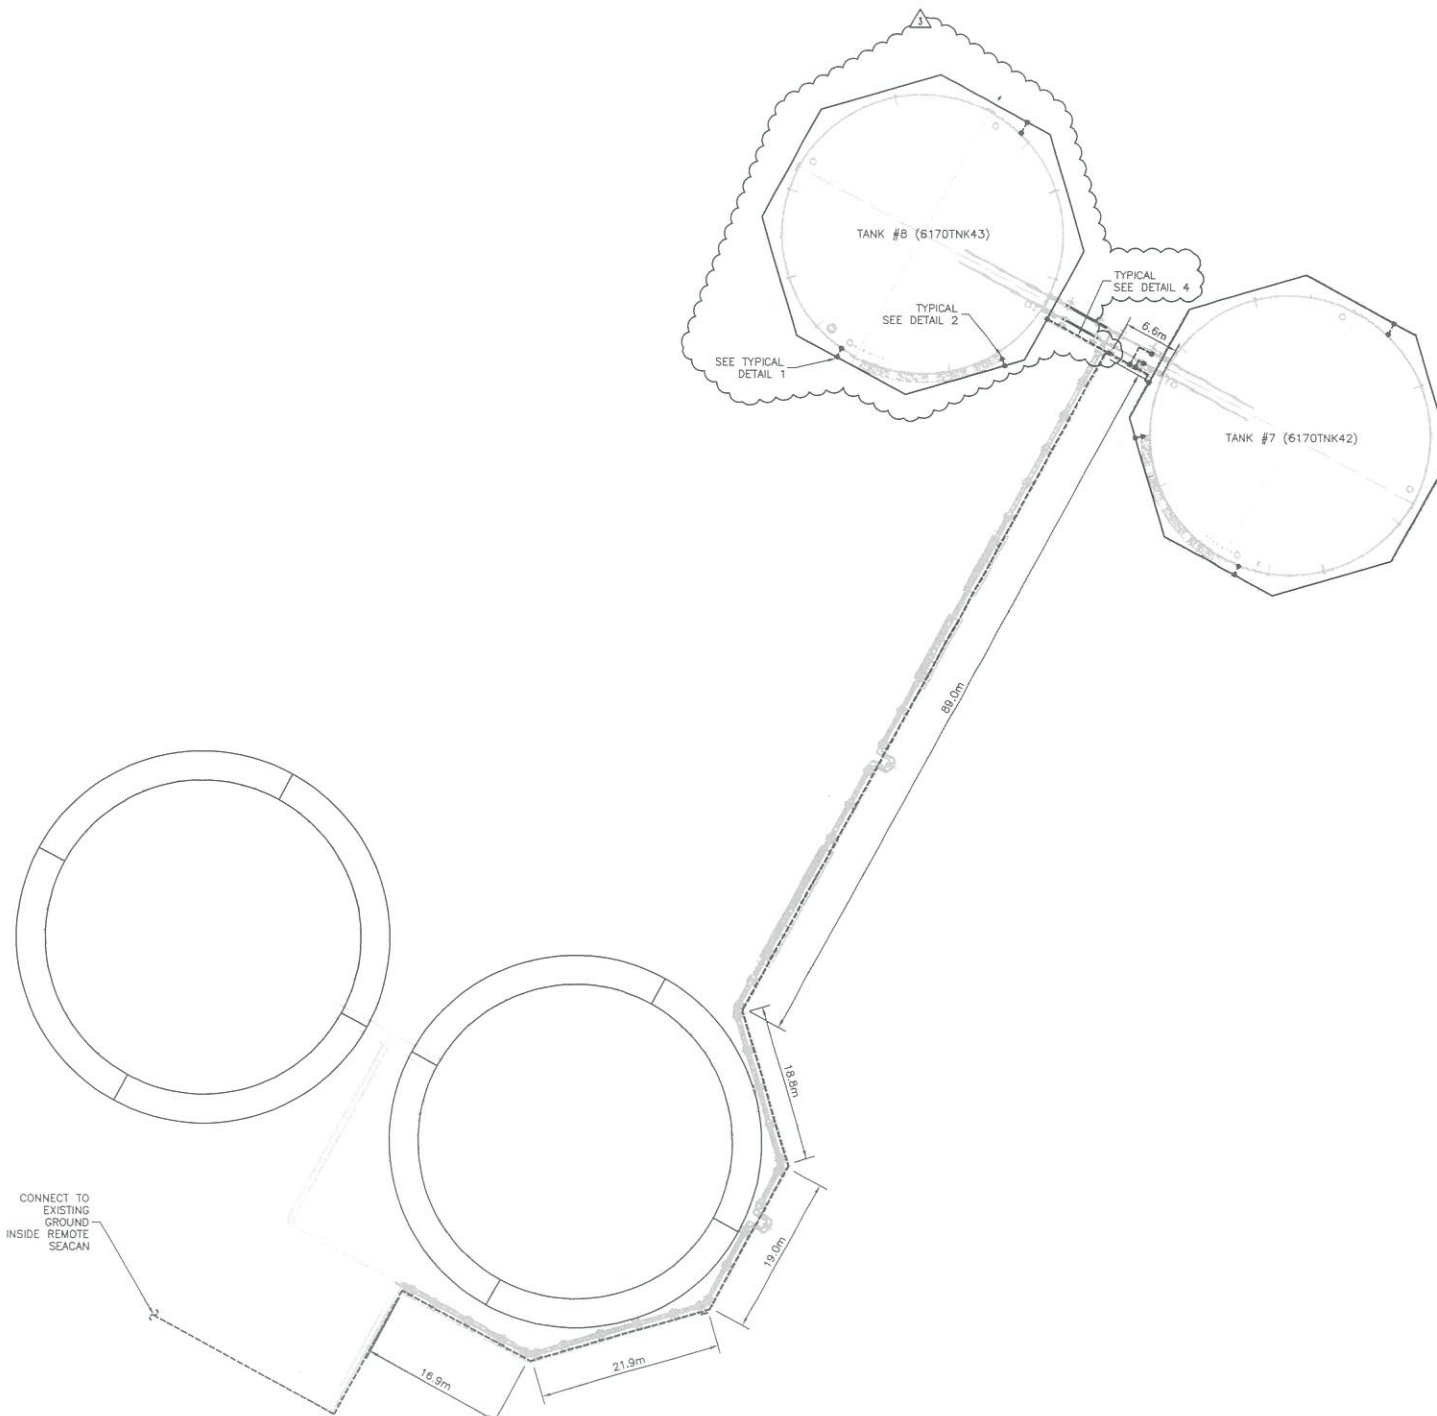

PLAN VIEW
SCALE: 1:400

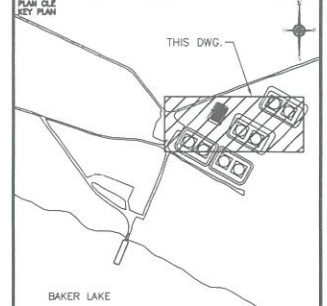

NOTES GÉNÉRALES / GENERAL NOTES

- LEGEND
- BURIED STRANDED TINNED BARE COPPER CONDUCTOR #4/0 AWG
 - SURFACE STRANDED TINNED BARE COPPER CONDUCTOR #4/0 AWG IN CABLE TRAY
- NOTES
- THE PERIMETER GROUND CONDUCTOR OF THE TANK MUST BE ABOVE THE GEOMEMBRANE
 - THE GROUND CONDUCTOR MUST BE FIXED TO THE CABLE TRAY TO ALL 15 METER MINIMUM WITH MECHANICAL CONNECTOR BURNDY MODEL GB29

SNC-Lavalin Stavisbel Inc.
150, rue Samble-Ouellet
Rouville-Nordville (Québec) J8X 2B7
Tél. 819 765-0181 Fax 819 765-0158
www.snc-lavalin.com

Project #: 660534-0000

DESSINS EN RÉFÉRENCE / REFERENCE DRAWINGS

TITRE / TITLE	# DES



REV.	DATE	DESCRIPTION	PAR/REV APP. / SIGNATURE
3	2021-03-10	ISSUED FOR CONSTRUCTION	D.PEL. / J.BOU.
2	2020-01-24	AS BUILT	S.MAR. / E.LAV.
1	2019-05-03	ISSUED FOR CONSTRUCTION	S.MAR. / P.LEM.
0	2019-05-03	ISSUED FOR TENDER	D.PEL. / P.LEM.

REVISIONS




TITRE / TITLE
AGNICO EAGLE - MEADOWBANK DIVISION
740 - BAKER LAKE AREA
275 - POWER ELECTRICAL
ARRANGEMENT
10M LITERS DIESEL TANK #7 (6170TNK42)
& TANK #8 (6170TNK43) GROUNDING

DESIGNED PAR	DATE
DRIVEN BY	2019-04-24
VERIFIED PAR	DATE
CHECKED BY	2019-04-25
APPROVED PAR	DATE
APPROVED BY	2019-05-03
ÉCHELLE	DATE
INDICATED	2019-04-24

NO. DESIGN
DRAWING NO. 61-740-275-201

NO. PROJECT	REVISION	FEUILLE / SHEET
6120	3	1 / 1

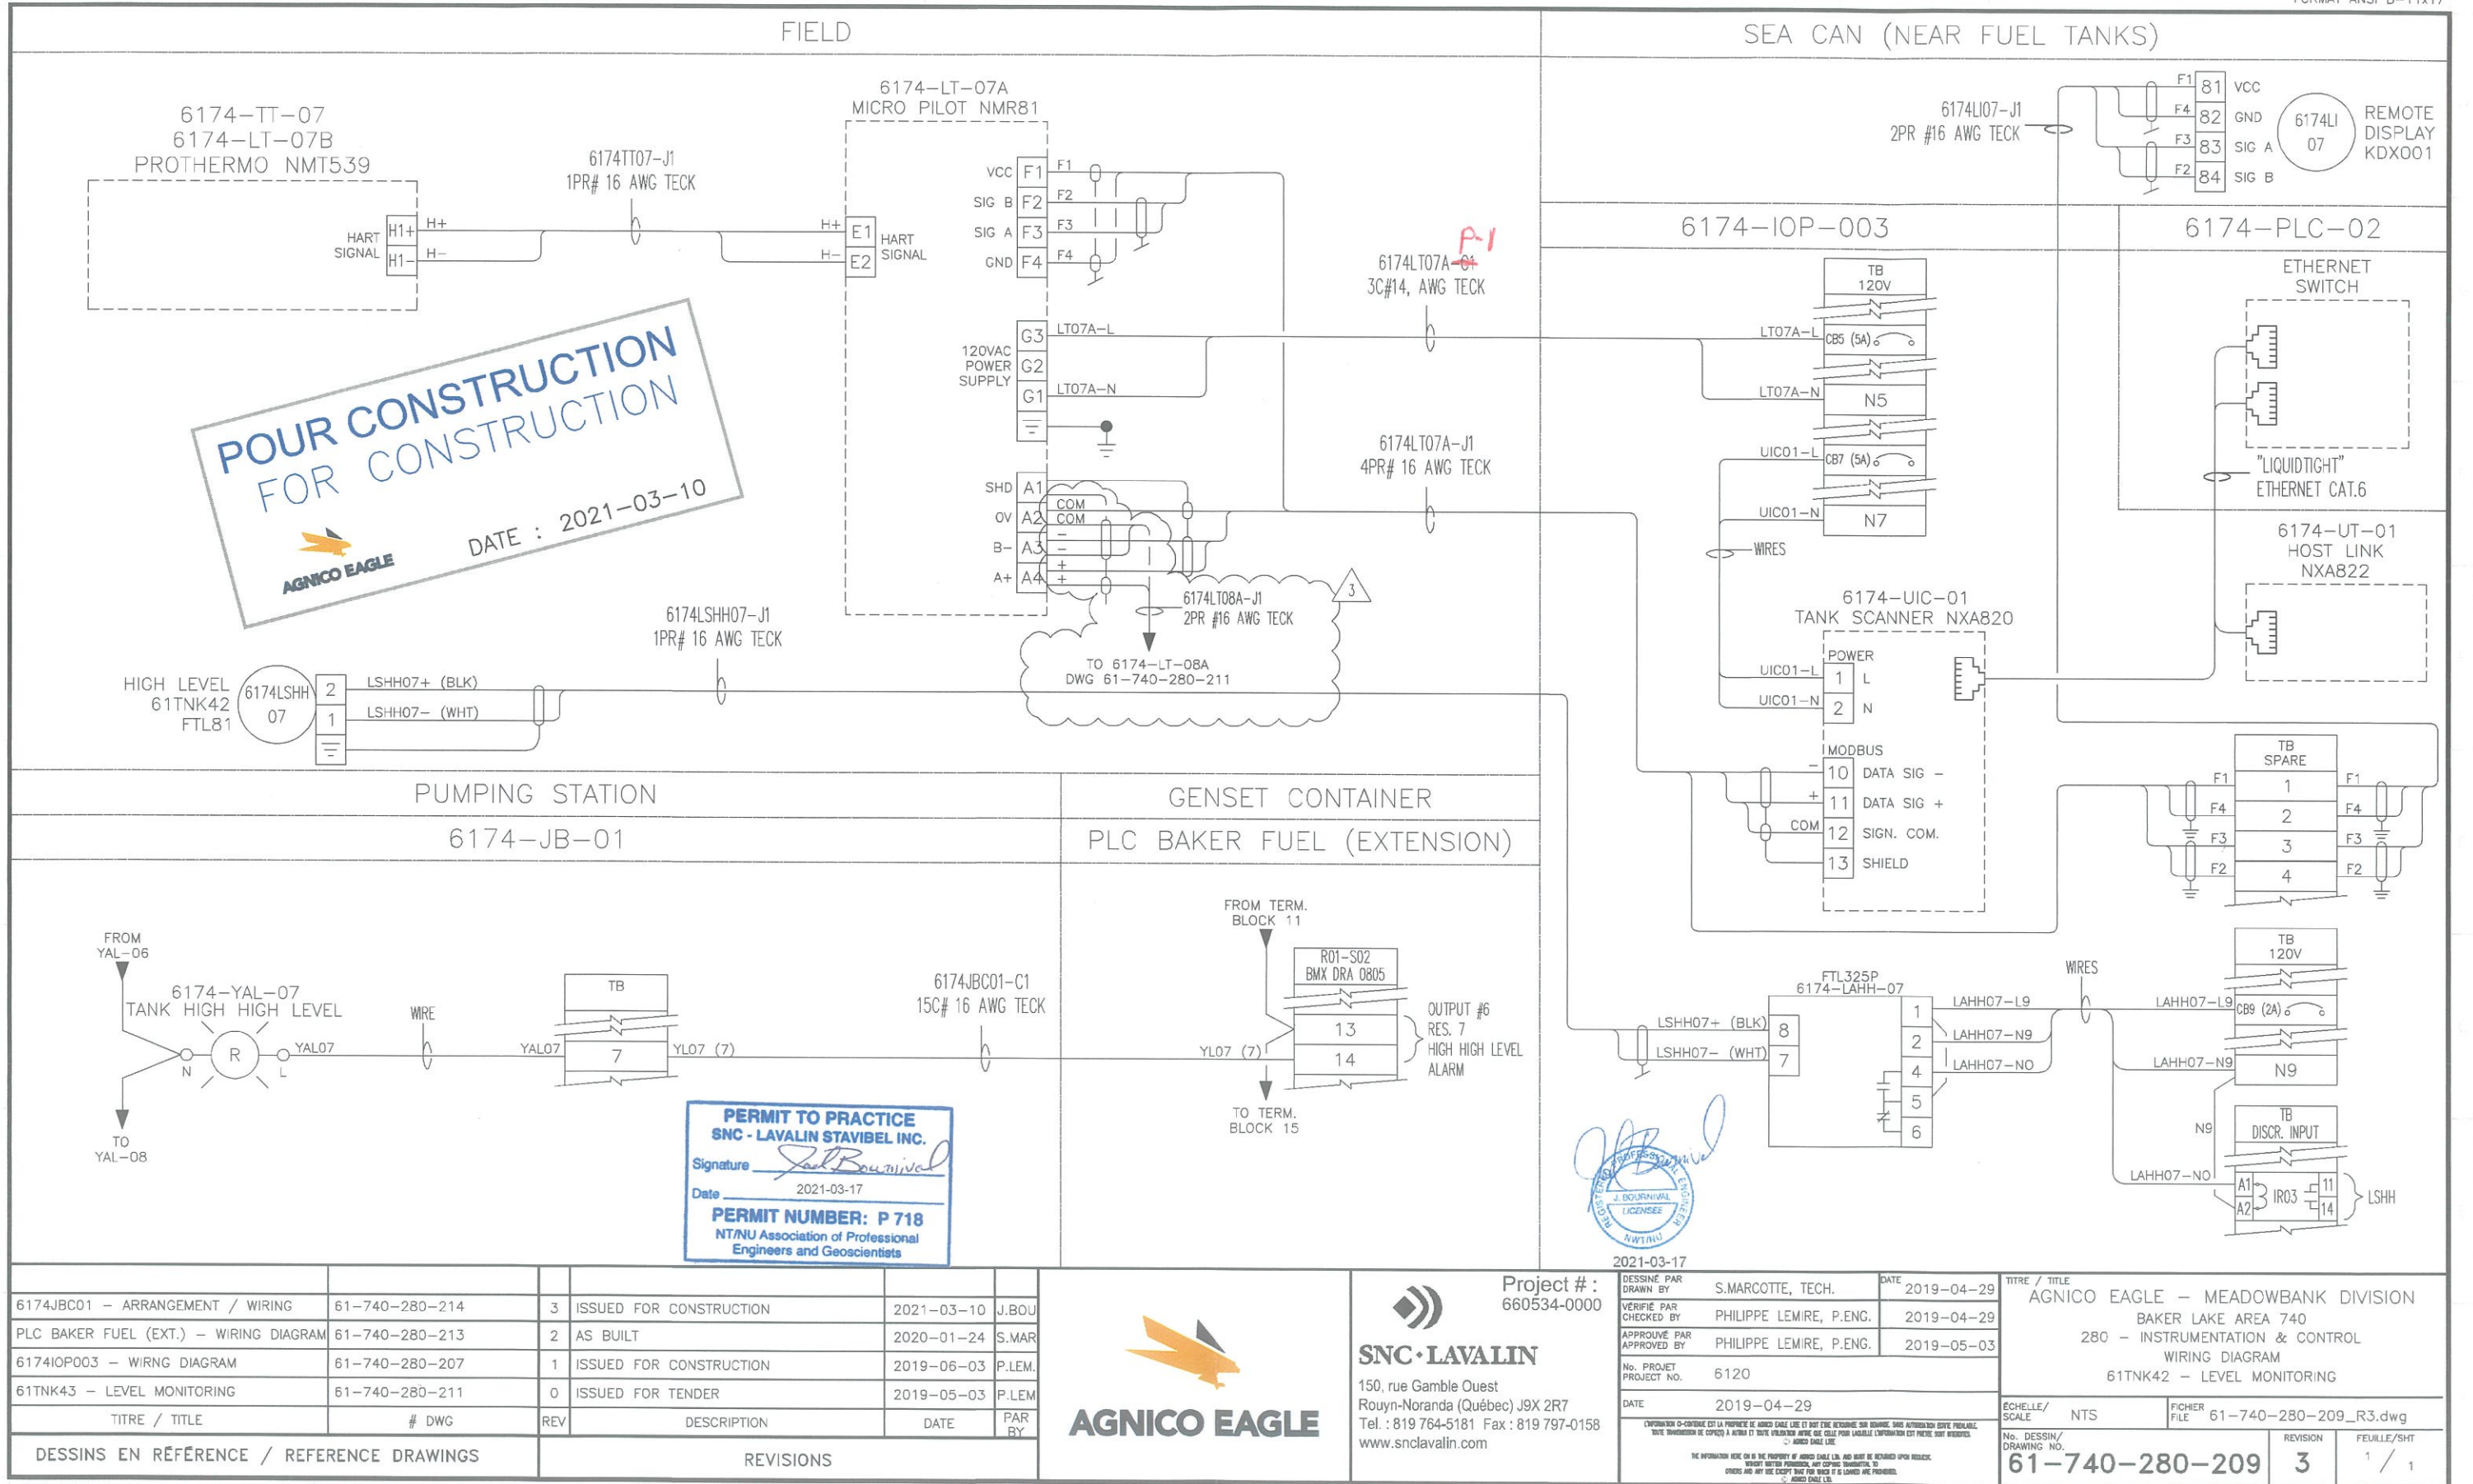




FIELD

SEA CAN (NEAR FUEL TANKS)

POUR CONSTRUCTION
FOR CONSTRUCTION



DATE : 2021-03-10

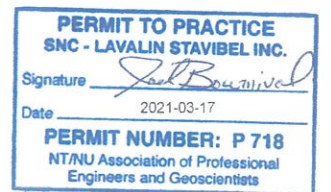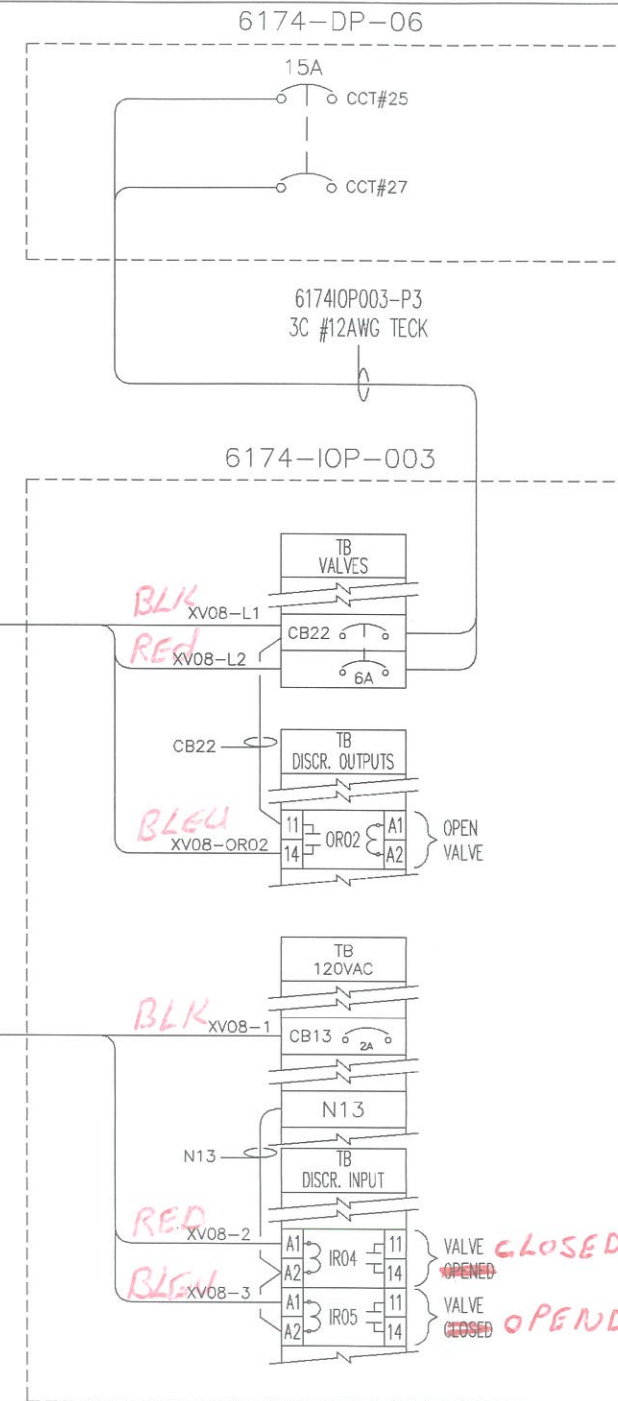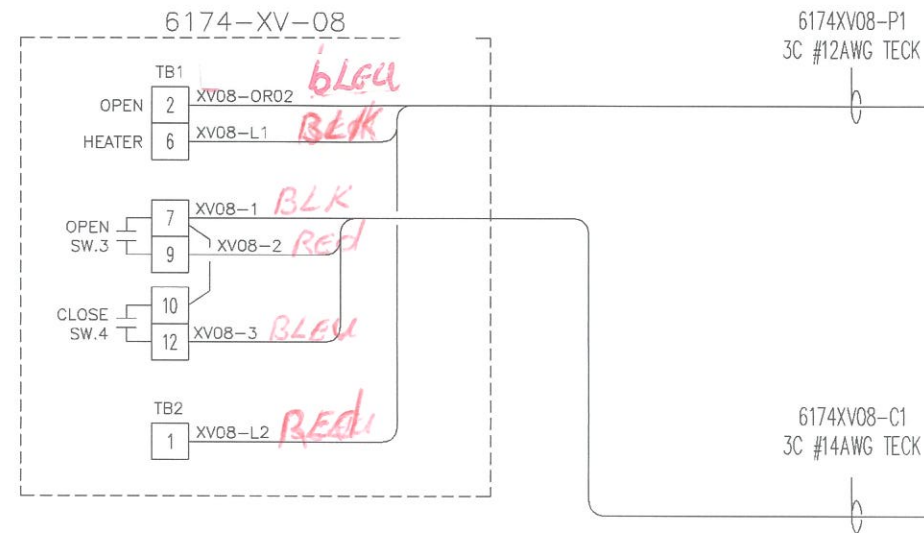

2021-03-17

		3	ISSUED FOR CONSTRUCTION	2021-03-10	J.BOU
		2	AS BUILT	2020-01-24	S.MAR
6174-DP-06 - SCHEDULE	61-740-285-200	1	ISSUED FOR CONSTRUCTION	2019-06-03	P.LEM
6174IOP003 - WIRING DIAGRAM	61-740-280-207	0	ISSUED FOR TENDER	2019-05-03	P.LEM
TITRE / TITLE	# DWG	REV	DESCRIPTION	DATE	PAR BY
DESSINS EN RÉFÉRENCE / REFERENCE DRAWINGS			REVISIONS		




Project # : 660534-0000


SNC • LAVALIN



150, rue Gamble Ouest
Rouyn-Noranda (Québec) J9X 2R7
Tel. : 819 764-5181 Fax : 819 797-0158
www.snc-lavalin.com

DESSINÉ PAR DRAWN BY	S.MARCOTTE, TECH.	DATE	2019-04-30
VERIFIÉ PAR CHECKED BY	PHILIPPE LEMIRE, P.ENG.	2019-04-30	
APPROUVÉ PAR APPROVED BY	PHILIPPE LEMIRE, P.ENG.	2019-05-03	
No. PROJET PROJECT NO.	6120		
DATE	2019-04-30		
L'INFORMATION CI-CONTRE EST LA PROPRIÉTÉ DE AGNICO EAGLE LTD. ET DOIT ÊTRE RETENUE SOUS SCÈLLE. Toute reproduction ou copie sans autorisation écrite préalable est interdite. Toute violation sera poursuivie. Toute information est fournie sans garantie. Toute information est fournie sans garantie. Toute information est fournie sans garantie.			

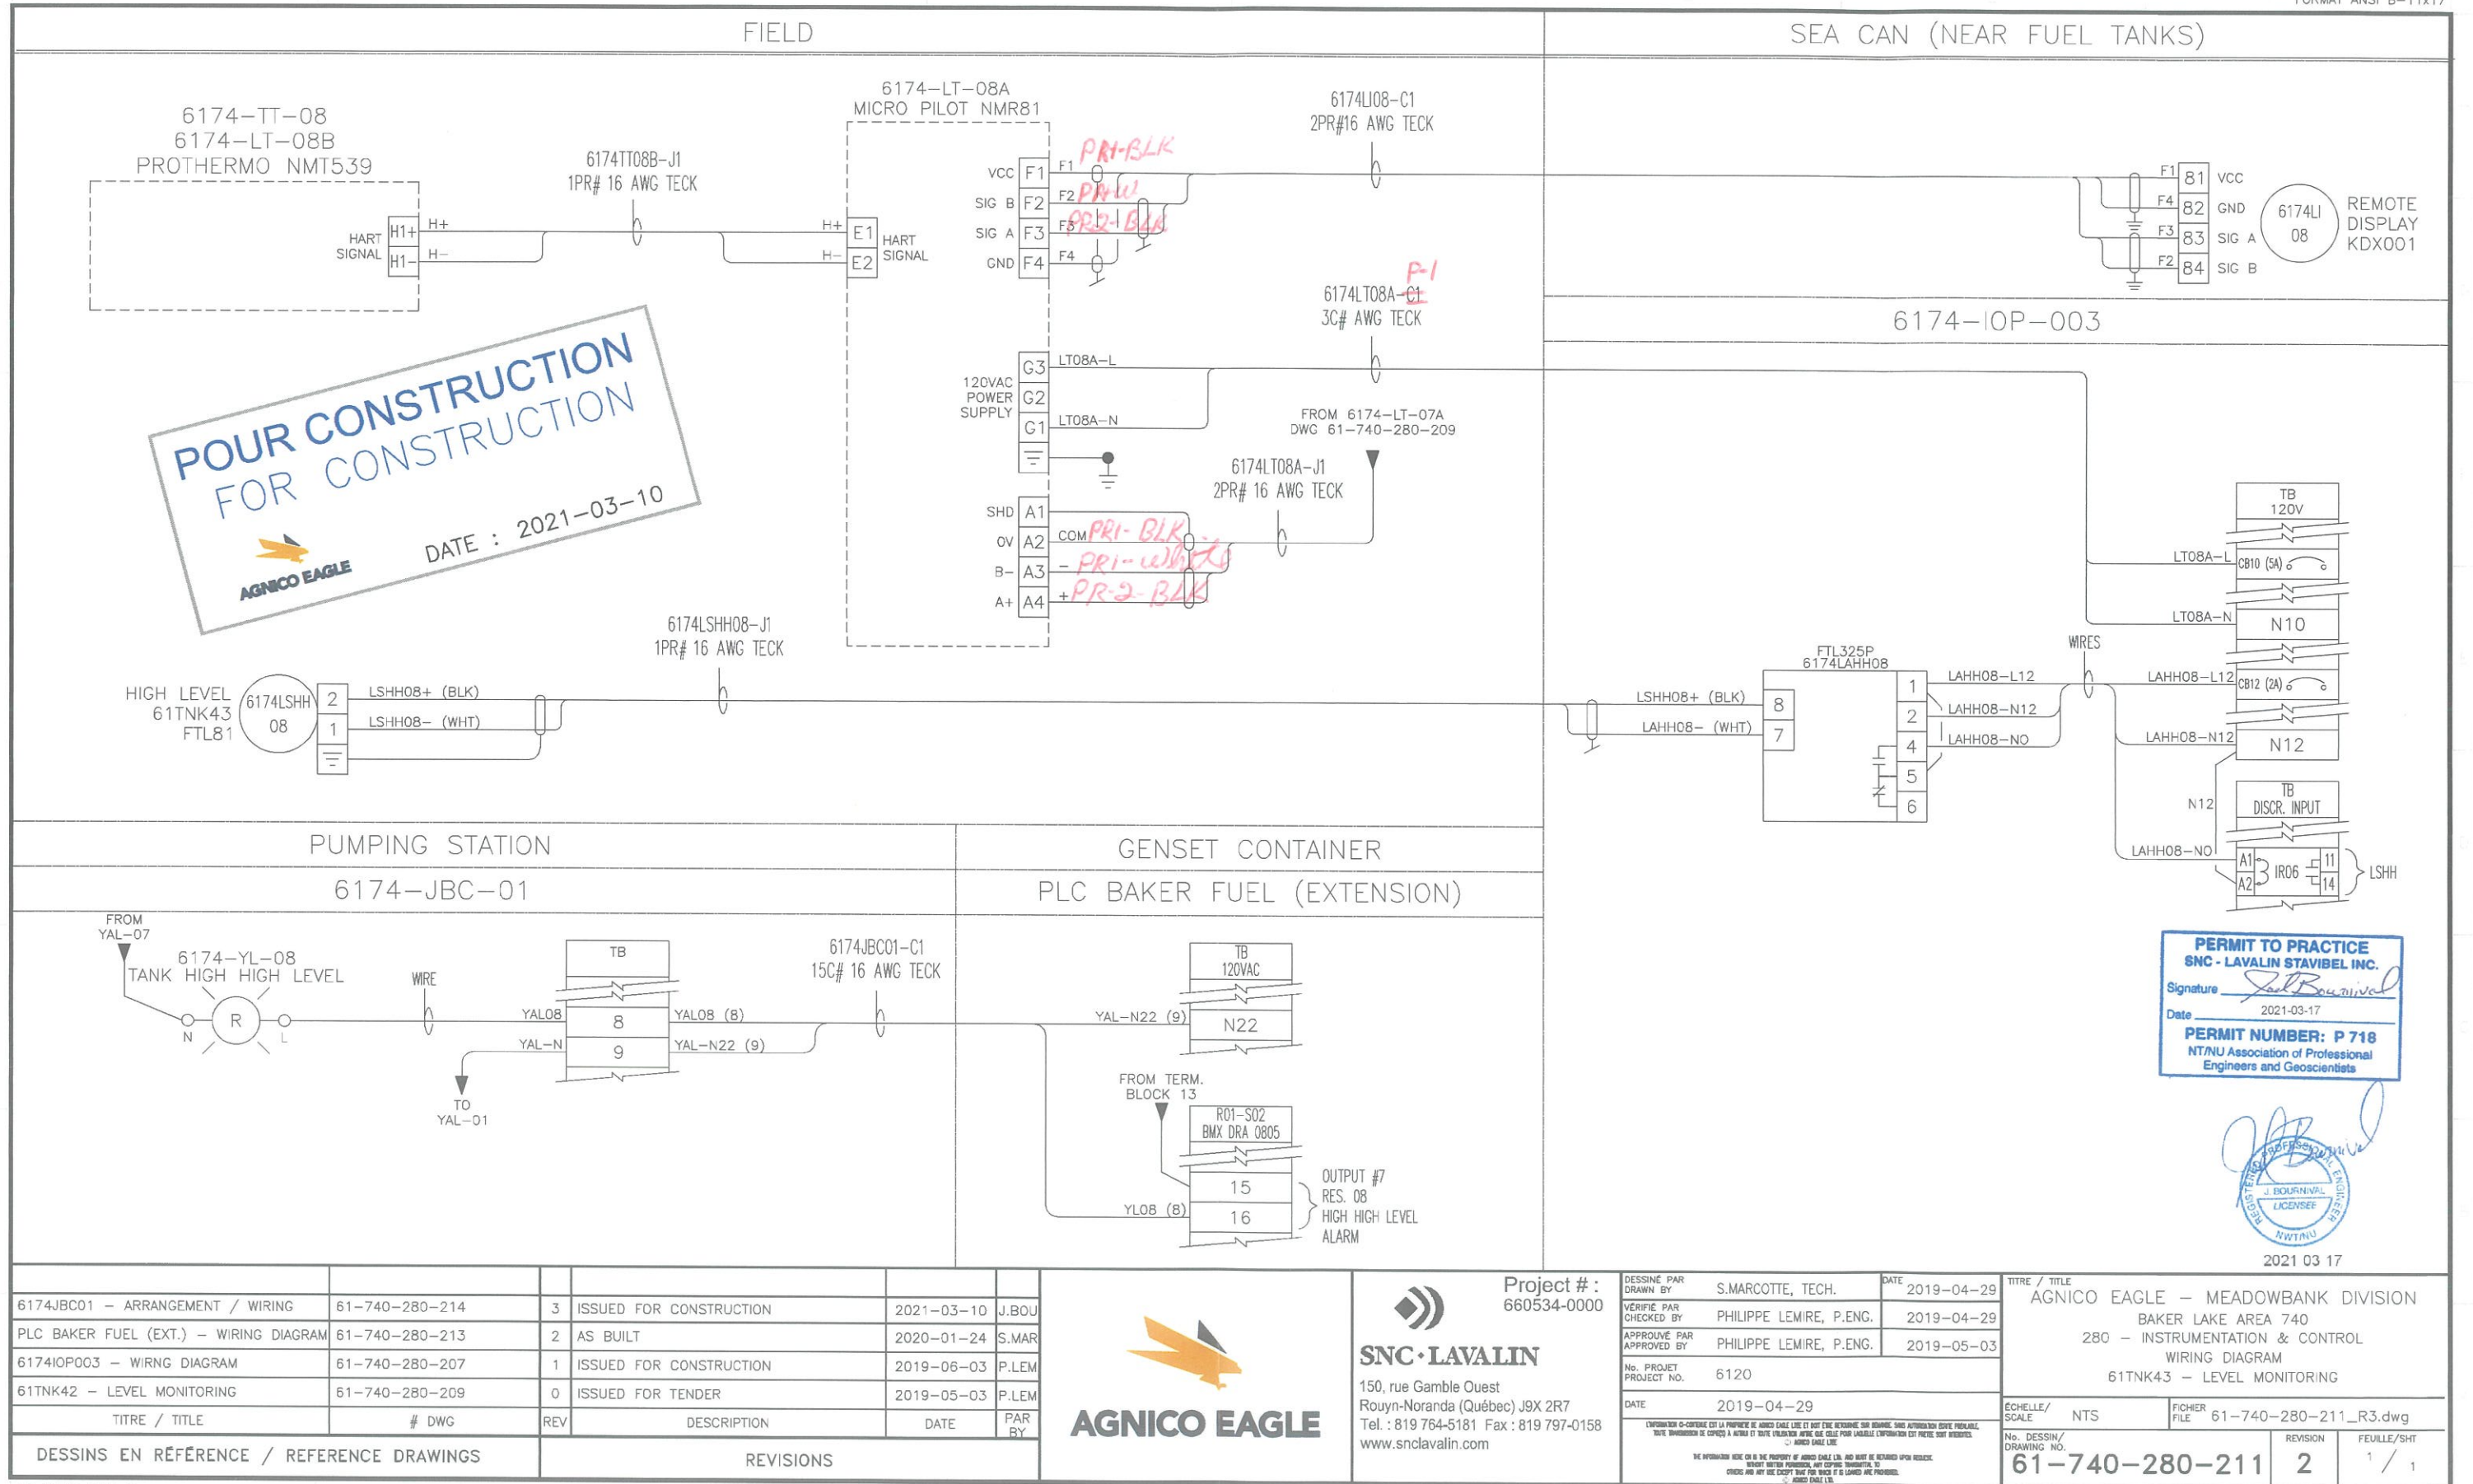TITRE / TITLE		AGNICO EAGLE - MEADOWBANK DIVISION	
		BAKER LAKE AREA 740	
		280 - INSTRUMENTATION & CONTROL	
		WIRING DIAGRAM	
		6170TNK43 - VALVE 6174-XV-08	
ECHELLE/ SCALE	NTS	FICHIER FILE	61-740-280-212_R3.dwg
No. DESSIN/ DRAWING NO.	61-740-280-212	REVISION	3
		FEUILLE/SHT	1 / 1

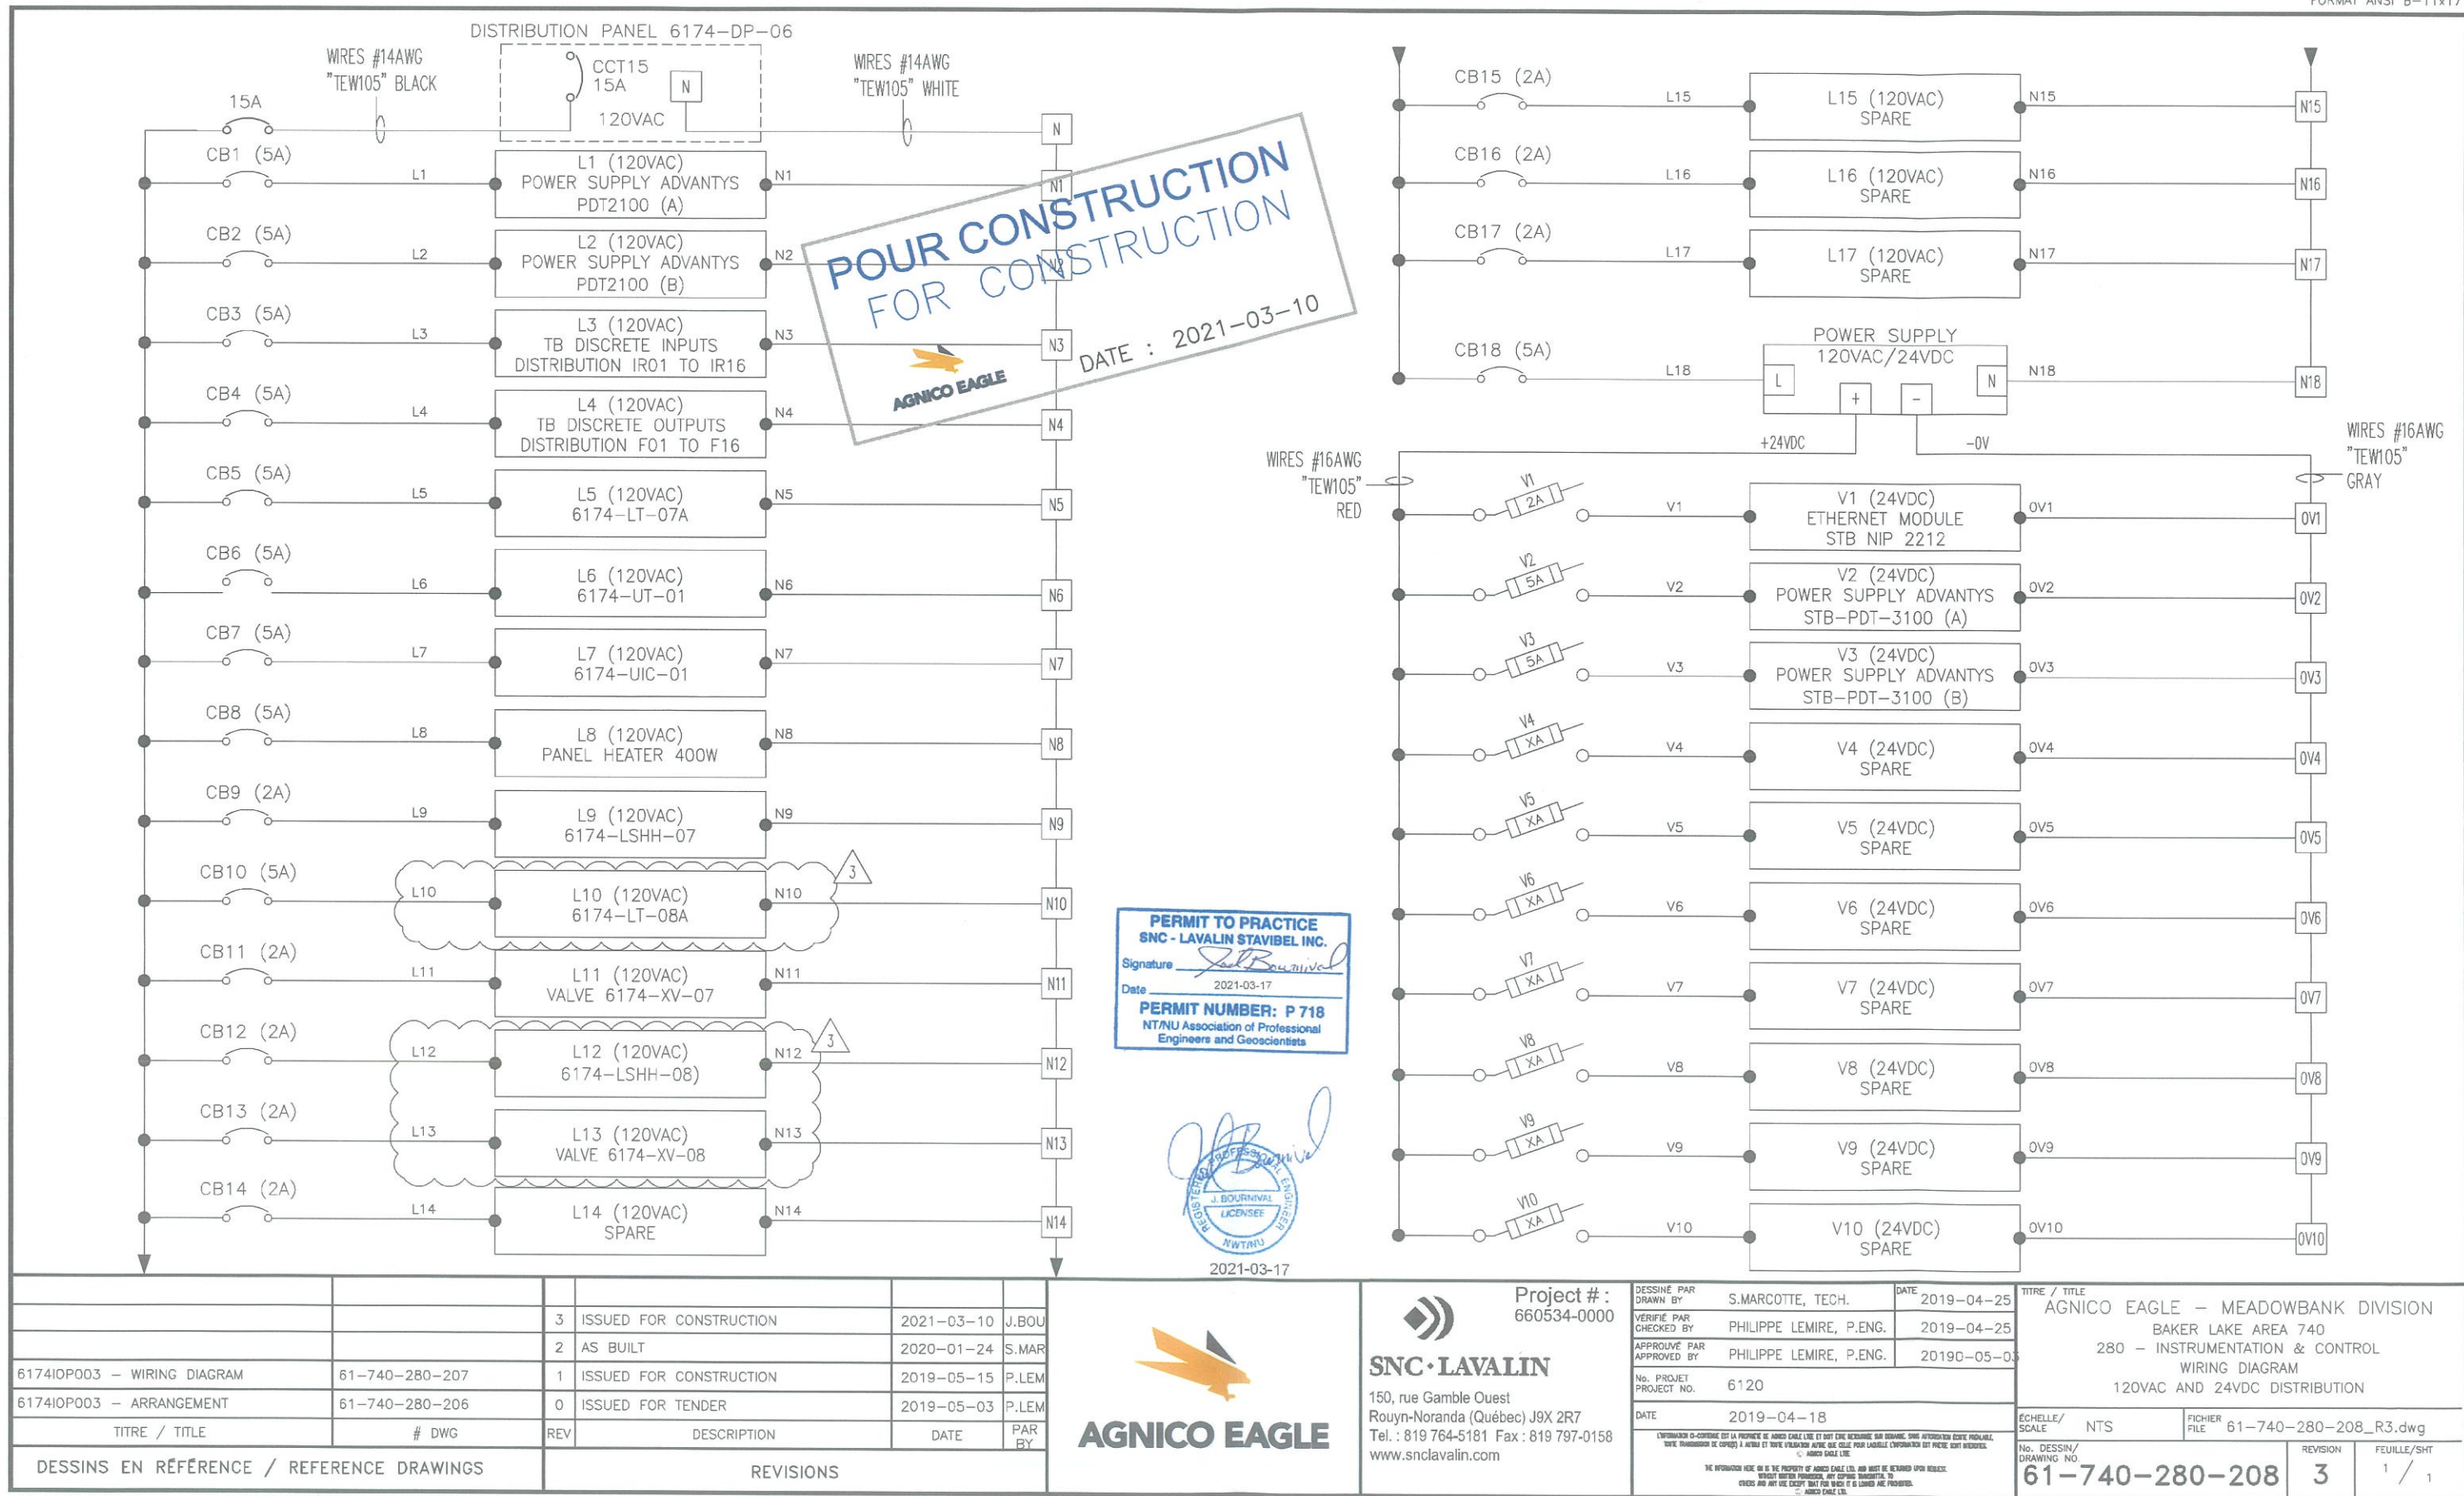



 SNC • LAVALIN	OWNER		Agnico Eagle Mines	BY:	Nathan Bisson				 AGNICO EAGLE			
	PROJECT NAME:		Baker Lake Fuel Farm	APPROVED:	Roxanne Lavoie, P.Eng. (OIQ) / I.Gagnon P.Eng.							
	PROJECT NO:		6129-S-265-020	REV:	0 - For Tender							
	DOC NO:		6129-S-265-020-MTO-002	REV DATE:	2021-06-30							
			MTO Piping - Baker Lake Fuel Farm Drawing number: 61-740-270-003	MATERIAL TAKE OFF Description								
Rev. Date	Qty ¹	Unit	Description	ND	STANDARD	SCH./PN	PACKAGE #	MTO #	MATERIAL	MANUFACTURER	MODEL	REMARKS
PIPING AND FITTING TABLE												
2021-06-30	260	m	STEEL PIPING	Ø150mm	ASTM A333 GR.6	SCH. STD			CARBON STEEL			SHOP PAINTED AS PER 60-000-245-GGD-001. YELLOW
2021-06-30	20	UNIT	WIELDING NECK FLANGE	Ø150mm	A350 GR. LF2	CL150			FORGED STEEL			SHOP PAINTED AS PER 60-000-245-GGD-001. YELLOW
2021-06-30	2	UNIT	BLIND FLANGE	Ø150mm	ASTM A420 GR.WPL6	CL150			FORGED STEEL			SHOP PAINTED AS PER 60-000-245-GGD-001. YELLOW
2021-06-30	19	UNIT	45° ELBOW BUTT WELD	Ø150mm	ASTM A420 GR.WPL6, BW	SCH. STD			FORGED STEEL			SHOP PAINTED AS PER 60-000-245-GGD-001. YELLOW
2021-06-30	4	UNIT	90° LONG RADIUS ELBOW BUTT WELD	Ø150mm	ASTM A420 GR.WPL6, BW	SCH. STD			FORGED STEEL			SHOP PAINTED AS PER 60-000-245-GGD-001. YELLOW
2021-06-30	5	UNIT	STRAIGHT TEE BUTT WELD	Ø150mm	ASTM A420 GR.WPL6, BW	SCH. STD			FORGED STEEL			SHOP PAINTED AS PER 60-000-245-GGD-001. YELLOW
2021-06-30	1	UNIT	WELDED 45° LATERAL BUTT WELD	Ø150mm	ASTM A420 GR.WPL6, BW	SCH. STD			FORGED STEEL			SHOP PAINTED AS PER 60-000-245-GGD-001. YELLOW
2021-06-30	2	UNIT	FLEXIBLE HOSE, 350 mm Lg.	Ø150mm	FLANGED	CL150			STAINLESS STEEL	SENIOR FLEXTRONICS	SA-BSFS SERIES	
2021-06-30	1	UNIT	FLEXIBLE HOSE, 450 mm Lg.	Ø150mm	FLANGED	CL150			STAINLESS STEEL	SENIOR FLEXTRONICS	SA-BSFS SERIES	
2021-06-30	6	UNIT	ECCENTRIC REDUCER BUTT WELD	Ø150x100mm	ASTM A420 GR.WPL6, BW	SCH. STD			CARBON STEEL			SHOP PAINTED AS PER 60-000-245-GGD-001. YELLOW
2021-06-30	6	UNIT	BLIND FLANGE	Ø100mm	ASTM A420 GR.WPL6	CL150			FORGED STEEL			SHOP PAINTED AS PER 60-000-245-GGD-001. YELLOW
2021-06-30	10	UNIT	WIELDING NECK FLANGE	Ø100mm	A350 GR. LF2	CL150			FORGED STEEL			SHOP PAINTED AS PER 60-000-245-GGD-001. YELLOW
2021-06-30	3	UNIT	THREAOLET FOR Ø150mm PIPE	Ø25mm	ASTM A350 GR.LF2	CL3000			FORGED STEEL			
2021-06-30	2	m	PIPING	Ø25mm	ASTM A333 GR.6	SCH. 80			CARBON STEEL			SHOP PAINTED AS PER 60-000-245-GGD-001. YELLOW
2021-06-30	3	UNIT	SCREW CAP	Ø25mm	FORGED STEEL	CL3000			FORGED STEEL			
2021-06-30	22	UNIT	FLEXIBLE BRAID	-	-	-				NVENT	MBJ 35-250-25	
PIPING AND SUPPORT TABLE												
2021-06-30	12	UNIT	TYPE 1 PREFAB PIPING SUPPORT ON DRAWING 61-740-270-XXX	-	HSS G40 350 W OR ASTM A500	-			STRUCTURAL STEEL			SHOP PAINTED AS PER 60-000-245-GGD-001. GREY
2021-06-30	43	UNIT	TYPE 2 PREFAB PIPING SUPPORT ON DRAWING 61-740-270-XXX	-	HSS G40 350 W OR ASTM A500	-			STRUCTURAL STEEL			SHOP PAINTED AS PER 60-000-245-GGD-001. GREY
2021-06-30	4	UNIT	TYPE 3 PREFAB PIPING SUPPORT ON DRAWING 61-740-270-XXX	-	HSS G40 350 W OR ASTM A500	-			STRUCTURAL STEEL			SHOP PAINTED AS PER 60-000-245-GGD-001. GREY
2021-06-30	15	UNIT	EXTRA GREY PAINT GALLONS	-	-	-			-			FOR PAINT TOUCH-UP ON SITE
2021-06-30	10	UNIT	EXTRA YELLOW PAINT GALLON	-	-	-			-			FOR PAINT TOUCH-UP ON SITE
VALVE TABLE												
2021-06-30	7	UNIT	GATE VALVE	Ø150mm	ASTM A-352, FLANGED	CL150			LCC	BERIC	API 600, LCC BODY	
2021-06-30	3	UNIT	BALL VALVE API 607	Ø25mm	SOCKET WELD				LCC	APOLLO	83L-240-24 SERIES	

¹ No contingency was planned on material take off list and no material was planned for field adjustment.

Roxanne Lavoie

I. Gagnon
L3940 2021-06-30



S1: PIPE SUPPORT TYPE 1
S2: PIPE SUPPORT TYPE 2
SEE DWG. # 61-740-270-202

POUR CONSTRUCTION
FOR CONSTRUCTION
AFRICO EAGLE
DATE : 2021-03-23



SNC-Lavalin Stavitel inc.
150, rue Gamble Ouest
Rouyn-Noranda (Québec) J9X 2R7
Tel. : 819 764-5181 Fax : 819 797-0158
www.snc-lavalin.com

Project #: 671087-0000

REV.: 2

L'OPÉRATION O-CONTIENT DE LA PROPRIÉTÉ DE AIGIS SANS L'ÉTAT ET NE S'EST RÉVÉLÉE SON COMMERCE, SANS AUCUNEMENT D'UN
PÉRIODE, SANS TROUVER DE CÉLÈBRE À AIGIS ET SANS VÉRIFICATION AVEC DE CÉLÈBRE POUR LA SÉCURITÉ L'OPÉRATION O-CONTIENT
SANS TROUVER. AIGIS SANS L'ÉTAT

THE INFORMATION HERE ON IS THE PROPERTY OF ARROW EAGLE LTD. AND MUST BE RETURNED UPON REQUEST. WITHOUT WRITTEN PERMISSION ANY COPIES, TRANSMISSION, TO WHOM AND ANY USE, EXCEPT THAT FOR WHICH IT IS LOANED ARE PROHIBITED.

DESSINS EN RÉFÉRENCE / REFERENCE DRAWINGS

TITLE / TITLE	# DWG
GENERAL EARTH WORKS	61-740-230-200 TO 202
ELECTRICAL	61-740-275-200 TO 202
P&ID	61-740-J-0100, 1 & 2
10M LITERS DIESEL TANK @ (6170THK43)	61-740-270-001
TANK 7 & 8 PIPE SUPPORTS - DETAILS	61-740-270-202
TANK 7 & 8 PIPING - ELEV. & DETAILS	61-740-270-201

[illegible]

REVISIONS



2021-03-23

TITLE / TITLE


AGNICO EAGLE - MEADOWBANK DIVISION
740 BAKER LAKE AREA
PIPING
PLAN VIEW
10M LITERS DIESEL TANK #7 (6170TNK42)
& TANK #8 (6170TNK43) PIPING




DESIGNED PAR DRAWN BY	B. LEMIEUX, Tech.	DATE 2019/02/
VERIFIED PAR CHECKED BY	R. LAVOIE, Jr. Eng.	2019/02/
APPROVED PAR APPROVED BY	A. OUELLET, P. Eng.	2019/02/

ÉCHELLE SCALE	1 : 300	DATE	2019/02/15
------------------	---------	------	------------

NO. DESIGN DRAWING NO.	61-740-270-200
---------------------------	----------------

NO. PROJ. PROJECT NO.	REVISION	FOLLE / 89
6120	2	1 / 1

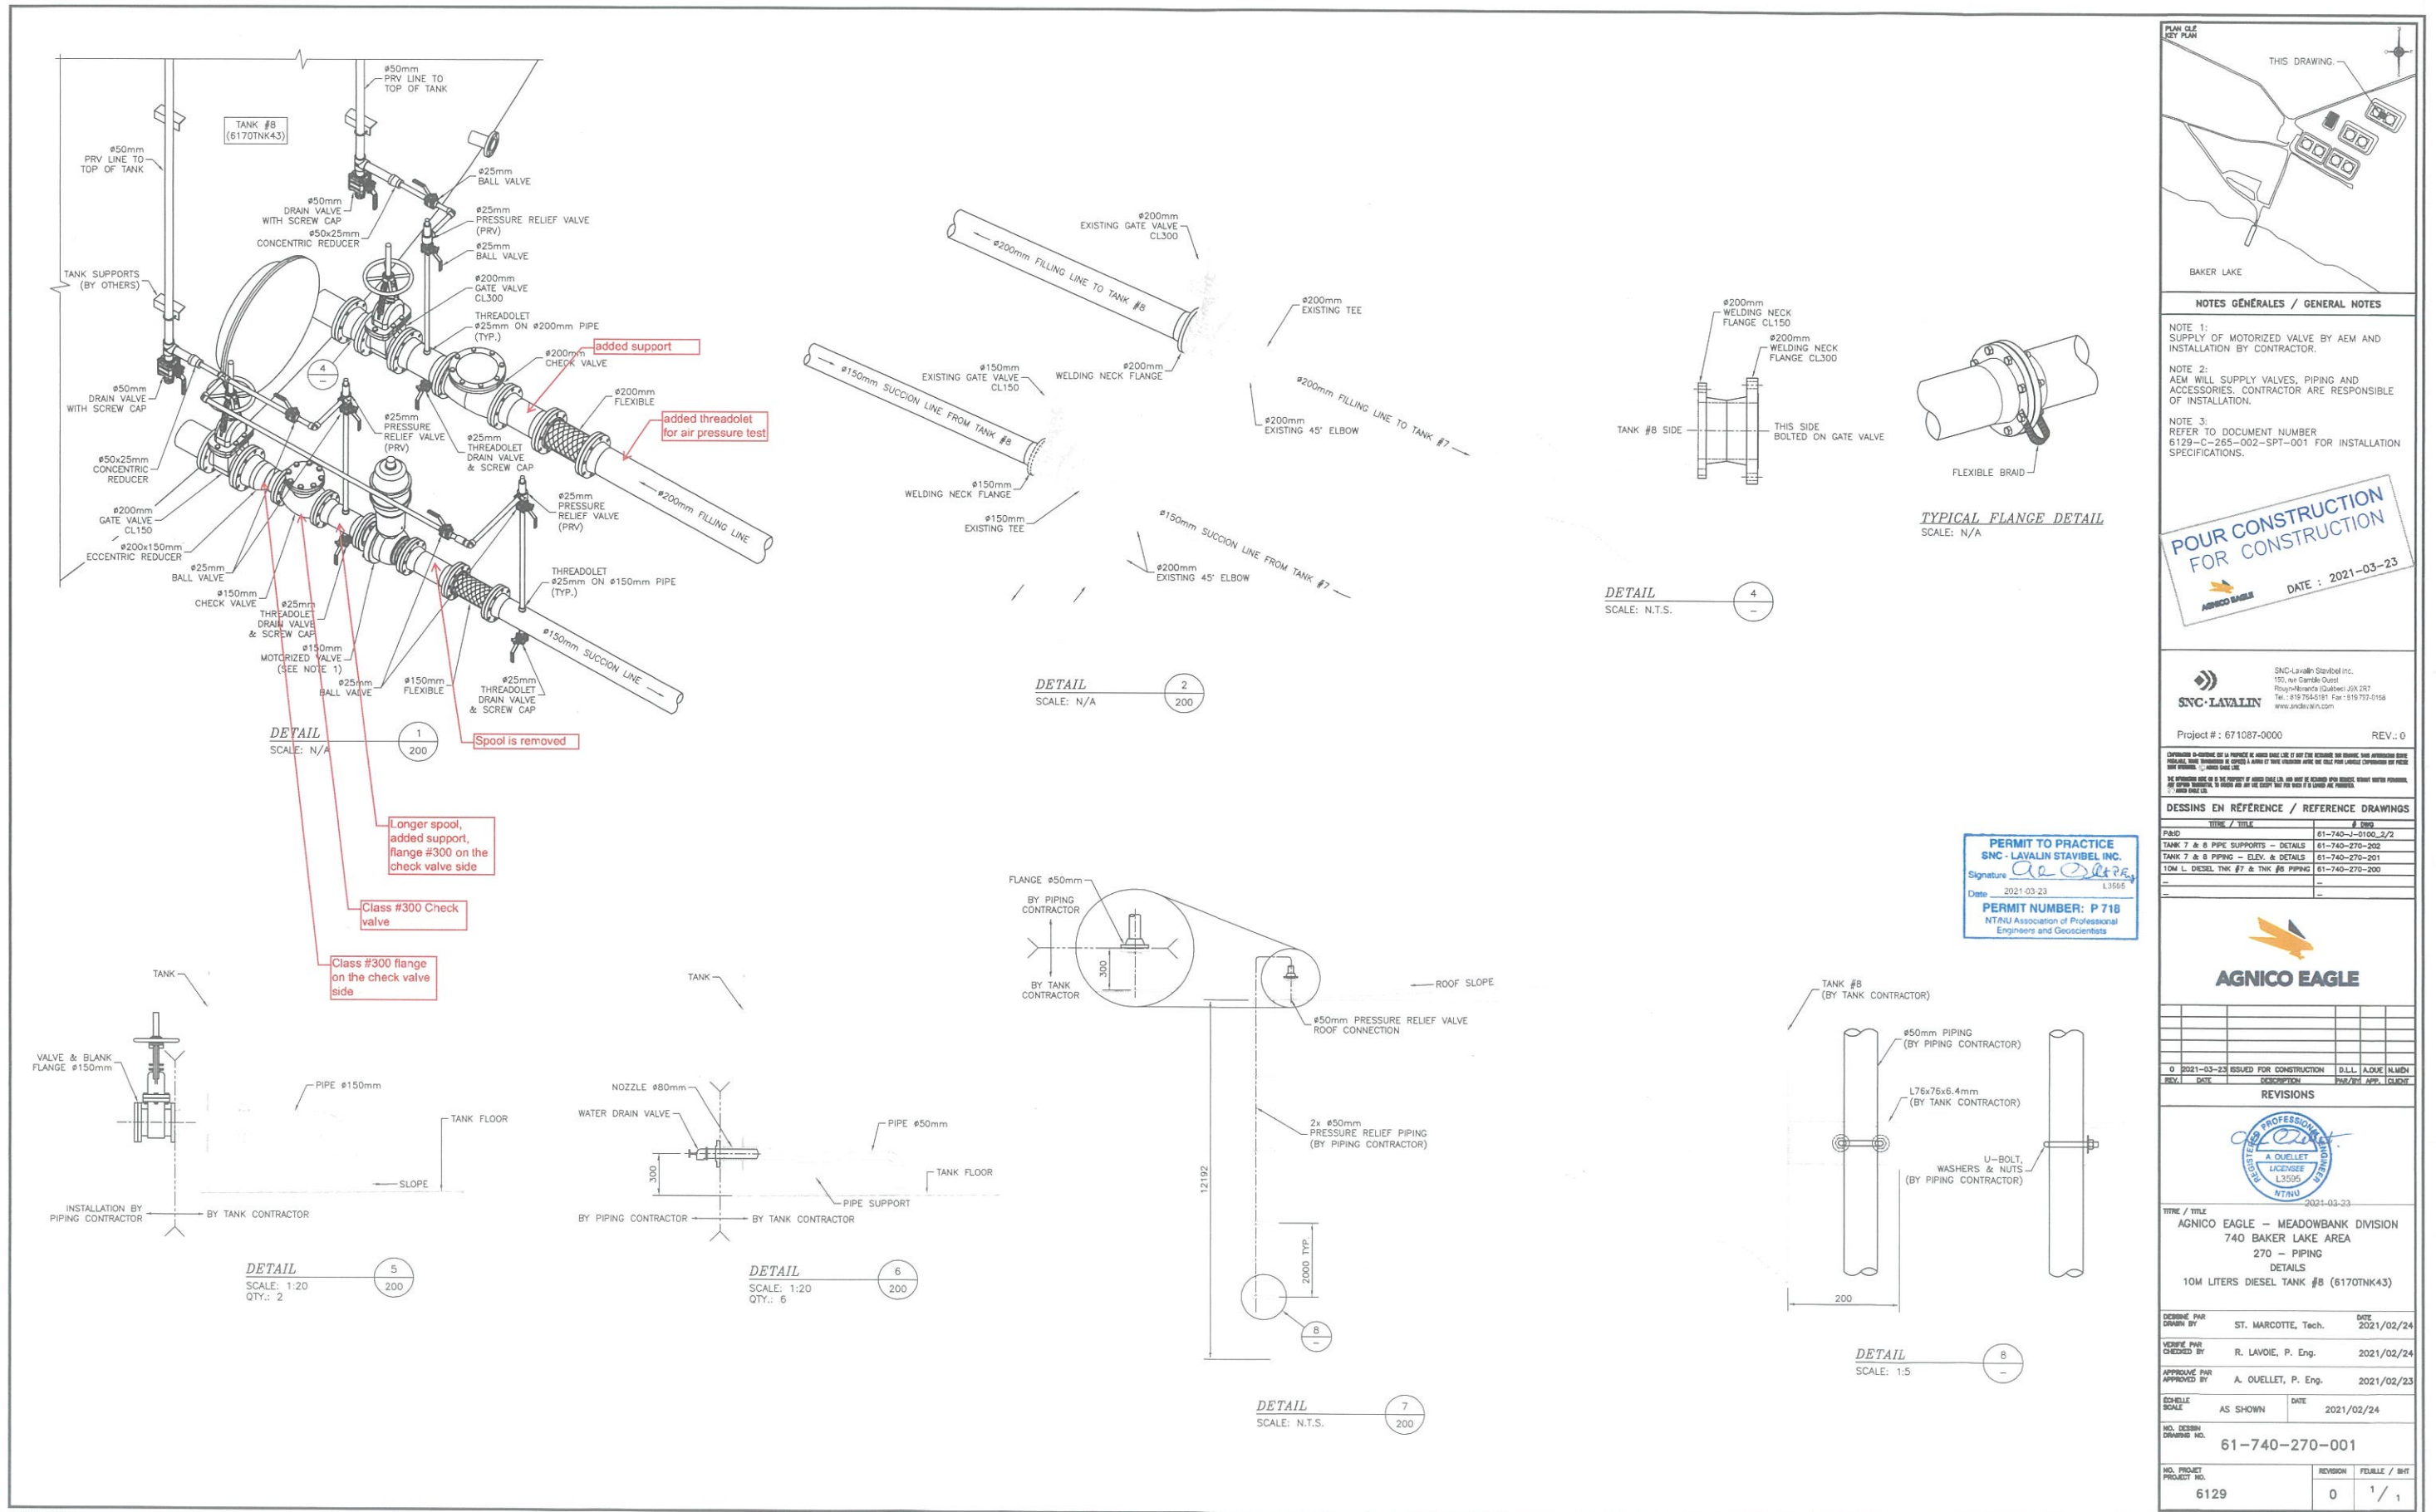

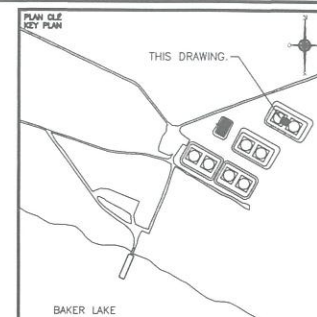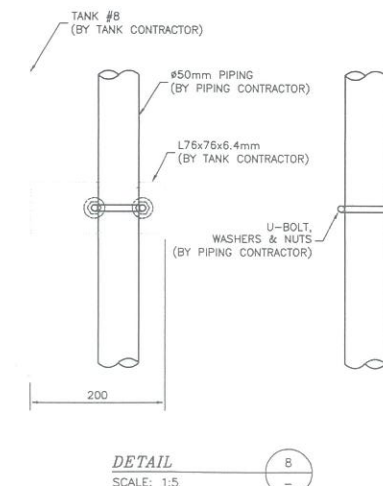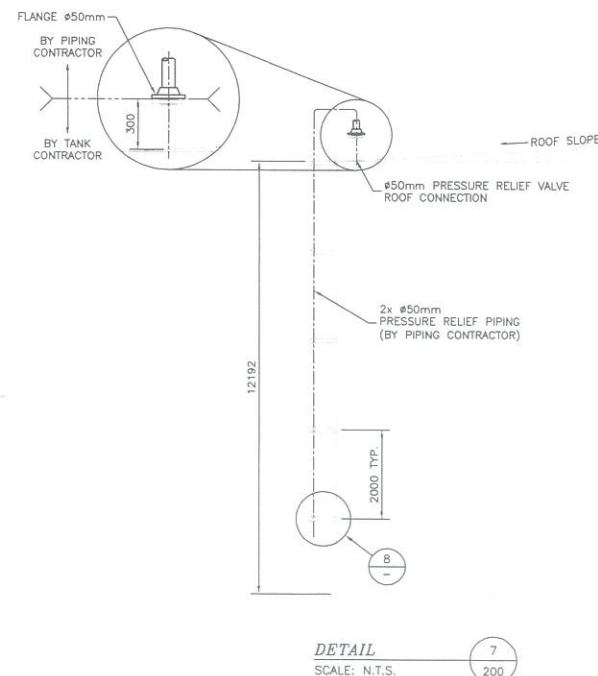

NOTES GÉNÉRALES / GENERAL NOTES

NOTE 1:
SUPPLY OF MOTORIZED VALVE BY AEM AND
INSTALLATION BY CONTRACTOR.

NOTE 2:
AEM WILL SUPPLY VALVES, PIPING AND
ACCESSORIES. CONTRACTOR ARE RESPONSIBLE
OF INSTALLATION.

NOTE 3:
REFER TO DOCUMENT NUMBER
6129-C-265-002-SPT-001 FOR INSTALLATION
SPECIFICATIONS.

POUR CONSTRUCTION
FOR CONSTRUCTION
AMERCO EAGLE
DATE : 2021-03-23



SNC-Lavalin Styrilbel Inc.
150, rue Gamble Ouest
Rouyn-Noranda (Québec) J0X 2R7
Tel.: 819 764-5181 Fax: 819 797-0158
www.sncslavalin.com

Project #: 671087-0000 REV.: 0

CHAMPAGNON IS CONTENTE EST LA PROPRIÉTÉ DE AMIGO CHALE L&L ET DOIT ÊTRE RETENUE SUR DEMANDE. SANS AUTORISATION DE PRÉALABLE, TOUTE TRANSMISSION DE COPIES À AUTRUI ET TOUTE VULGARISATION AUTRE QUE CELLE POUR L'ÉTIQUETTE CHAMPAGNON EST PROHIBÉE. © AMIGO CHALE L&L

DESSINS EN RÉFÉRENCE / REFERENCE DRAWINGS

TIME / TITLE	# DNG
PAID	61-740-J-0100_2/2
TANK 7 & 8 PIPE SUPPORTS - DETAILS	61-740-270-202
TANK 7 & 8 PIPING - ELEV. & DETAILS	61-740-270-201
10M L. DIESEL. TANK #7 & TANK #8 PIPING	61-740-270-200
-	-



0	2021-03-23	ISSUED FOR CONSTRUCTION	D.L.I.	AJOU	N.M.

REVISIONS



2021-03-23
TITLE / TITLE
AGNICO EAGLE - MEADOWBANK DIVISION
740 BAKER LAKE AREA
270 - PIPING
DETAILS
10M LITERS DIESEL TANK #8 (6170TNK43)

DESIGNÉ PAR _____ DATE _____

VERIFIÉ PAR
CHECKED BY R. LAYDIE, P. Eng. 2021/02/2

APPROUVÉ PAR
APPROVED BY A. OUELLET, P. Eng. 2021/02/21

SCHELLE SCALE	AS SHOWN	DATE	2021/02/24
------------------	----------	------	------------

NO. DESIGN
DRAWING NO. 61-740-270-001

NO. PROJET PROJECT NO.	REVISION	FOLLETT / 8
6129	0	1 / 1