
 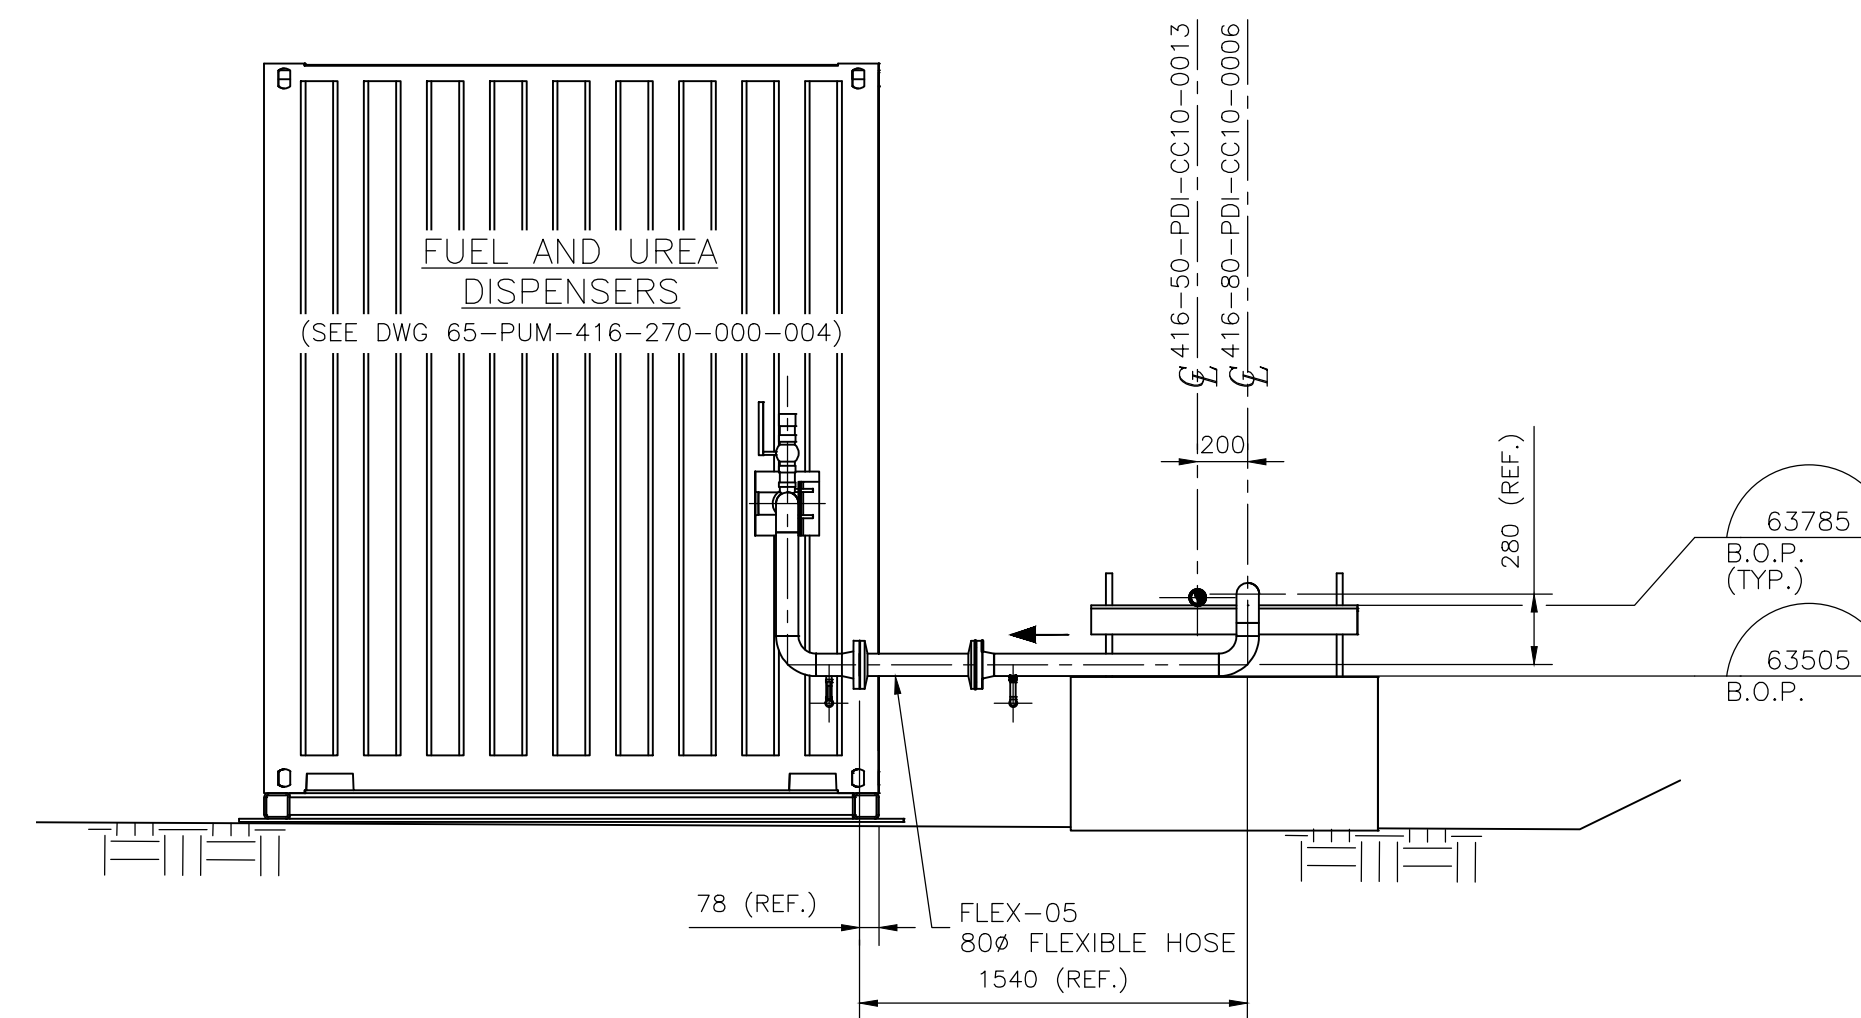



SECTION

SCL: 1:50



SECTION

 SCL: 1:30



POUR SOUMISSION
FOR TENDER


05-06-13

AGNICO EAGLE

PERMIT TO PRACTICE
WSP Canada, Inc.


Signature _____
Date _____

PERMIT NUMBER: P407
NT/NU Association of Professional
Engineers and Geoscientists

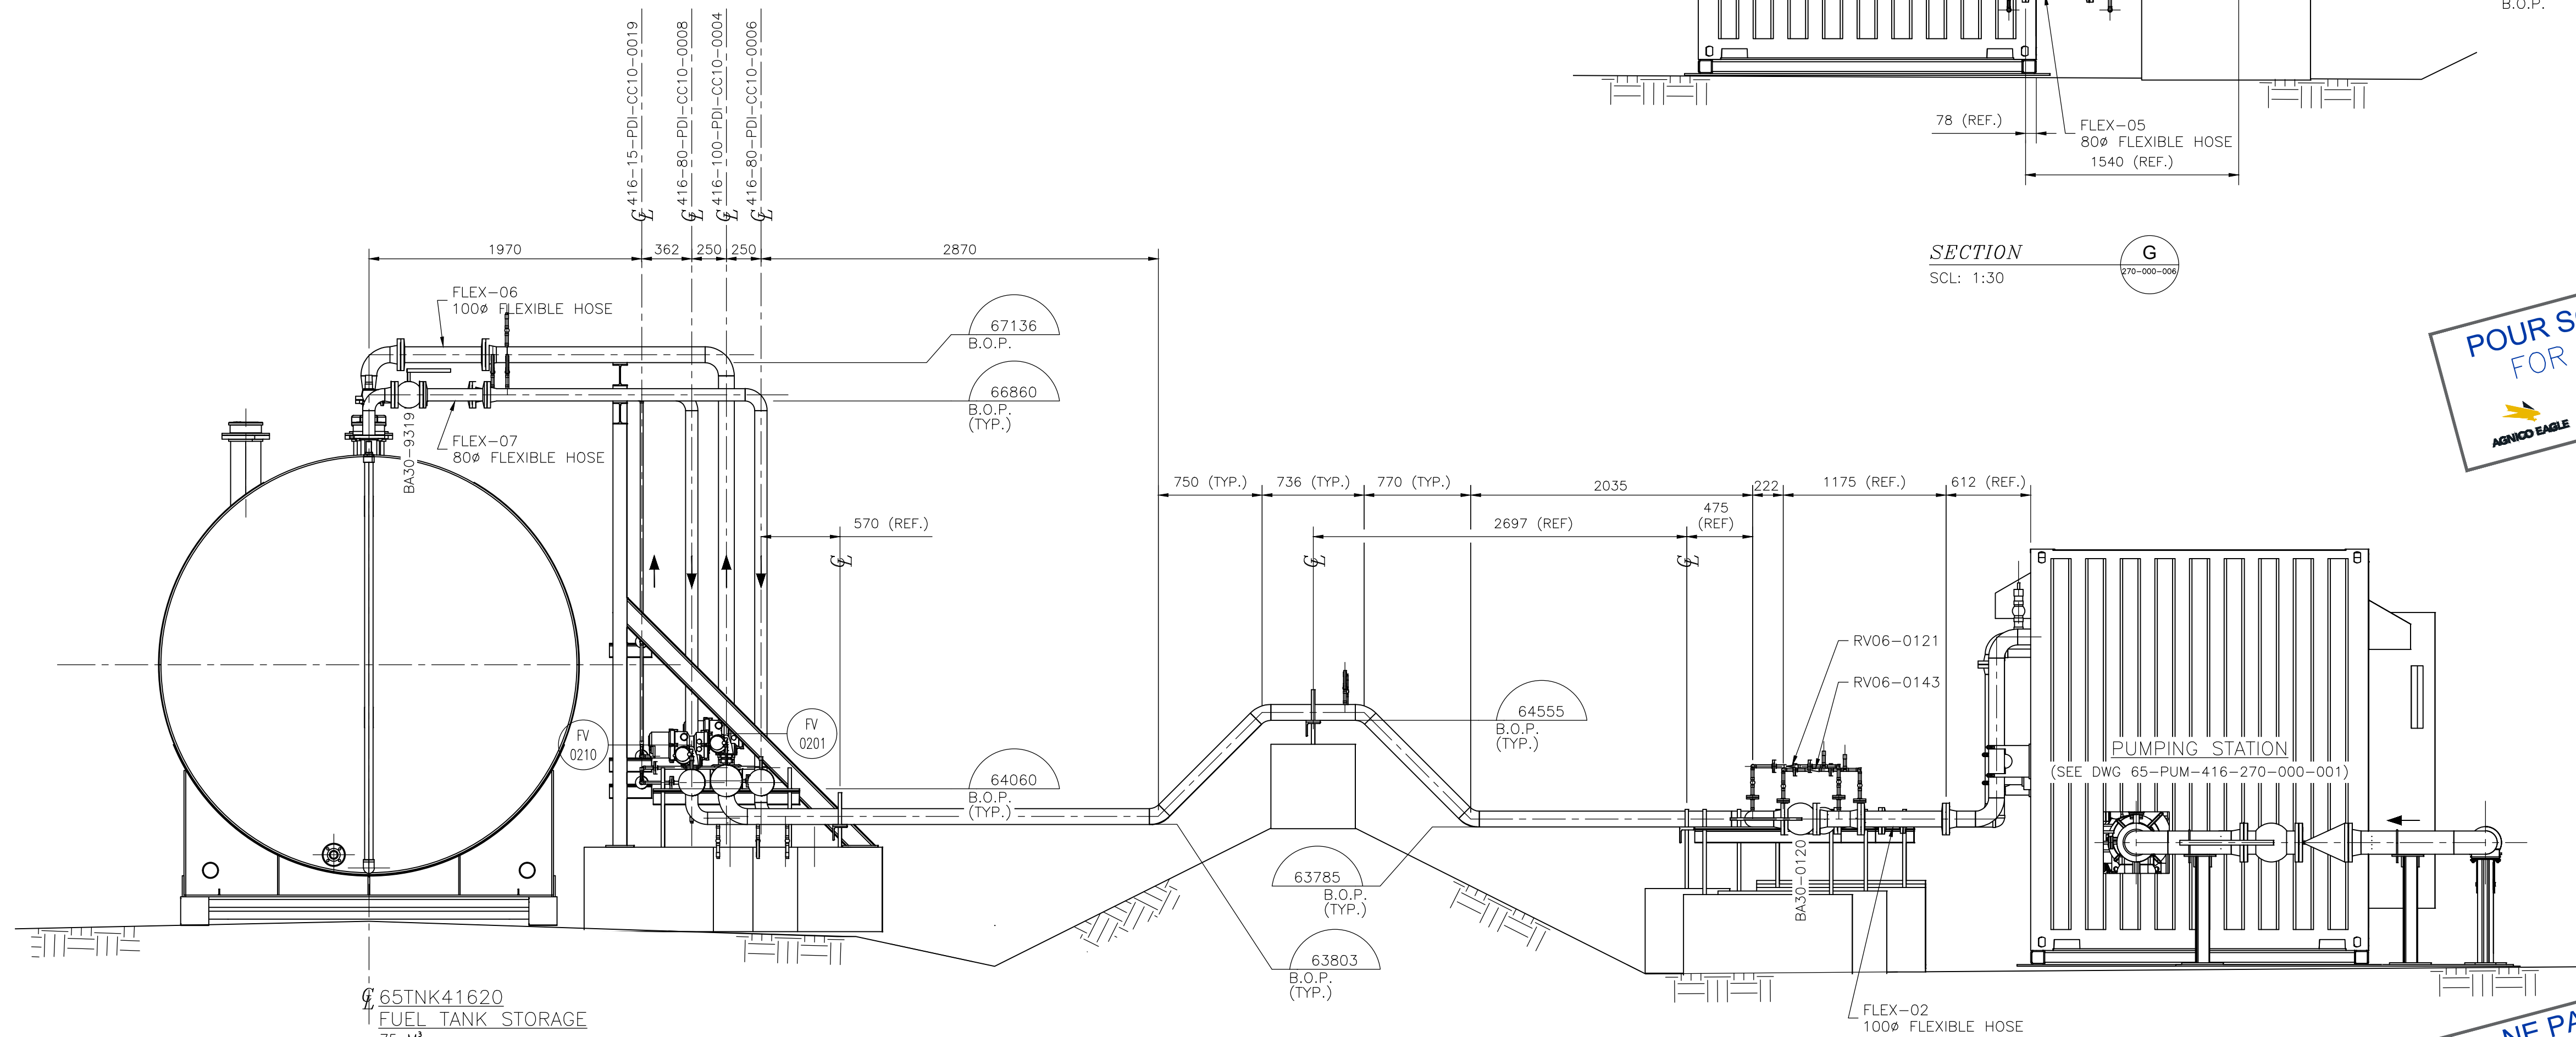

SECTION

 SCL: 1:30



NE PAS UTILISER
POUR CONSTRUCTION

2025-06-13

PLAN CLÉ
KEY PLAN



1075, 3e Av E
Val-d'Or, Québec, J9P 0J7
T 819 825-4711 | www.wsp.com

PROJET : CA0049485.7297

NOTES GÉNÉRALES / GENERAL NOTES

1. PIPING AS PER CSA B139 AND 31.3 (CURRENT EDITIONS).
2. ASME B31.3 FLUID SERVICE CATEGORY : NORMAL FLUID SERVICE.
3. ALL DIMENSIONS IN MILLIMETERS (mm) UNLES NOTED OTHERWISE.
4. CONTRACTOR TO FIELD VERIFY ALL DIMENSIONS PRIOR TO FABRICATION AND INSTALLATION.
5. PIPING AND EQUIPMENT MUST BE GROUNDED.
6. U-BOLTS TO BE 3MM OVERSIZE TO ALLOW FREE EXPANSION OF THE PIPING.

THE INFORMATION HERE ON IS THE PROPERTY OF AMCOG EAGLE LTD. AND MUST BE RETURNED UPON REQUEST. WITHOUT WRITTEN PERMISSION, ANY COPYING, TRANSMITTAL TO OTHERS AND ANY USE (EXCEPT THAT FOR WHICH IT IS LOANED) ARE PROHIBITED.
© AMCOG EAGLE LTD.

DESSINS EN RÉFÉRENCE / REFERENCE DRAWINGS

TITRE / TITLE	# DWG
P&ID - FUEL PUMPING - PART 2	65-PUM-416-205-000-002
GENERAL ARRANGEMENT - PLAN VIEW	65-PUM-416-270-000-006
---	---
---	---
---	---

**AGNICO EAGLE**

0	2025-06-13	ISSUED FOR TENDER	JR	MD		AF	
REV.	DATE	DESCRIPTION	PAR/BY	VER.	CLIENT		

REVISIONS

--	--

TITLE / TITLE
AGNICO EAGLE - MELIADINE
416 - FUEL TANK FARM
270 - PIPING
GENERAL ARRANGEMENT
SECTION VIEWS (PART 2)

DESSINÉ PAR DRAWN BY	JOCELYN RICHER	DATE 2025-06-13
REVU PAR REVIEWED BY	BRUNO RUETTE, P.Eng.	2025-06-13
VÉRIFIÉ PAR VERIFIED BY	MARC DESCHAMPS, P.Eng.	2025-06-13

NO. DESSIN DRAWING NO.	65-PUM-416-270-000-010
---------------------------	------------------------

NO. PROJ PROJECT NO.	REVISION	FEUILLE / SHT
6542	0	1 / 1