


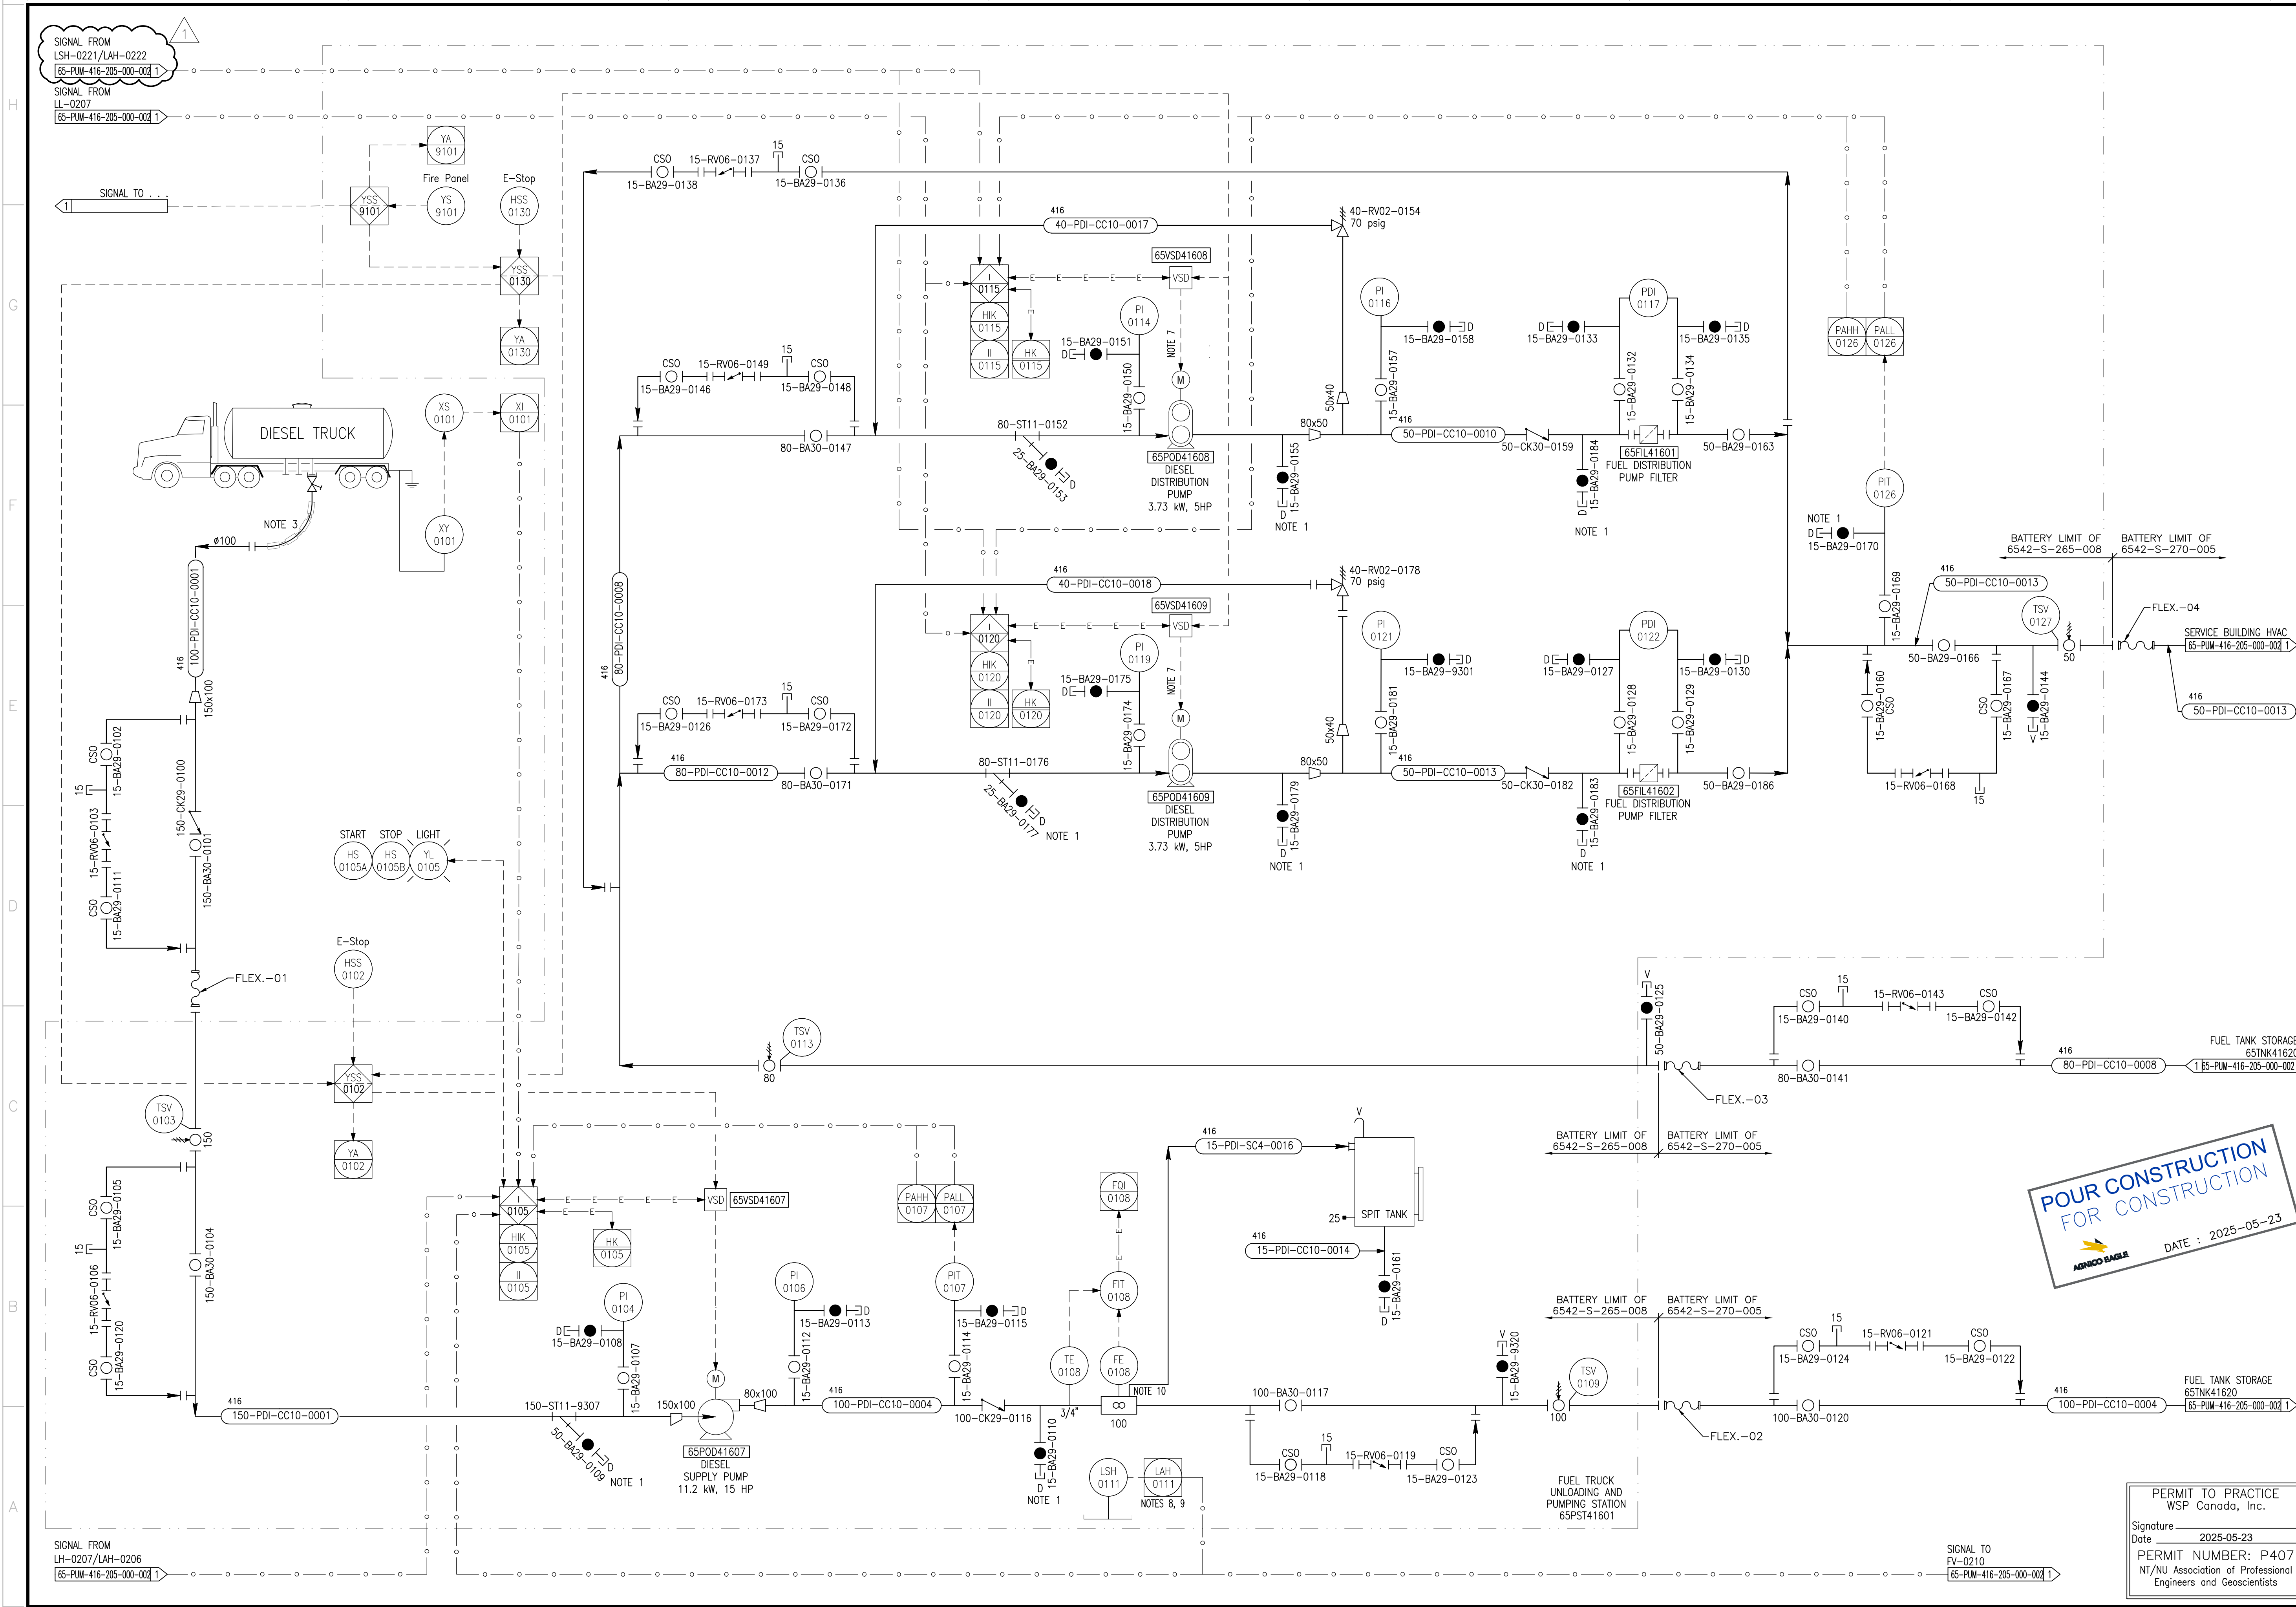

PLAN CLE
KEY PLAN



1075, 3e Av. E.
Viel-Or, Québec, QP Q1T
T 819 825-4711 | www.wsp.com

PROJET : CA0049485.7297

NOTES GÉNÉRALES / GENERAL NOTES

1. DRAIN TO AN APPROPRIATE BUCKET.
2. REMOVED.
3. FLEXLITE HOSE
4. LOW POINT DRAINS AND HIGH POINT VENTS TO BE ADDED WHERE APPLICABLE.
5. VALVES CONNECTED FLANGE TO FLANGE WITH NO PIPE IN BETWEEN.
6. ALL TSV (FUSIBLE-LINK TEMPERATURE VALVE) CLUTCHES SHOULD BE LOCKED IN THE DISENGAGED POSITION.
7. VFD WILL OPERATE UNDER AN ON/OFF MODE.
8. BUILT-IN CONTAINER FOR THE PUMPHOUSE CONTAINER.
9. LEVEL SWITCH FOR CONTAINER CONTAINMENT.
10. AIR RELEASE CONNECTIONS ON EQUIPMENT TO BE FITTED ON SITE.
11. REMOVED.
12. THE SOLENOID ANTI-SIPHON NEEDS TO HAVE A BUILT-IN PRESSURE RELIEF.
13. MECHANICAL ANTI-SIPHON WITH AN HYDROSTATIC HEAD PRESSURE OF 0-10" DIFFERENCE IN ELEVATION BETWEEN TOP OF STORAGE TANK AND DIESEL DISTRIBUTION PUMP SUCTION NOT TO EXCEED 10 FT.

L'INFORMATION CI-DESSUS EST LA PROPRIÉTÉ DE AGNICO EAGLE LTD. ET DOIT ÊTRE RETENUE PAR VOUS. SANS AUTORISATION ÉCRITE, VOUS NE DEVEZ PAS RÉPÉTER, COPIER, RÉPRODUIRE, NI COMMUNIQUER À TROISIÈME PARTIE, NI UTILISER À D'autres fins que celles pour lesquelles elle a été fournie. AGNICO EAGLE LTD. ASSUME AUCUNE RESPONSABILITÉ POUR L'UTILISATION DE L'INFORMATION CI-DESSUS.

ALL INFORMATION HEREIN IS THE PROPERTY OF AGNICO EAGLE LTD. AND MUST BE RETURNED UPON REQUEST. WITHOUT WRITTEN PERMISSION, YOU MAY NOT REPRODUCE, COPY, REPRODUCE, OR COMMUNICATE TO A THIRD PARTY, OR USE FOR ANY OTHER PURPOSE THAN THAT FOR WHICH IT IS PROVIDED. AGNICO EAGLE LTD. ASSUMES NO LIABILITY FOR THE USE OF THE INFORMATION CI-DESSUS.

DESSEINS EN RÉFÉRENCE / REFERENCE DRAWINGS

TITRE / TITLE	# DWG
---	---
---	---
---	---
---	---
---	---
---	---



AGNICO EAGLE

FUEL TANK STORAGE
65TNK41620
1 65-PUM-416-205-000-002

REV.	DATE	DESCRIPTION	PAR/EN	VER.	CLIENT
1	2025-05-23	ISSUED FOR CONSTRUCTION	B.R.	C.P.	A.F.
0	2025-05-02	ISSUED FOR CONSTRUCTION	C.V.	B.R.	A.F.
0	2025-04-16	ISSUED FOR REVIEW	S.G.	M.D.	A.F.
0	2025-03-31	ISSUED FOR REVIEW	S.G.	M.D.	A.F.

REVISIONS

TITRE / TITLE
AGNICO EAGLE - MELIADINE
416-FUEL TANK FARM-PUMP PORTAL FUEL DISTRIBUTION
205 - PIPING & INSTRUMENTATION DIAGRAM
P&ID - FUEL PUMPING STATION & DISTRIBUTION
P&ID

DESSINÉ PAR DRAWN BY	C. VILLON	DATE 2025-05-02
REVU PAR REVIEWED BY	M. DESCHAMPS, P. Eng.	2025-05-02
VÉRIFIÉ PAR VERIFIED BY	B. RUETTE, Eng.	2025-05-02

ÉCHELLE
SCALE N.T.S. DATE 2025-05-23

NO. DESSIN
DRAWING NO. 65-PUM-416-205-000-001

NO. PROJET PROJECT NO.	REVISION	FEUILLE / SHEET
6542	1	1 / 1

PERMIT TO PRACTICE
WSP Canada, Inc.
Signature
Date 2025-05-23
PERMIT NUMBER: P407
NT/NU Association of Professional
Engineers and Geoscientists