


7000-05-030-0007
DWG. NO.

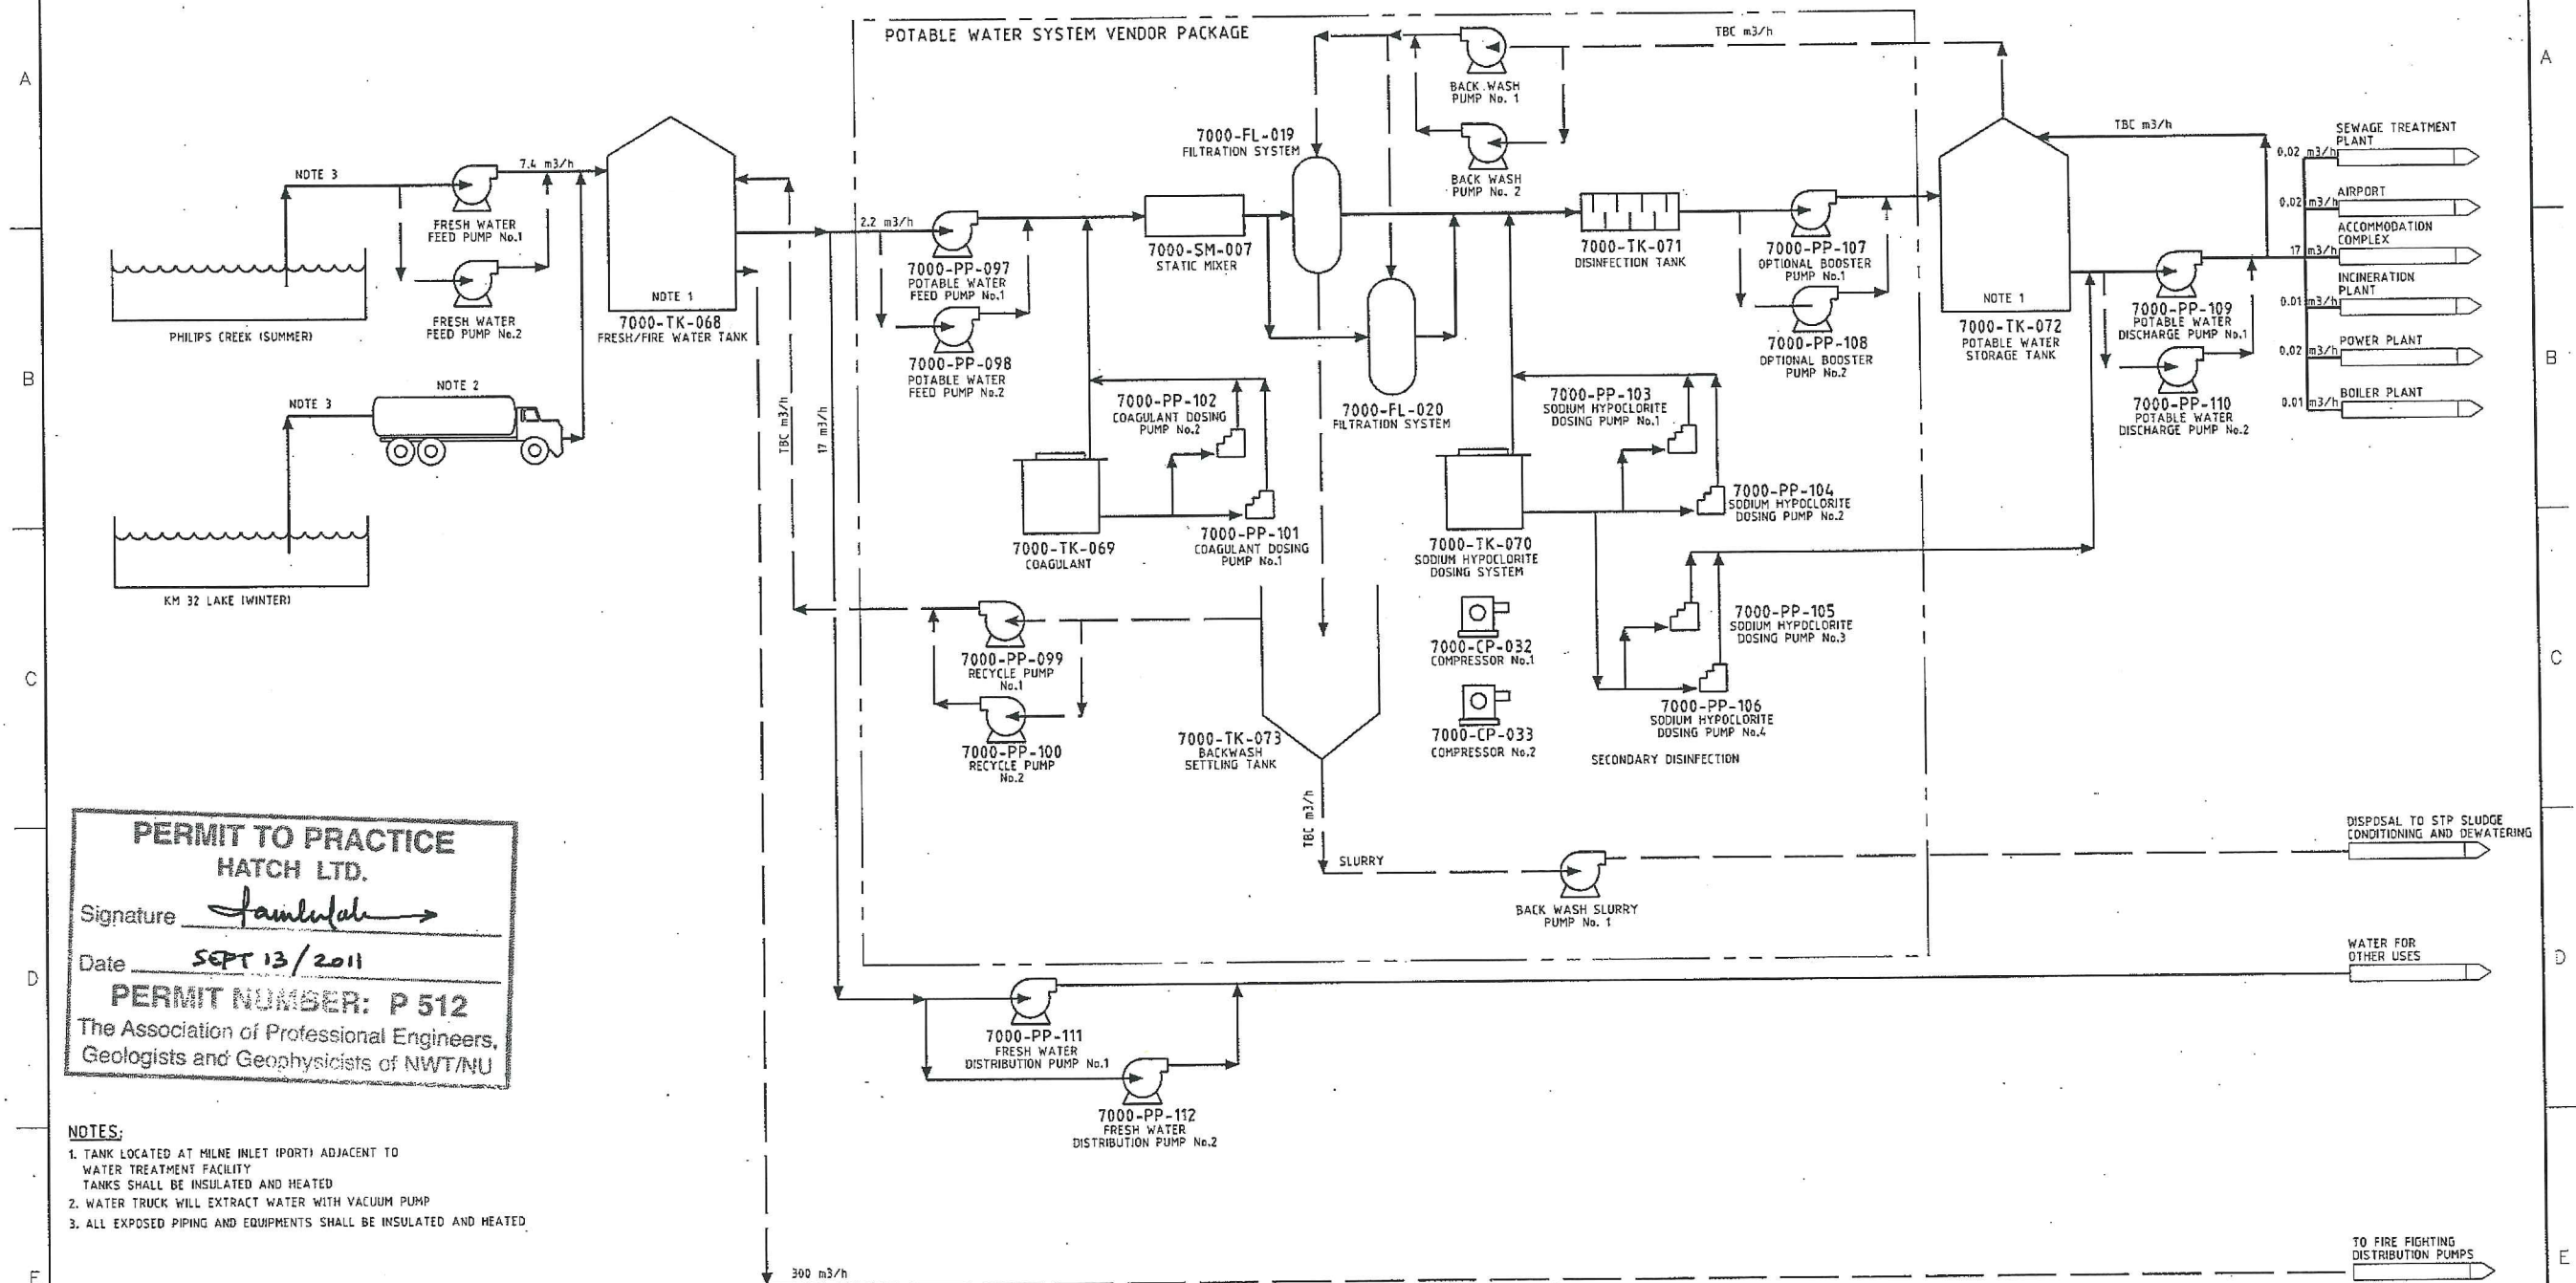


PERMIT TO PRACTICE
HATCH LTD.
Signature *[Signature]*
Date **SEPT 13/2011**
PERMIT NUMBER: P 512
The Association of Professional Engineers,
Geologists and Geophysicists of NWT/NU

- NOTES:**
1. TANK LOCATED AT MILNE INLET (PORT) ADJACENT TO WATER TREATMENT FACILITY
TANKS SHALL BE INSULATED AND HEATED
 2. WATER TRUCK WILL EXTRACT WATER WITH VACUUM PUMP
 3. ALL EXPOSED PIPING AND EQUIPMENTS SHALL BE INSULATED AND HEATED

LEGEND:

- PRIMARY FLOW
- SECONDARY FLOW
- INTERMITTENT OR ALTERNATE FLOW
- MATERIAL FLOW
- VENDOR PACKAGE LIMIT

DRAWING NO.	DRAWING TITLE
REFERENCE DRAWINGS	
1	
2	
3	
4	
5	
6	
7	
8	

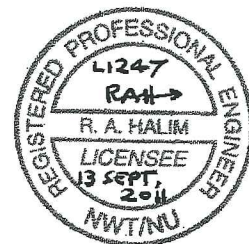

NO.	DESCRIPTION	BY	CHK'D	APP'D	DATE
B	CHANGES FROM INTERNAL REVIEW	RR	RK	AZ	9/6/2011
A	INTERNAL REVIEW	JF	RK	AZ	8/24/2011

REV.	ISSUE FOR	DATE	AUTH. BY	DATE
B	ENVIRONMENTAL PERMIT	9/6/2011	RK	AZ
A	INTERNAL REVIEW	8/24/2011	RK	AZ

DESIGNED BY	DRAWN BY
R. KAPADIA	J. FESAR
DATE 2011-08-03	DATE 2011-08-03
CHECKED BY	DISCIP. ENGR.
R. KAPADIA	AZLATIC
DATE 2011-08-24	DATE 2011-08-03
PROJ. DES. COORD.	PROJ. ENGR.
	J. CASSON

HATCH		Baffinland	
PROCESS FLOW DIAGRAM			
MILNE INLET (PORT) POTABLE WATER SYSTEM			
SCALE	DWG. NO.	REV.	
OR AS NOTED	H337697-7000-05-030-0007	B	