


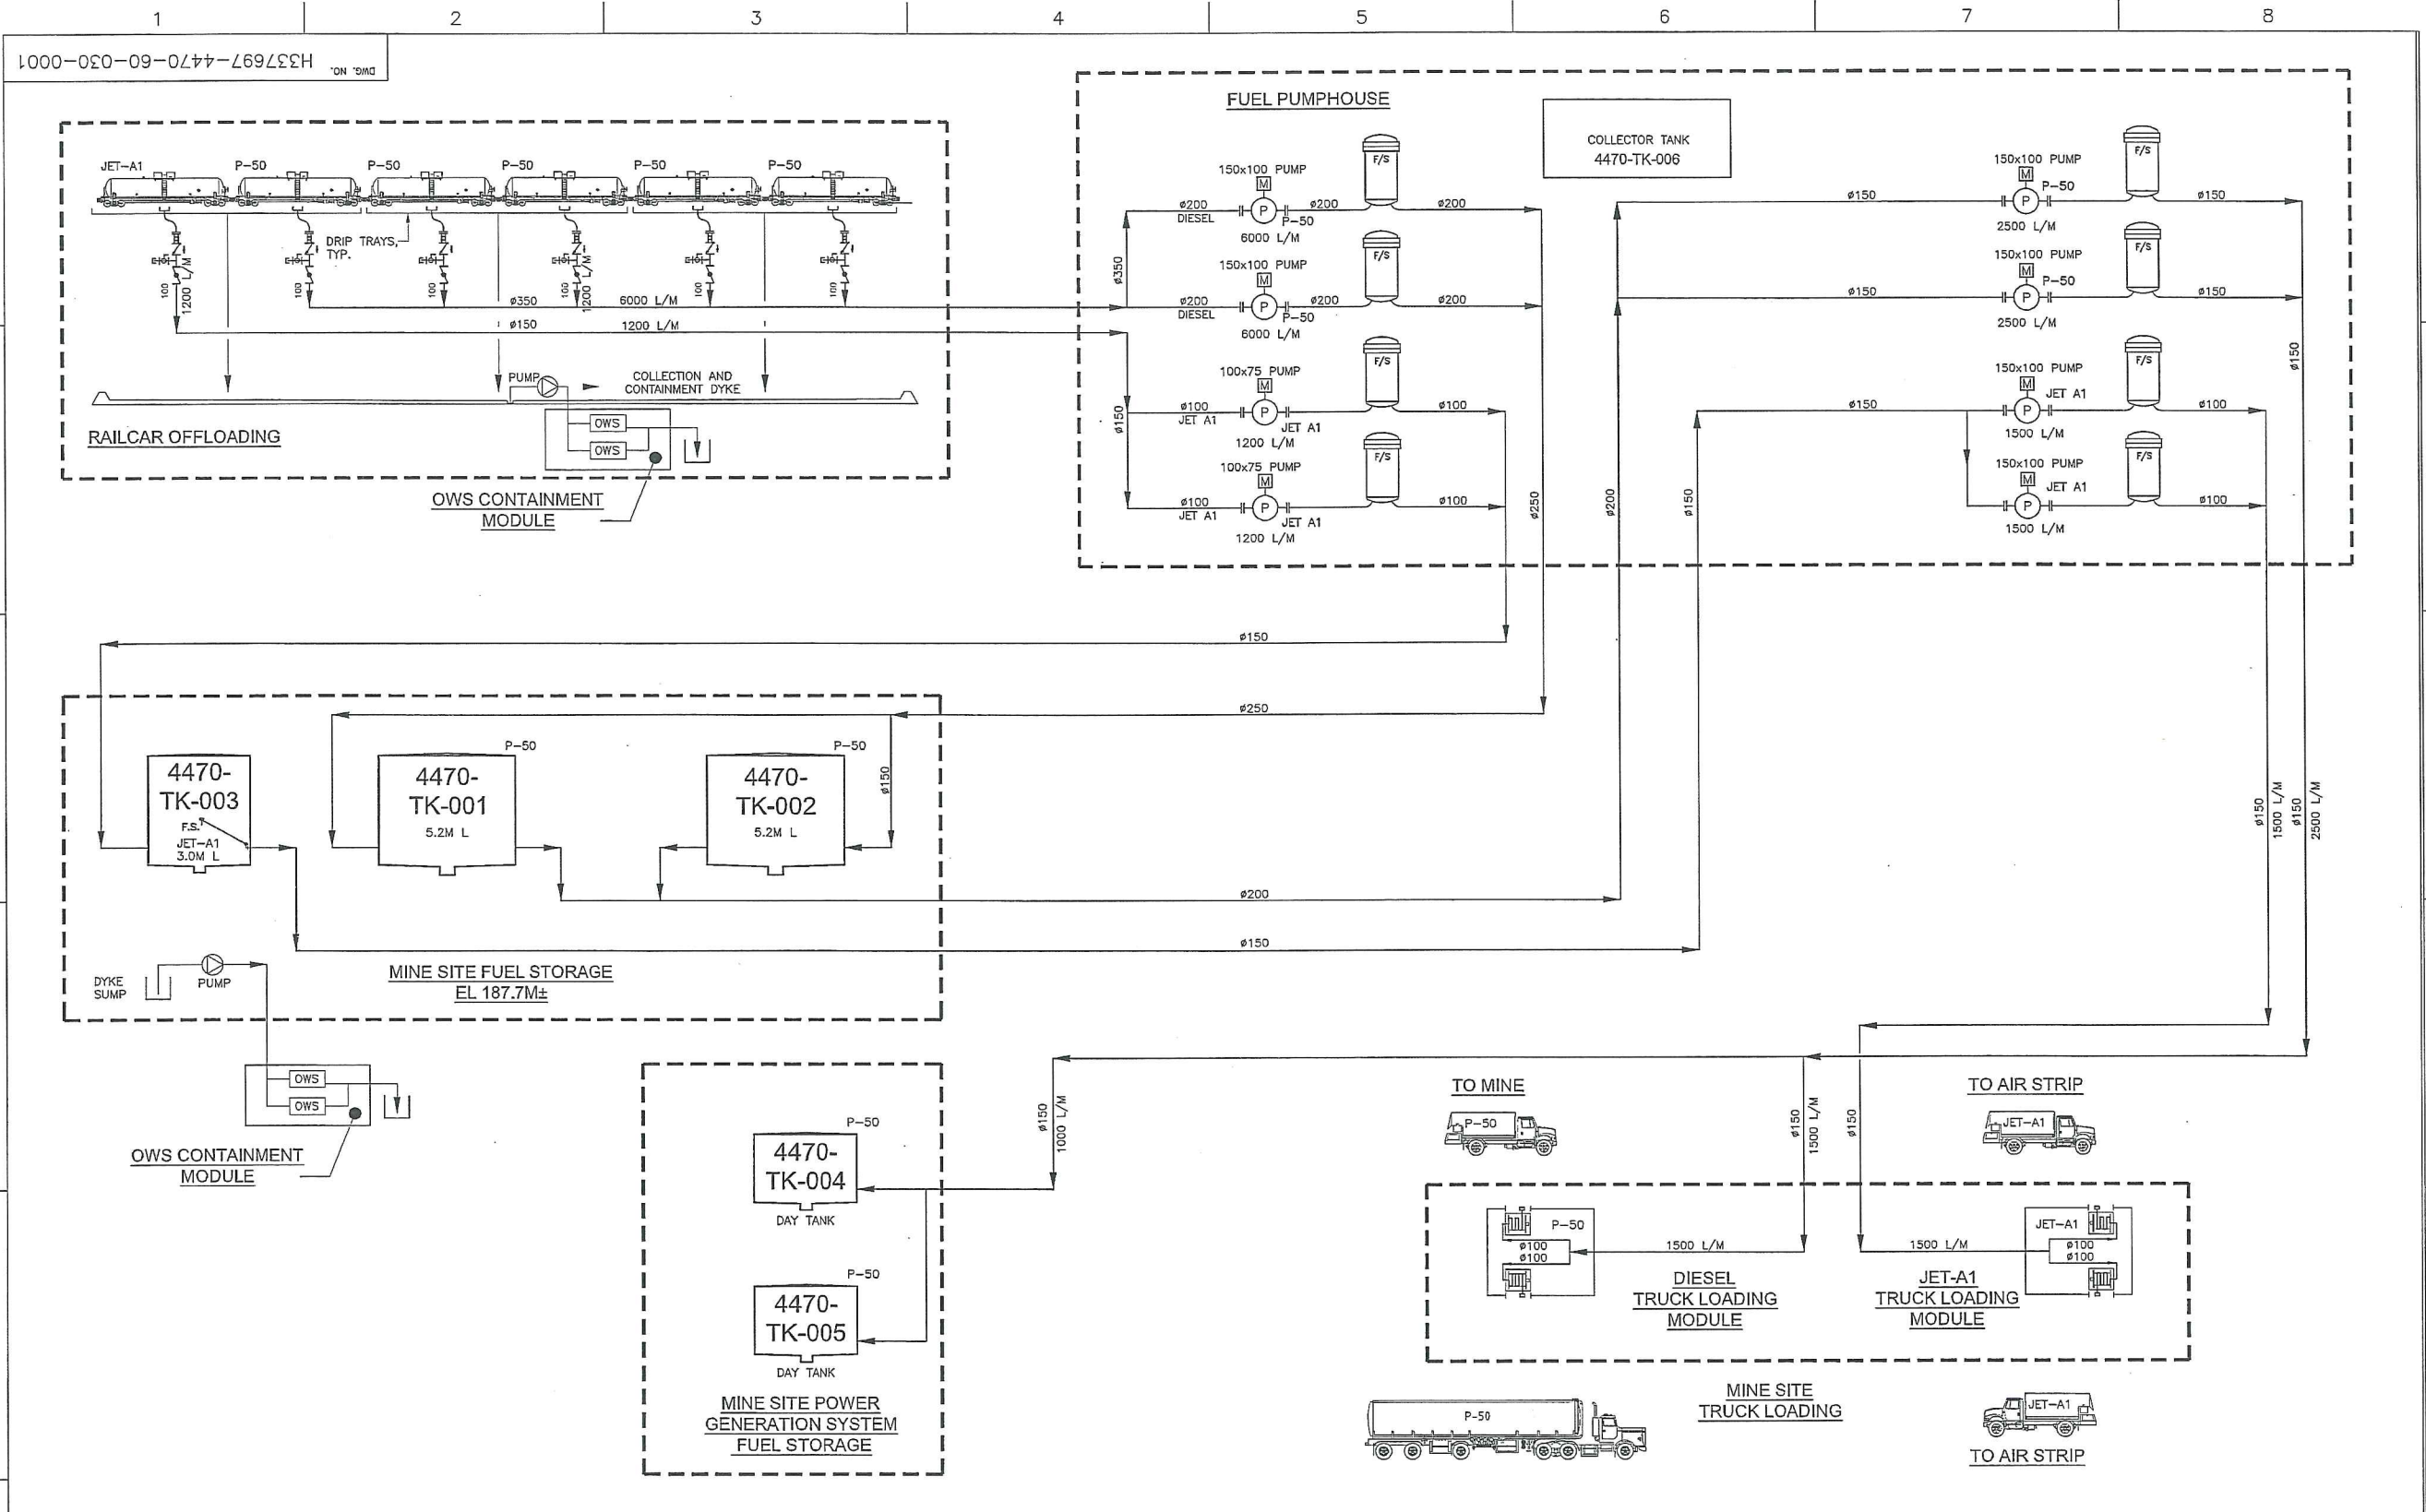

DWG. NO. H337697-4470-60-030-0001		REGISTERED PROFESSIONAL ENGINEER J.W. CASSON LICENSEE Sept 30/11 NTNU		HATCH™		Baffinland	
DESIGNED BY JM DATE 11-08-02		CHECKED BY FGK DATE 11-09-23		DRAWN BY EB DATE 11-08-02		MARY RIVER PROJECT	
PROJ. DES. COORD. F. BUTTS DATE 11-09-23		PROJ. ENGR. F. BUTTS DATE 11-09-23		DATE 11-09-23		MINE SITE FUEL OFFLOAD, STORAGE & DISTRIBUTION PROCESS FLOW DIAGRAM	
ISSUED FOR ENVIRONMENTAL PERMIT		DATE 11-09-23		DATE 11-09-23		SCALE N.T.S. OR AS NOTED	
ISSUE FOR		DATE 11-09-23		DATE 11-09-23		DWG. NO. H337697-4470-60-030-0001	
ISSUE AUTHORIZATION		DATE 11-09-23		DATE 11-09-23		REV. A	
REFERENCE DRAWINGS		REVISIONS		DATE 11-09-23		DATE 11-09-23	