


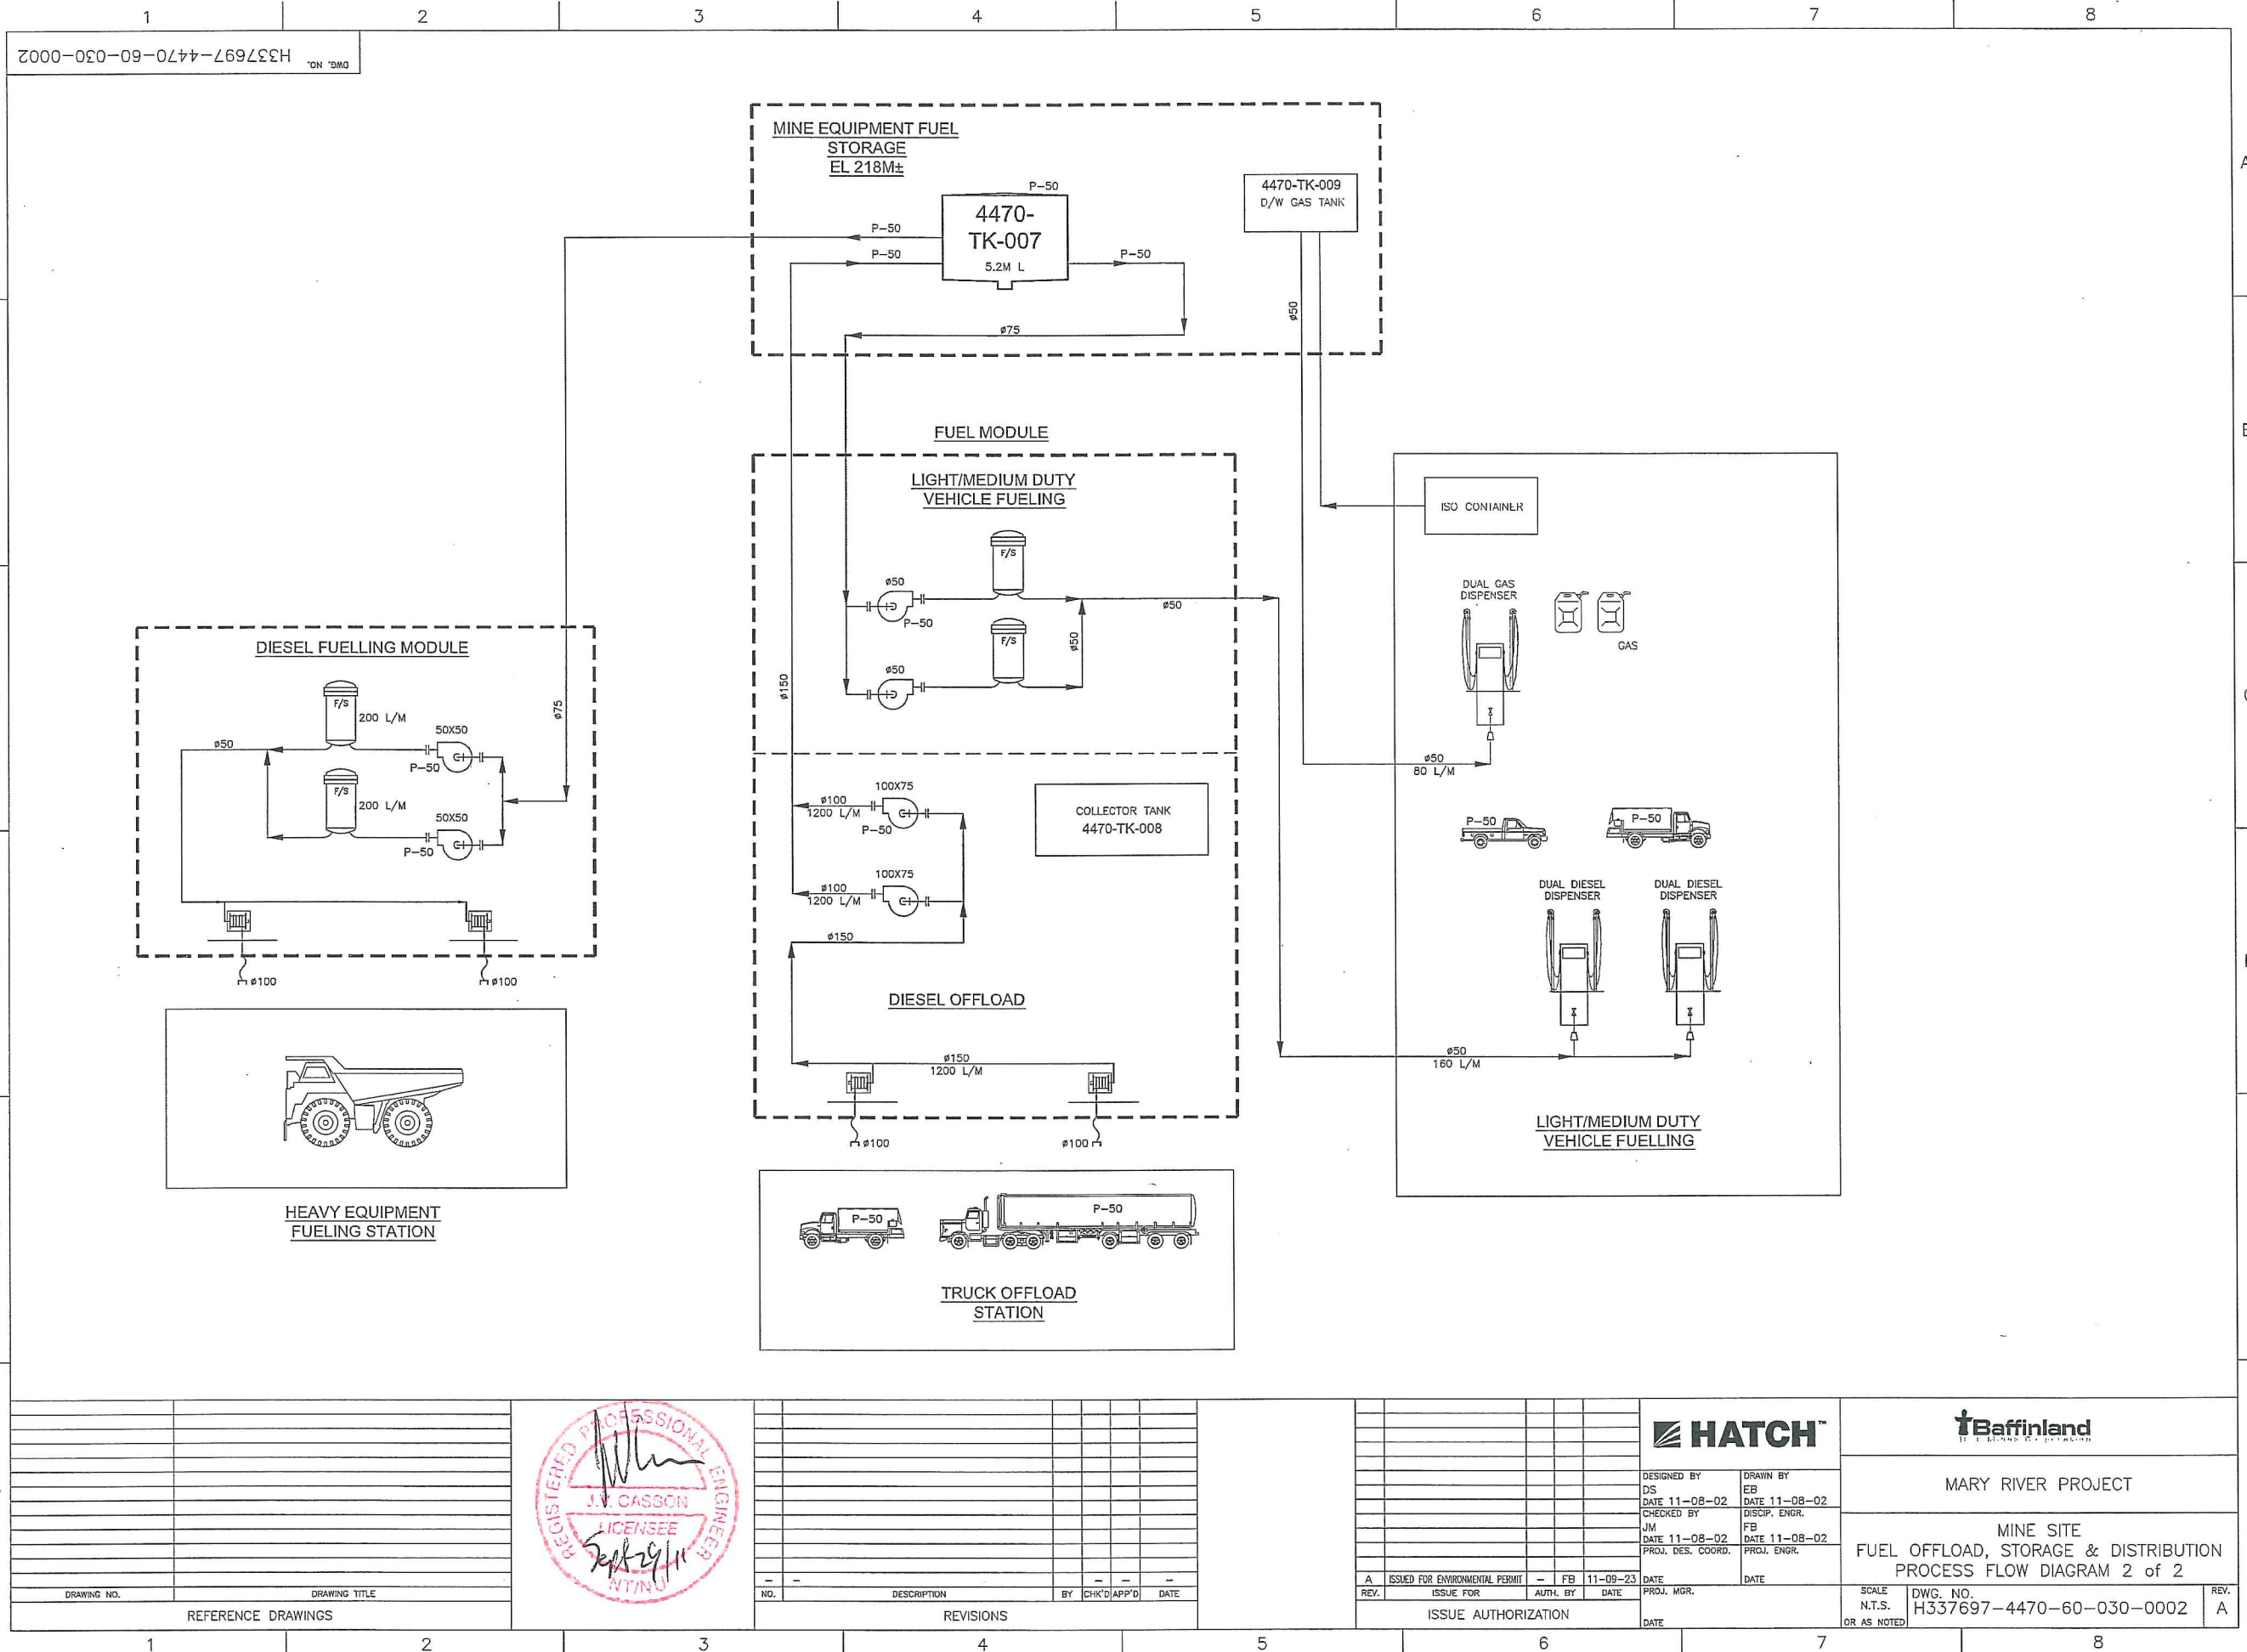

DRAWING NO.	DRAWING TITLE
1	REFERENCE DRAWINGS



NO.	DESCRIPTION	BY	CHK'D	APP'D	DATE
1	REVISIONS				

REV.	ISSUE FOR	AUTH. BY	DATE
A	ISSUED FOR ENVIRONMENTAL PERMIT	FB	11-09-23

DESIGNED BY	DRAWN BY
DS	EB
DATE 11-08-02	DATE 11-08-02
CHECKED BY	DISCIP. ENGR.
JM	FB
DATE 11-08-02	DATE 11-08-02
PROJ. DES. COORD.	PROJ. ENGR.

MARY RIVER PROJECT

MINE SITE
FUEL OFFLOAD, STORAGE & DISTRIBUTION
PROCESS FLOW DIAGRAM 2 of 2

SCALE
N.T.S.
OR AS NOTED

DWG. NO.
H337697-4470-60-030-0002

REV.
A