


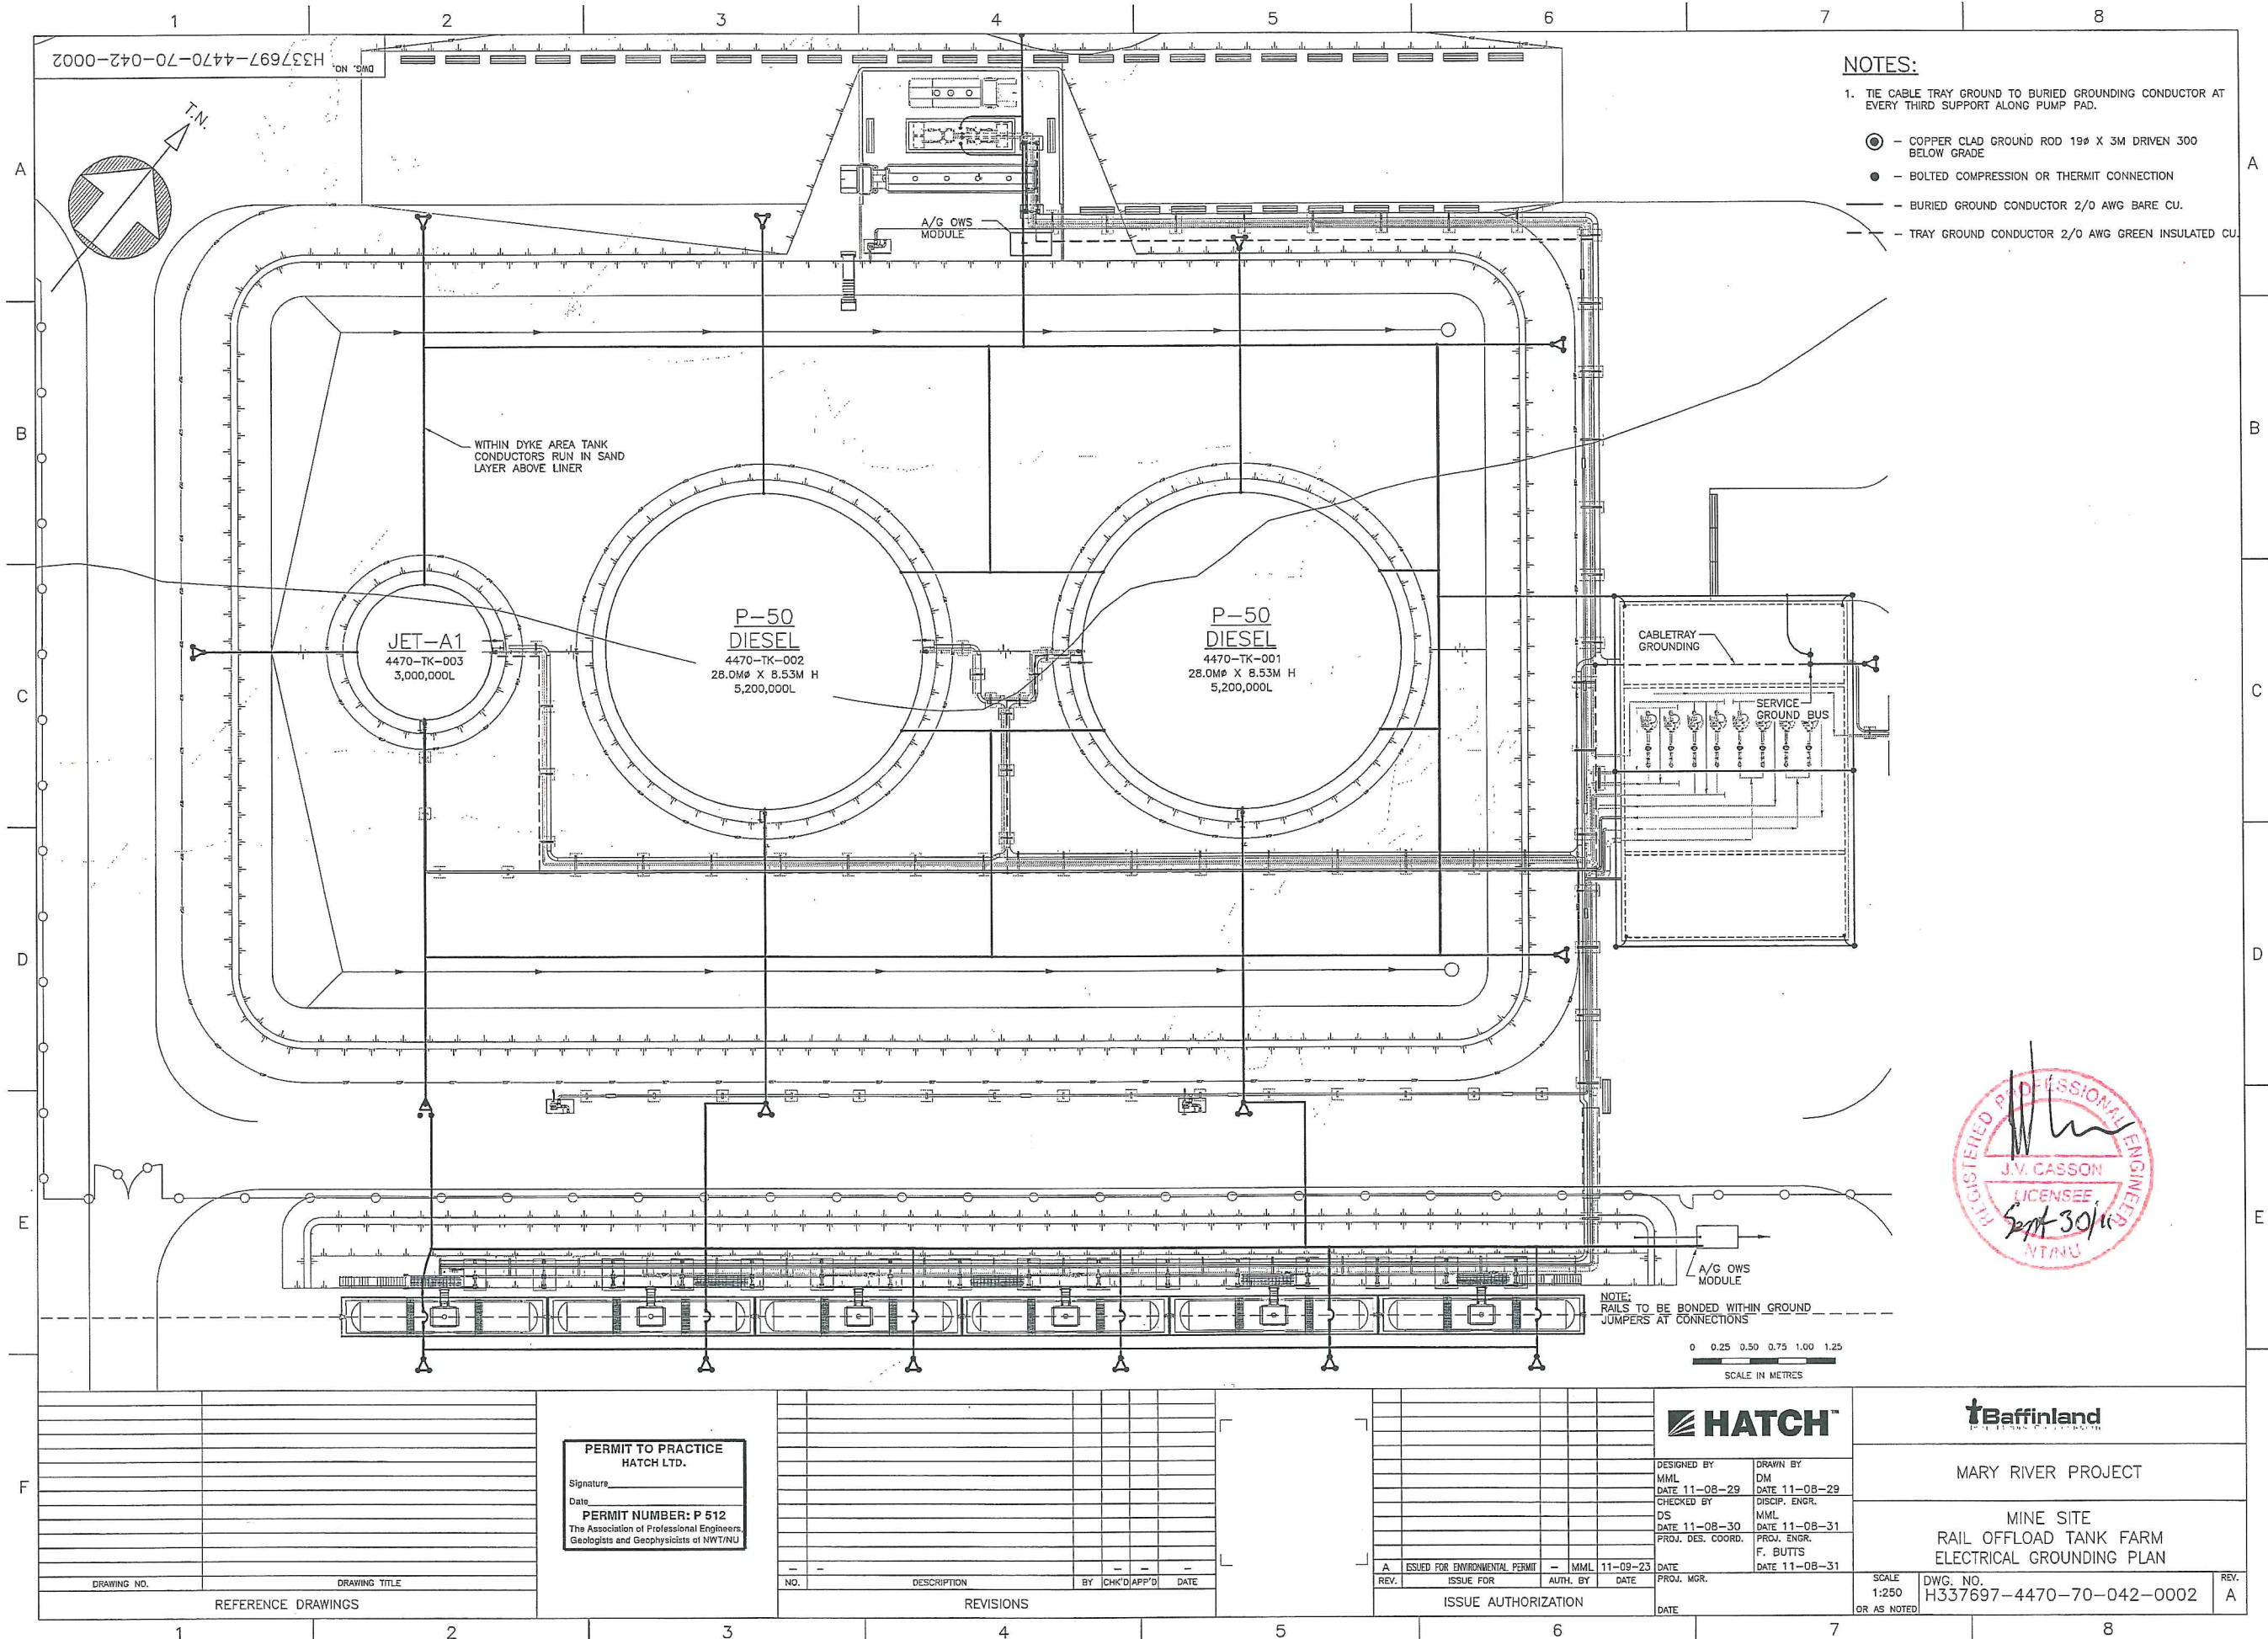

- NOTES:**
1. TIE CABLE TRAY GROUND TO BURIED GROUNDING CONDUCTOR AT EVERY THIRD SUPPORT ALONG PUMP PAD.
- - COPPER CLAD GROUND ROD 19# X 3M DRIVEN 300 BELOW GRADE
 - - BOLTED COMPRESSION OR THERMIT CONNECTION
 - - BURIED GROUND CONDUCTOR 2/0 AWG BARE CU.
 - - TRAY GROUND CONDUCTOR 2/0 AWG GREEN INSULATED CU.



REFERENCE DRAWINGS	
DRAWING NO.	DRAWING TITLE
1	
2	
3	
4	
5	
6	
7	
8	

**PERMIT TO PRACTICE
HATCH LTD.**

Signature _____
Date _____

PERMIT NUMBER: P 512
The Association of Professional Engineers,
Geologists and Geophysicists of NWT/NU

REVISIONS			
NO.	DESCRIPTION	BY	CHK'D APP'D DATE

ISSUE AUTHORIZATION			
REV.	ISSUE FOR	AUTH. BY	DATE

HATCH	
DESIGNED BY MML DATE 11-08-29	DRAWN BY DM DATE 11-08-29
CHECKED BY DS DATE 11-08-30	DISCIP. ENGR. MML DATE 11-08-31
PROJ. DES. COORD. F. BUTTS DATE 11-08-31	PROJ. ENGR. F. BUTTS DATE 11-08-31

Baffinland	
MARY RIVER PROJECT	
MINE SITE RAIL OFFLOAD TANK FARM ELECTRICAL GROUNDING PLAN	
SCALE 1:250 OR AS NOTED	DWG. NO. H337697-4470-70-042-0002
	REV. A