


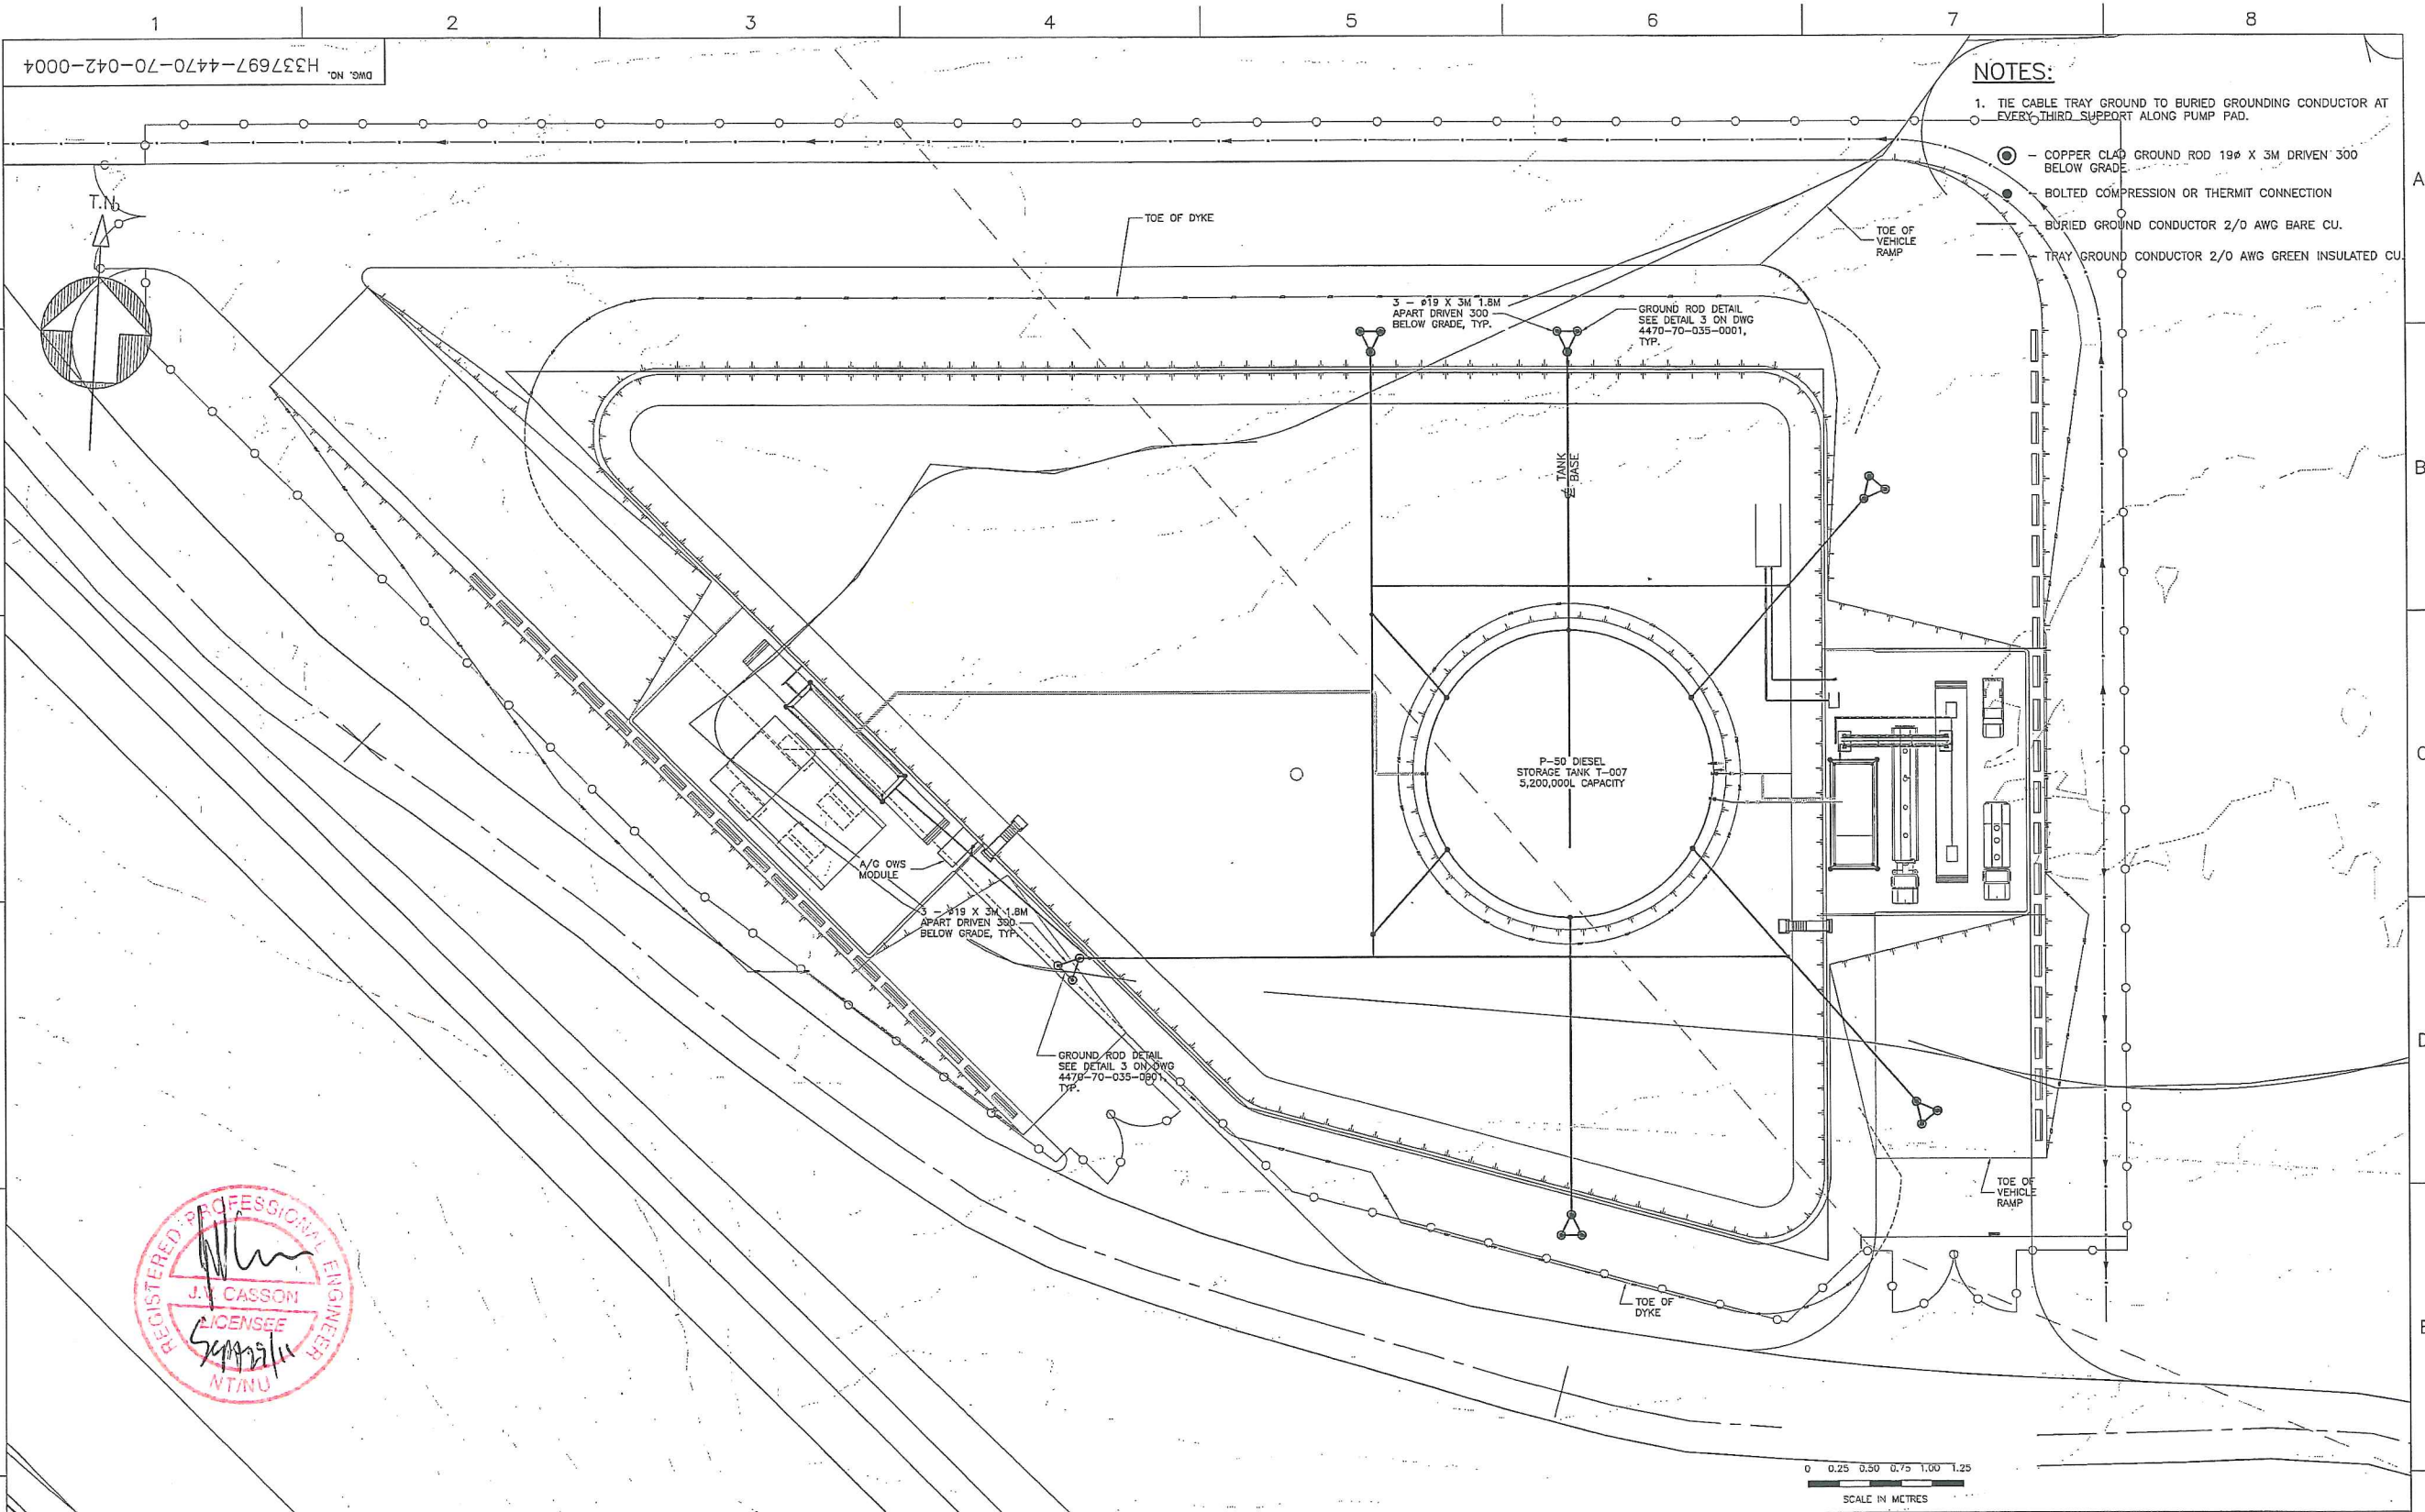

- NOTES:**
1. TIE CABLE TRAY GROUND TO BURIED GROUNDING CONDUCTOR AT EVERY THIRD SUPPORT ALONG PUMP PAD.
- - COPPER CLAD GROUND ROD 19# X 3M DRIVEN 300 BELOW GRADE
 - - BOLTED COMPRESSION OR THERMIT CONNECTION
 - BURIED GROUND CONDUCTOR 2/0 AWG BARE CU.
 - TRAY GROUND CONDUCTOR 2/0 AWG GREEN INSULATED CU.



PERMIT TO PRACTICE HATCH LTD. Signature _____ Date _____ PERMIT NUMBER: P 512 The Association of Professional Engineers, Geologists and Geophysicists of NWT/NU		REVISIONS NO. DESCRIPTION BY CHK'D APP'D DATE		ISSUE AUTHORIZATION A ISSUED FOR ENVIRONMENTAL PERMIT - FB 11-09-23 REV. ISSUE FOR. AUTH. BY DATE		HATCH DESIGNED BY MML DATE 11-08-29 CHECKED BY DS DATE 11-08-30 PROJ. DES. COORD. F. BUTTS DATE 11-08-31 DRAWN BY DM DATE 11-08-29 DISCIP. ENGR. MML DATE 11-08-31 PROJ. ENGR. F. BUTTS DATE 11-08-31		Baffinland MARY RIVER PROJECT MINE SITE MINE SERVICES TANK FARM ELECTRICAL GROUNDING PLAN SCALE 1:300 OR AS NOTED DWG. NO. H337697-4470-70-042-0004 REV. A	
DRAWING NO. REFERENCE DRAWINGS		NO. DESCRIPTION BY CHK'D APP'D DATE		A ISSUED FOR ENVIRONMENTAL PERMIT - FB 11-09-23		HATCH		Baffinland	