


E337697-PM402-50-031-0011

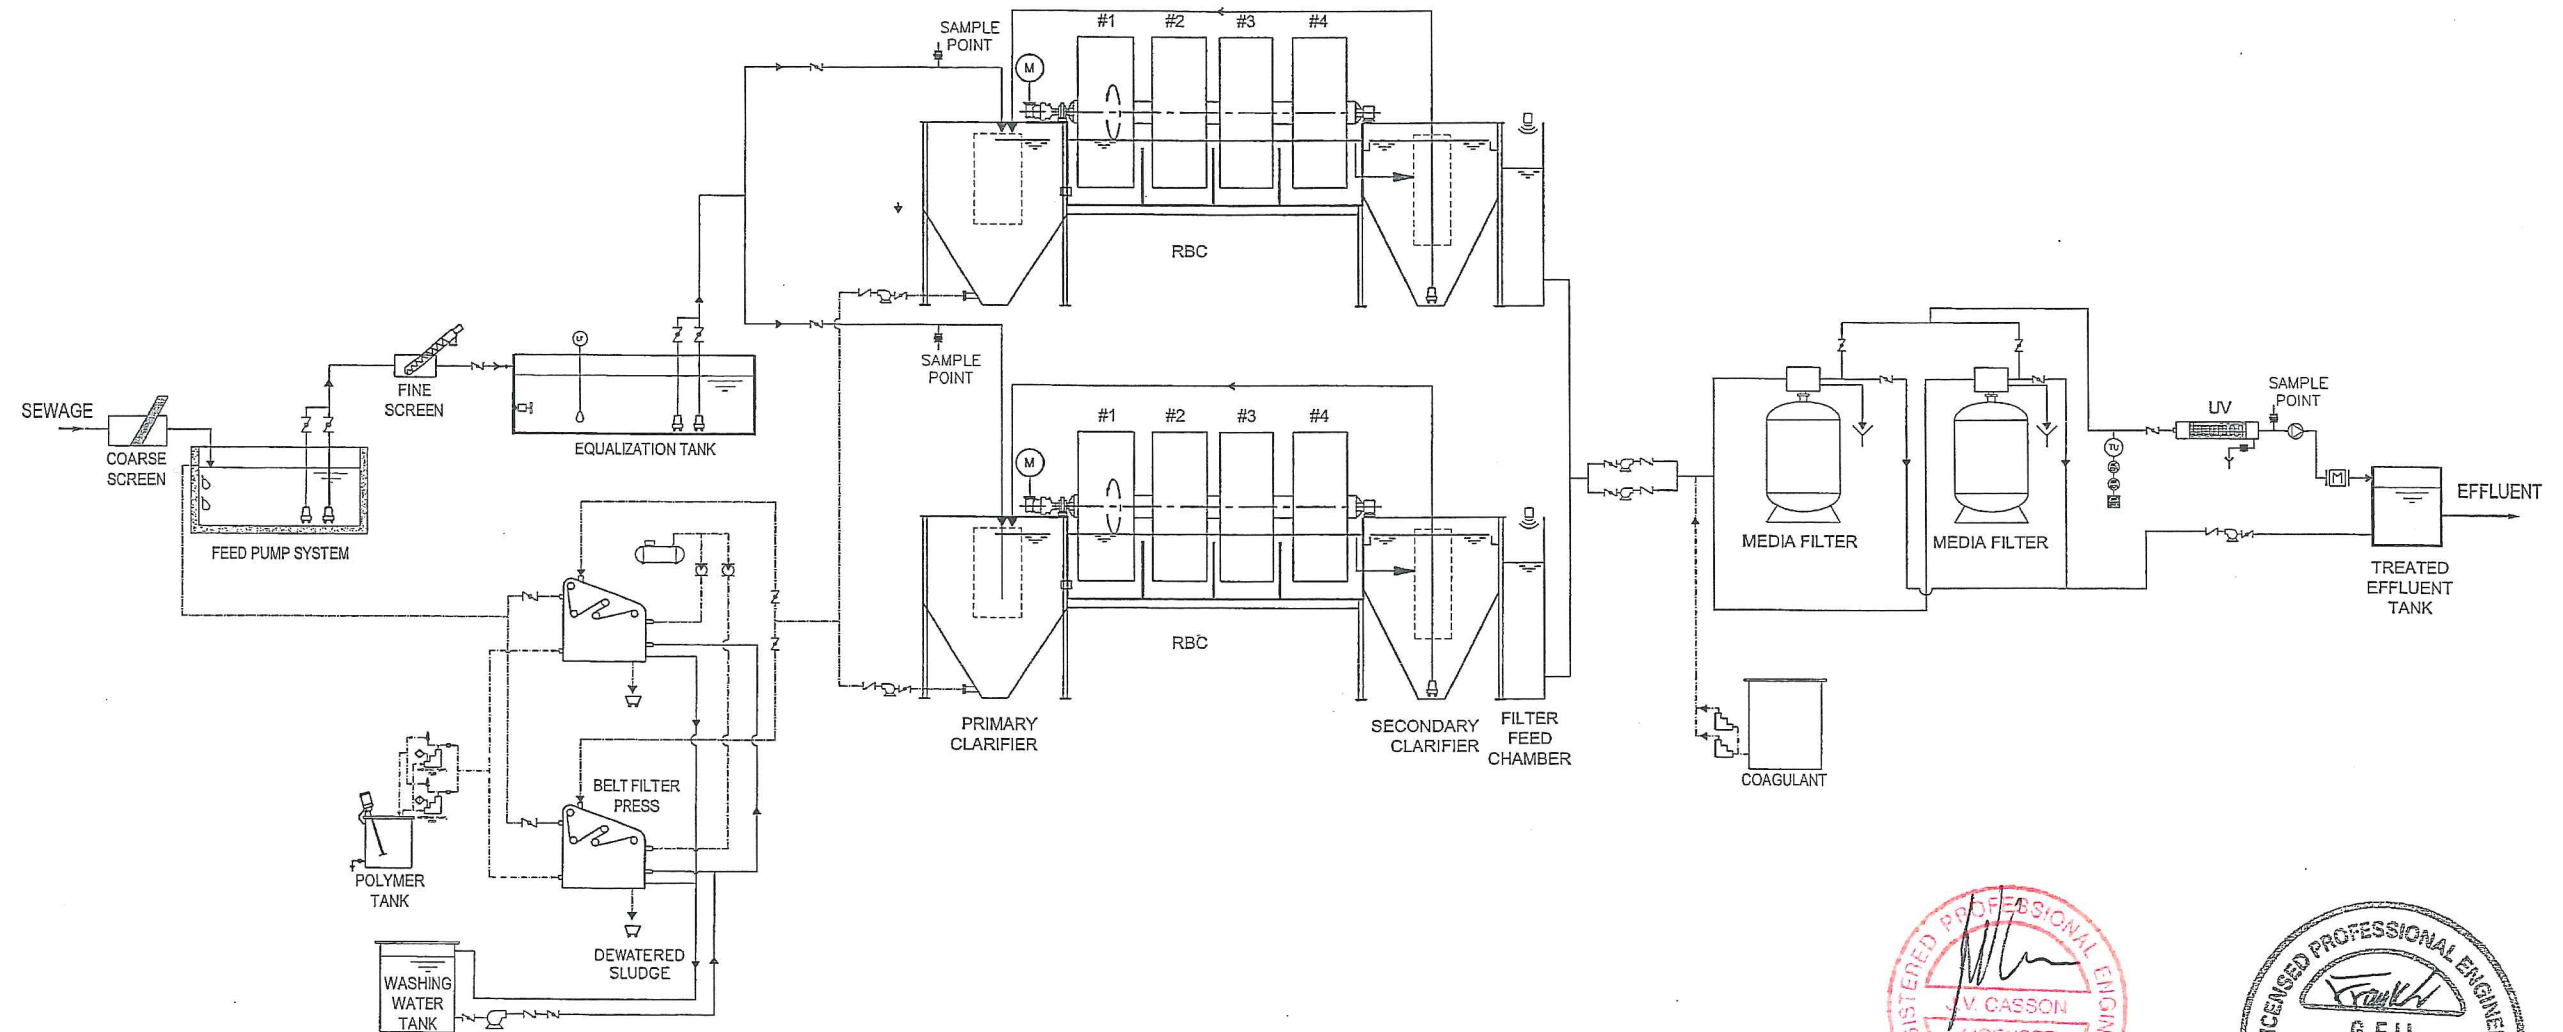

LEGEND

- | | | |
|-------------------------|-------------------|------------------------------|
| ⌵ CHECK VALVE | COMPRESSOR | Ⓜ PRESSURE LEVEL TRANSMITTER |
| ⌵ BUTTERFLY VALVE | METERING PUMP | Ⓜ pH METER |
| ⌵ PRESSURE RELIEF VALVE | FLOAT SWITCH | Ⓜ TEMPERATURE METER |
| Ⓜ MOTORIZED ACTUATOR | SUBMERSIBLE PUMP | Ⓜ ROTARY LIMIT SWITCH |
| Ⓜ MOTORIZED VALVE | PUMP | Ⓜ TURBIDITY SENSOR |
| Ⓜ BALL VALVE | BLOWER | Ⓜ MAGNETIC FLOWMETER |
| Ⓜ SUBMERSIBLE MIXER | LEVEL TRANSMITTER | |
| Ⓜ BOOSTER PUMP | | |



NOTE:

THIS DRAWING DOES NOT REPRESENT OUR SCOPE OF SUPPLY.
PLEASE REFER TO OUR QUOTE FOR THE SAME.



REVISION HISTORY		MM / DD / YYYY	DESIG	CHEC	APPR	NOTES
00	ISSUED FOR APPROVAL	09/13/2011	LL	LC	FL	
Since 1950 NAPIER-REID TORONTO CANADA DESIGN FLOW RATE 206 M3/DAY STEENBY STP (STP3) P & ID						
CUSTOMER ARCELOR MITTAL		PROJECT MARY RIVER STP		SCALE N/A OR AS NOTED	FILE NO.: 11-2931 DWG. NO.: 11-2931-STP3-PID	SHEET 1 OF 1
CONTRACTOR		CONSULTING ENGINEER HATCH		DESIGN DATE: Sep 05, 2011 PLOT DATE: Sep 13, 2011	VERSION R00	

Sep 13, 2011 05:02:44PM LEE Z:\DRAWING\PROJECTS\MARY RIVER PROJECT, BAYFILLAND SUBMISSION DRAWING\STP3