

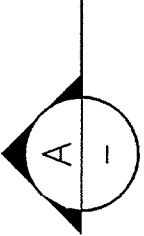
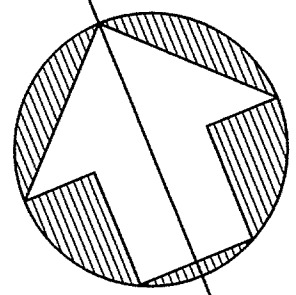


Σ000-410-01-Σ192-00067ΣH ON 3MD

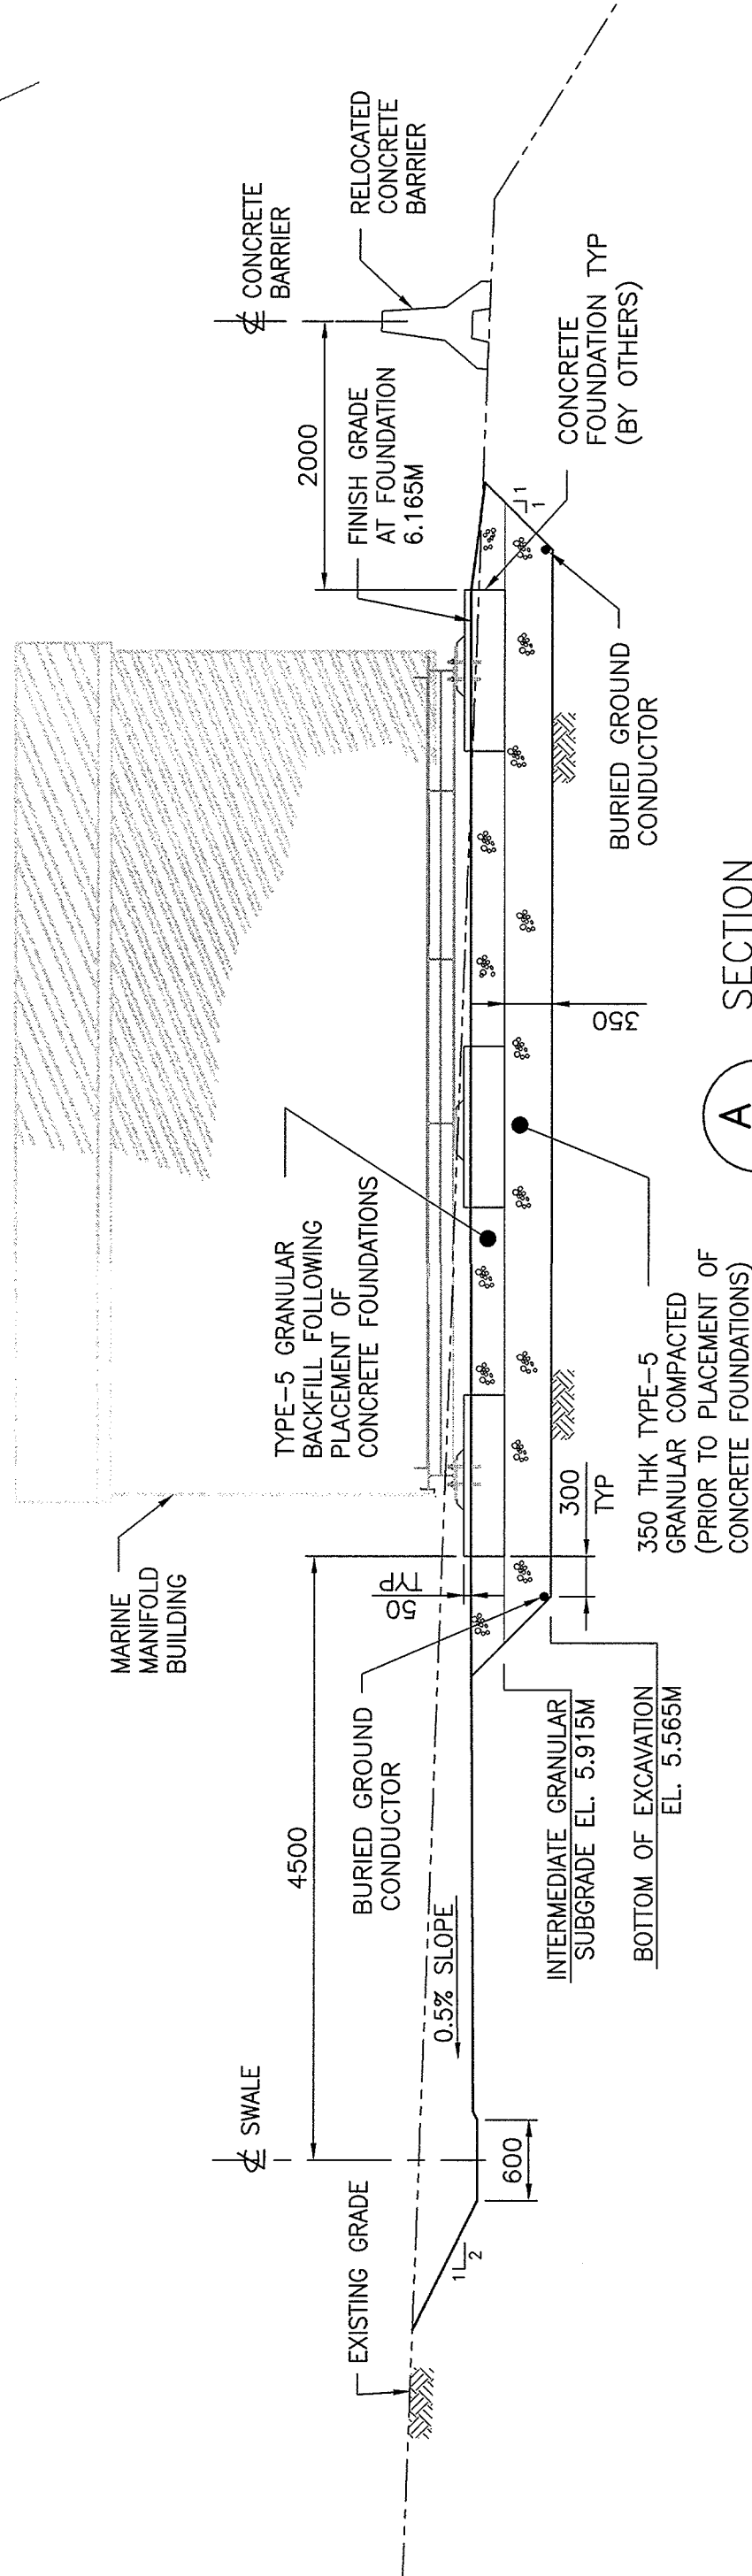


PLAN
SCALE: 1:50

A SECTION
SCALE: 1:50

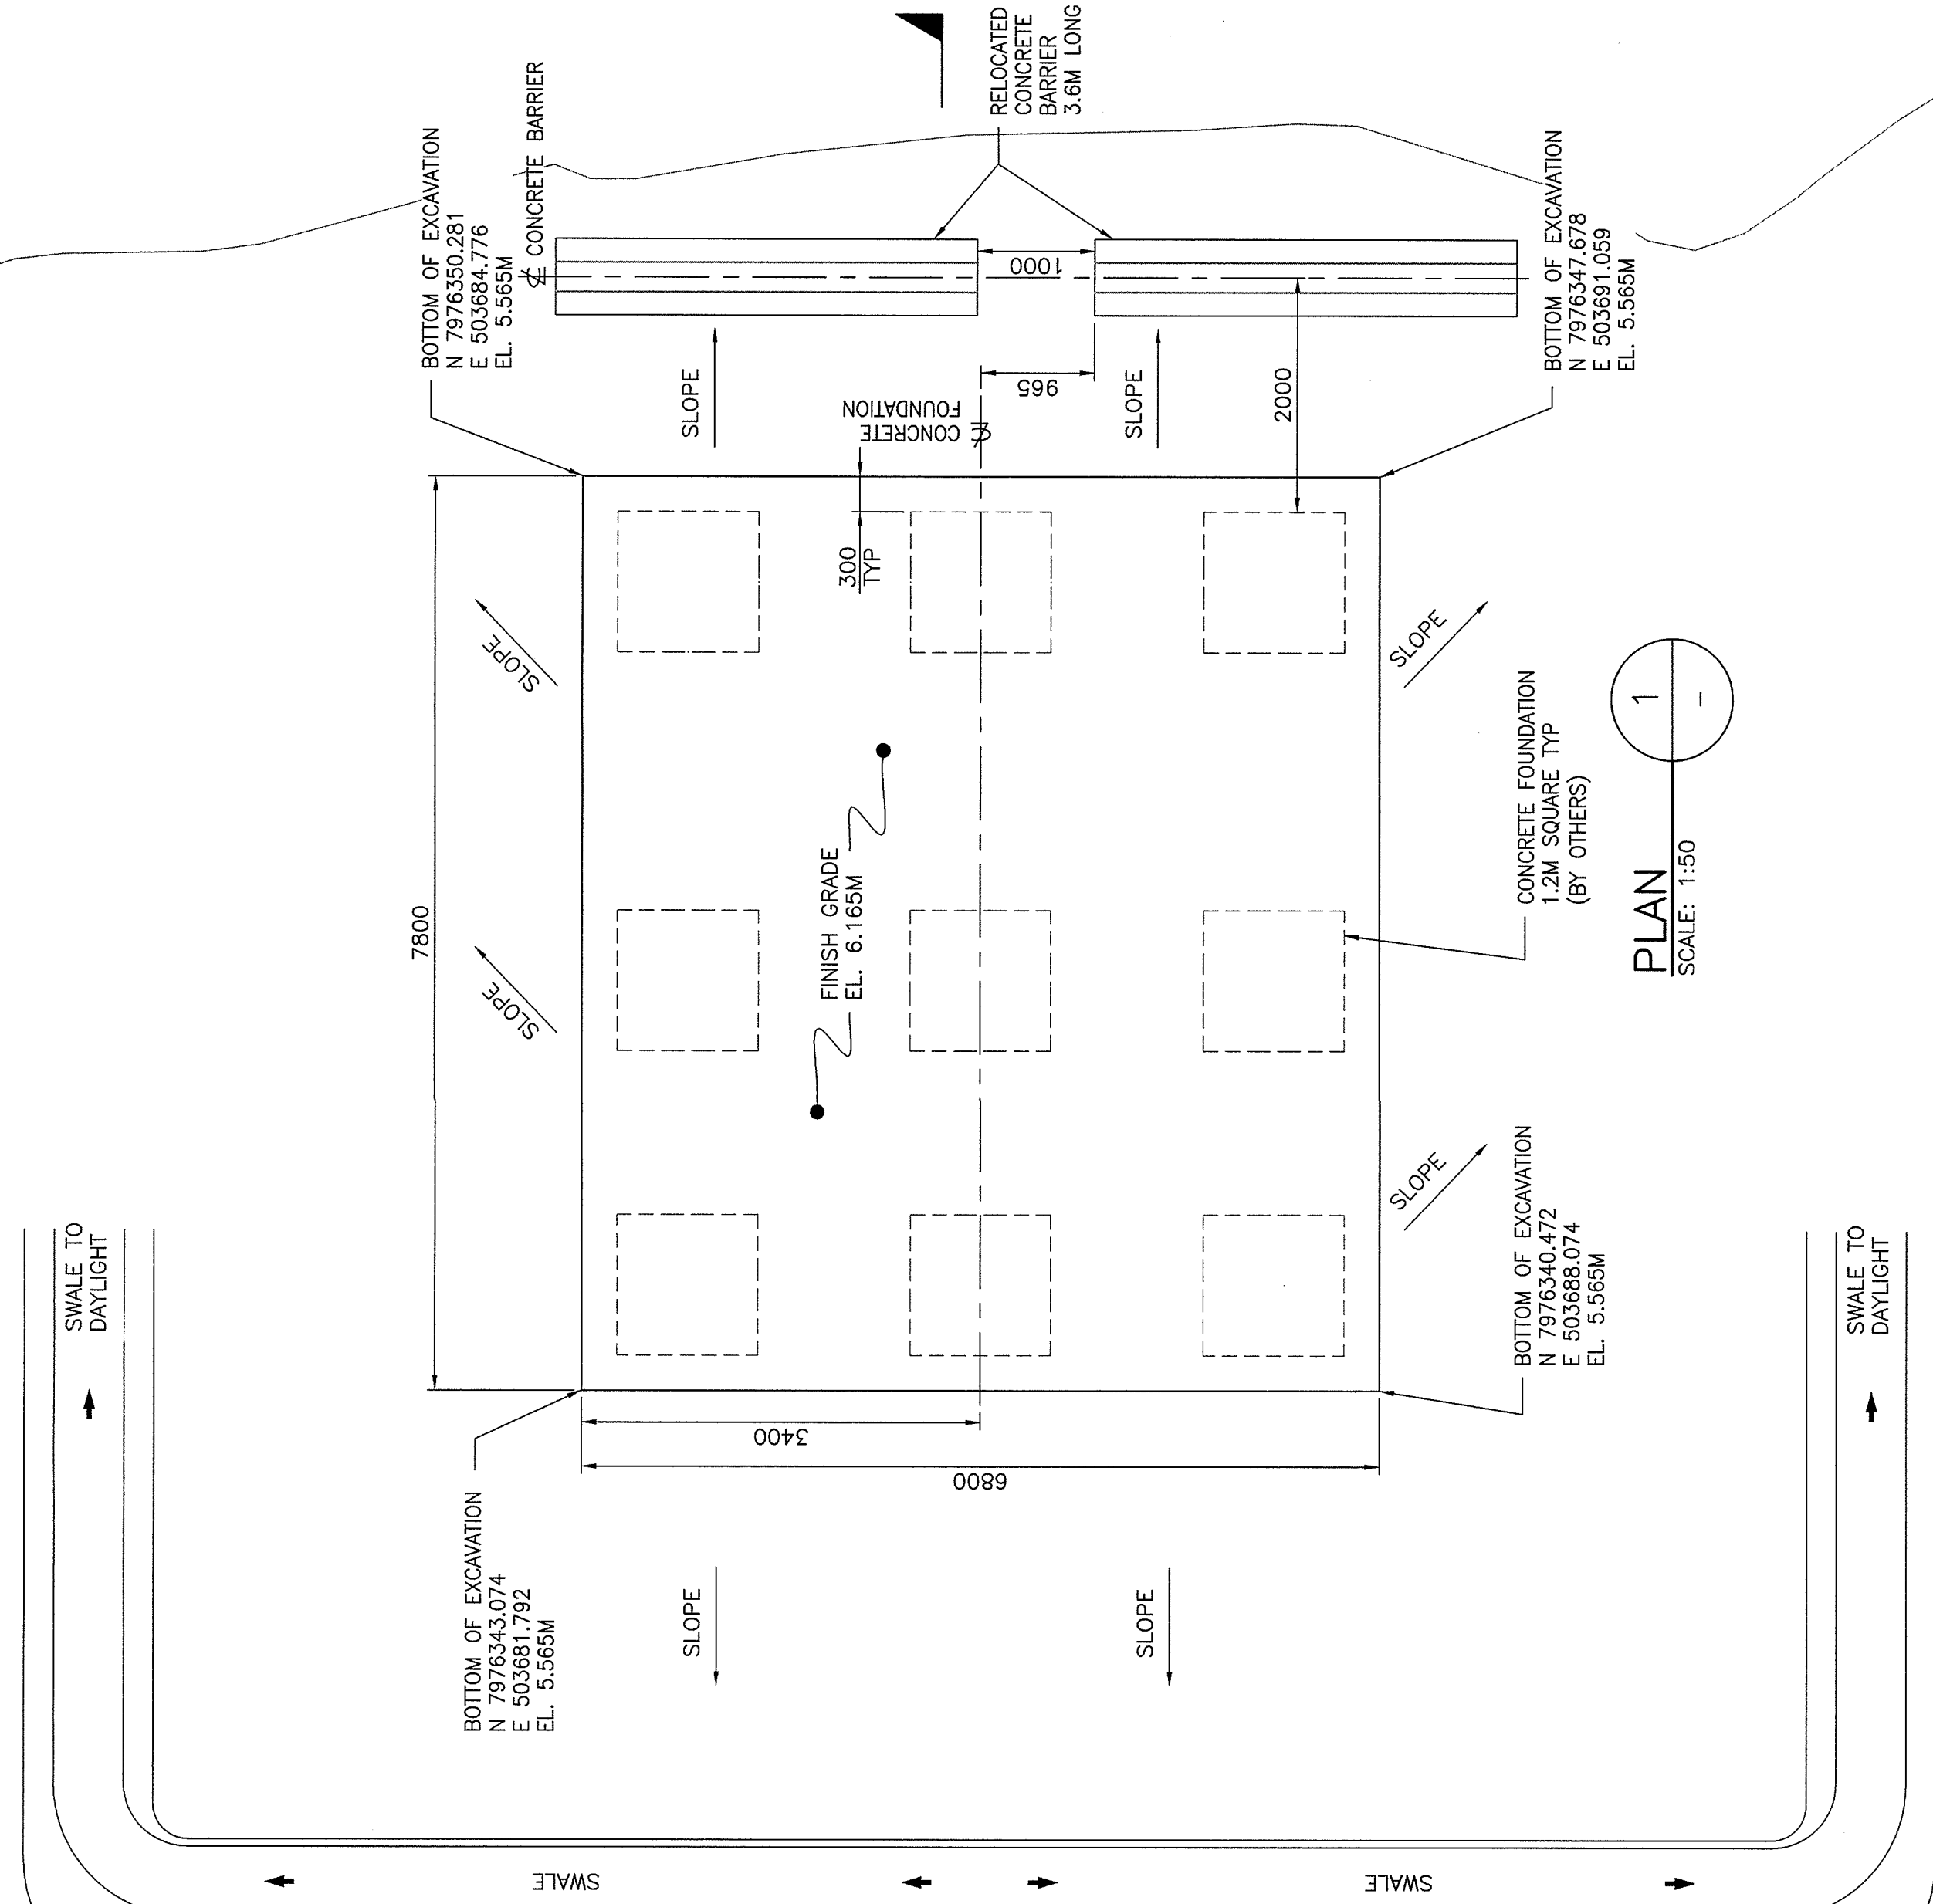

LEGEND:

- - COPPER CLAD GROUND ROD 19# X 3M DRIVEN 300 BELOW GRADE
- - BOLTED COMPRESSION OR MECHANICAL COMPRESSION CONNECTION
- - BURIED GROUND CONDUCTOR 2/0 AWG BARE CU.

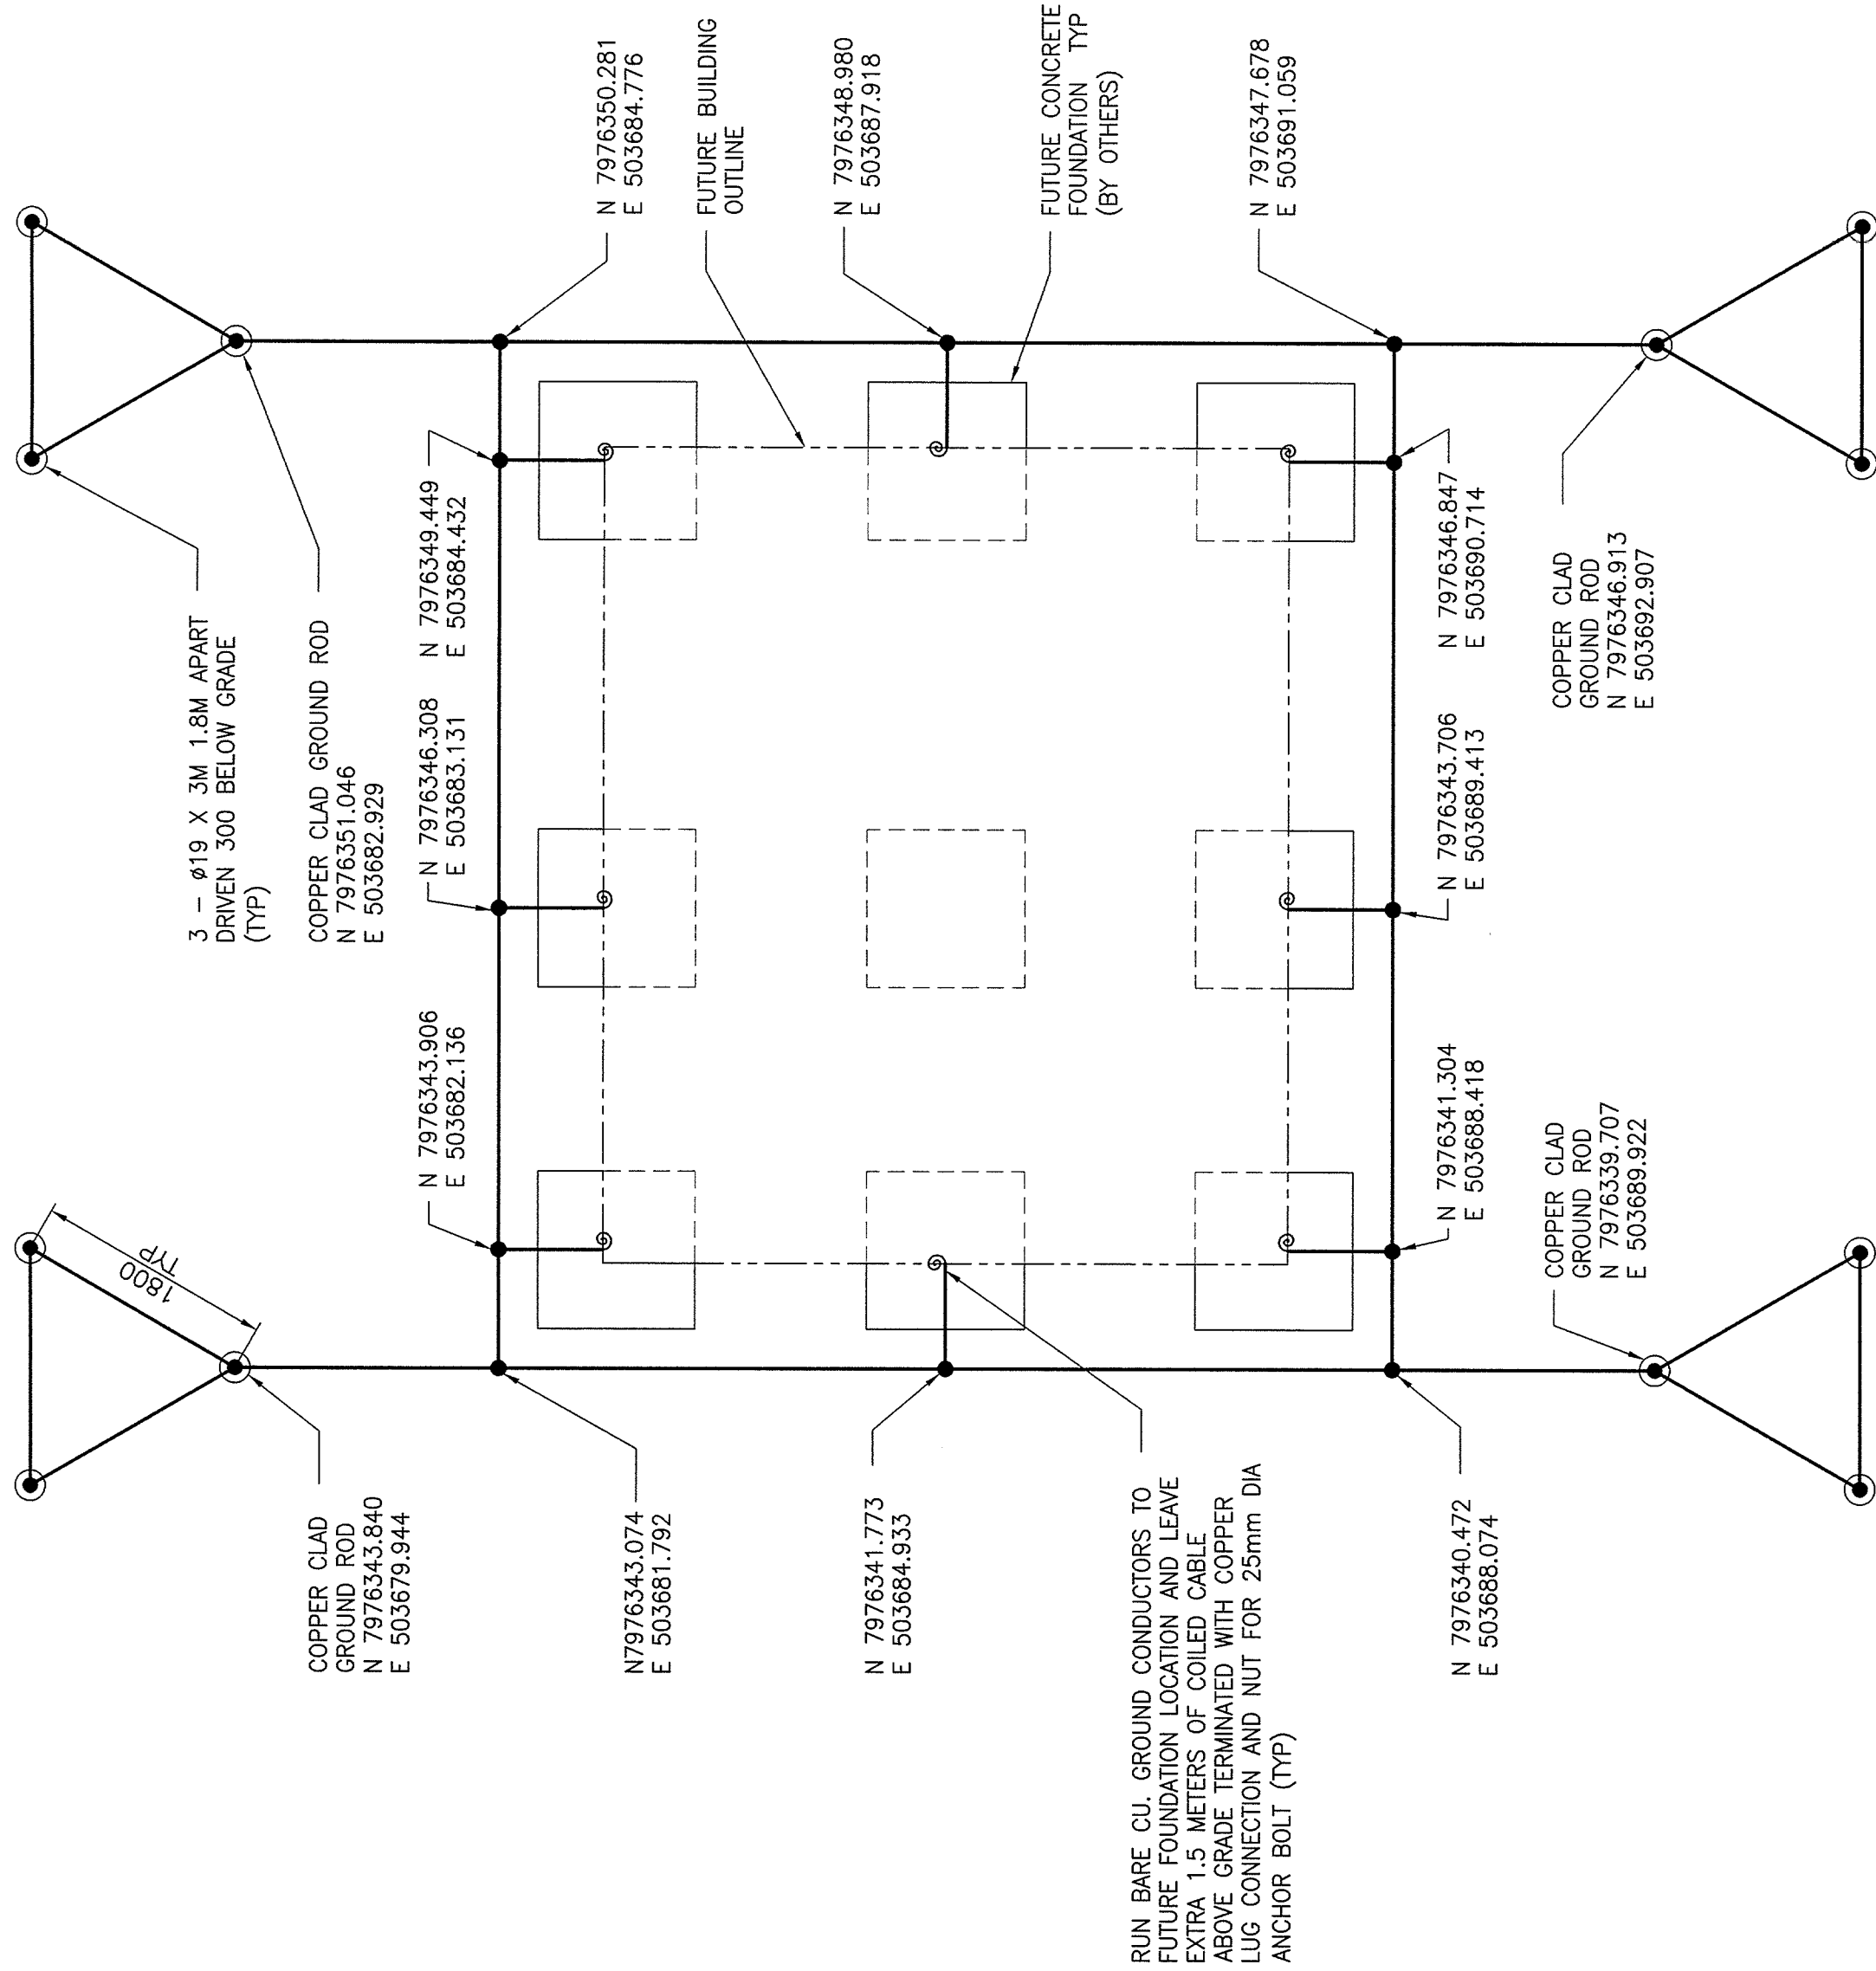

GROUNDING PLAN
PLAN
SCALE: 1:50


HATCH

Baffinland

MARY RIVER PROJECT
MILNE PORT – MANIFOLD BUILDING
EXCAVATION, BACKFILL & GROUNDING
PLANS & SECTION

DESIGNED BY
D. STEPHENSON
DATE 13-07-03
CHECKED BY
B. BROPHY
DATE 13-07-03
DESIGNER
S. PERRY
DATE 13-07-22
PROJ. DES. COORD.
T. THERTELL
J. CLELAND
DATE 13-07-22
DATE 13-07-22

ISSUED FOR CONSTRUCTION
DS
13-07-23
ISSUED FOR INTERNAL REVIEW
DS
13-07-03
AUTH. BY
S. PERRY
DATE 13-07-22

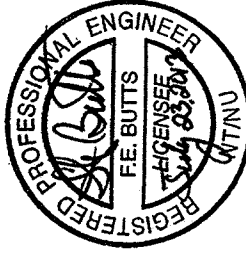

THIS DRAWING WAS PREPARED FOR THE EXCLUSIVE USE OF BAFFINLAND. IT IS NOT TO BE REPRODUCED OR USED FOR ANY OTHER PROJECT WITHOUT THE WRITTEN PERMISSION OF BAFFINLAND. THE USER OF THIS DRAWING SHALL BE RESPONSIBLE FOR THE ACCURACY OF THE INFORMATION PROVIDED AND FOR THE RESULTS OF ANY ACTION TAKEN THEREON.

DRAWING NO.
DRAWING TITLE
REFERENCE DRAWINGS

REVISIONS
NO. DESCRIPTION BY CHK'D APP'D DATE

ISSUE AUTHORIZATION
REV. DATE

SCALE
1:50
OR AS NOTED
H349000-2613-10-014-0003
DWG. NO.
H349000-2613-10-014-0003
REV. 0

ORIGINAL SHEET SIZE: ISO A1 (841 x 594)