

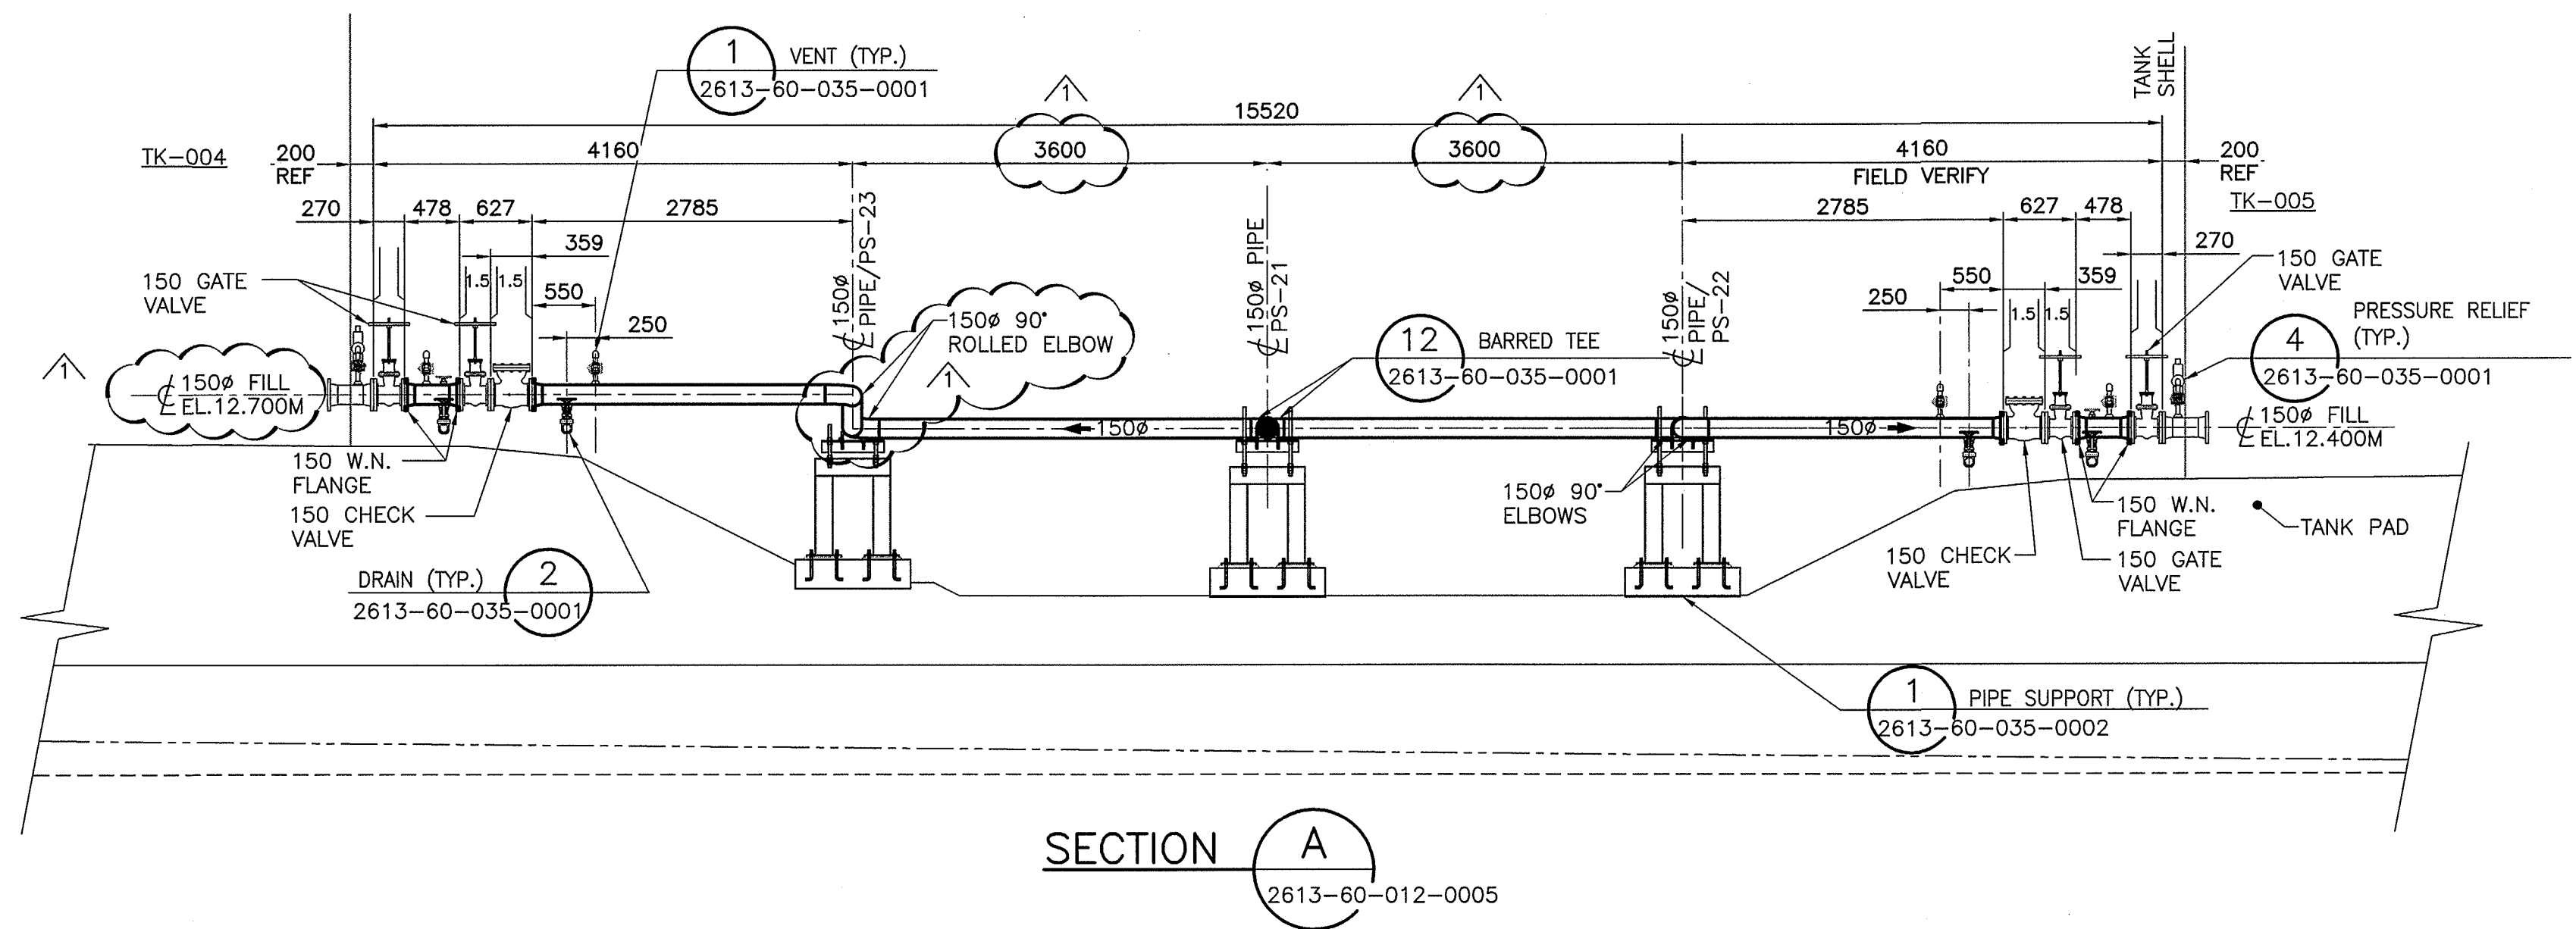
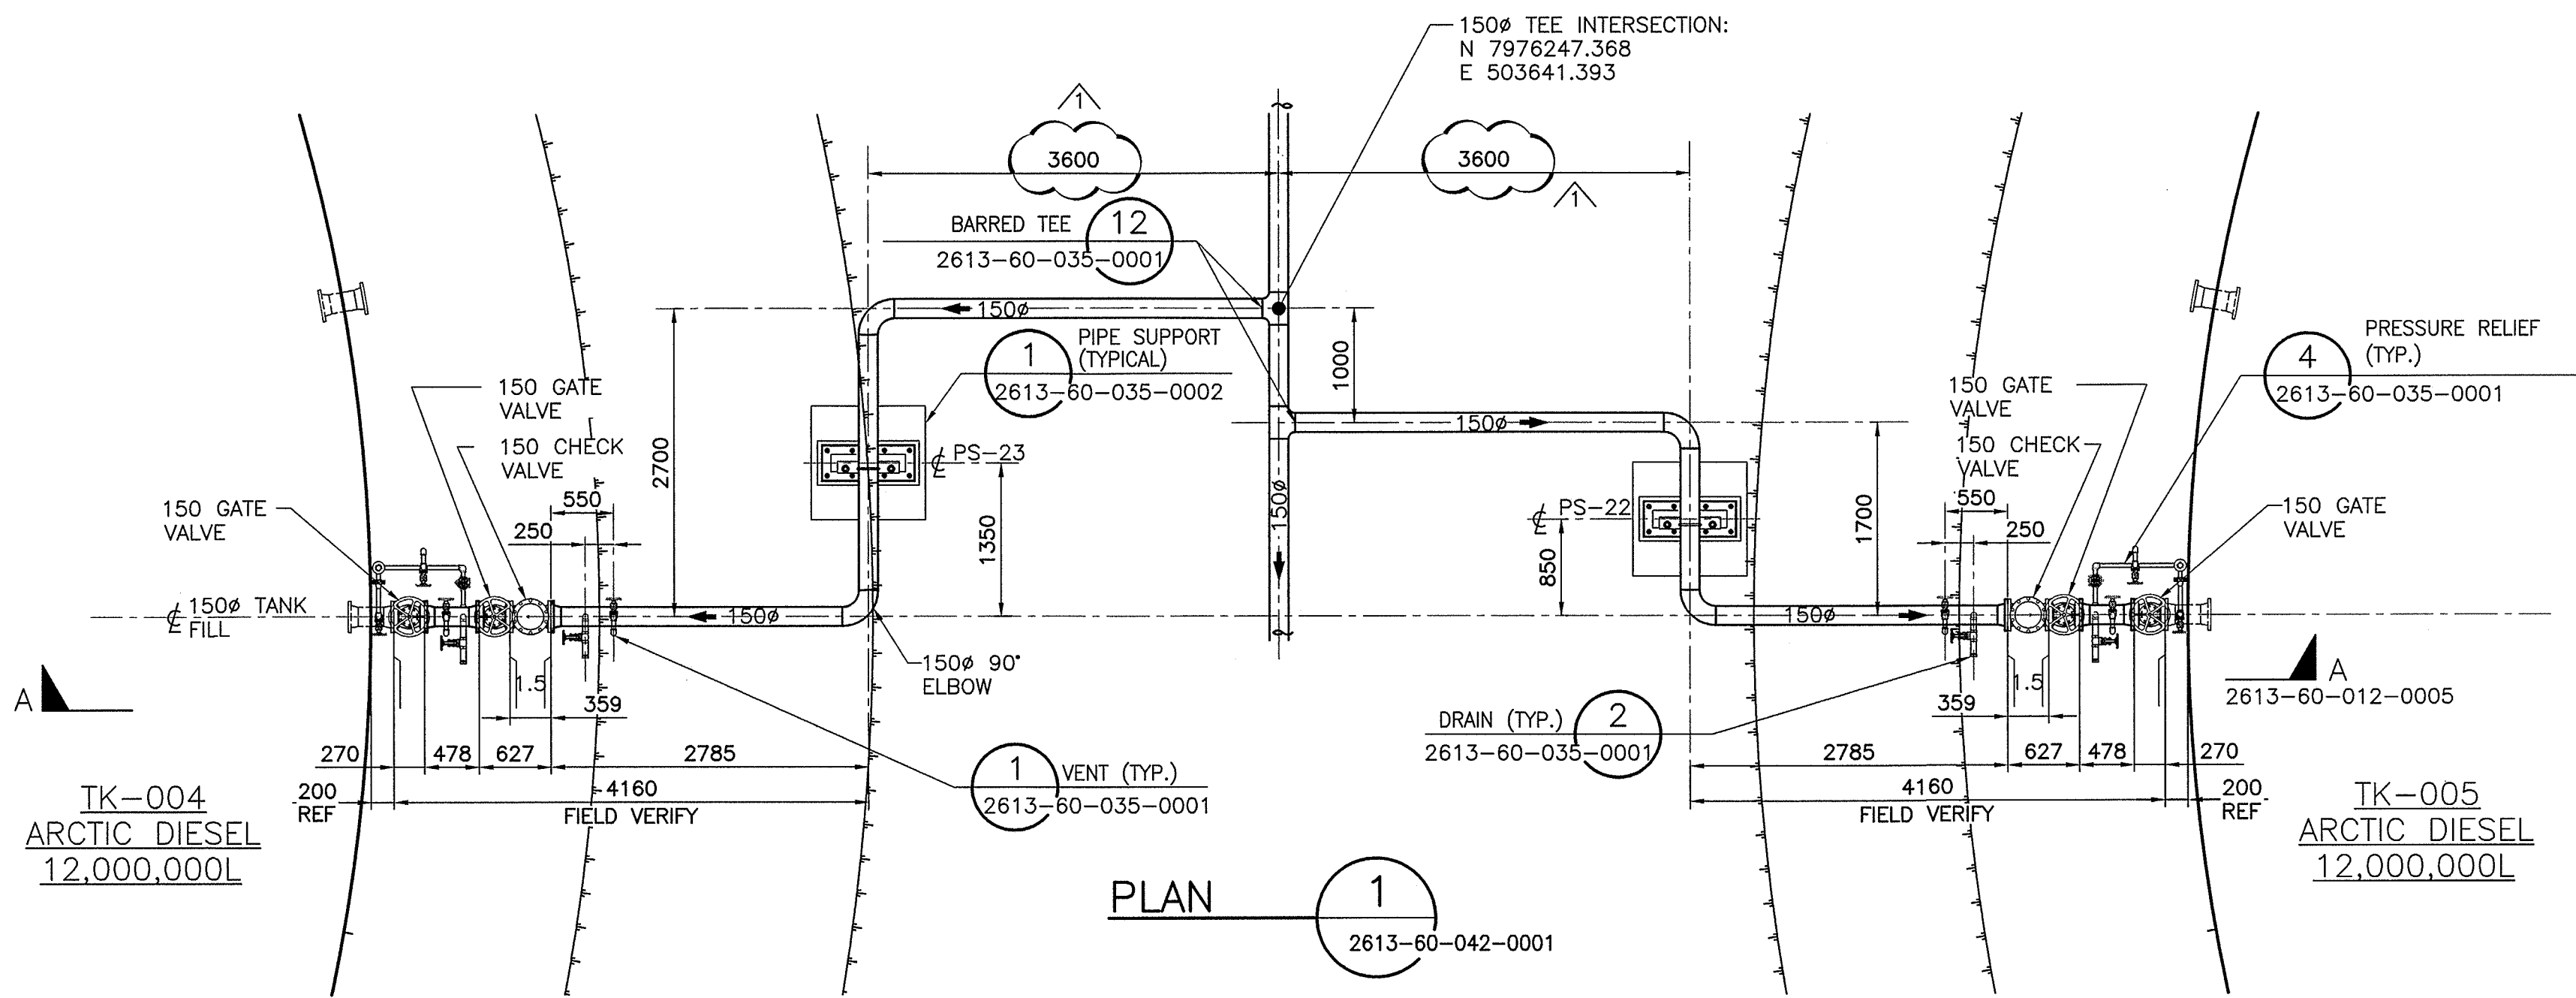


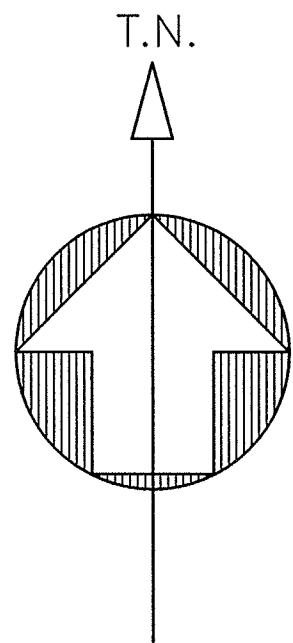

| DRAWING NO. | DRAWING TITLE      |
|-------------|--------------------|
| 1           | REFERENCE DRAWINGS |

THIS DRAWING WAS PREPARED FOR THE EXCLUSIVE USE OF Baffinland. THE Baffinland logo and name are the property of Baffinland. Baffinland is not responsible for the accuracy or completeness of the information provided in this drawing. The user of this drawing is responsible for verifying the accuracy and completeness of the information provided in this drawing. The user of this drawing is responsible for verifying the accuracy and completeness of the information provided in this drawing.

| NO. | DESCRIPTION                                                                                                                                           | BY | CHK'D | APP'D | DATE     |
|-----|-------------------------------------------------------------------------------------------------------------------------------------------------------|----|-------|-------|----------|
| 1   | TK-004 FILL NOZZLE ELEVATION NOW EL. 12.700M WAS EL 12.400M. PIPING ROLLED TO SUIT ELEVATION CHANGE. PS-22 AND PS-23 RELOCATED TO SUIT 12ML. TANK PAD | MP | OS    | FB    | 13-05-10 |

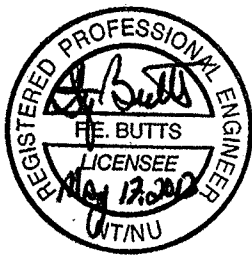

| REV. | ISSUE FOR               | DATE     | AUTH. BY |
|------|-------------------------|----------|----------|
| 1    | ISSUED TO CONTRACTOR    | 13-05-10 | OS FB    |
| 0    | ISSUED FOR CONSTRUCTION | 13-04-26 |          |

| DESIGNED BY       | DRAWN BY      |
|-------------------|---------------|
| D. STEPHENSON     | S. LEY        |
| DATE 13-03-06     | DATE 13-03-06 |
| CHECKED BY        | DISCIP. ENGR. |
| S. Perry          | S. Perry      |
| DATE 13-05-10     | DATE 13-05-10 |
| PROJ. DES. COORD. | PROJ. ENGR.   |
| T. THERTELL       | J. CLELAND    |
| DATE 13-05-10     | DATE 13-05-10 |
| PROJ. MGR.        |               |
| S. PERRY          |               |
| DATE 13-05-10     |               |

|                                         |                                      |
|-----------------------------------------|--------------------------------------|
| Baffinland                              |                                      |
| MARY RIVER PROJECT                      |                                      |
| MILNE INLET                             |                                      |
| PIPING PLAN & SECTION                   |                                      |
| SCALE<br>1:50<br>OR AS NOTED            | DWG. NO.<br>H349000-2613-60-012-0005 |
| ORIGINAL SHEET SIZE: ISO A1 (841 x 594) | REV.<br>1                            |

\$TIMES  
\$DATES  
\$USERNAME\$