


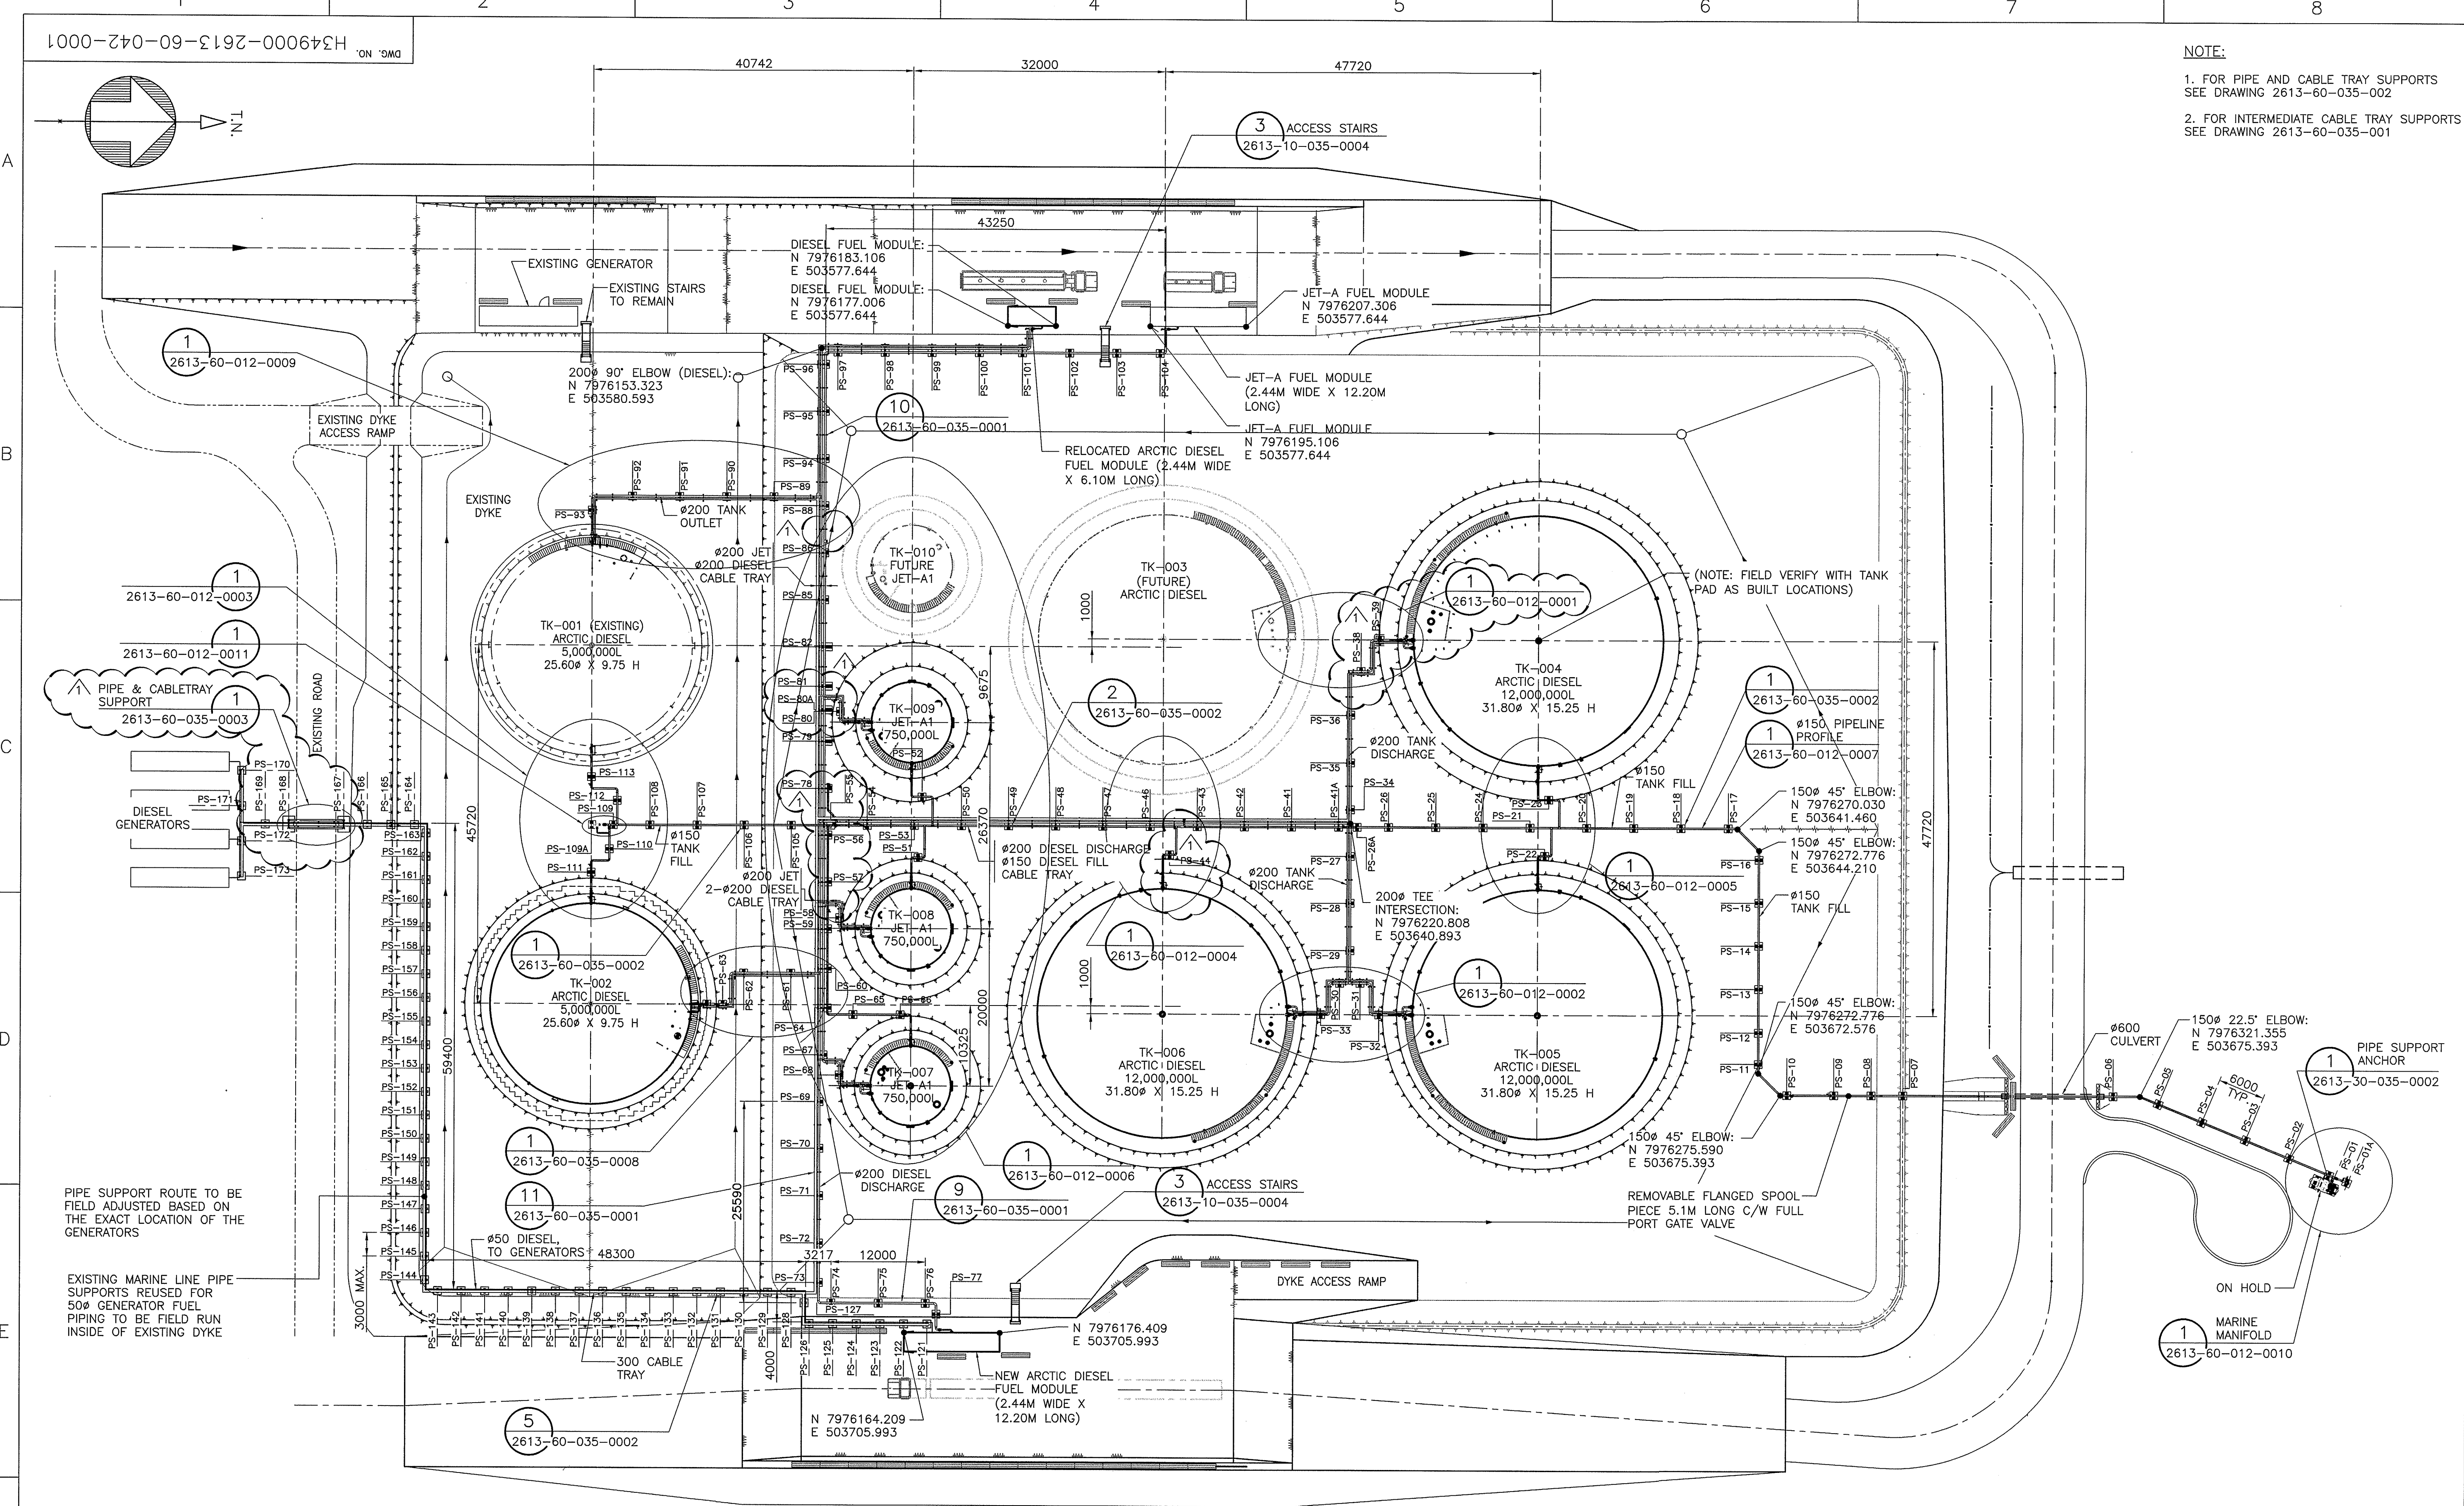


- NOTE:
- 1. FOR PIPE AND CABLE TRAY SUPPORTS SEE DRAWING 2613-60-035-002
 - 2. FOR INTERMEDIATE CABLE TRAY SUPPORTS SEE DRAWING 2613-60-035-001

DRAWING NO.	DRAWING TITLE
1	REFERENCE DRAWINGS

THIS DRAWING WAS PREPARED FOR THE EXCLUSIVE USE OF Baffinland AND IS NOT TO BE REPRODUCED OR TRANSMITTED IN ANY FORM OR BY ANY MEANS, ELECTRONIC OR MECHANICAL, INCLUDING PHOTOCOPYING, RECORDING, OR BY ANY INFORMATION STORAGE AND RETRIEVAL SYSTEM, WITHOUT THE WRITTEN PERMISSION OF Baffinland.

NO.	DESCRIPTION	BY	CHK'D	APP'D	DATE
1	PIPING REVISED AND FUTURE PIPING REMOVED	MS	DS	FB	13-05-10

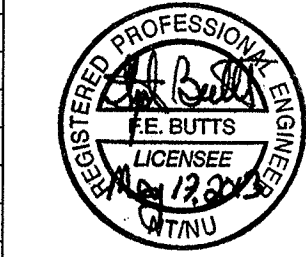

REV.	ISSUE FOR	AUTH. BY	DATE
1	ISSUED TO CONTRACTOR	DS	13-05-10
0	ISSUED FOR CONSTRUCTION	DS	13-04-22

HATCH

DESIGNED BY
D. STEPHENSON
DATE 13-03-06

CHECKED BY
[Signature]
DATE 13-05-10

PROJ. DES. COORD.
T. THERTELL
DATE 13-05-10

PROJ. MGR.
S. PERRY
DATE 13-05-10

DRAWN BY
S. LEY
DATE 13-03-06

DISCIP. ENGR.
[Signature]
DATE 13-05-10

PROJ. ENGR.
J. CLELAND
DATE 13-05-10

Baffinland

MARY RIVER PROJECT

MILNE PORT PIPING PLAN

SCALE
1:400
OR AS NOTED

DWG. NO.
H349000-2613-60-042-0001

REV.
1

\$FILES
\$DATES
\$USERNAMES