
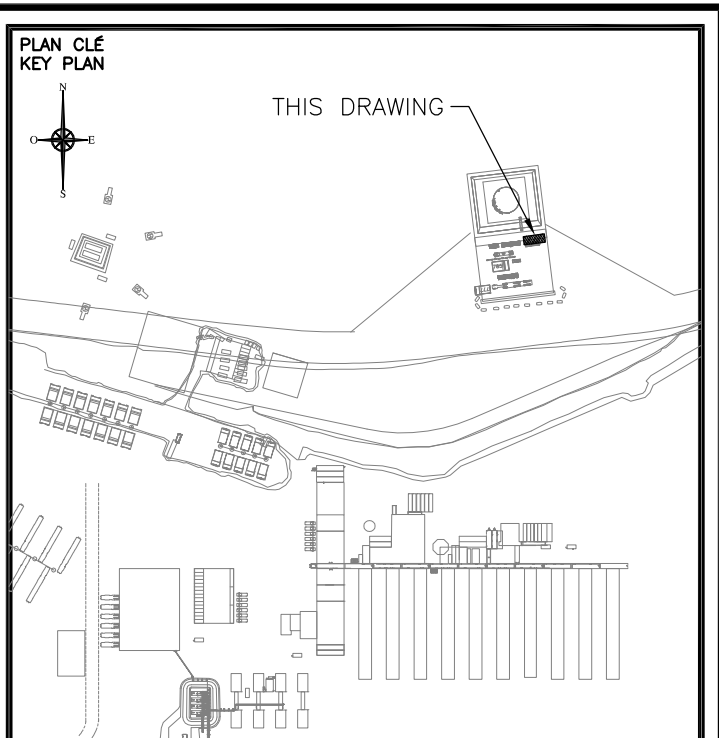


 SNC • LAVALIN	WHALE TAIL INFRASTRUCTURE ENGINEERING PROJECT	 AGNICO EAGLE
	FUEL STORAGE TANK AND CONTAINMENT FACILITIES DESIGN REPORT AND DRAWINGS	

APPENDIX C **Engineering Drawings**

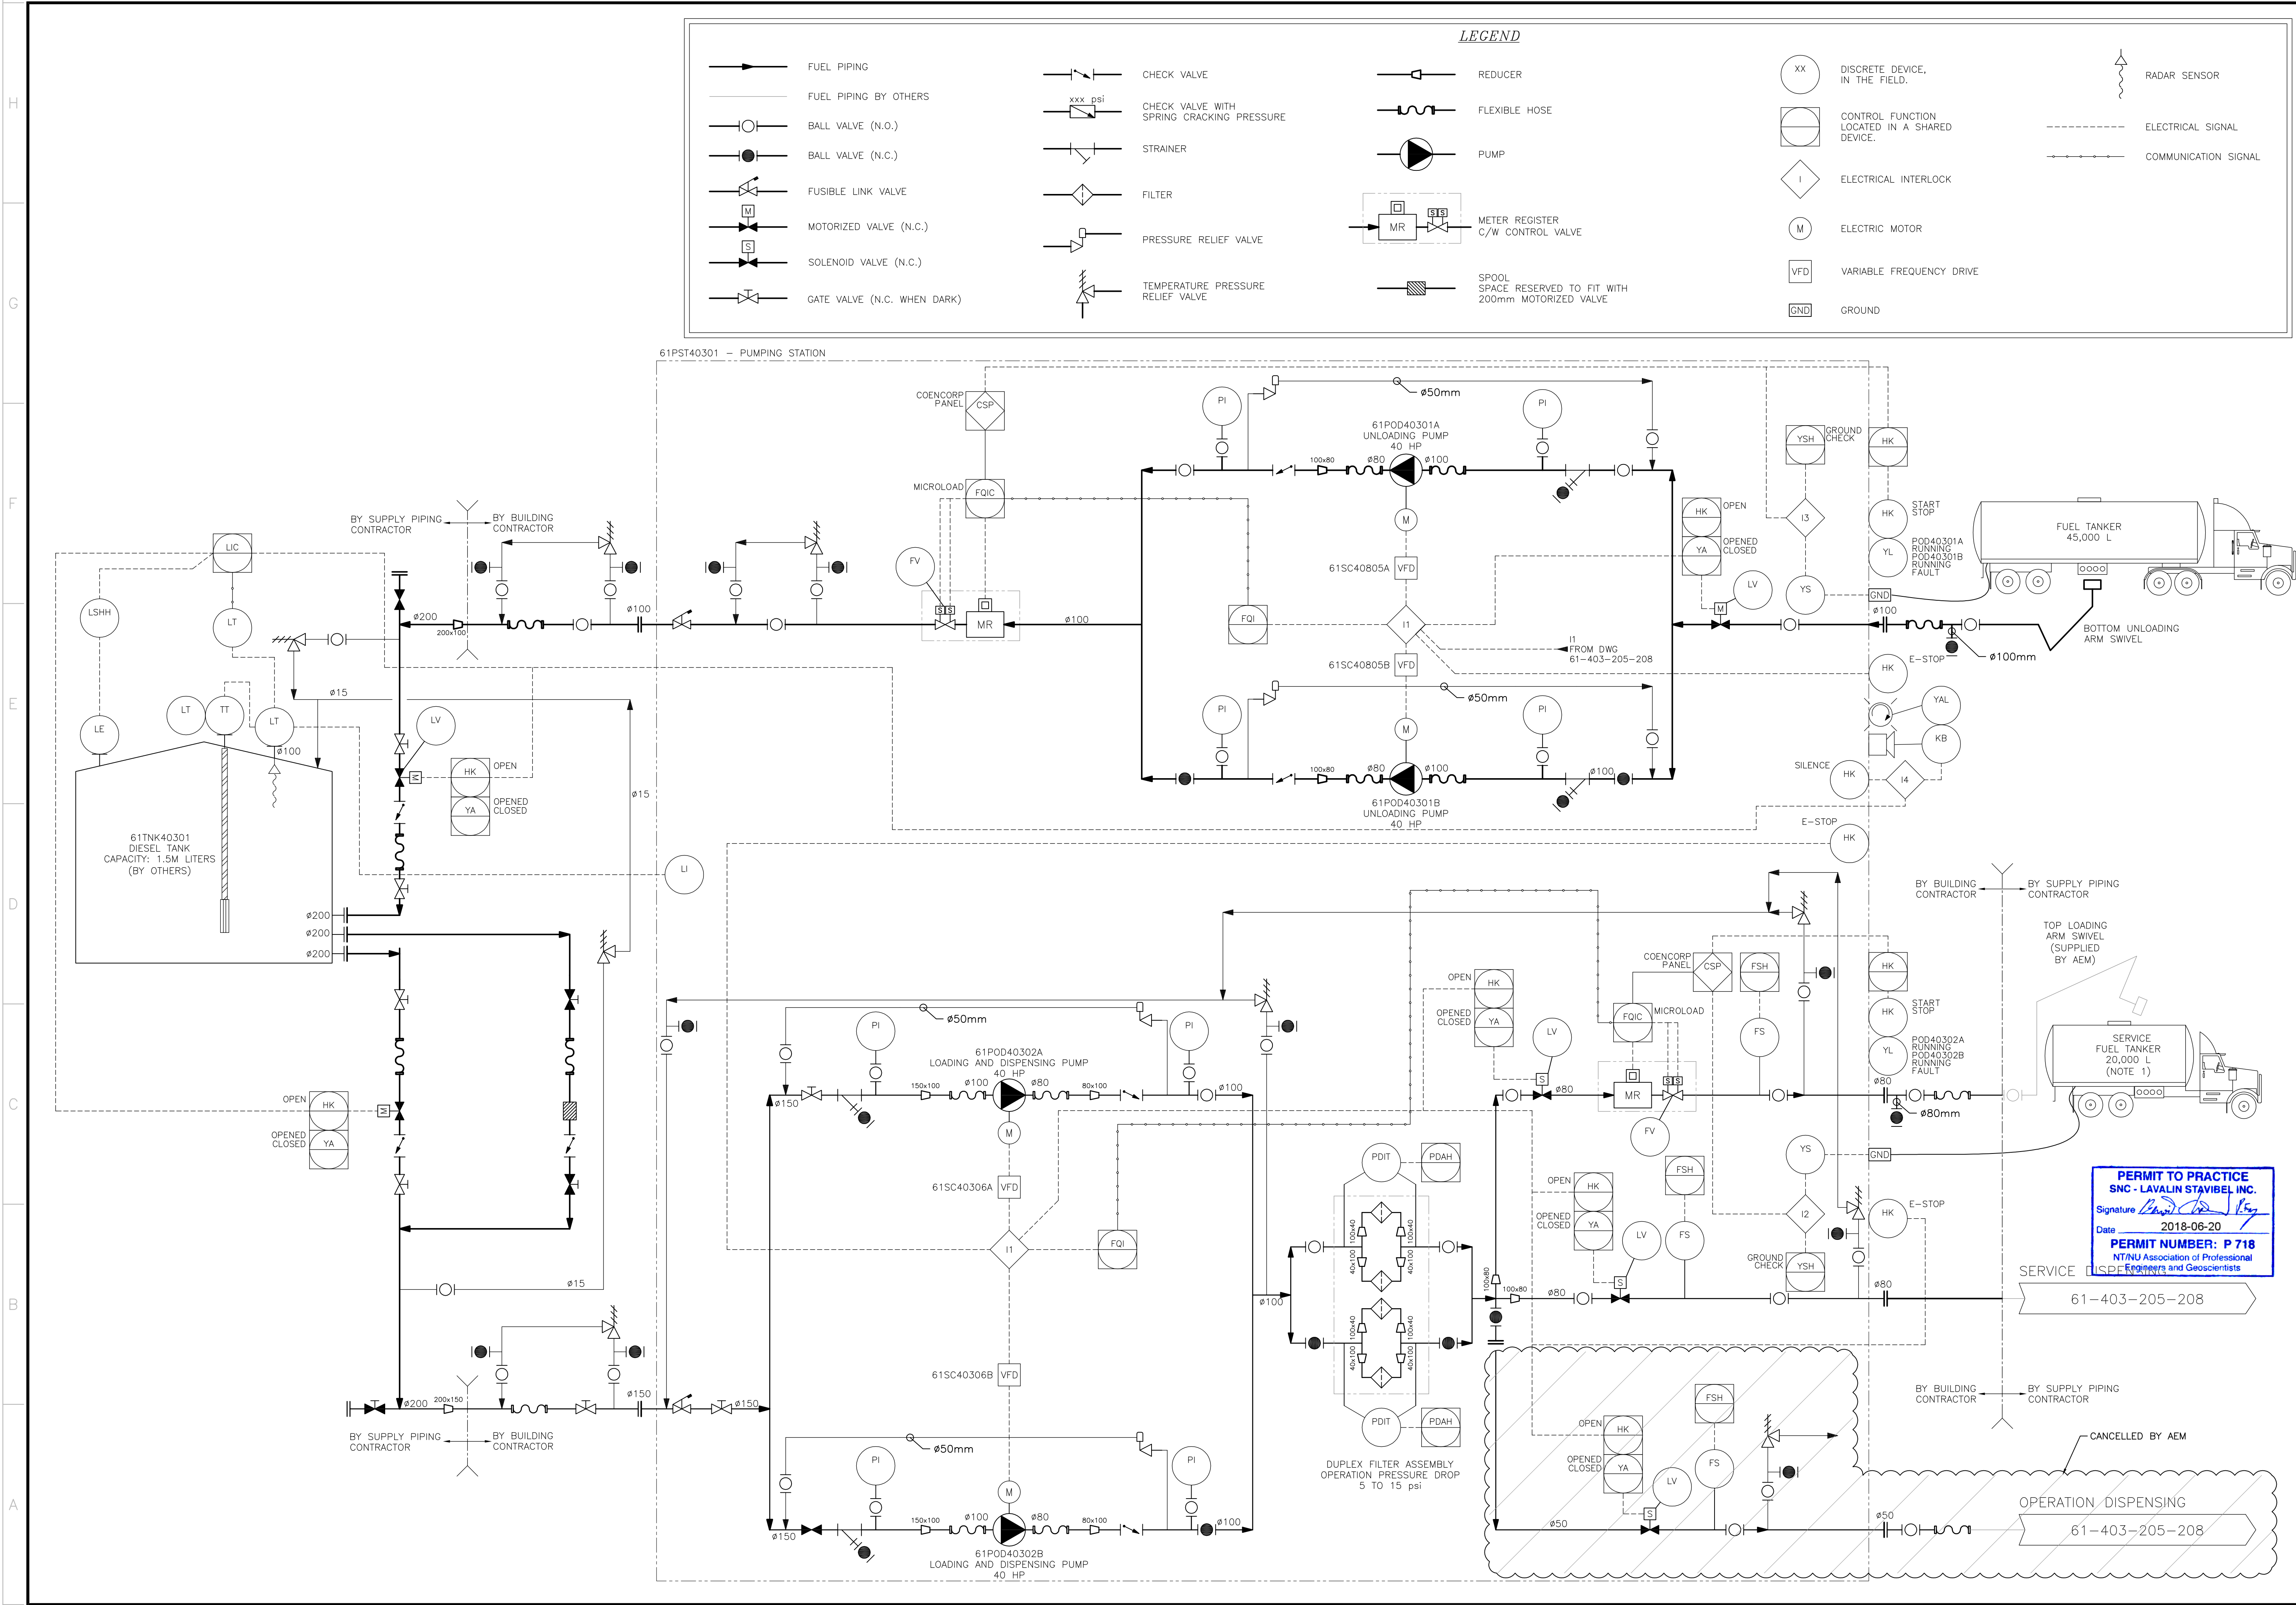

NOTES GÉNÉRALES / GENERAL NOTES

NOTE FOR SUPPLY PIPING CONTRACTOR
(LOT # 6115-S-270-004-SOW-001)

1- INDOOR PIPING, SOLENOID VALVES AND INSTRUMENTS ARE EXCLUDED.

2- PROVIDE ALL OUTSIDE PIPING (ABOVE AND UNDERGROUND), VALVES, FITTING AND OTHER ACCESSORIES.

3- OUTDOOR MOTORIZED VALVES ARE EXCLUDED.

NOTE FOR BUILDING CONTRACTOR
(LOT # 6115-S-265-011-SOW-001)

POUR CONSTRUCTION FOR CONSTRUCTION

AGNICO EAGLE

DATE : 2018-06-20

SNC-LAVALIN

SNC-Lavalin Stavisbel Inc.
150, rue Gamble Ouest
Roxbury-Noranda (Québec) J8X 2R7
Tél. : 519 784-5181 Fax : 519 787-0158
www.snc-lavalin.com

Project # : 644819-0000

L'INFORMATION CONTENUE EST LA PROPRIÉTÉ DE AGNICO EAGLE LTD ET DOIT ÊTRE RETENUE SUR DEMANDE. SANS GARANTIE EXPRESSE. AGNICO EAGLE LTD. ASSUME AUCUNE RESPONSABILITÉ EN CAS D'ERREUR. AGNICO EAGLE LTD. ASSUME AUCUNE RESPONSABILITÉ EN CAS D'ERREUR. AGNICO EAGLE LTD. ASSUME AUCUNE RESPONSABILITÉ EN CAS D'ERREUR.

DESSINS EN RÉFÉRENCE / REFERENCE DRAWINGS	
TITRE / TITLE	# DWG
FUEL DISTRIBUTION DIAGRAM	61-403-200-202
FUEL DISPENSING BUILDINGS	61-403-205-208

AGNICO EAGLE

3	2018-06-20	ISSUED FOR CONSTRUCTION	D.L.L.	A.O.	D.L.
2	2018-06-06	ISSUED FOR CONSTRUCTION	D.L.L.	A.O.	D.L.
1	2018-05-23	ISSUED FOR CONSTRUCTION	ST.M.	A.O.	D.L.
0	2018-05-17	ISSUED FOR CONSTRUCTION	STW/BP	A.O./B.C.	D.L.
REV.	DATE	DESCRIPTION	PAR/BY	APP.	CLIENT
REVISIONS					

REVISIONS

DOCUMENT SIGNÉ NUMÉRIQUEMENT

PERMIT TO PRACTICE
SNC - LAVALIN STAVISBEL INC.
Signature: [Signature]
Date: 2018-06-20
PERMIT NUMBER: P 718
NTNU Association of Professional Engineers and Geoscientists

 
TITRE / TITLE
AGNICO EAGLE - WHALE TAIL (AMARUQ)
403 - COMBUSTIBLE
205 - P&ID
P&ID
FUEL TANK FARM
PUMPING STATION

DESSINÉ PAR STÉPHANE MARCOTTE, TECH.
DATE 2018-05-14
VERIFIÉ PAR MICHEL FOURNIER, TECH.
DATE 2018-05-17
APPROUVÉ PAR ALAIN OUELLET, P.ENG.
DATE 2018-05-17




ÉCHELLE N/A
DATE 2018-02-08

NO. DESSIN 61-403-205-207
DRAWING NO. 6115

NO. PROJET 6115
PROJET NO. 3
FEUILLE / SHEET 1 / 1



LEGEND -- FUELING SIDE			
FUEL TRUCK	DESCRIPTION	UREA	DIESEL
777	OPERATION TRUCK	N/A	PASSENGER
785	OPERATION TRUCK	N/A	DRIVER
LHT	LONG HAUL TRUCK	PASSENGER	PASSENGER
	JERSEY PROTECTION BLOCK	N/A	N/A

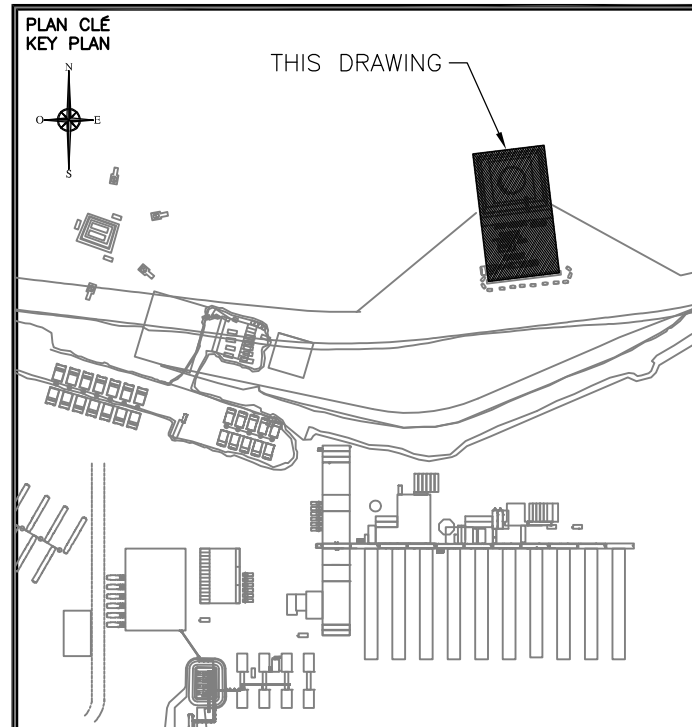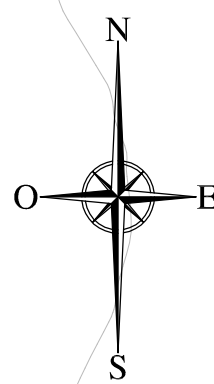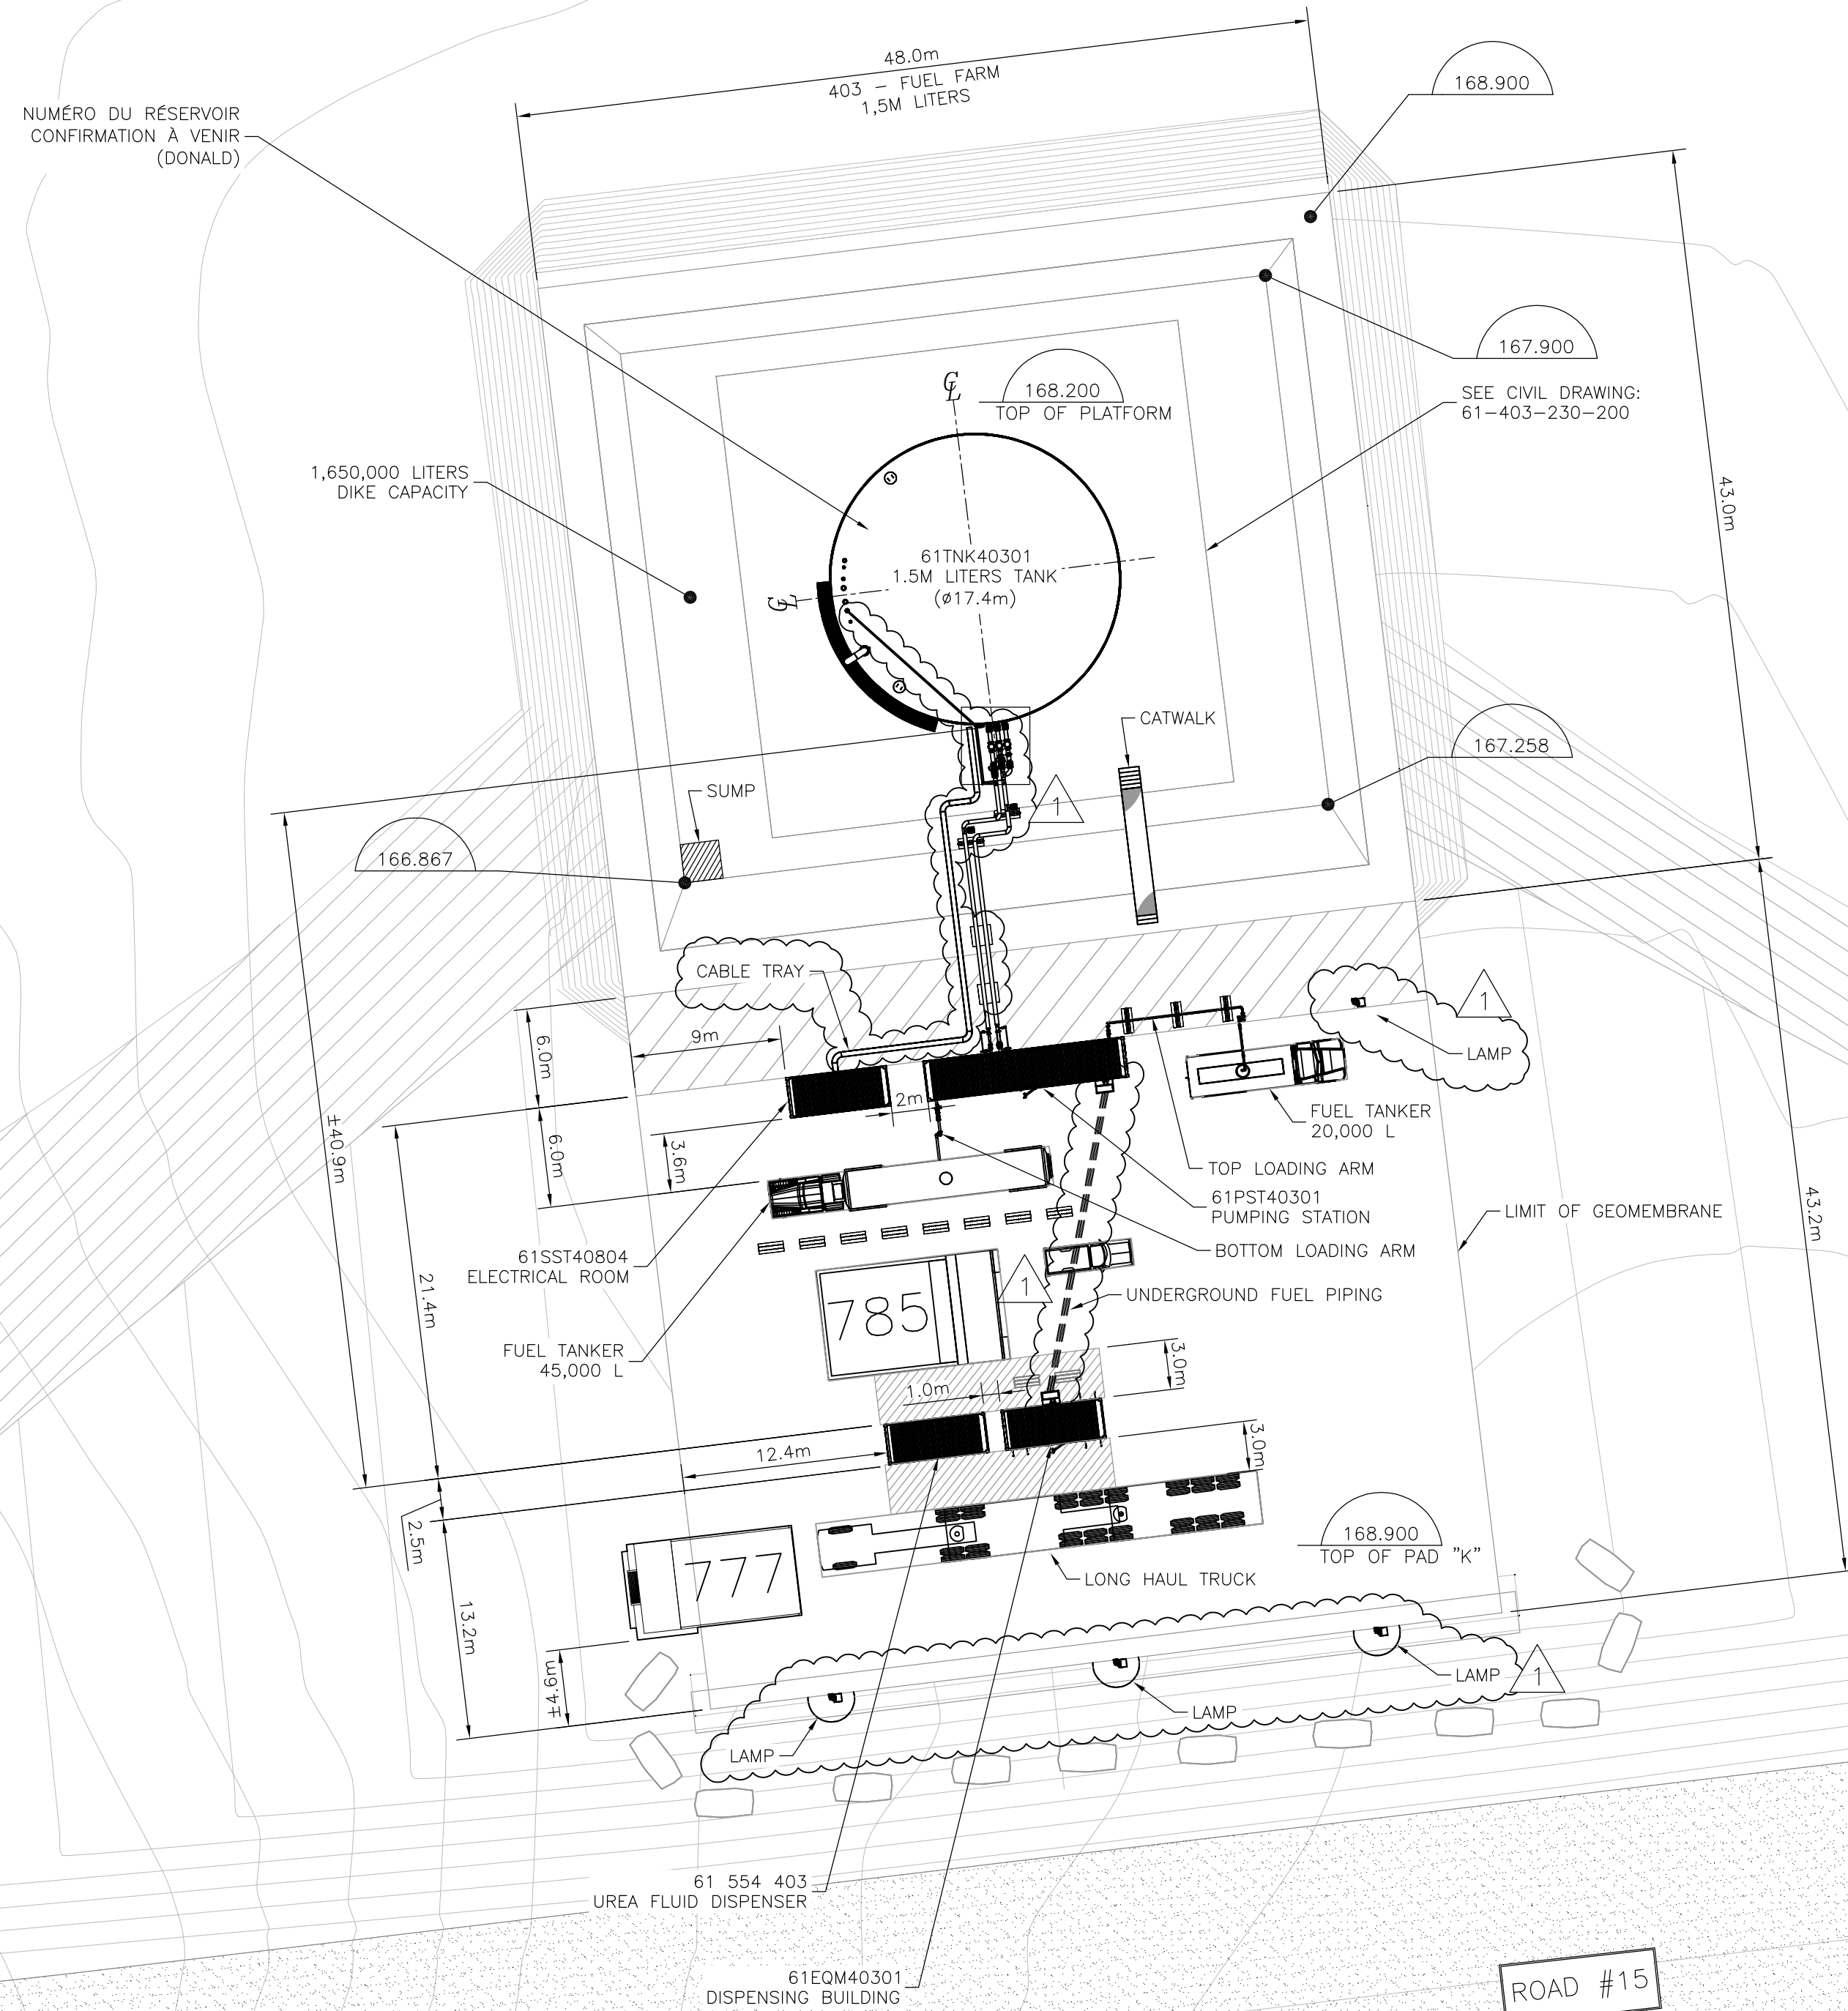

NOTES GÉNÉRALES / GENERAL NOTES



SNC • LAVALIN

SNC-Lavalin Stavibel inc.
150, rue Gamble Ouest
Rouyn-Noranda (Québec) J9X 2R7
Tel. : 819 764-5181 Fax : 819 797-0158
www.snc-lavalin.com

Project # : 644819-0000

THE INFORMATION ON-CONTAINED IS THE PROPERTY OF ADNOC EAGLE LTD. AND MUST BE RETURNED UPON REQUEST. WITHOUT WRITTEN PERMISSION, ANY COPYING, TRANSMITTAL TO OTHERS AND ANY USE EXCEPT THAT FOR WHICH IT IS LOANED ARE PROHIBITED.

DESSINS EN RÉFÉRENCE / REFERENCE DRAWINGS

TITLE / TITLE	# DWG
FUEL DISTRIBUTION DIAGRAM - FLOWSHEET	61-403-200-202
FUEL TANK FARM - PUMPING STATION	61-403-205-207
FUEL TANK FARM - FUEL DISPENSING BLDG	61-403-205-208
RETENTION POND AND PAD "K"	61-403-230-200



AGNICO EAGLE

1	2018-06-20	ISSUED FOR CONSTRUCTION	ST.M.	A.O.	D.L.	
0	2018-06-19	ISSUED FOR CONSTRUCTION	ST.M.	A.O.	D.L.	
REV.	DATE	DESCRIPTION	PAR/BY	APP.	CLIENT	

REVISIONS



2018-06-20

TITLE / TITLE

AGNICO EAGLE - WHALE TAIL (AMARUQ)
403 - COMBUSTIBLES
210 - GENERAL ARRANGEMENT
PLAN VIEW
FUEL TANK FARM
LAYOUT

DESSINÉ PAR DRAWN BY	OTÉOLIANE MAROITTE-JEON	DATE 2019-09-14
-------------------------	-------------------------	--------------------





VERIFIÉ PAR CHECKED BY	MICHEL FOURNIER, TECH.	2018-06-15
---------------------------	------------------------	------------


APPROUVE PAR
APPROVED BY ALAIN OUELLET, P.ENG. 2018-06-19

ECHELLE SCALE	N.T.S.	DATE	2018-06-15
------------------	--------	------	------------

NO. DESSIN
DRAWING NO. 61-403-210-203

NO. PROJ PROJECT NO.	REVISION	FEUILLE / SHT
	1	1 / 1

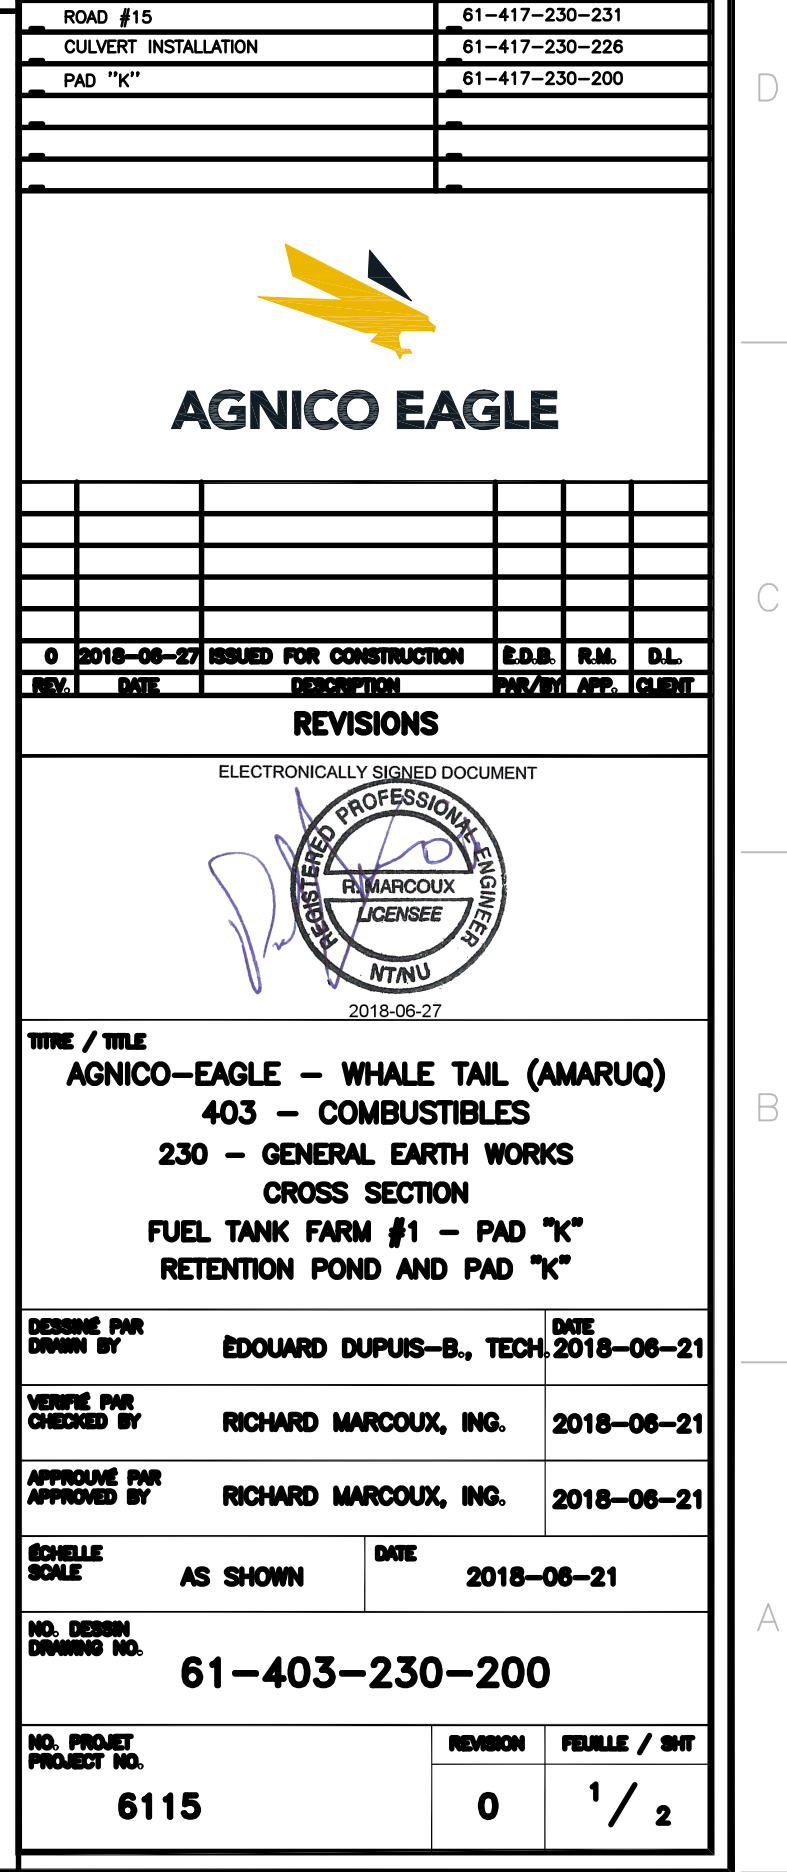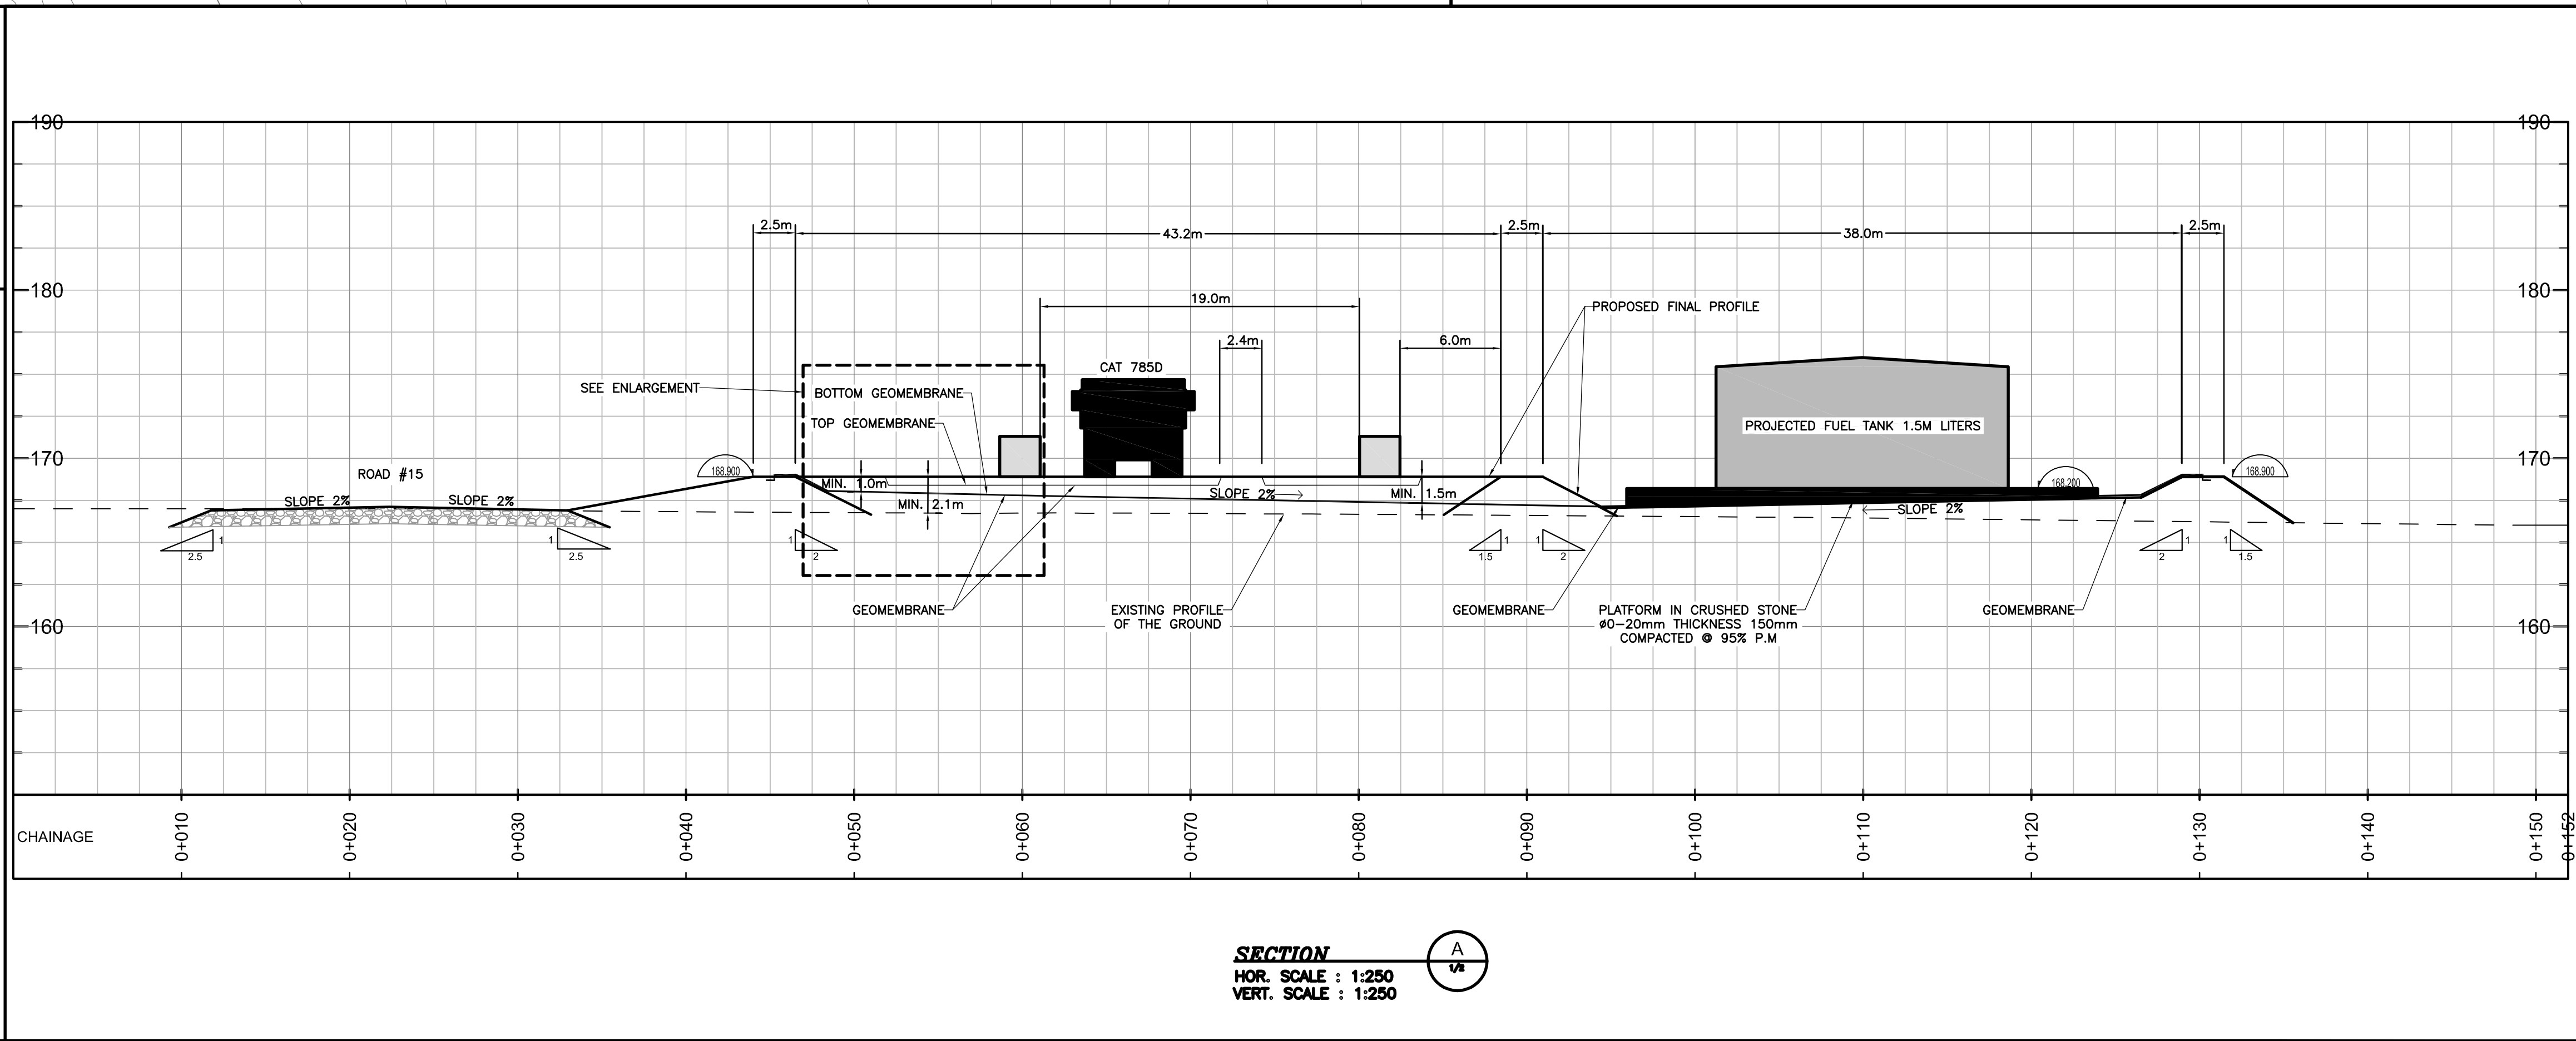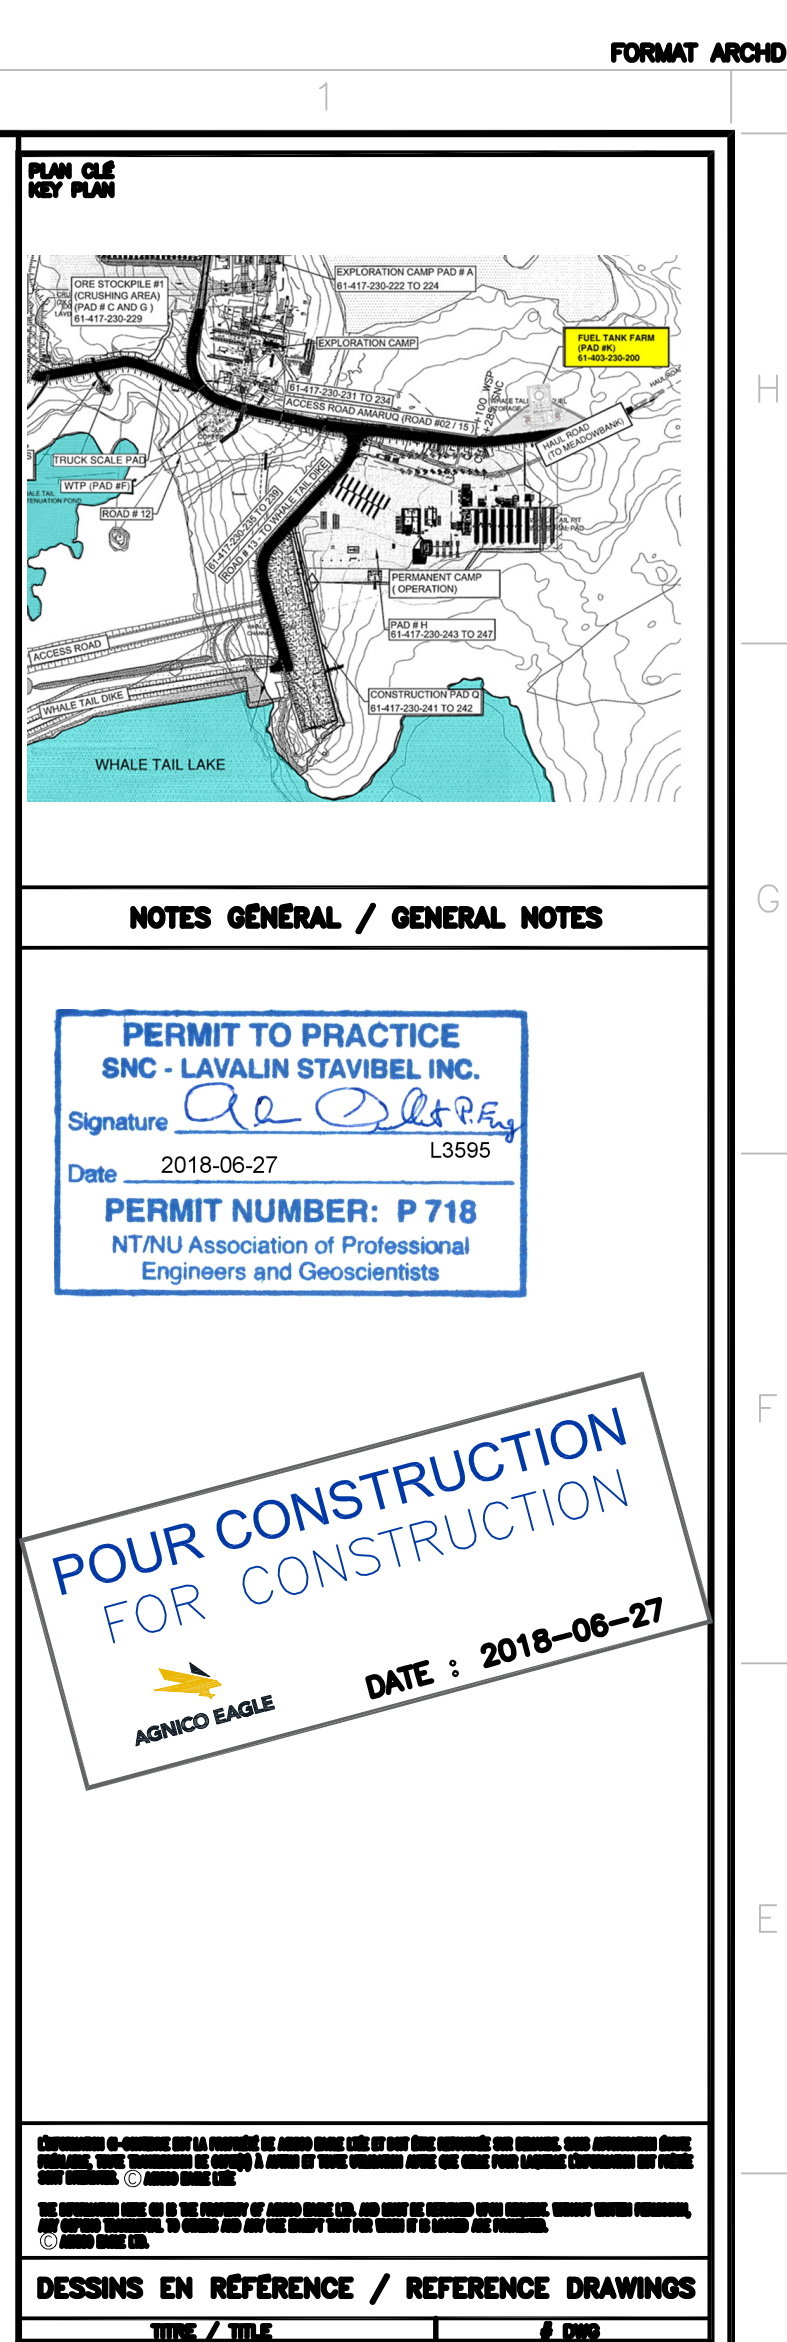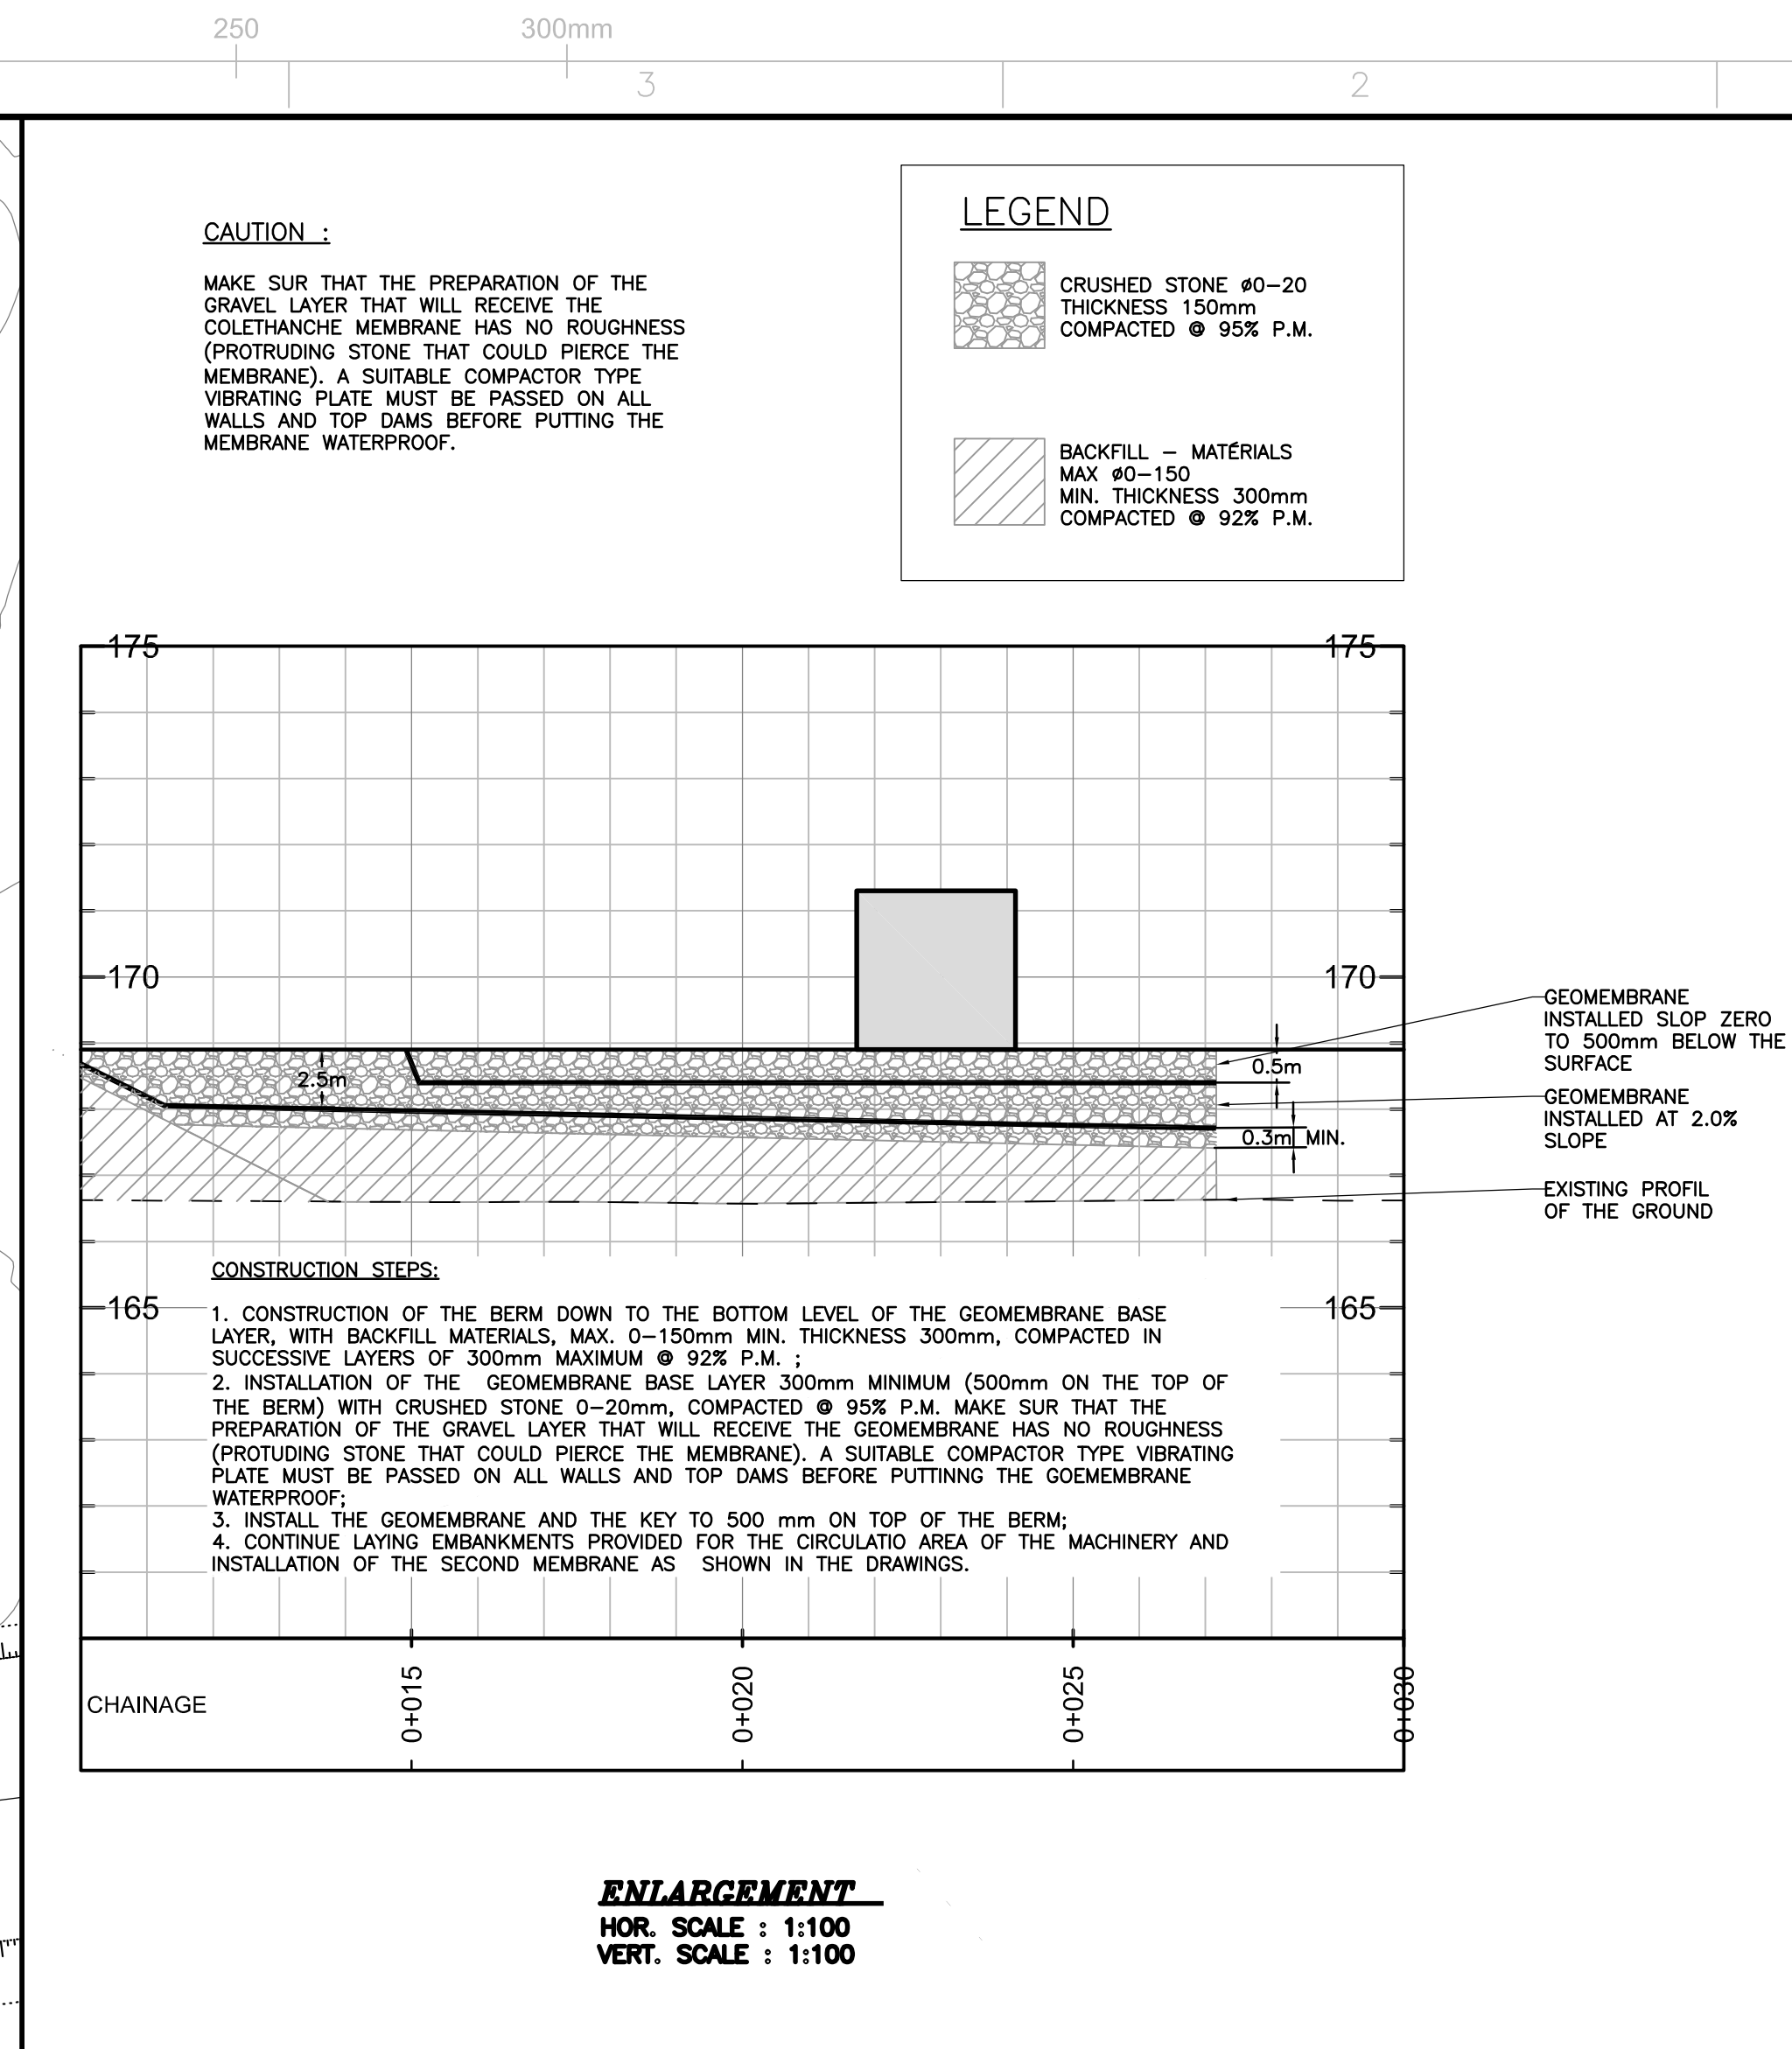

 

INC • LAVALIN


Project # : 644819-0000

DESSINS EN RÉFÉRENCE / REFERENCE DRAWING



0	2018-06-20	ISSUED FOR CONSTRUCTION	ST.M.	A.O.	D.
---	------------	-------------------------	-------	------	----

REV.	DATE	DESCRIPTION	PAR/BY	APP.	CLIE
------	------	-------------	--------	------	------

 

DESSINÉ PAR DRAWN BY	OTÉLIE MARCOTTE TECH	DATE 2010-09
-------------------------	----------------------	-----------------

DRAWN BY STEPHANE MARCOTTE, TECH. 2018-06-

VERIFIÉ PAR
CHECKED BY ROYANNE LAVOIE, Jr. ENG 2018-06

2010	55
------	----

APPROUVÉ PAR
APPROVED BY ALAIN OUELLET, P. ENG. 2018-06-

SOURCE	DATE	

ECHELLE SCALE	1:125	DATE	2018-05-11
------------------	-------	------	------------

NO. DESSIN	
------------	--

DRAWING NO. 61-403-270-232



01-405-270-252

NO. PROJET	REVISION	FEUILLE / S
------------	----------	-------------

PROJECT NO.		
G115	0	1 /

6115	0	/ 1
------	---	-----

 [illegible]

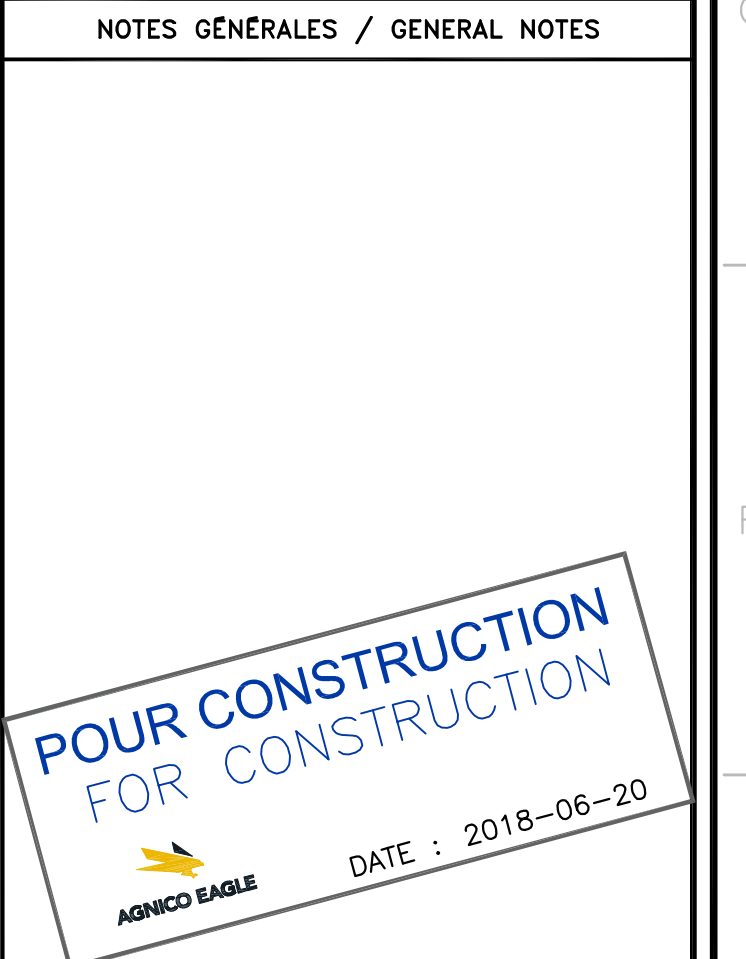

project # : 644819-0000

INFORMATION CONTAINED HEREON IS THE PROPERTY OF HONICO EAGLE LTD. AND MUST BE RETURNED UPON REQUEST. WITHOUT WRITTEN PERMISSION, NO INFORMATION CONTAINED HEREON IS TO BE DISCLOSED TO ANY OTHER PERSON OR ENTITY. ANY UNAUTHORIZED DISCLOSURE OR REPRODUCTION OF THIS INFORMATION IS PROHIBITED.

HONICO EAGLE LTD.

[illegible]

DESSINE PAR DRAWN BY	STÉPHANE MARCOTTE, TECH.	DATE 2018-06-18
VÉRIFIÉ PAR CHECKED BY	ROXANNE LAVOIE, Jr. ENG.	2018-06-19
APPROUVÉ PAR APPROVED BY	ALAIN OUELLET, P. ENG.	2018-06-19
ÉCHELLE SCALE	AS SHOWN	DATE 2018-05-11

1




NOTES:

1. UNLESS OTHERWISE INDICATED ALL CABLES ARE TECK90 1KV TYPE, WITH COPPER CONDUCTOR
2. IN CABLE TRAY, INSTALL THE CABLES WITH A SPACING OF A CABLE DIAMETER.
3. ALL METAL PIPES AND ALL NON-CURRENT CARRYING CONDUCTIVE MATERIALS PARTS OF FIXED OR PORTABLE OF ELECTRICAL EQUIPMENT SHALL BE BONDED TO GROUNDING SYSTEM.
4. BOND ALL STEEL STRUCTURES TO THE GROUNDING SYSTEM.



THE INFORMATION HERE ON IS THE PROPERTY OF AGNICO EAGLE LTD. AND MUST BE RETURNED UPON REQUEST, WITHOUT WRITTEN PERMISSION, ANY COPYING TRANSMITTAL TO OTHERS AND ANY USE EXCEPT THAT FOR WHICH IT IS LOANED ARE PROHIBITED.
 (C) AGNICO EAGLE LTD.

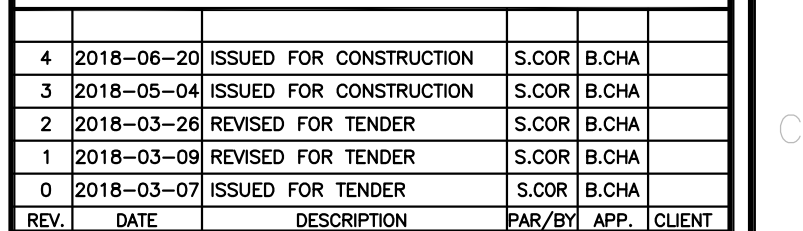[illegible]

DOCUMENT SIGNÉ NUMÉRIQUEMENT



TITLE / TITLE	
AGNICO EAGLE - AMARUQ	
403 - COMBUSTIBLES	
275 - POWER ELECTRICAL	
SINGLE LINE DIAGRAM	
600V DISTRIBUTION - FUEL TANK FARM	
ELECTRICAL SUBSTATION - 61SST40804	

DESSIN PAR DRAWN BY	DONALD PELLERIN, TECH.	DATE 2018-02-08
VERIFIÉ PAR CHECKED BY	BENOIT CHARTRAND P.ENG.	2018-02-08
APPROUVÉ PAR APPROVED BY	BENOIT CHARTRAND P.ENG.	2018-03-07
ÉCHELLE SCALE	1:1	DATE 2018-02-08

NO. DESSIN DRAWING NO.		
61-403-275-200		
NO. PROJET PROJECT NO.	REVISION	FEUILLE / SHT
	4	1 / 1
6115		

PERMIT TO PRACTICE
SNC - LAVALIN STAVIBEL INC.
 Signature [Signature]
 Date 2018-06-20
PERMIT NUMBER: P 718
 NT/NU Association of Professional
 Engineers and Geoscientists




POUR CONSTRUCTION
FOR CONSTRUCTION

AGNICO EAGLE

DATE : 2018-06-20




This technical drawing shows a side view of a mechanical assembly. On the left, there are two vertical pipes. A horizontal pipe runs across the middle, featuring a valve with a circular handle. To the right of this valve is a larger, more complex component, possibly a pump or a motor, with various pipes and fittings. A small rectangular box is labeled with the number '2'. The entire assembly is mounted on a base, and there are additional components on the right side, including what looks like a motor or a control unit.

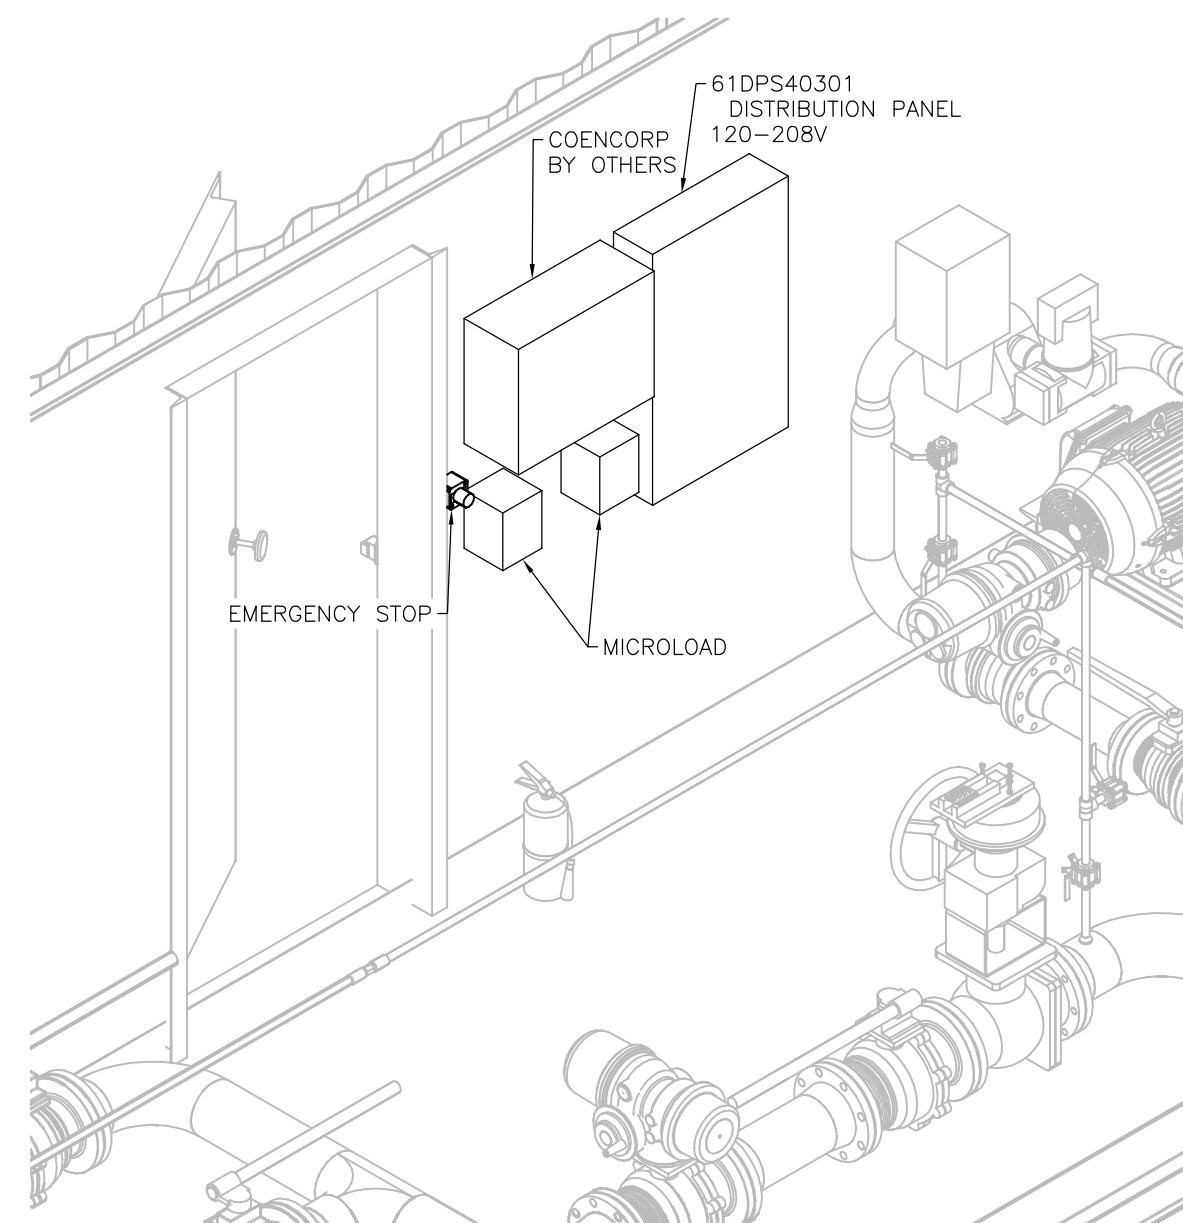


PERMIT TO PRACTICE
SNC - LAVALIN STAVIBEL INC.
Signature *[Signature]*
Date 2018-06-20
PERMIT NUMBER: P 718
NT/NU Association of Professional
Engineers and Geoscientists

NO. PROJ PROJECT NO.	REVISION	FEUILLE / SH
	2	1 / 1

FILE NO. 61-403-275-203_R0.dwg

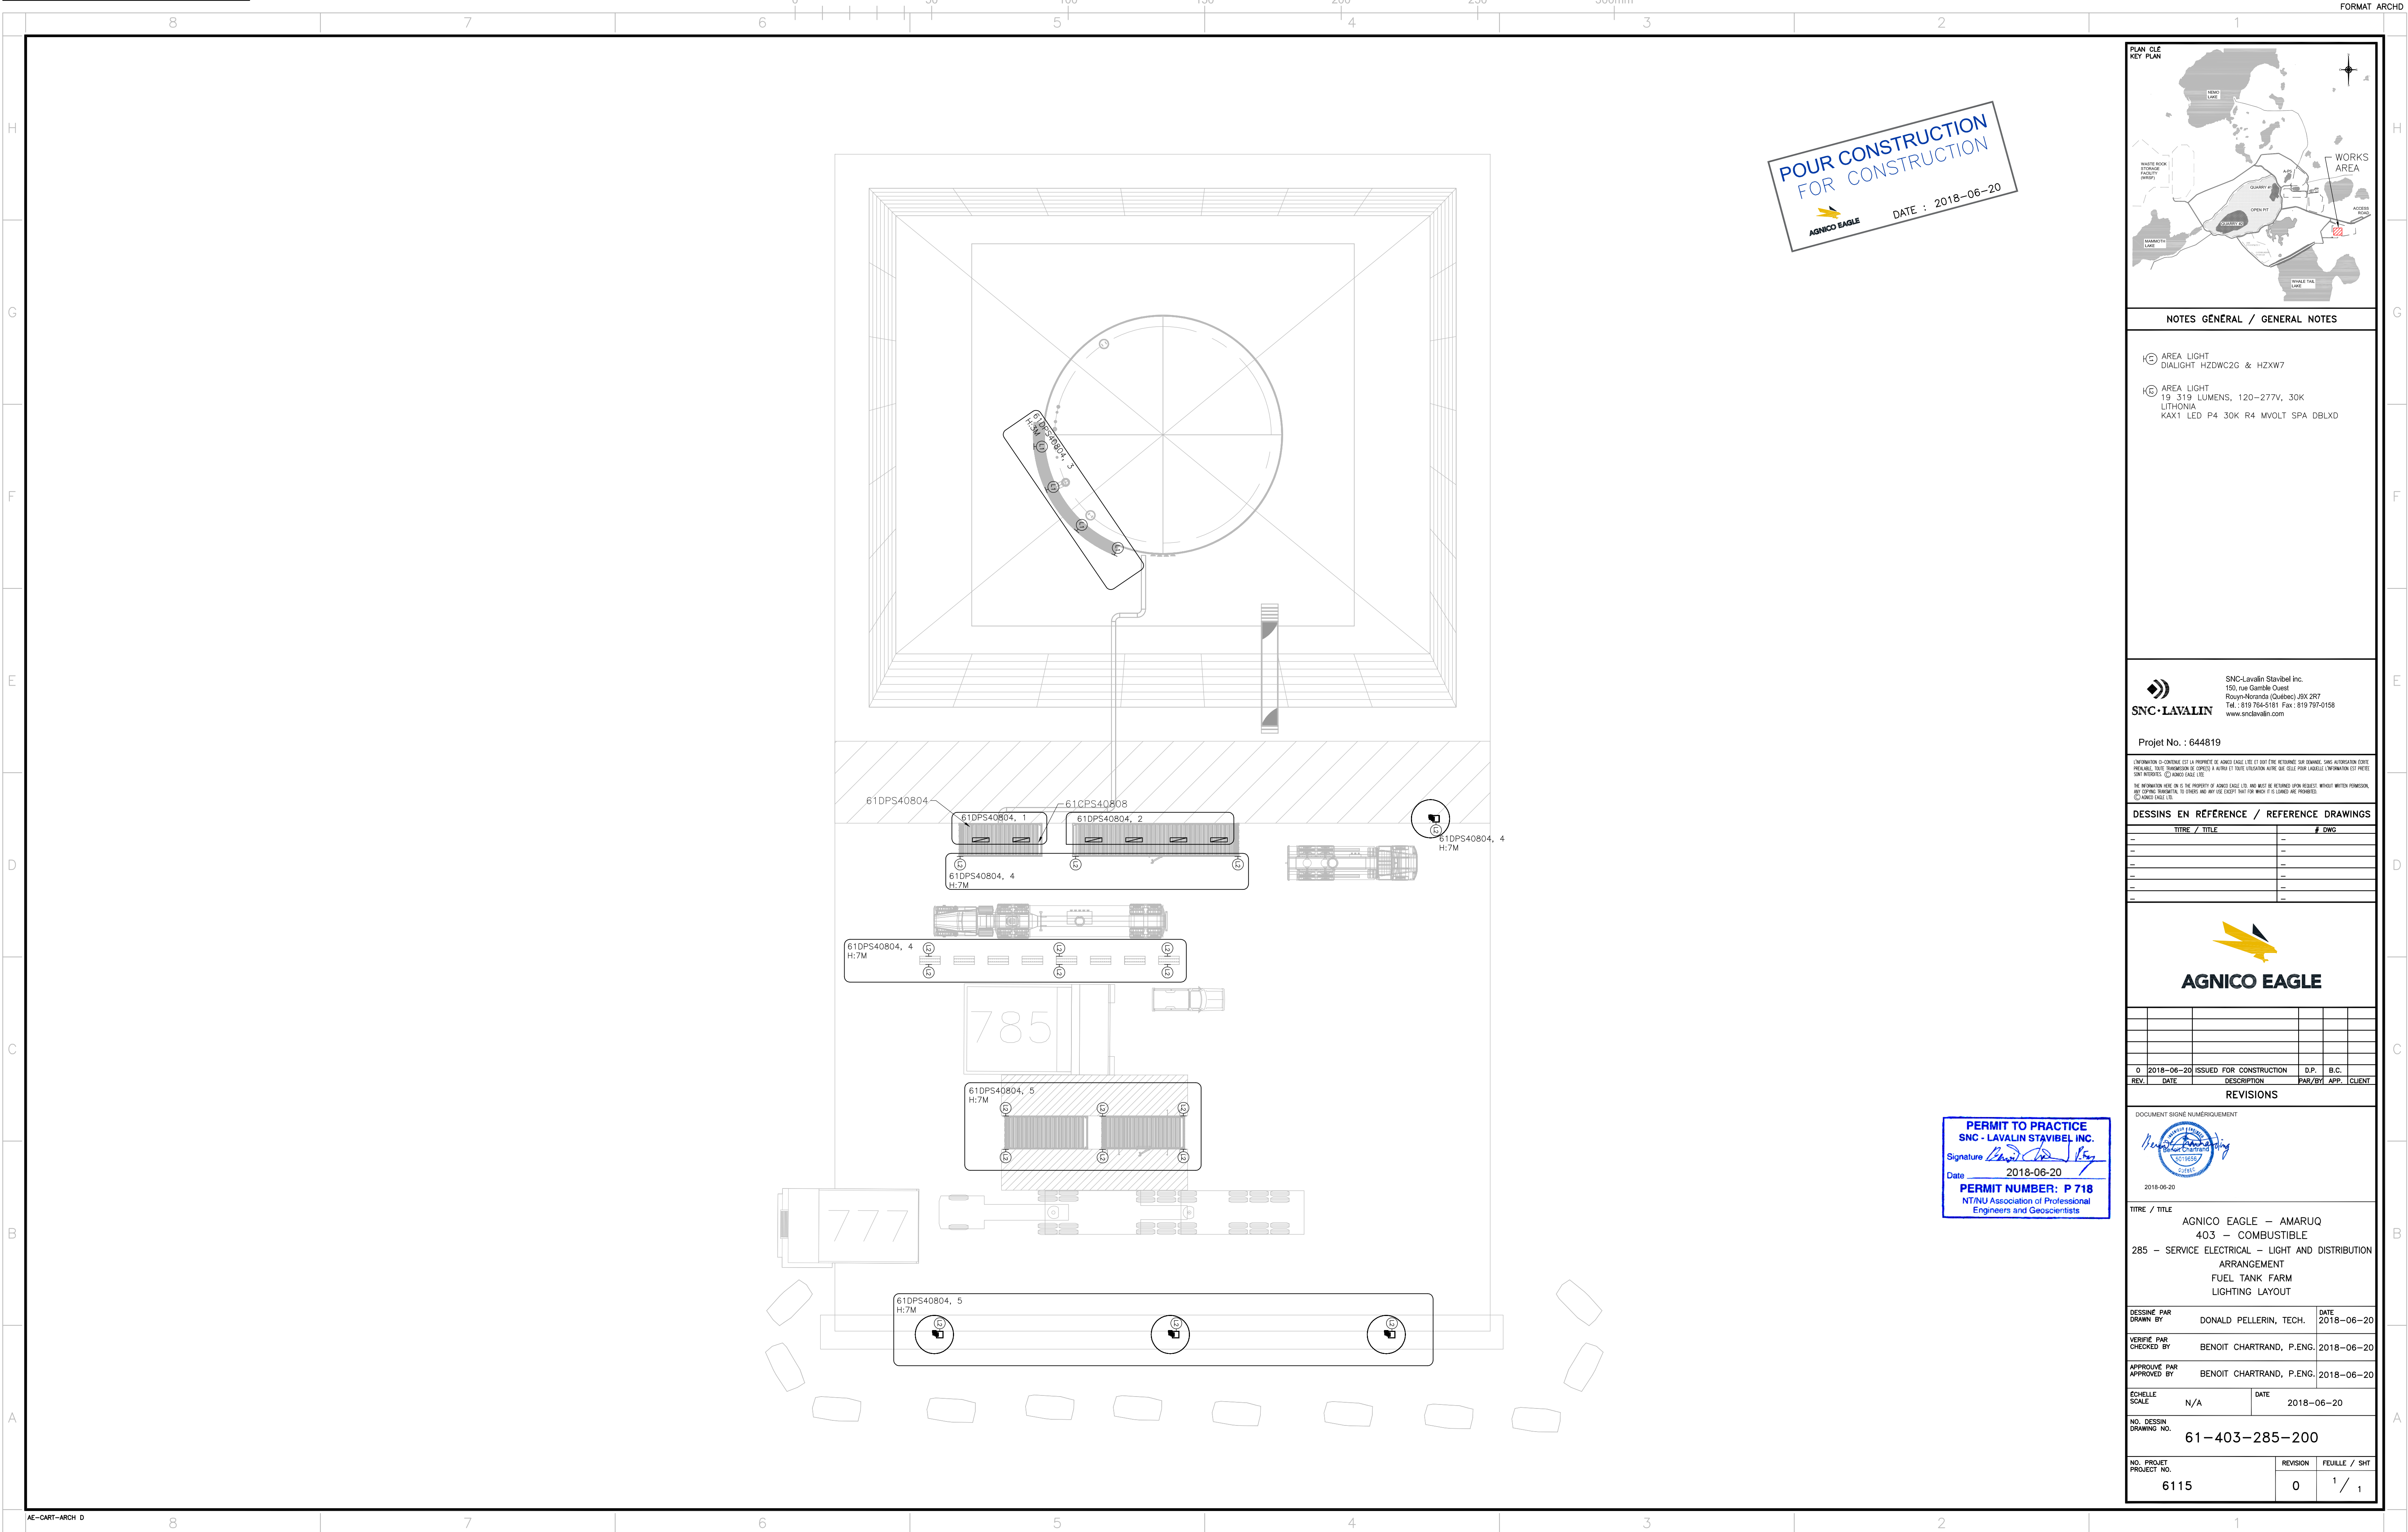

POUR CONSTRUCTION
FOR CONSTRUCTION
AGNICO EAGLE
DATE : 2018-06-20

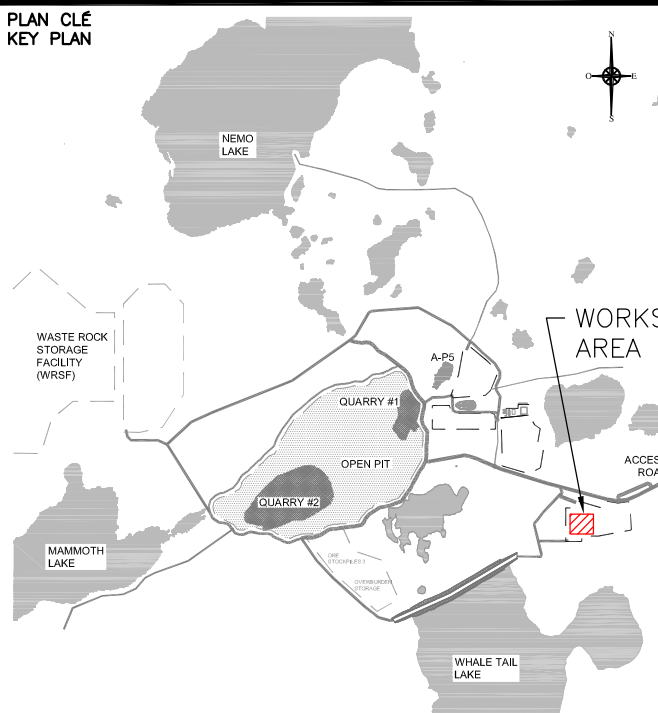

NOTES GÉNÉRAL / GENERAL NOTES

- Ⓢ AREA LIGHT
DIALIGHT HZDWC2G & HZXW7
- Ⓢ AREA LIGHT
19 319 LUMENS, 120-277V, 30K
LITHONIA
KAX1 LED P4 30K R4 MVOLT SPA DBLXD

SNC-LAVALIN
SNC-Lavalin Stavisbel inc.
150, rue Gamble Ouest
Roxbury-Noranda (Québec) J8X 2Z7
Tél. : 519 754-0161 Fax : 519 797-0158
www.snc-lavalin.com

Projet No. : 644819

L'INFORMATION CONTENUE EST LA PROPRIÉTÉ DE AGNICO EAGLE LTD. ET DOIT ÊTRE RETENUE SUR DEMANDE. SANS AUTORISATION ÉCRITE, REPRODUCTION, TRADUCTION OU COPIE À PARTIR DE TOUTE SITUATION AVEC DES DROITS AGNICO EAGLE LTD. SONT INTERDITS. © AGNICO EAGLE LTD.
ALL INFORMATION HEREIN IS THE PROPERTY OF AGNICO EAGLE LTD. AND MUST BE RETURNED UPON REQUEST. REPRODUCTION, TRANSLATION, OR COPYING WITHOUT WRITTEN PERMISSION OF AGNICO EAGLE LTD. IS PROHIBITED. © AGNICO EAGLE LTD.

DESSINS EN RÉFÉRENCE / REFERENCE DRAWINGS

TITRE / TITLE	# DWG
---	---
---	---
---	---
---	---
---	---
---	---



REV.	DATE	DESCRIPTION	PAR/ENI	APP.	CLIENT
------	------	-------------	---------	------	--------

REVISIONS

DOCUMENT SIGNÉ NUMÉRIQUEMENT

2018-06-20

TITRE / TITLE
AGNICO EAGLE - AMARUQ
403 - COMBUSTIBLE
285 - SERVICE ELECTRICAL - LIGHT AND DISTRIBUTION
ARRANGEMENT
FUEL TANK FARM
LIGHTING LAYOUT

DESSINE PAR
DRAWN BY DONALD PELLERIN, TECH. DATE 2018-06-20

VERIFIÉ PAR
CHECKED BY BENOIT CHARTRAND, P.ENG. 2018-06-20

APPROUVÉ PAR
APPROVED BY BENOIT CHARTRAND, P.ENG. 2018-06-20

ÉCHELLE
SCALE N/A DATE 2018-06-20

NO. DESSIN
DRAWING NO. 61-403-285-200

NO. PROJET PROJECT NO.	REVISION	FEUILLE / SHIT
6115	0	1 / 1

