
 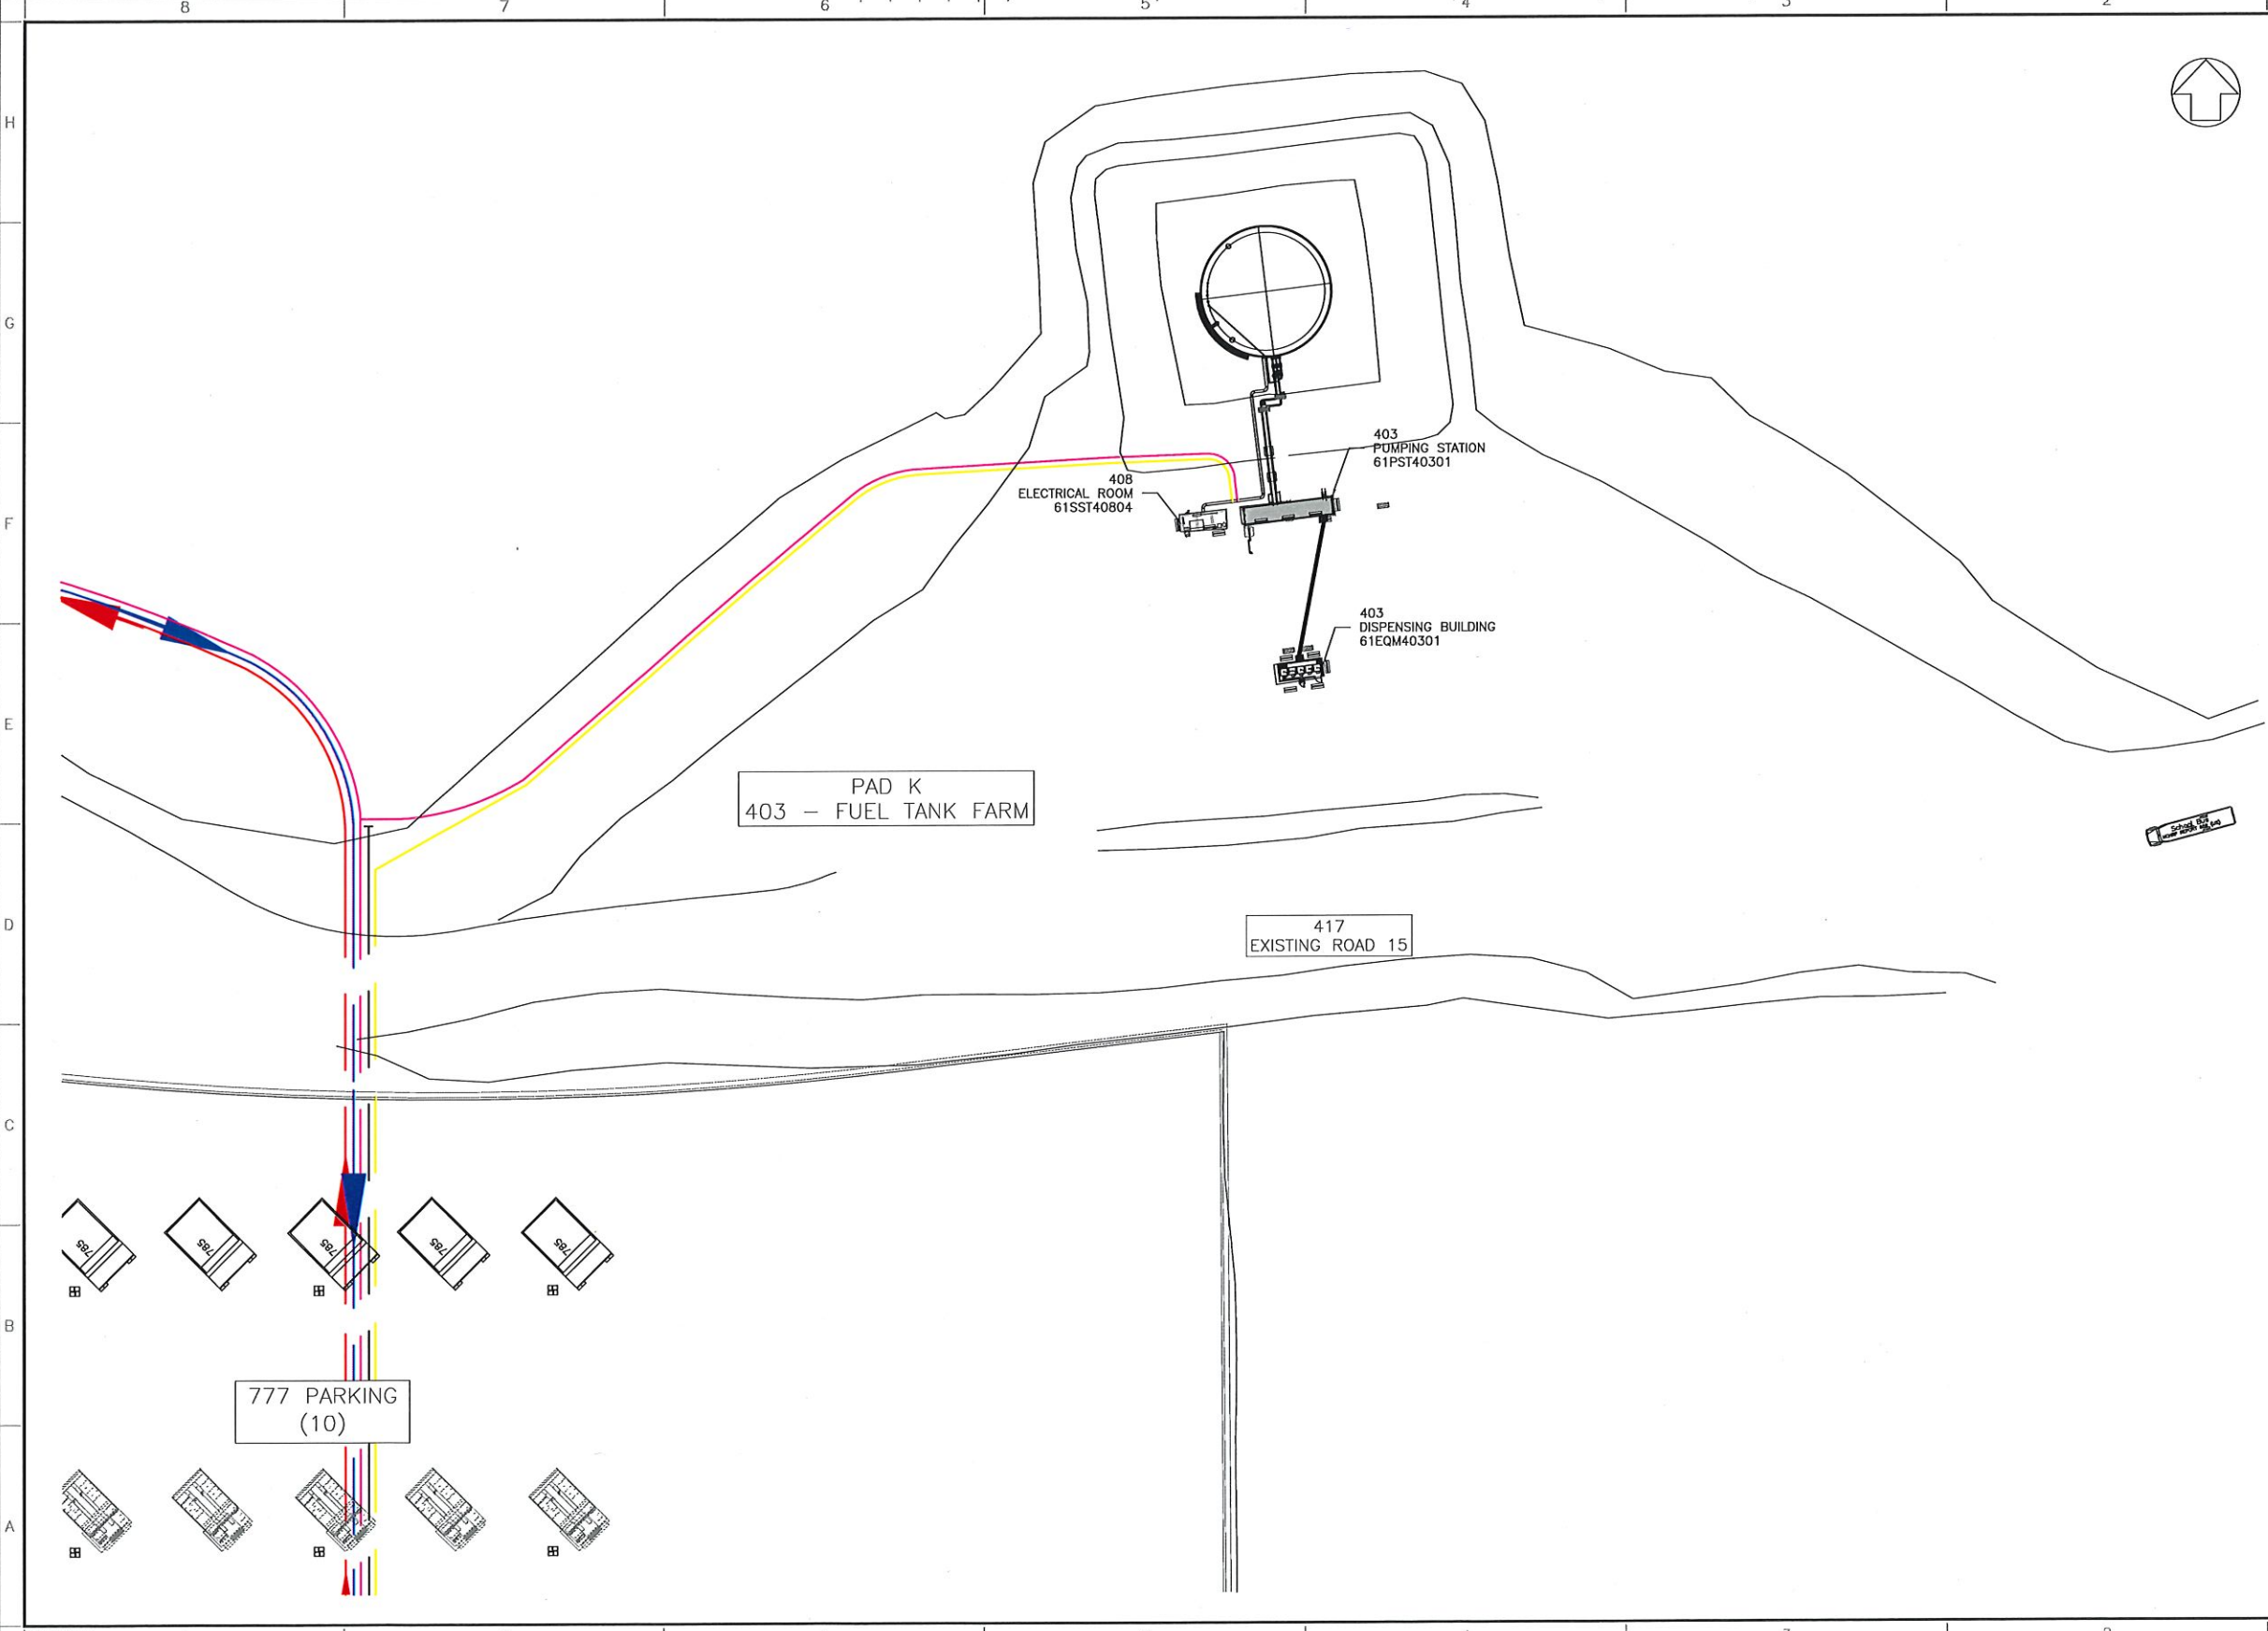




PLAN CLE
NOT PLAN

- NOTES GÉNÉRALES / GENERAL NOTES
- EXISTANT
 - NEW
 - FUTUR INFRASTRUCTURES FOR UNDERGROUND
 - CONSTRUCTION SEQUENCE
 - BUILDING NUMBER

**POUR CONSTRUCTION
FOR CONSTRUCTION**

AGNICO EAGLE DATE : 2018-07-16

LES PROJECTIONS 3-DIMENSIONNELLES DE LA PROJET DE CONSTRUCTION SONT SOUS-ENTENDUES. LES PROJECTIONS 2-DIMENSIONNELLES SONT SOUS-ENTENDUES. LES PROJECTIONS 1-DIMENSIONNELLES SONT SOUS-ENTENDUES. LES PROJECTIONS 0-DIMENSIONNELLES SONT SOUS-ENTENDUES.

DESSINS EN RÉFÉRENCE / REFERENCE DRAWINGS

NO.	TITRE / TITLE	#
1		
2		
3		
4		
5		
6		
7		
8		
9		
10		

AGNICO EAGLE

REV.	DATE	DESCRIPTION	PROJ.	REV.	APP.	CLIENT
0	2018-07-16	ISSUED FOR CONSTRUCTION	LAF.	D.L.	D.L.	

REVISIONS

AMARUQ PROJECT

TITRE / TITLE
AGNICO EAGLE - MEADOWBANK DIVISION
400 - SURFACE FACILITIES - AMARUQ
210 - G.A.
PLAN
INDUSTRIAL SITE ACCOMMODATION CAMP DETAIL
WHALE TAIL PIT

DESSINÉ PAR
DRAWN BY L. R. FRENETTE DATE 2018-07-16

VÉRIFIÉ PAR
CHECKED BY D. LAFLAMME 2018-07-16

APPROUVÉ PAR
APPROVED BY D. LAFLAMME 2018-07-16

ÉCHELLE
SCALE N/A DATE 2017-09-20



NO. DESIGN
DRAWING NO. 6115-400-210-002

NO. PROJECT
PROJECT NO. 6115 REVISION 0 FEUILLE / SHEET - / -



- 11 EMERGENCY STOP
- 12 61TNK40301 HIGH LEVEL ALARM
- 13 SYSTEM FAULT

TEL QUE CONSTRUIT
AS BUILT
DATE : 2019-10-03
AGNICO EAGLE

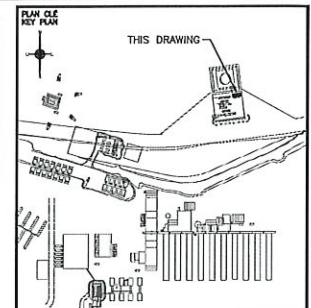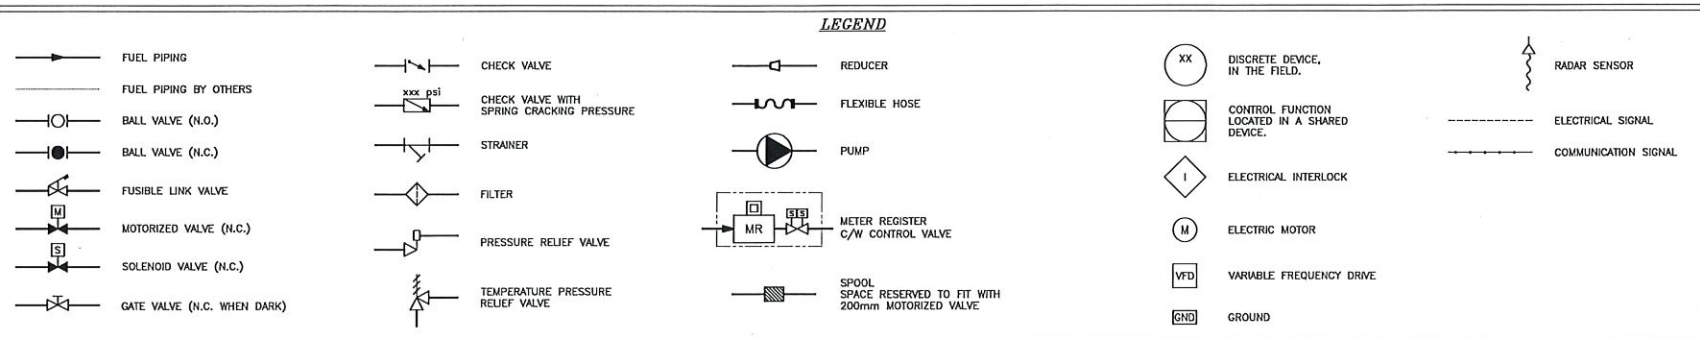

NOTES GÉNÉRALES / GENERAL NOTES

- NOTE FOR SUPPLY PIPING CONTRACTOR
(LOT # 6115-S-270-004-SOW-001)
- INDOOR PIPING, SOLENOID VALVES AND INSTRUMENTS ARE EXCLUDED.
 - PROVIDE ALL OUTSIDE PIPING (ABOVE AND UNDERGROUND), VALVES, FITTING AND OTHER ACCESSORIES.
 - OUTDOOR MOTORIZED VALVES ARE EXCLUDED.
- NOTE FOR BUILDING CONTRACTOR
(LOT # 6115-S-265-011-SOW-001)



Project # : 644819-0000

AGNICO EAGLE

DESSINS EN RÉFÉRENCE / REFERENCE DRAWINGS

NO.	TITLE / TITRE	REV.
1	FUEL DISTRIBUTION DIAGRAM	61-403-200-202
2	FUEL DISPENSING BUILDINGS	61-403-205-208



NO.	DATE	DESCRIPTION	FOR/REV.	APP. / CLERK
1	2019-05-31	ISSUED FOR CONSTRUCTION	P.D.C.	B.C.
2	2019-06-14	ISSUED FOR CONSTRUCTION	D.L.L.	A.A./A.
3	2019-06-20	ISSUED FOR CONSTRUCTION	D.L.L.	A.A.
4	2019-06-20	ISSUED FOR CONSTRUCTION	D.L.L.	A.A.
5	2019-06-20	ISSUED FOR CONSTRUCTION	D.L.L.	A.A.
6	2019-06-20	ISSUED FOR CONSTRUCTION	D.L.L.	A.A.
7	2019-06-20	ISSUED FOR CONSTRUCTION	D.L.L.	A.A.
8	2019-06-20	ISSUED FOR CONSTRUCTION	D.L.L.	A.A.
9	2019-06-20	ISSUED FOR CONSTRUCTION	D.L.L.	A.A.
10	2019-06-20	ISSUED FOR CONSTRUCTION	D.L.L.	A.A.

REVISIONS




TITLE / TITRE
AGNICO EAGLE - WHALE TAIL (AMARUQ)
403 - COMBUSTIBLE
205 - P&ID
P&ID
FUEL TANK FARM
PUMPING STATION

DESIGNER / CONCEPTEUR	STÉPHANE MARCOTTE, TECH.	DATE	2018-05-14
DRAWN BY	DONALD PELLERIN, TECH.		
CHECKED BY	MICHEL FOURNIER, TECH.		
APPROVED BY	BENOIT CHARTRAND, P.ENG.		
APPROVED BY	ALAIN OUELLET, P.ENG.		
APPROVED BY	BENOIT CHARTRAND, P.ENG.		

NO. DESIGN
DRAWING NO. 61-403-205-207

NO. PROJECT	REVISION	FEUILLE / SHEET
6115	6	1 / 1

TEL QUE CONSTRUIT
AS BUILT
AGNICO EAGLE
DATE : 2019-10-03

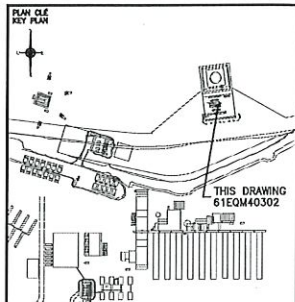

NOTES GÉNÉRALES / GENERAL NOTES

NOTE FOR SUPPLY PIPING CONTRACTOR
(LOT # 6115-S-270-004-SOW-001)

1-INSTRUMENTS ARE EXCLUDED.

NOTE FOR BUILDING CONTRACTOR
(LOT # 6115-S-285-011-SOW-001)

1-LOCALISATIONS OF ORIFICE PLATES SHOULD BE COORDINATED WITH CONTRACTOR.

SNC-LAVALIN
SNC-Lavalin Stabilité Inc.
150, rue Gaudet Ouest
Rivière-Rouge (Québec) J8K 2P7
Tel: 514 737-0181 Fax: 514 737-0155
www.snc-lavalin.com

Project #: 644819-0000


CONTRACTOR IS ADVISED THAT THE PROJECT IS SUBJECT TO THE FOLLOWING CONDITIONS: THE CONTRACTOR SHALL BE RESPONSIBLE FOR THE DESIGN AND CONSTRUCTION OF THE PROJECT. THE CONTRACTOR SHALL BE RESPONSIBLE FOR THE DESIGN AND CONSTRUCTION OF THE PROJECT. THE CONTRACTOR SHALL BE RESPONSIBLE FOR THE DESIGN AND CONSTRUCTION OF THE PROJECT.

DESSINS EN RÉFÉRENCE / REFERENCE DRAWINGS

NO.	TITLE / TITRE	REV.
1	FUEL DISTRIBUTION DIAGRAM	61-403-200-202
2	PUMPING STATION	61-403-205-207
3		
4		
5		

AGNICO EAGLE

REV.	DATE	DESCRIPTION	BY	APP.	CLIENT
1	2019-10-03	AS BUILT	S.M.	S.A.	
2	2019-05-17	ISSUED FOR CONSTRUCTION	P.O.C.	A.G.	M.A.B.
3	2018-05-17	ISSUED FOR CONSTRUCTION	D.L.L.	A.G.	D.L.
4	2018-05-17	ISSUED FOR CONSTRUCTION	D.L.L.	A.G.	D.L.
5	2018-05-17	ISSUED FOR CONSTRUCTION	D.L.L.	A.G.	D.L.
6	2018-05-17	ISSUED FOR CONSTRUCTION	D.L.L.	A.G.	D.L.

 

TITLE / TITRE
AGNICO EAGLE - WHALE TAIL (AMARUQ)
403 - COMBUSTIBLE
205 - PAID
FUEL TANK FARM
FUEL DISPENSING BUILDINGS

DESIGNED BY	STÉPHANE MARCOTTE, TECH.	DATE	2018-05-11
CHECKED BY	DONALD PELLERIN, TECH.		
APPROVED BY	MICHEL FOURNIER, TECH.	DATE	2018-05-17
	BENOIT CHARTRAND, P.ENG.		
	ALAIN OUELLET, P.ENG.	DATE	2018-05-17
	BENOIT CHARTRAND, P.ENG.		

EDVILLE SCALE N/A DATE 2018-05-11

NO. DESIGN
DRAWING NO. 61-403-205-208

NO. PROJECT	REVISION	FEUILLE / SHEET
6115	5	1 / 1

61PST40301
PUMPING STATION
61-403-205-207

BY SUPPLY PIPING CONTRACTOR BY BUILDING CONTRACTOR

BY SUPPLY PIPING CONTRACTOR BY BUILDING CONTRACTOR

LEGEND

	FUEL PIPING
	SECONDARY LINE - OVER PRESSURE
	INSTRUMENTATION SIGNAL
	CAP
	BALL VALVE (N.O.)
	BALL VALVE (N.C.)
	FUSIBLE LINK VALVE
	SOLENOID VALVE
	TEMPERATURE PRESSURE RELIEF VALVE
	REDUCER
	FLEXIBLE HOSE
	BREAKAWAY COUPLING
	BUILDING SHEAR VALVE
	ORIFICE PLATE
	GLOBE VALVE
	METER REGISTER
	TRANSITION BOX

ONE(1) SPARE UNDERGROUND PIPING THREADED END CAP
2x #50mm UNDERGROUND PIPING DOUBLE WALL

