



H337697-4630-05-030-0003

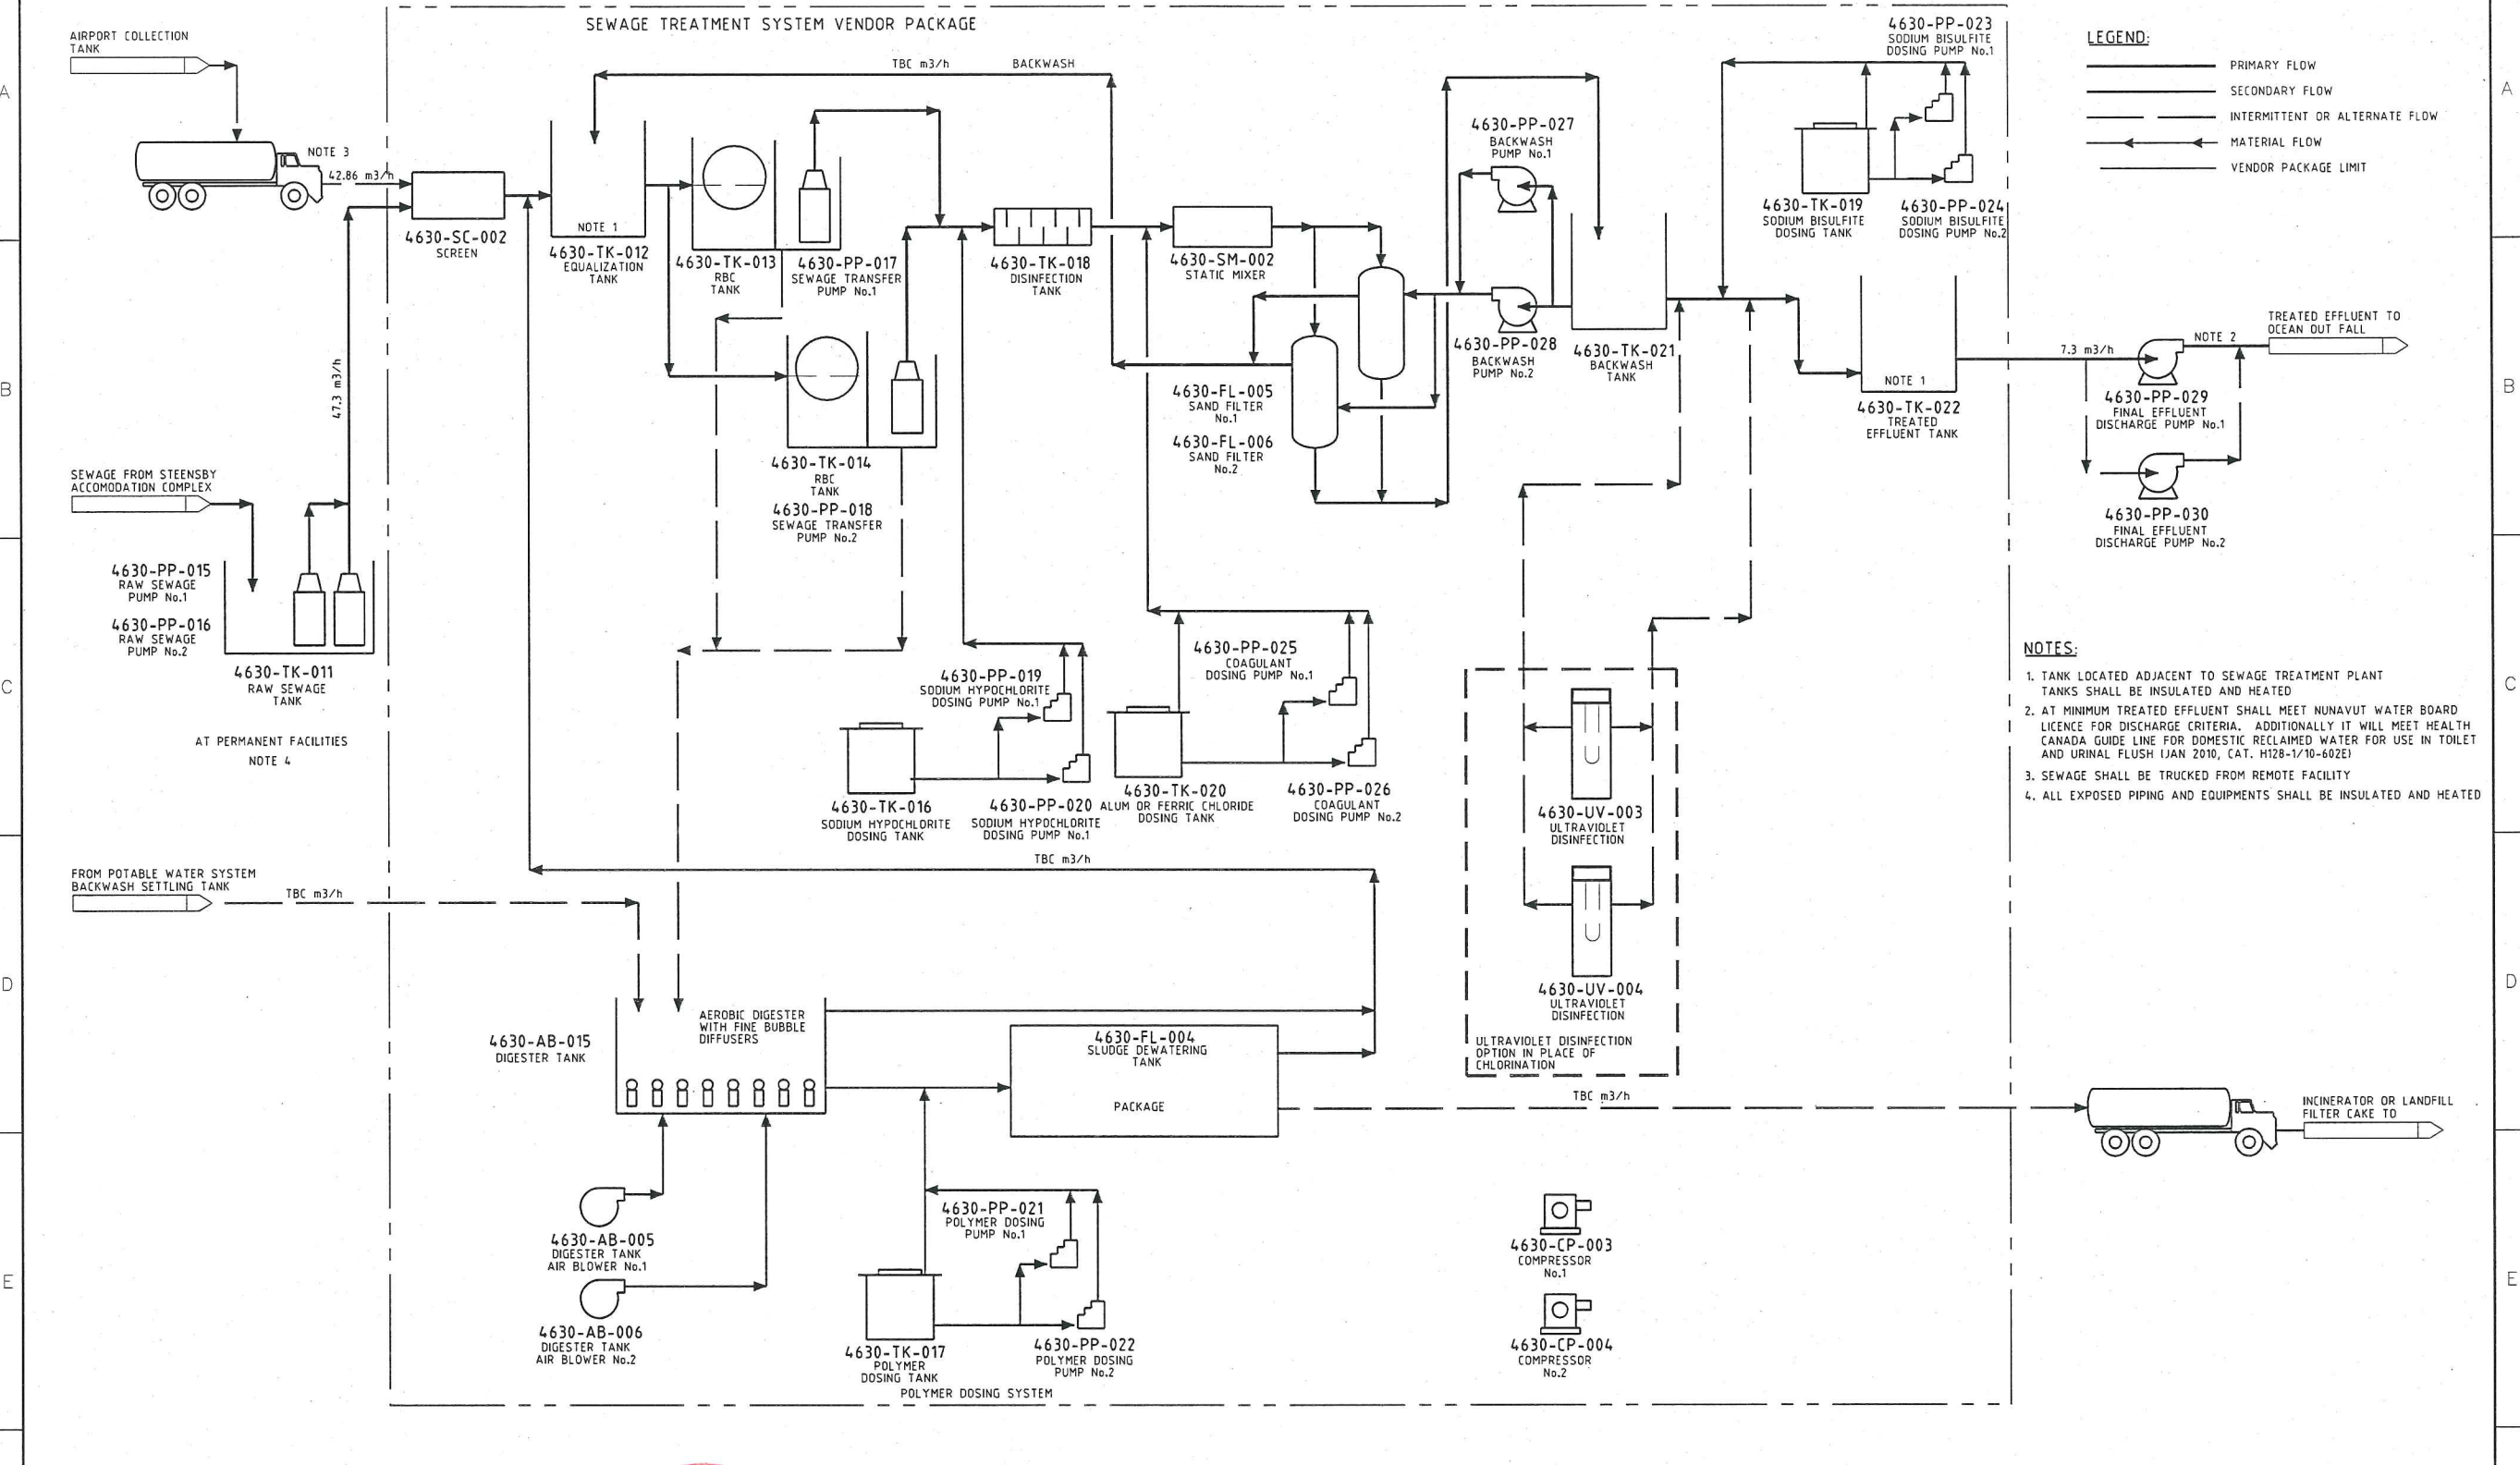

																		
													PROCESS FLOW DIAGRAM					
													STEENSBY (PORT) SEWAGE TREATMENT PLANT RBC BASED SYSTEM					
DRAWING NO.		DRAWING TITLE		B CHANGES FROM INTERNAL REVIEW		RR	RK	AZ	9/6/2011	B ENVIRONMENTAL PERMIT		RK	AZ	9/6/2011	DESIGNED BY R. KAPADIA DATE 2011-08-03		DRAWN BY J. FESAR DATE 2011-08-02	
				A INTERNAL REVIEW		JF	RK	AZ	8/24/2011	A INTERNAL REVIEW		RK	AZ	8/24/2011	CHECKED BY R. KAPADIA DATE 2011-08-24		DISCIP. ENGR. A. ZLATIC DATE	
				NO. DESCRIPTION		BY	CHK'D	APP'D	DATE	REV. ISSUE FOR		AUTH. BY	DATE	PROJ. DES. COORD. H. CHARALAMBU DATE		PROJ. ENGR. J. CASSON DATE		

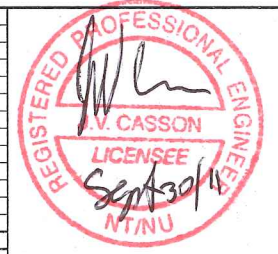

PROCESS FLOW DIAGRAM
STEENSBY (PORT)
SEWAGE TREATMENT PLANT
RBC BASED SYSTEM