


GOVERNMENT OF NUNAVUT

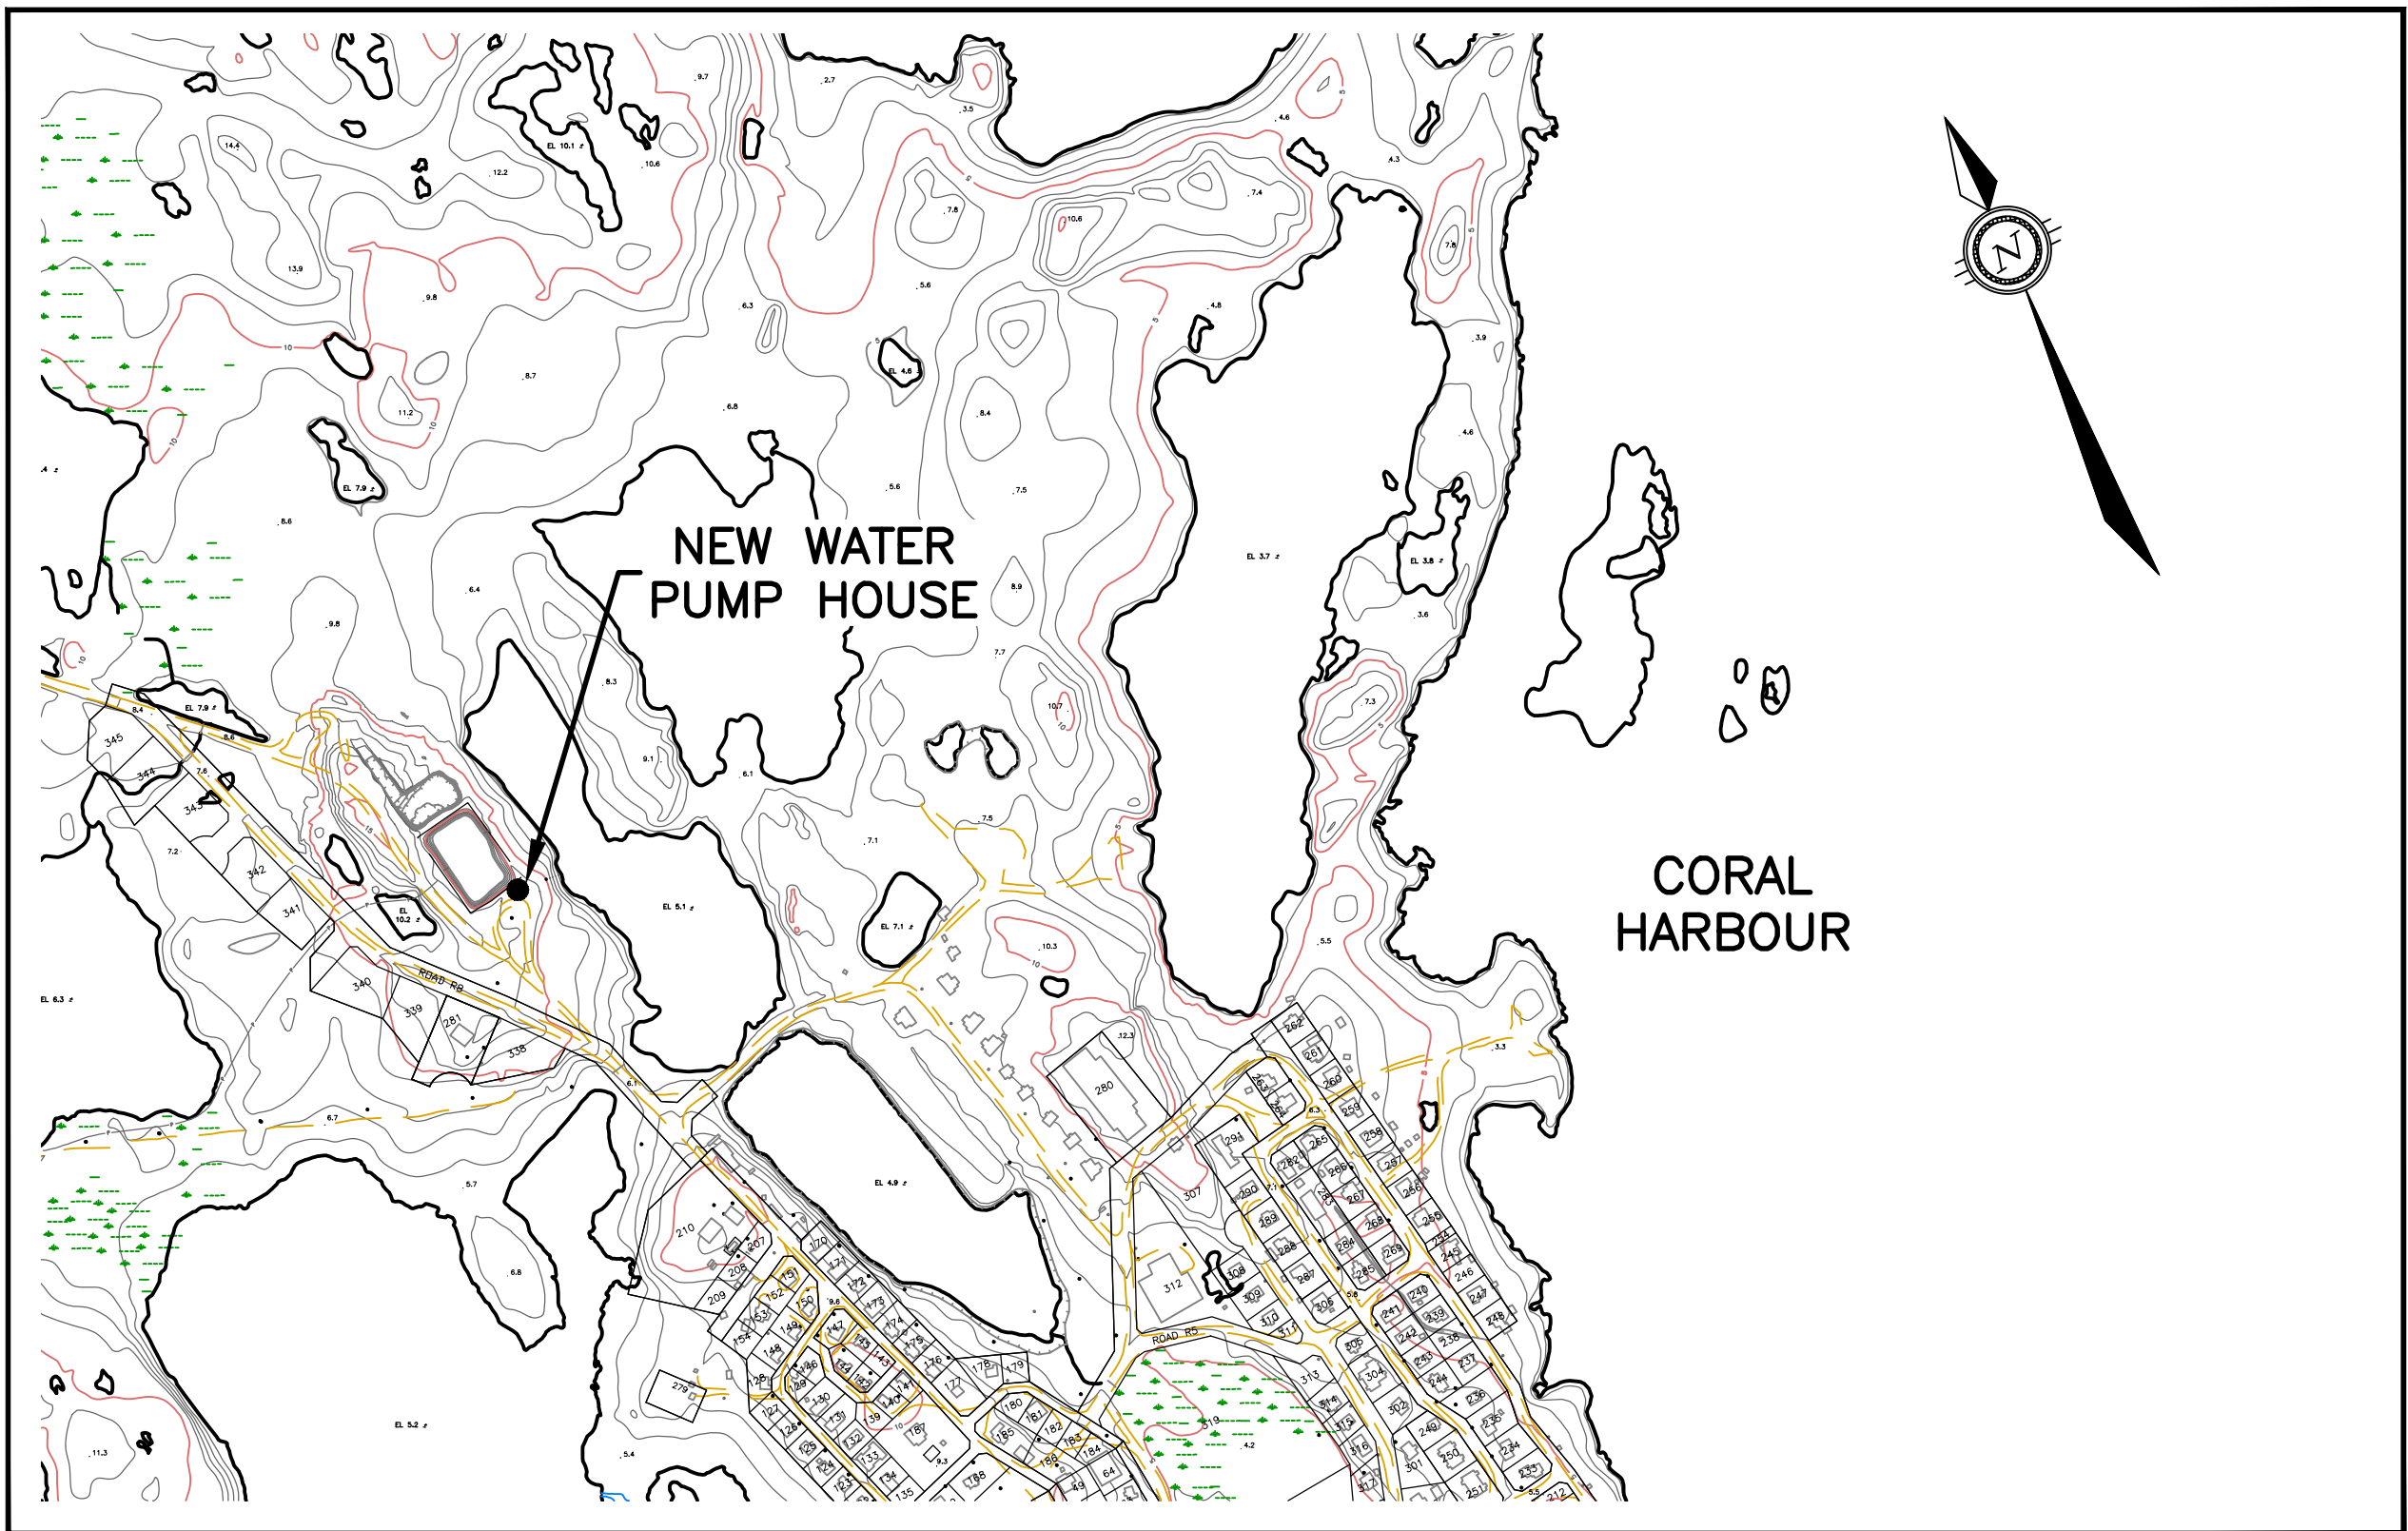

ISSUED FOR
CONSTRUCTION
DATE: MAY 16, 2016

INDEX OF INCLUDED DRAWINGS

DRAWING NO.	REVISION	DESCRIPTION
		COVER
OTT-00203694A-C1	REV 3	SITE PLAN
OTT-00203694A-C2	REV 3	PLAN & PROFILE
OTT-00203694A-C3	REV 3	DETAILS
OTT-00203694A-C4	REV 3	DETAILS
OTT-00203694A-S1	REV 3	GROUND FLOOR PLAN AND GENERAL NOTES
OTT-00203694A-S2	REV 3	FOUNDATION PLAN, ROOF PLAN AND DETAILS
OTT-00203694A-S3	REV 3	BUILDING ELEVATIONS AND FILL PIPE DETAILS
OTT-00203694A-S4	REV 3	SECTIONS
OTT-00203694A-S5	REV 3	SECTIONS
8011-116-M100	REV 1	MECHANICAL LEGEND AND DRAWING LIST
8011-116-M101	REV 1	MECHANICAL DETAILS
8011-116-M200	REV 1	MECHANICAL PLUMBING LAYOUT
8011-116-M201	REV 1	MECHANICAL PLUMBING LAYOUT
8011-116-M202	REV 1	MECHANICAL PLUMBING SCHEMATIC
8011-116-M300	REV 1	MECHANICAL FUEL SYSTEM LAYOUT
8011-116-M301	REV 1	MECHANICAL FUEL SYSTEM SCHEMATIC & NORTH ELEVATION
8011-116-M500	REV 1	MECHANICAL VENTILATION LAYOUT
8011-116-M600	REV 1	MECHANICAL CONTROLS SCHEMATICS
8011-116-M601	REV 1	MECHANICAL CONTROLS SCHEMATICS
8011-116-M602	REV 1	MECHANICAL CONTROLS SCHEMATICS
8011-116-E1	REV 1	ELECTRICAL NEW POWER AND LIGHTING LAYOUT
8011-116-E2	REV 1	ELECTRICAL SINGLE LINE DIAGRAM
8011-116-E3	REV 1	ELECTRICAL GROUNDING LAYOUT AND DETAILS

CORAL HARBOUR NEW WATER PUMP HOUSE PROJECT 11-3018



exp Services Inc.
t: +1.613.688.1899 | f: +1.613.225.7337
2650 Queensview Drive, Suite 100
Ottawa, ON K2B 8H6
Canada

www.exp.com

• BUILDINGS • EARTH & ENVIRONMENT • ENERGY •
• INDUSTRIAL • INFRASTRUCTURE • SUSTAINABILITY •