



ET:55524/Cadd FileA1-PROJ-SHT.dwg/Last Edit: 2004-04-06 (17:00)/Plot Scale: 1:1 (A1)


PLUMBING

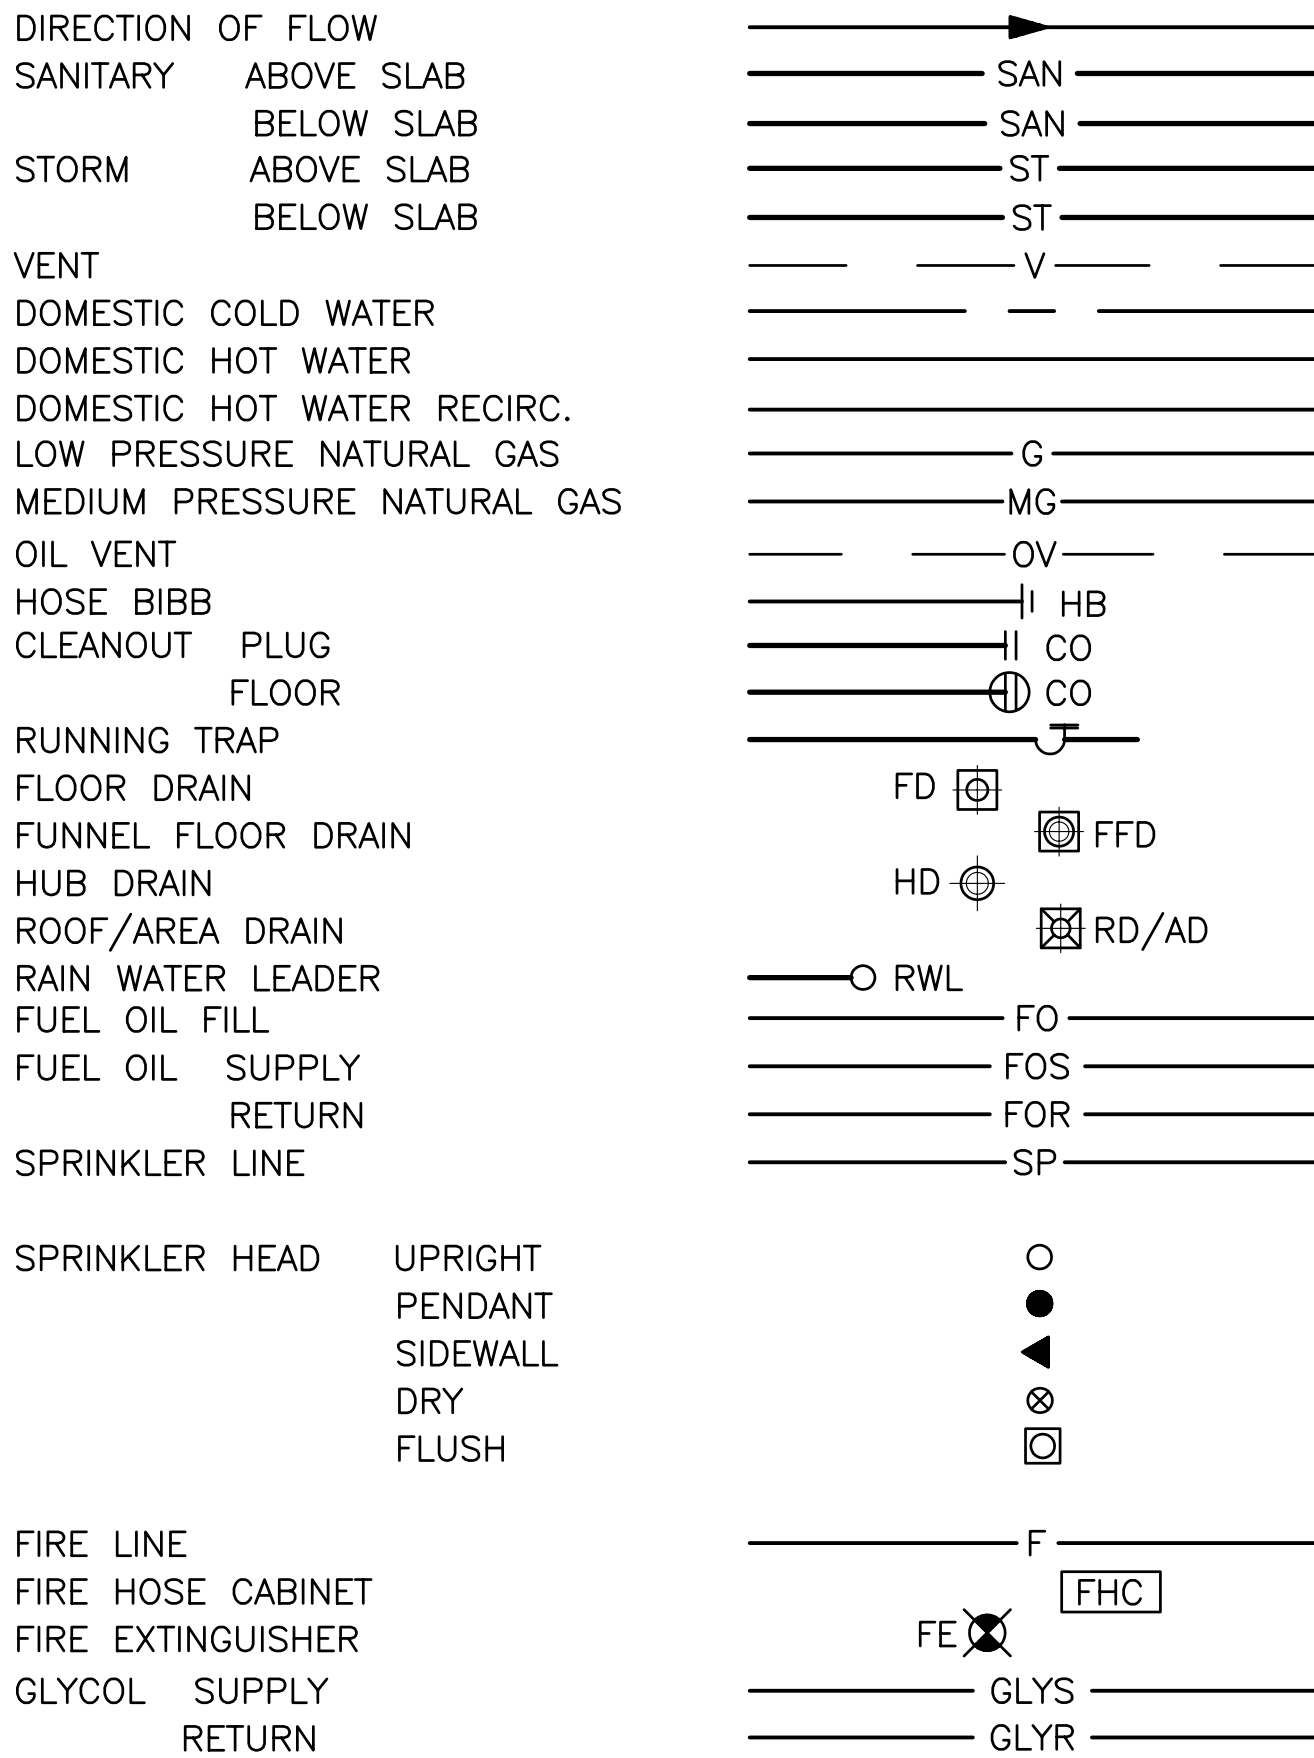


PLUMBING FIXTURE TAG

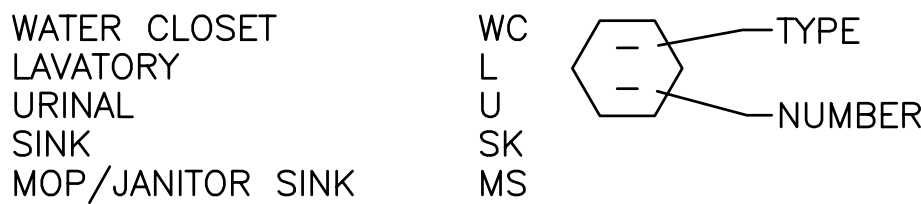


EQUIPMENT FIXTURE TAG

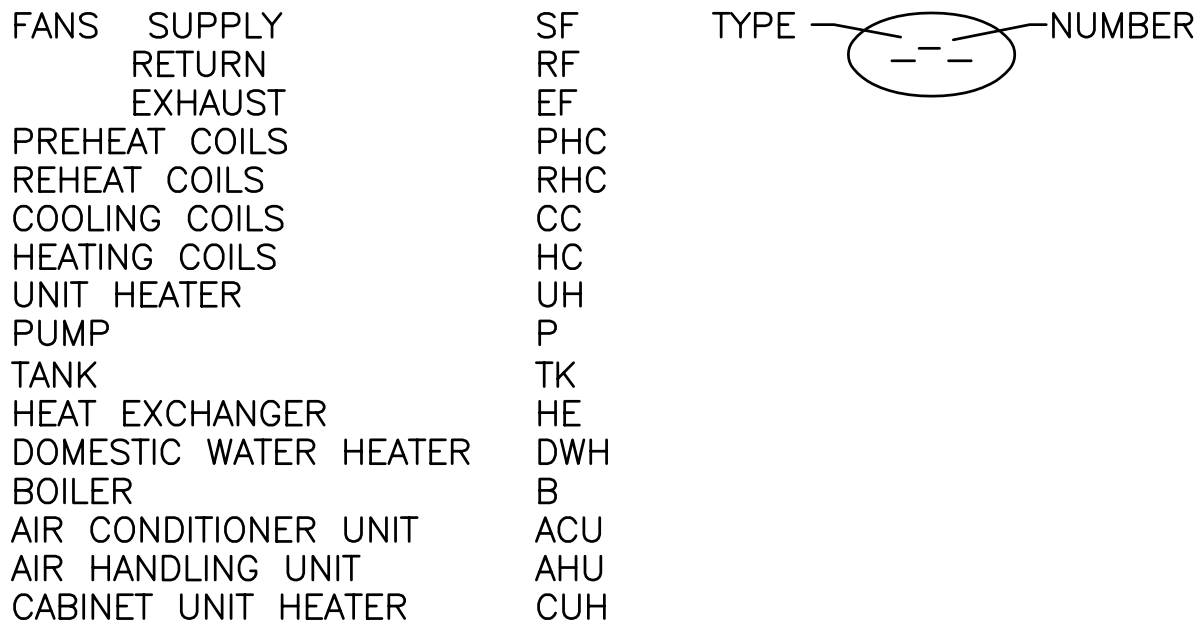


PIPE FITTINGS

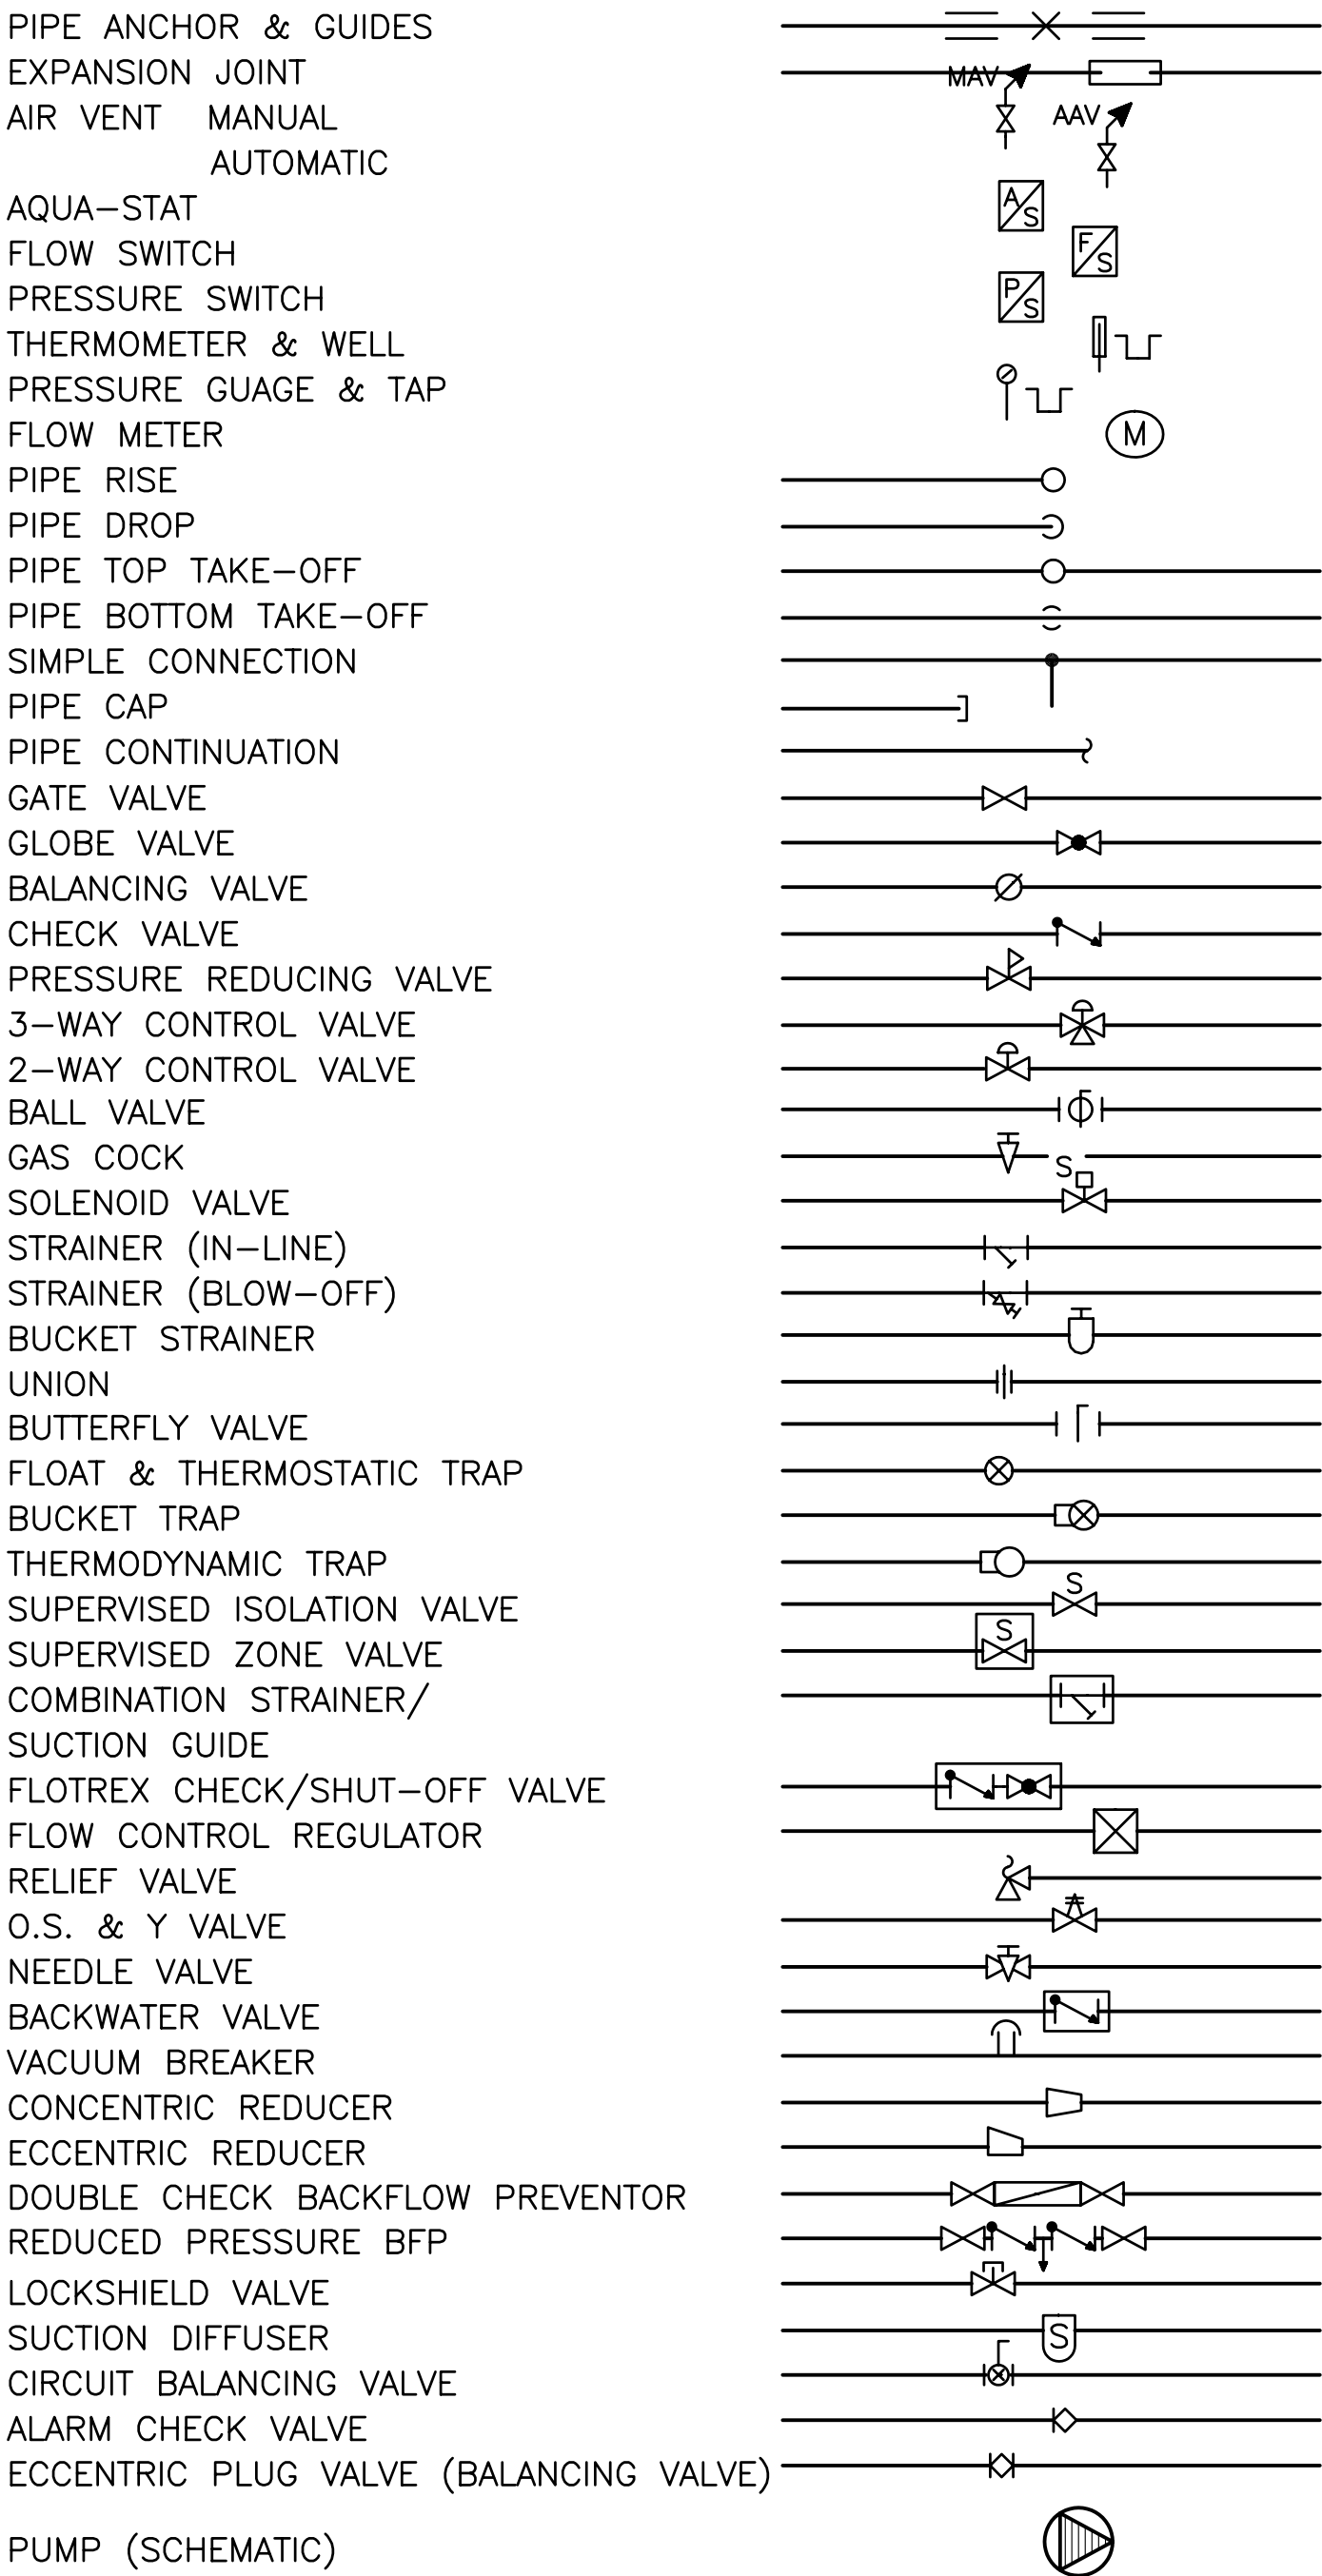


AIR DISTRIBUTION

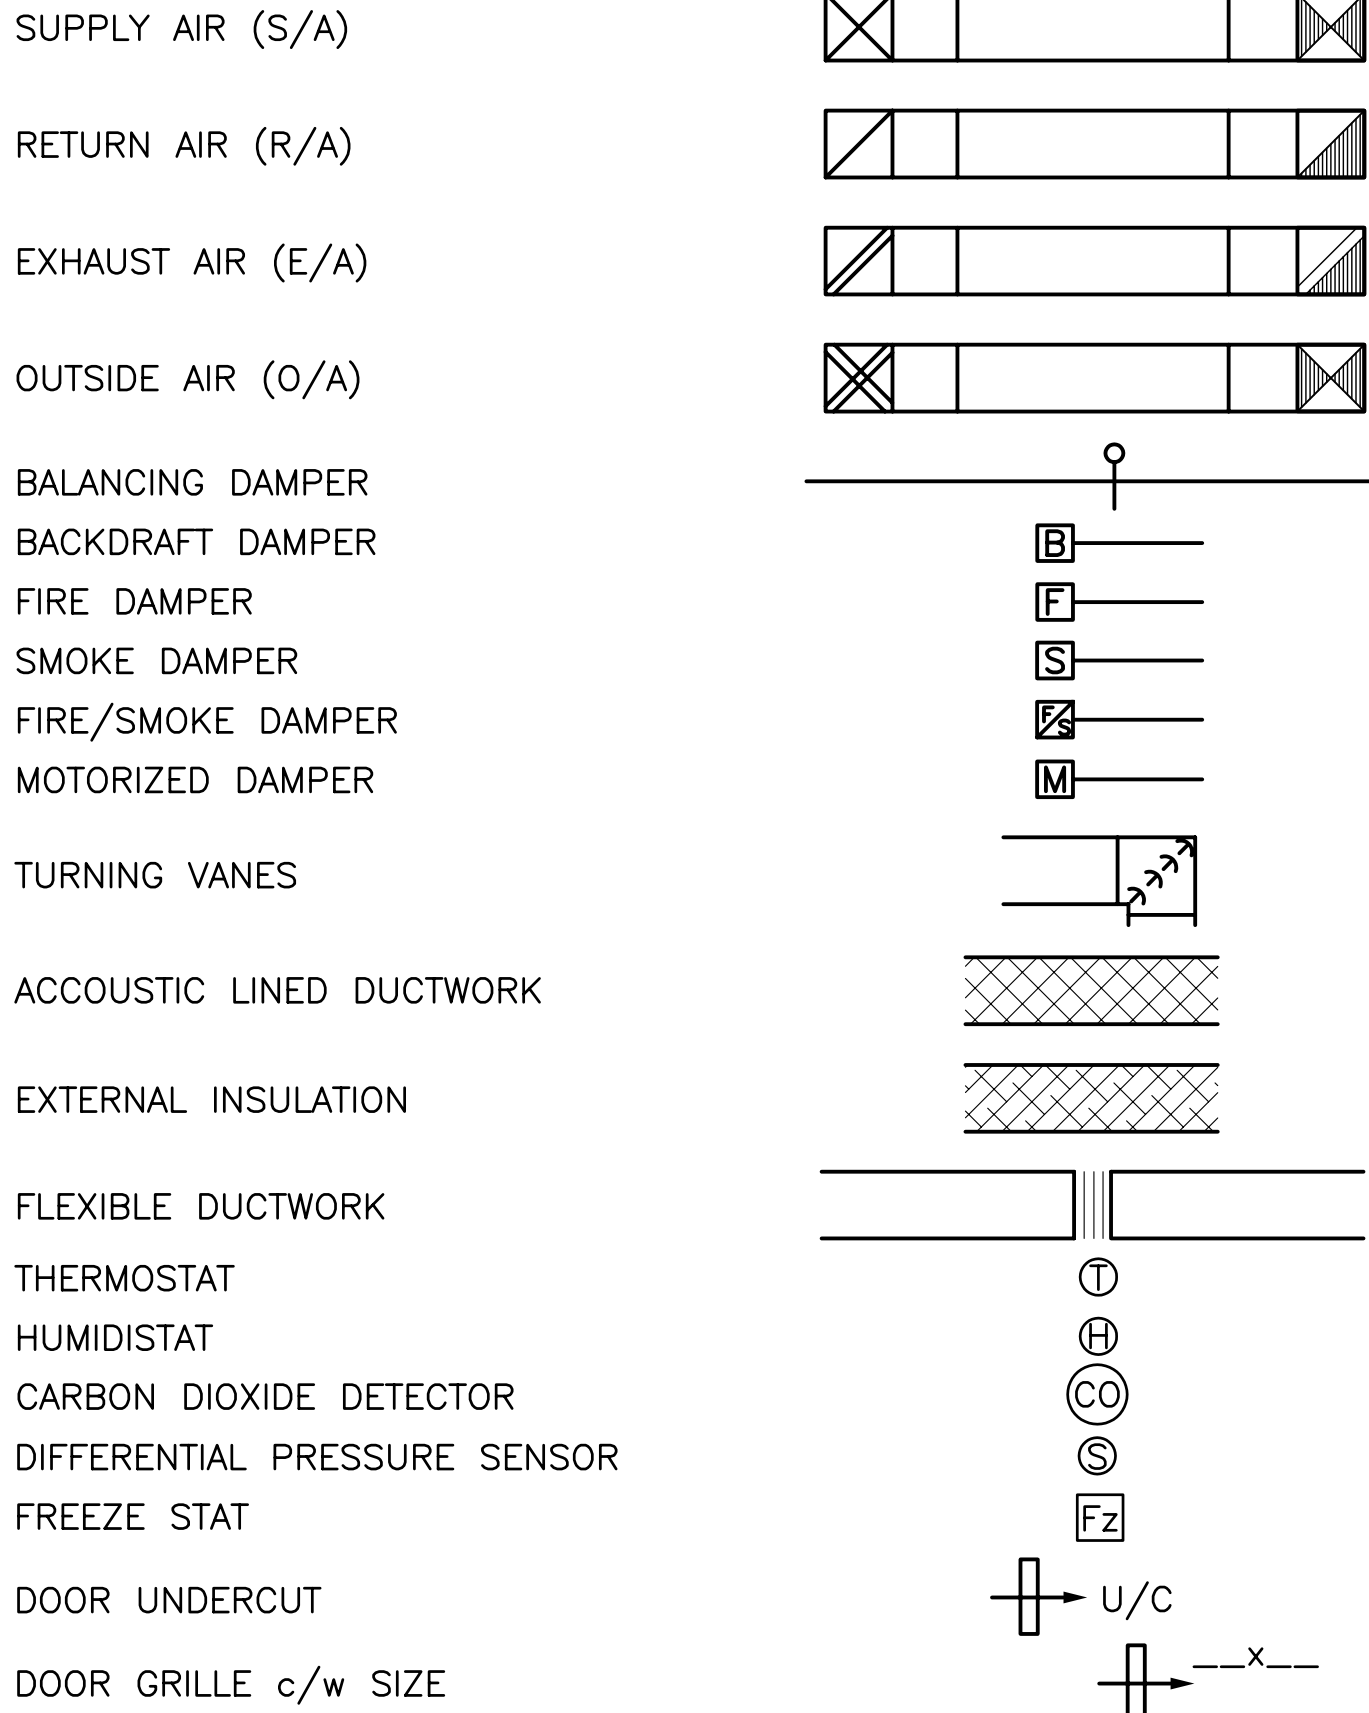


DUCT DIMENSIONING

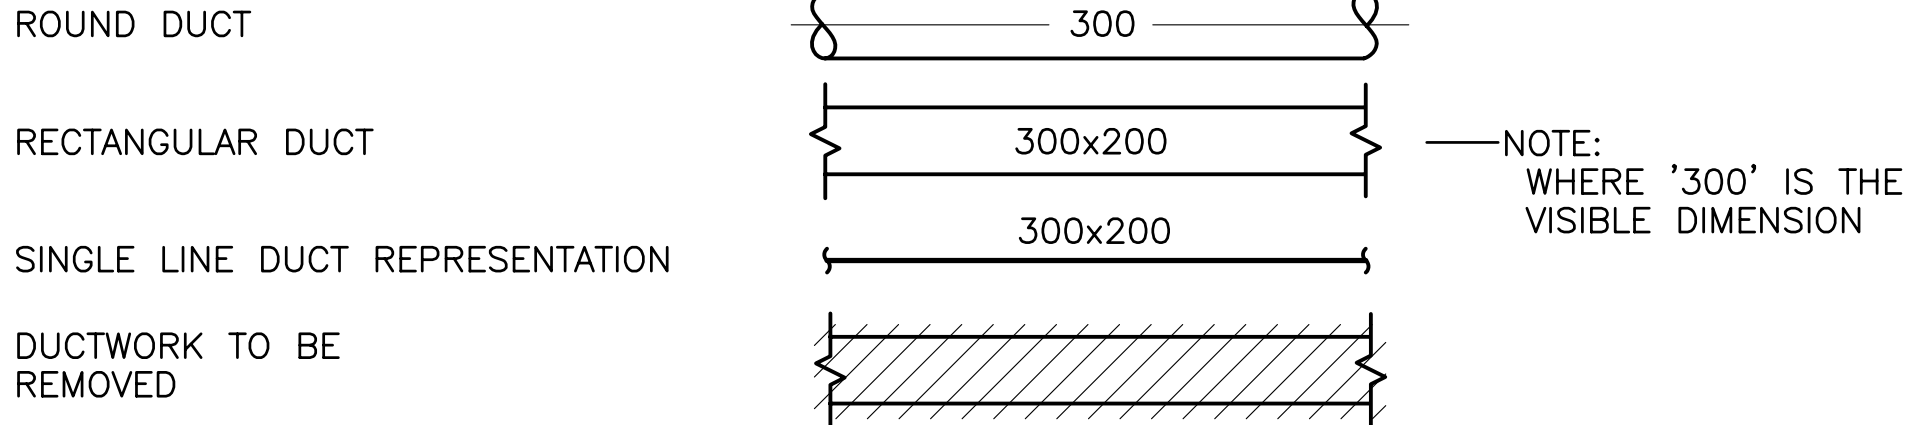

AIR OUTLET TAG

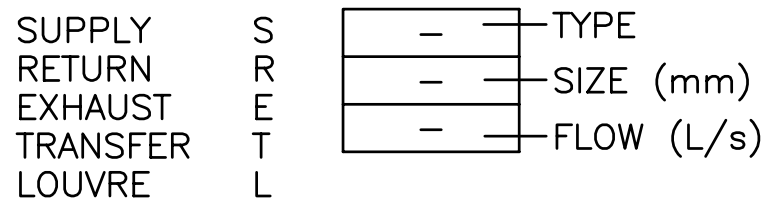

RADIATION / RADIANT PANEL TAG

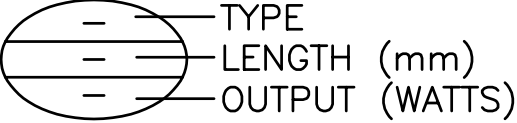

REVISION TAG



1 MECHANICAL LEGEND
SCALE : N.T.S.

				Company Permit		Engineer Seal		MECHANICAL		 CITY of IQALUIT, Nunavut	CITY OF IQALUIT		EARTHTECH Earth Tech (Canada) Inc. <table><tr><td>DRAWN BY: CWN</td><td>SCALE: AS NOTED</td><td>DATE: FEB. 03, 2003</td><td>SHEET NO.</td></tr><tr><td>CHECKED BY: DBF</td><td></td><td></td><td></td></tr><tr><td>CADD SYSTEM AutoCAD</td><td>DWG NO. M-1</td><td>REV. 1</td><td>CONTRACT 55524</td></tr></table>				DRAWN BY: CWN	SCALE: AS NOTED	DATE: FEB. 03, 2003	SHEET NO.	CHECKED BY: DBF				CADD SYSTEM AutoCAD	DWG NO. M-1	REV. 1	CONTRACT 55524
DRAWN BY: CWN	SCALE: AS NOTED	DATE: FEB. 03, 2003	SHEET NO.																									
CHECKED BY: DBF																												
CADD SYSTEM AutoCAD	DWG NO. M-1	REV. 1	CONTRACT 55524																									
				RECORD DRAWING		INFORMATION CONTAINED IN THESE DRAWINGS IS AS SUPPLIED BY SHENDEL MECHANICAL CONTRACTING LTD. DATE: MAY 03, 2004		LEGEND			IQALUIT WATER TREATMENT PLANT																	
2	RECORD DRAWING	23/04/04	IV	1	ISSUED FOR CONSTRUCTION	22/04/03	DBF																					
0	ISSUED FOR TENDER	19/02/03	DBF																									
NO.		REVISION	DATE	INITIAL																								