



HVAC

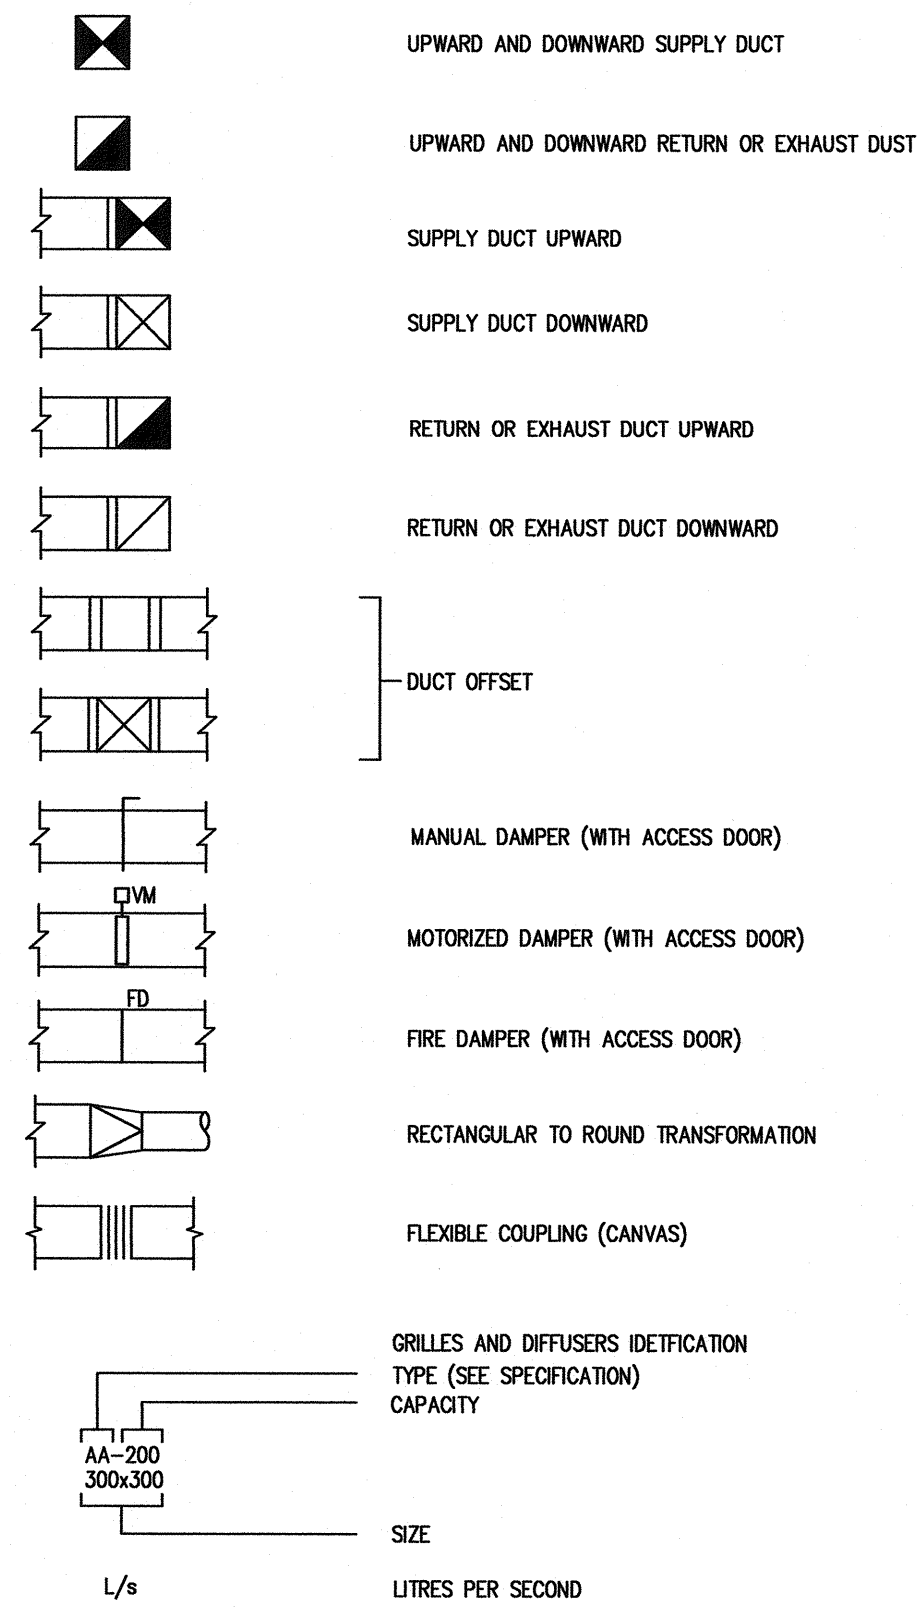


PLUMBING AND HEATING

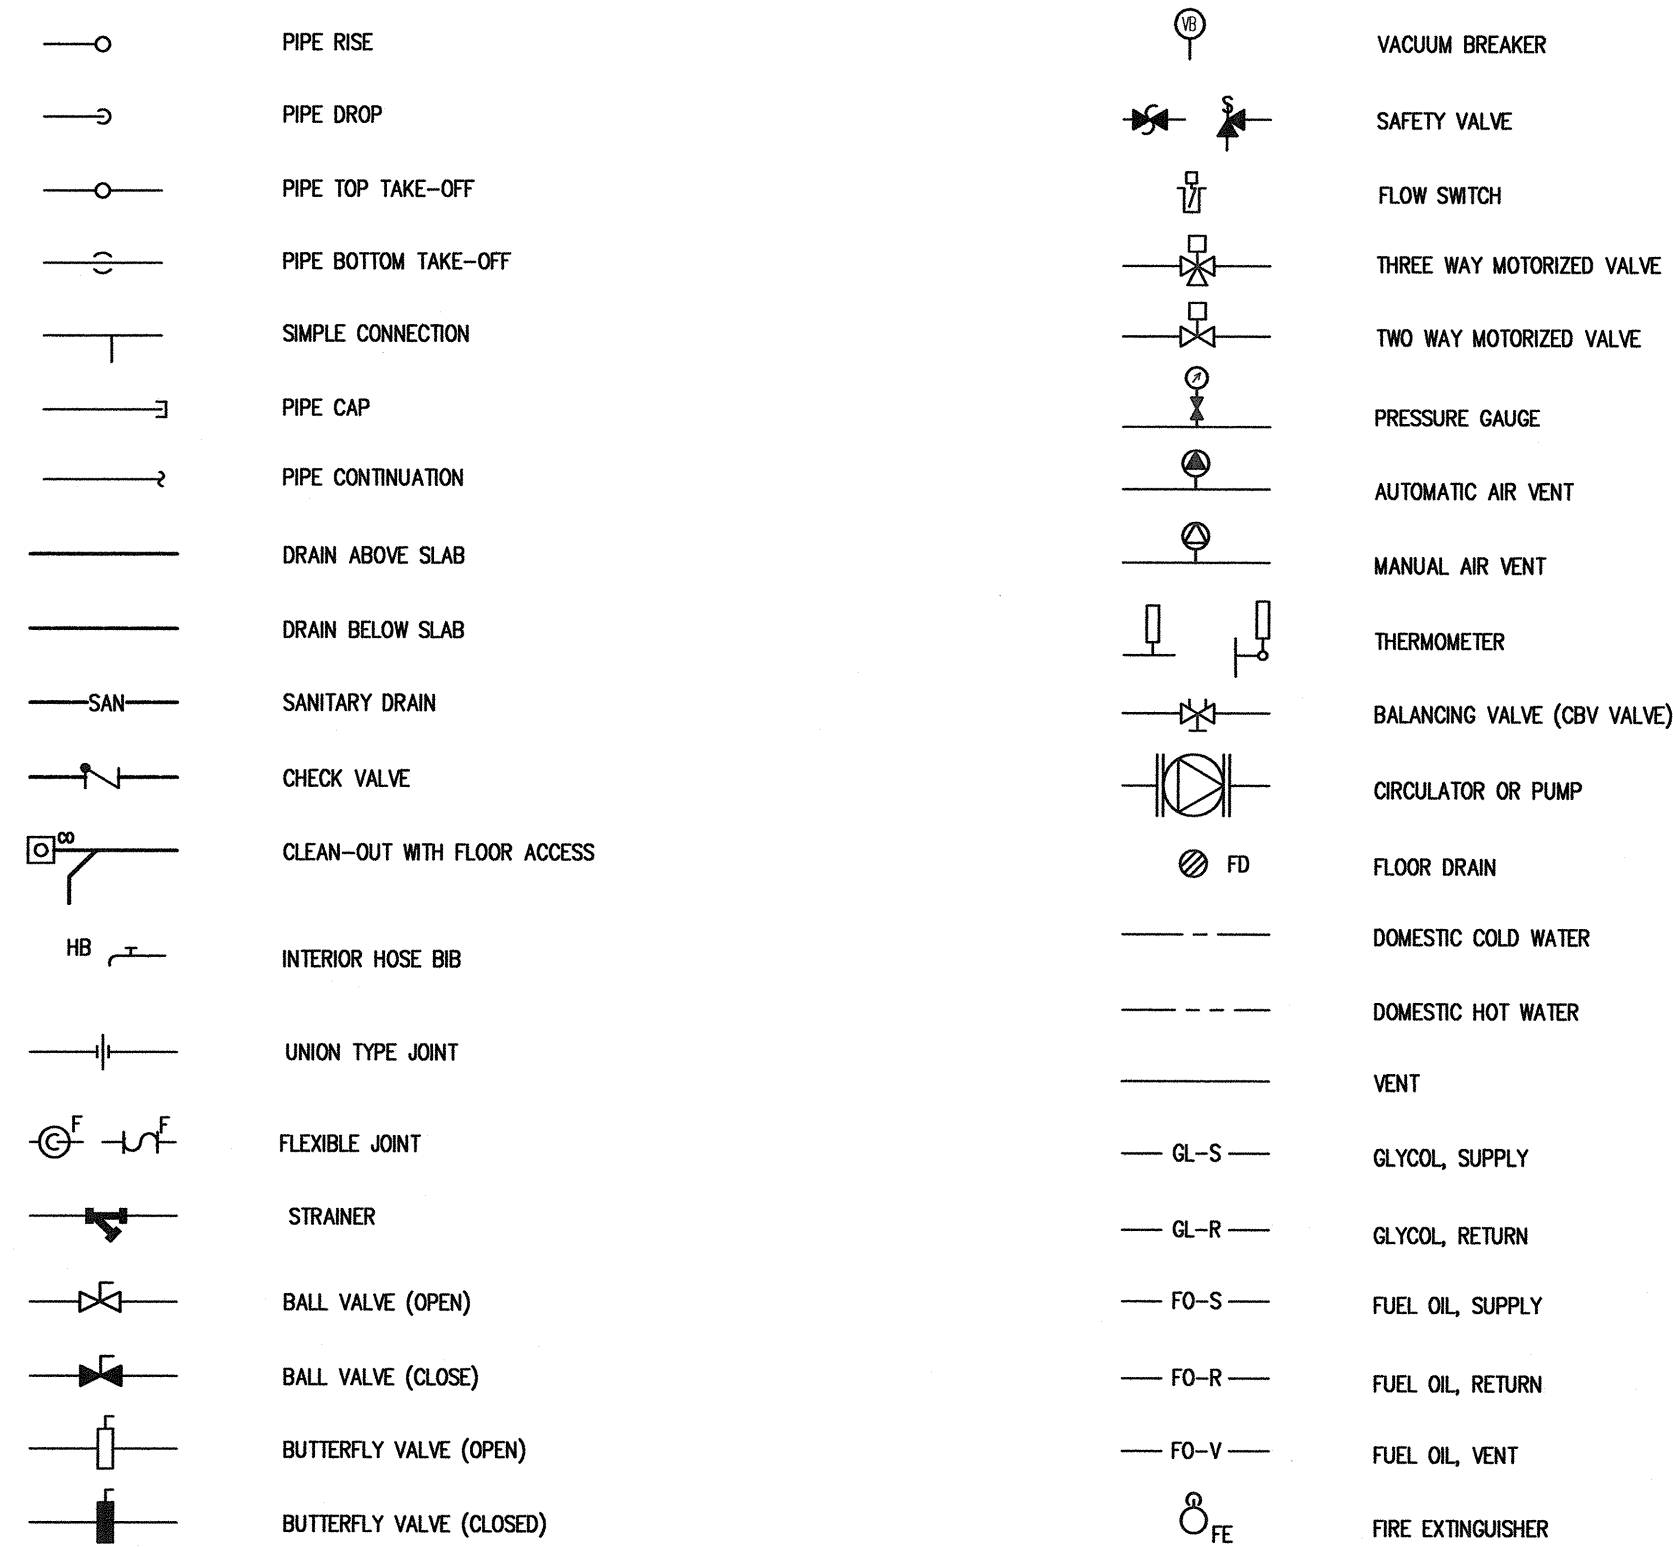


DRAWING LIST

M1	MECHANICAL - LEGENDS AND DRAWING LIST
M2	MECHANICAL - DETAILS
M3	MECHANICAL - DOMESTIC WATER AND SANITARY PLUMBING LAYOUT
M4	MECHANICAL - HEATING PLUMBING AND EQUIPMENT LAYOUT
M5	MECHANICAL - VENTILATION LAYOUT
M6	MECHANICAL - VENTILATION SECTION VIEWS
M7	MECHANICAL - CONTROLS SCHEMATICS AND HYDRAULIC DIAGRAMS
M8	MECHANICAL - CONTROLS SCHEMATICS AND HYDRAULIC DIAGRAMS

SECTIONS AND DETAILS

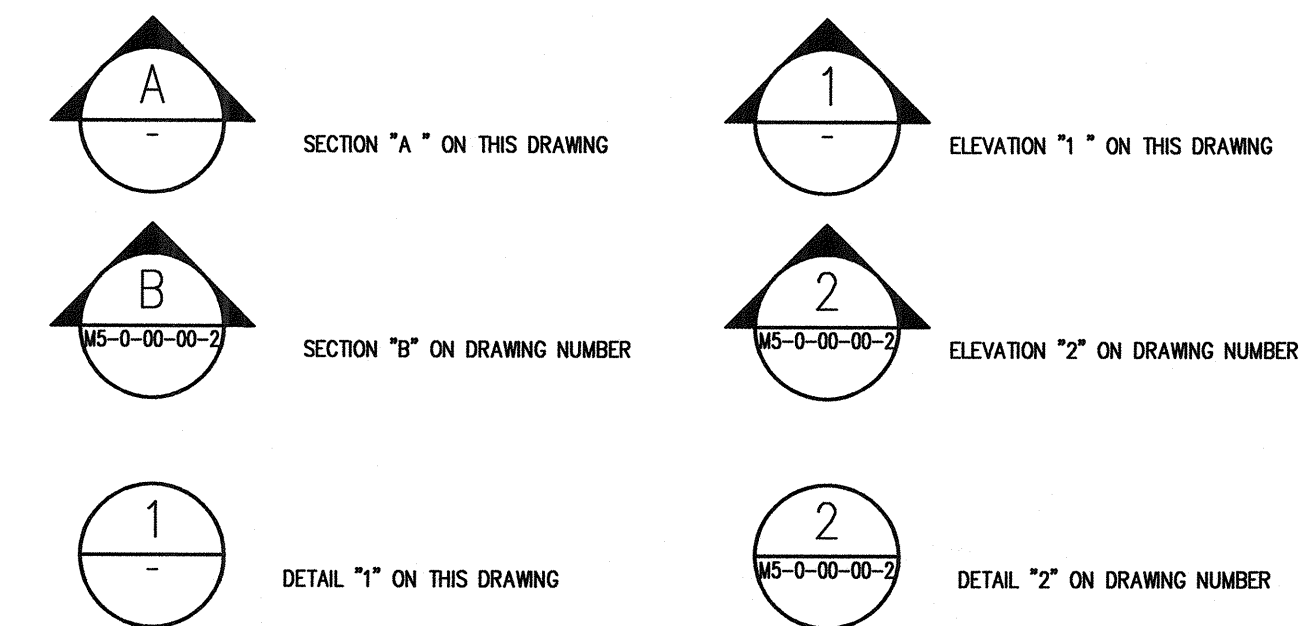


CONTROLS LEGEND

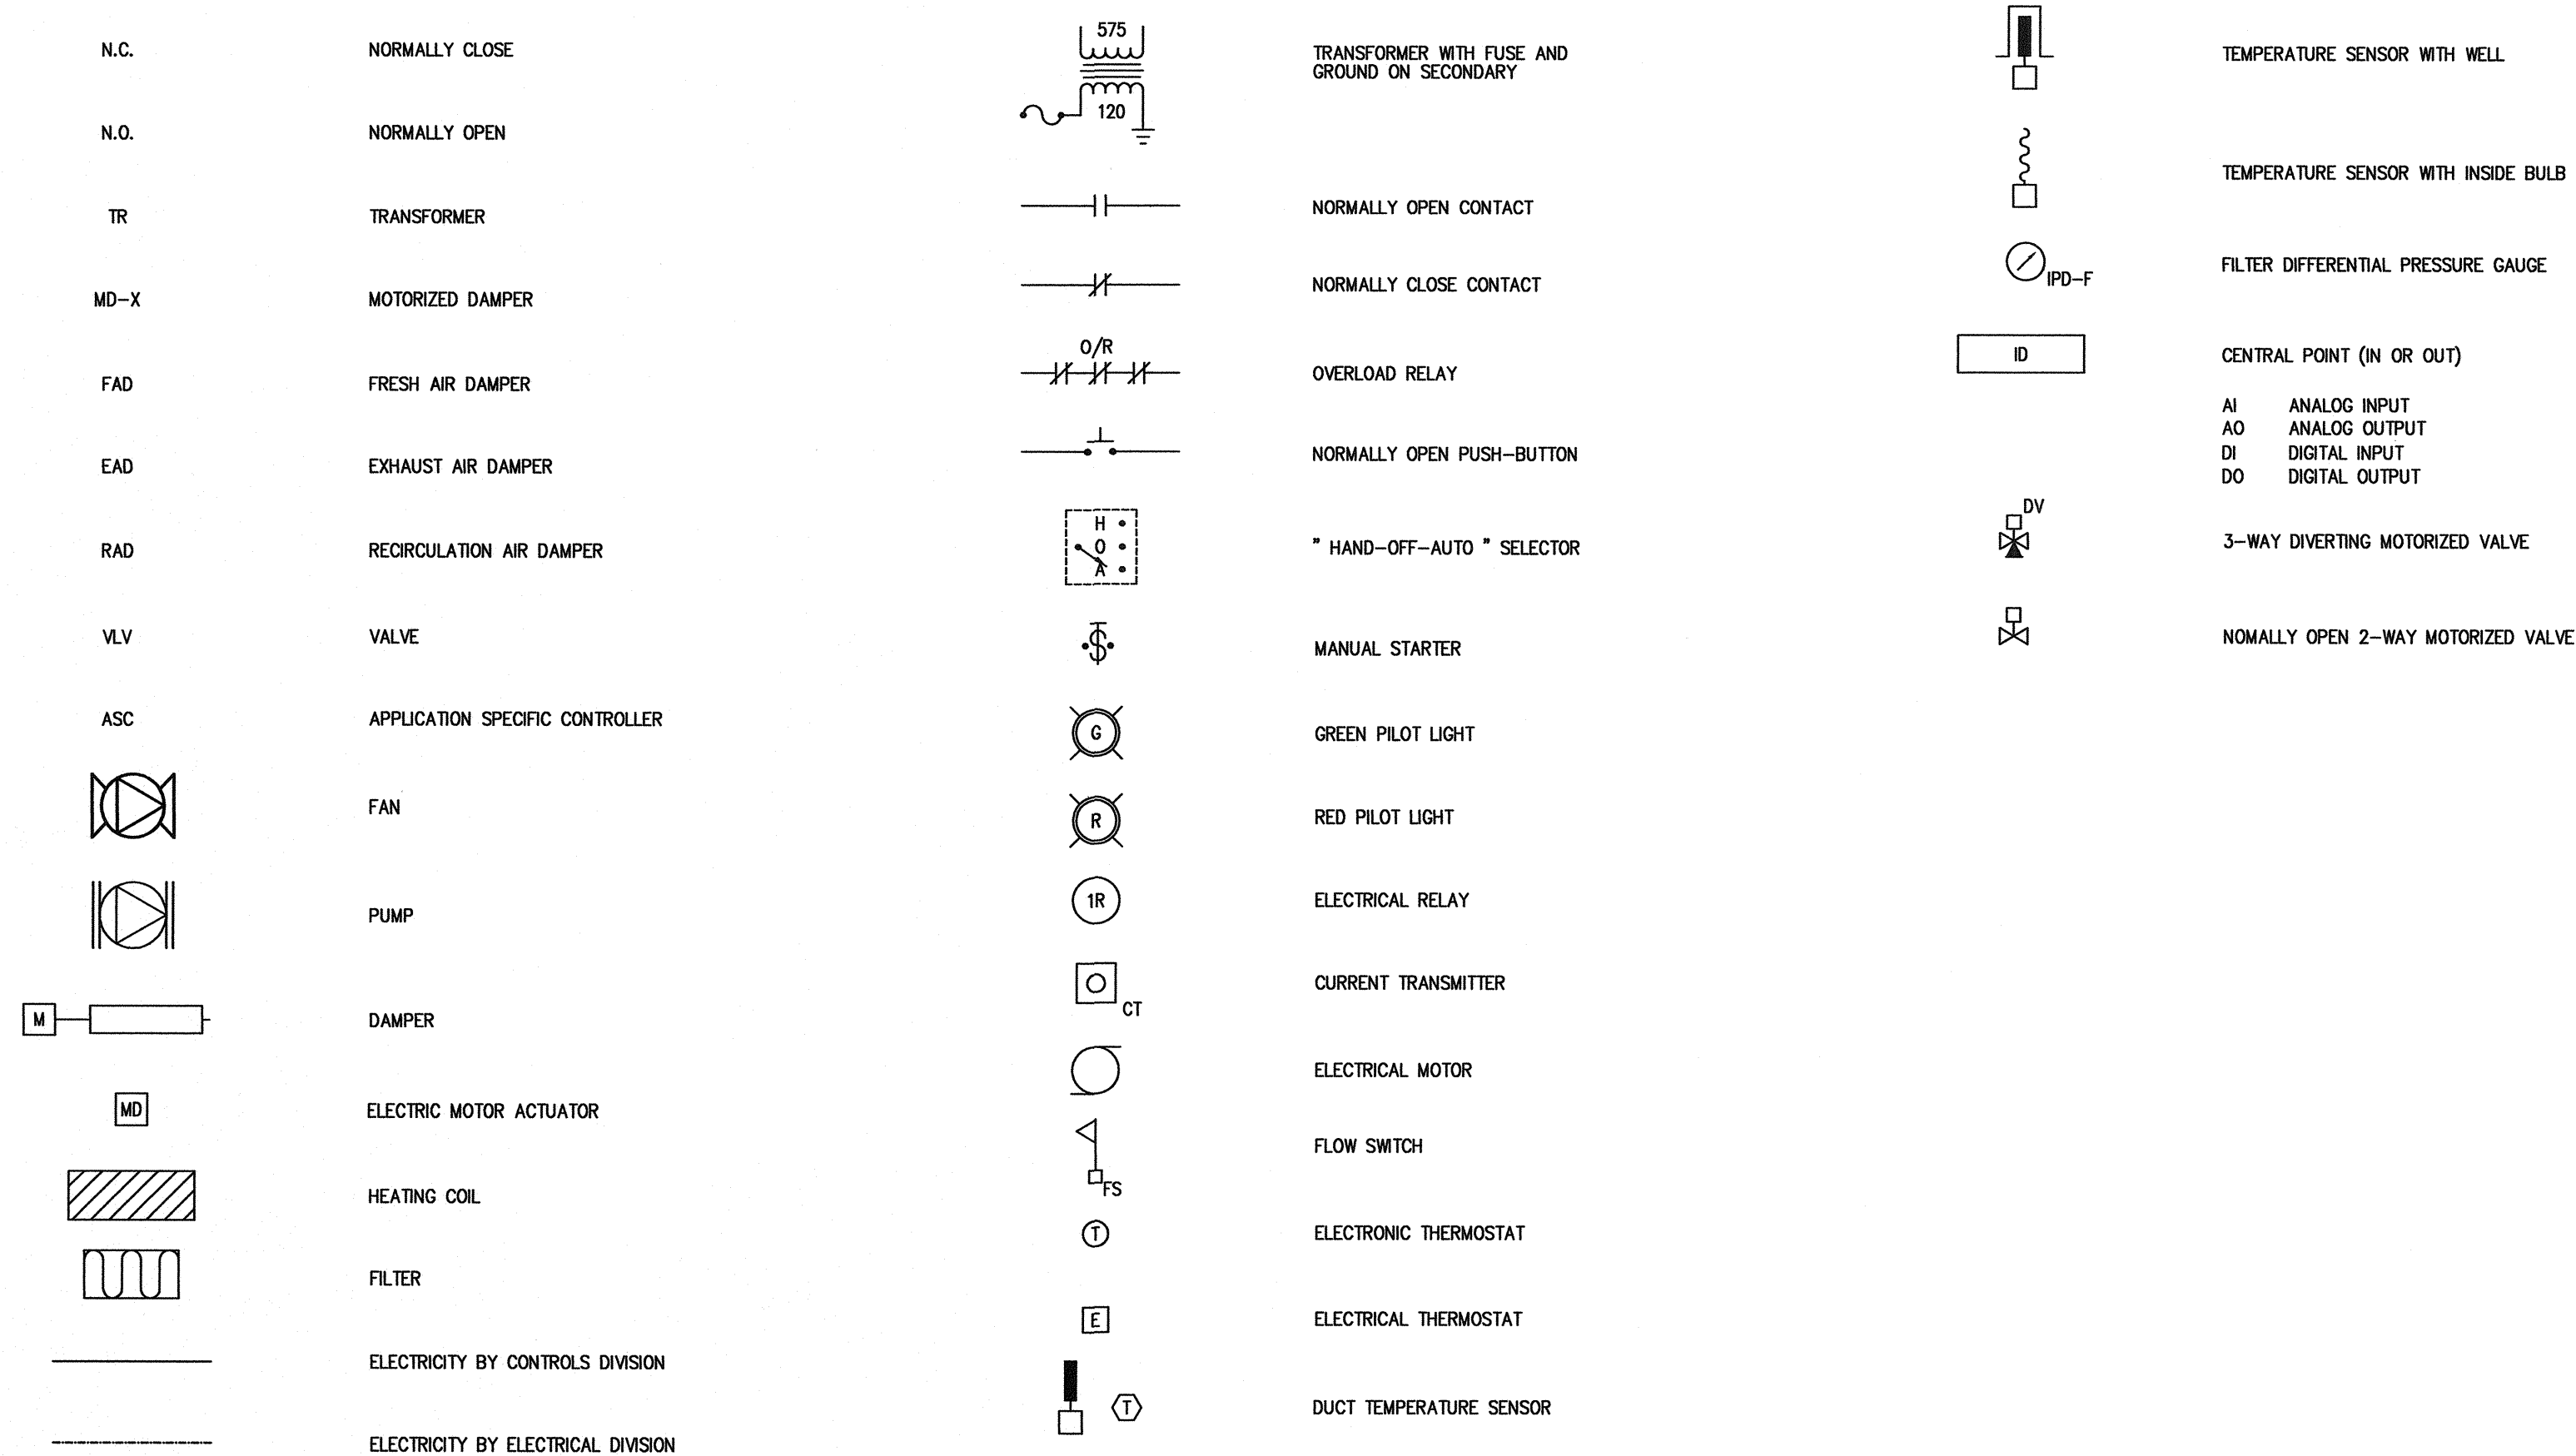

Ottawa :
3740 Richmond Road, Suite 100, K2H 5B9
T.(613) 596.6454 F.(613) 596.3346
www.WBPEngineering.com

Gatineau :
430 de l'hôpital bld, suite 210, J8V 1T7
T.(819) 778.2448 F.(819) 778.5031
Consulting Engineers

No.	DESCRIPTION	DATE	BY	APP'D
1	ISSUED FOR CONSTRUCTION	05/04/10	WBEP	P.S.O.
0	ISSUED FOR TENDER	06/19/09	WBEP	P.S.O.

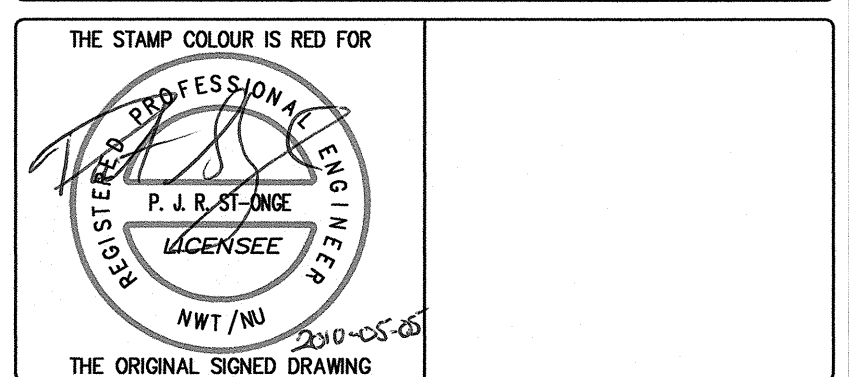

Trow Associates Inc.
154 Colonnade Road South
Ottawa, Ont. K2E 7J5
Tel: (613) 225-9940
Fax: (613) 225-7337

CLIENT
CITY OF IQALUIT

PROJECT
LIFT STATION No. 2
MODIFICATIONS

TITLE MECHANICAL LEGENDS AND DRAWING LIST	design by L.P.	project no. OTCD00019365A
	drawn by L.P.	drawing no.
	checked by G.M.	
	date 05/04/2010	
	scale NOT TO SCALE	

M1