


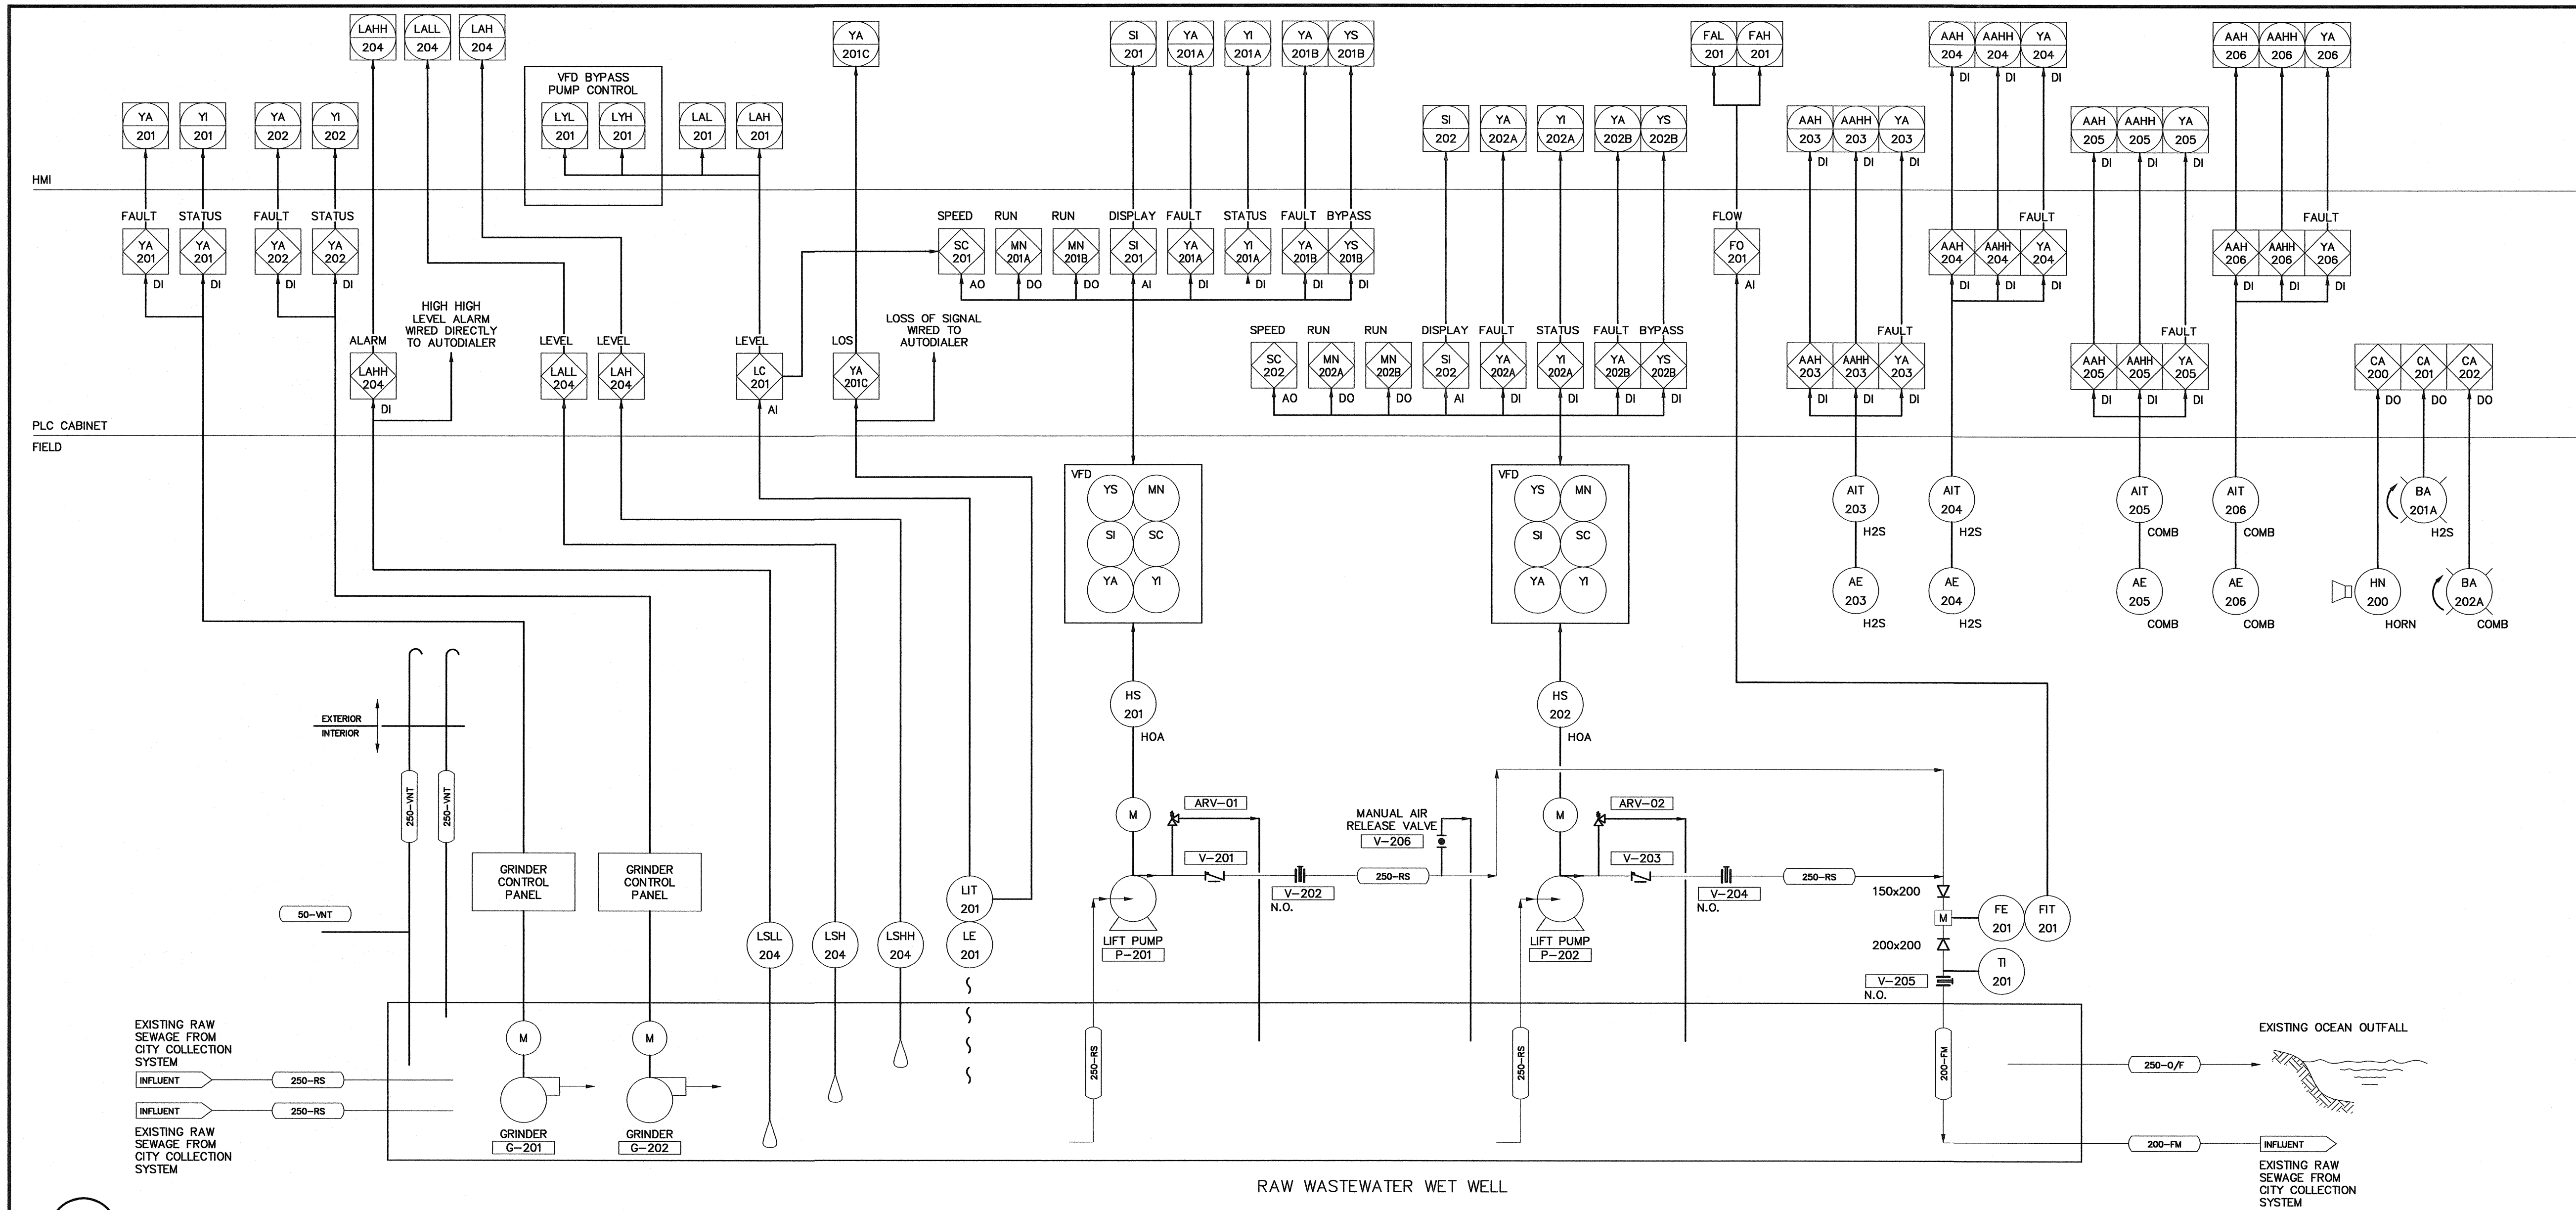

1
E5
PIPING AND INSTRUMENTATION
N.T.S.

Ottawa :
3740 Richmond Road, Suite 100, K2H 5B9
T.(613) 596.6454 F.(613) 596.3346
www.WBBPEngineering.com

Gatineau :
430 de l'hôpital bld, suite 210, J8V 1T7
T.(819) 778.2448 F.(819) 778.5031

Consulting Engineers

No.	DESCRIPTION	DATE	BY	APP'D
1	ISSUED FOR CONSTRUCTION	05/04/10	WBBP	
0	ISSUED FOR TENDER	06/19/09	WBBP	C.W.

R E V I S I O N S

THE STAMP COLOUR IS RED FOR

REGISTERED PROFESSIONAL ENGINEER
G. L. WOOD
LICENSE NO. 12030
NWT/N.S.

THE ORIGINAL SIGNED DRAWING

Trow Associates Inc.

154 Colonnade Road South
Ottawa, Ont. K2E 7J5

Tel: (613) 225-9940
Fax: (613) 225-7337

CLIENT

CITY OF IQALUIT


PROJECT

LIFT STATION No. 2
MODIFICATIONS

TITLE

ELECTRICAL
PIPING AND INSTRUMENTATION
DIAGRAM, PLC CABINET ELEVATION

design by	C.M.	project no.	OTCD00019365A
drawn by	F.S.	drawing no.	E5
checked by	C.M.		
date	06/11/2009		
scale	NOT TO SCALE		

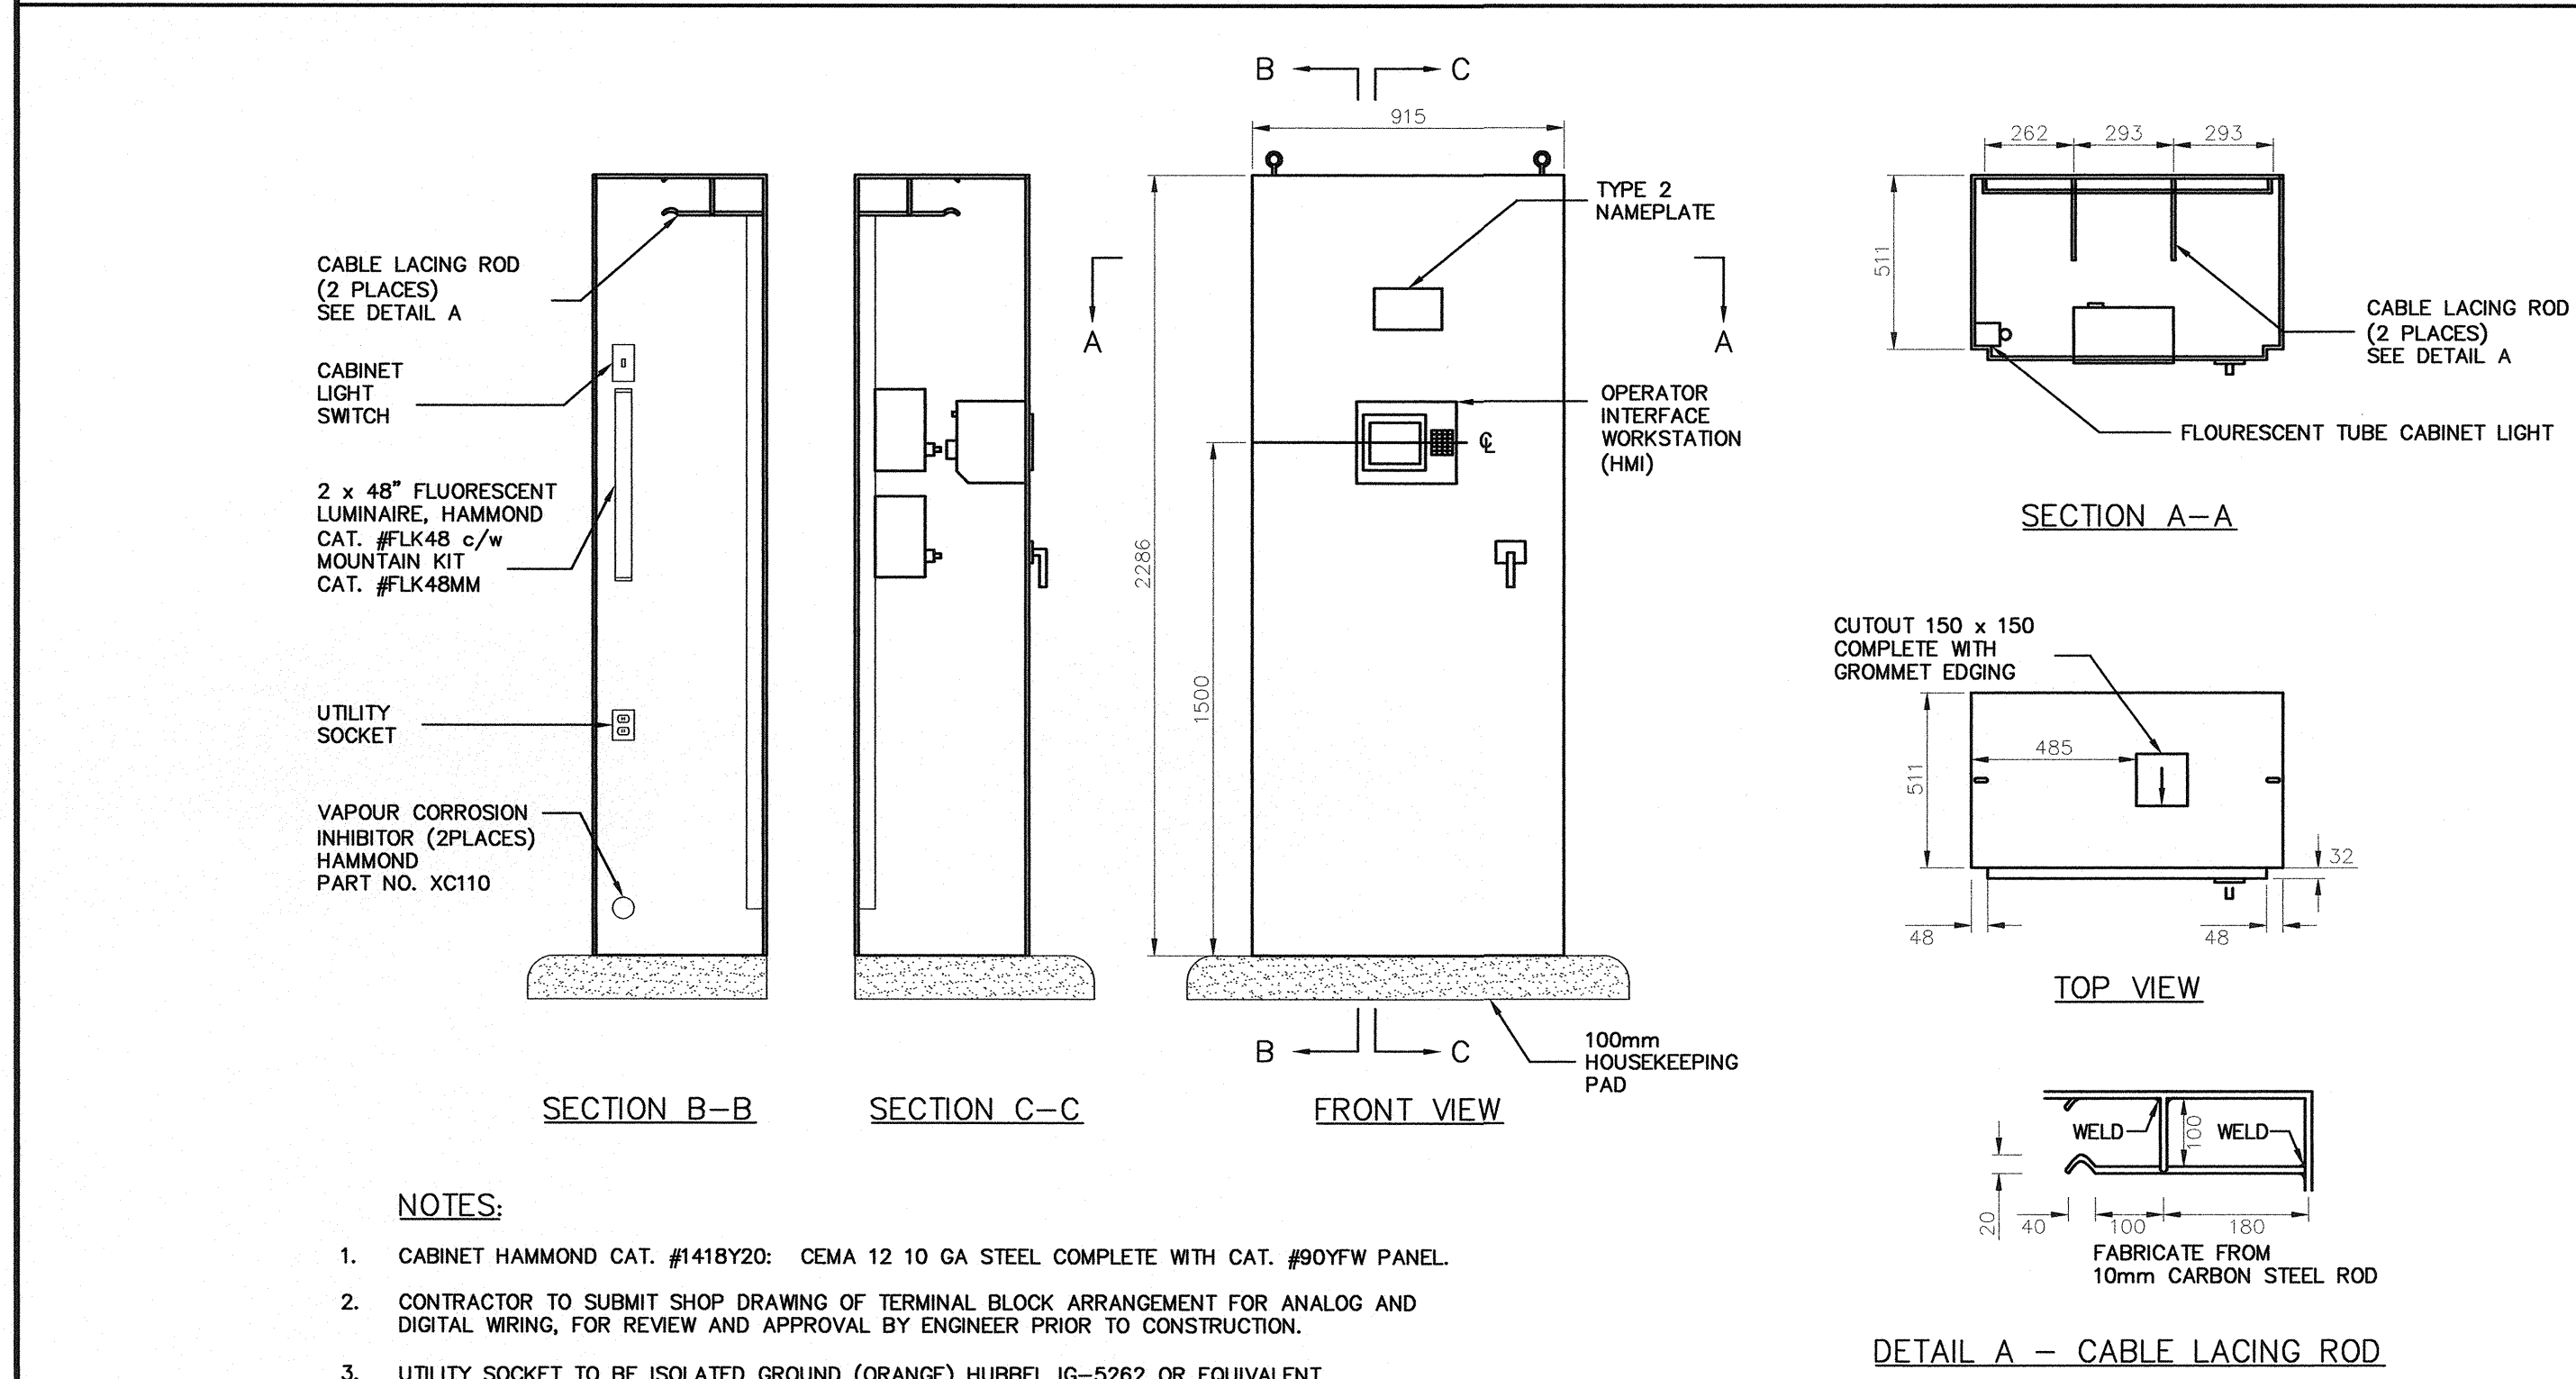

2
E5
PLC CABINET ELEVATION
N.T.S.

May 04, 2010