
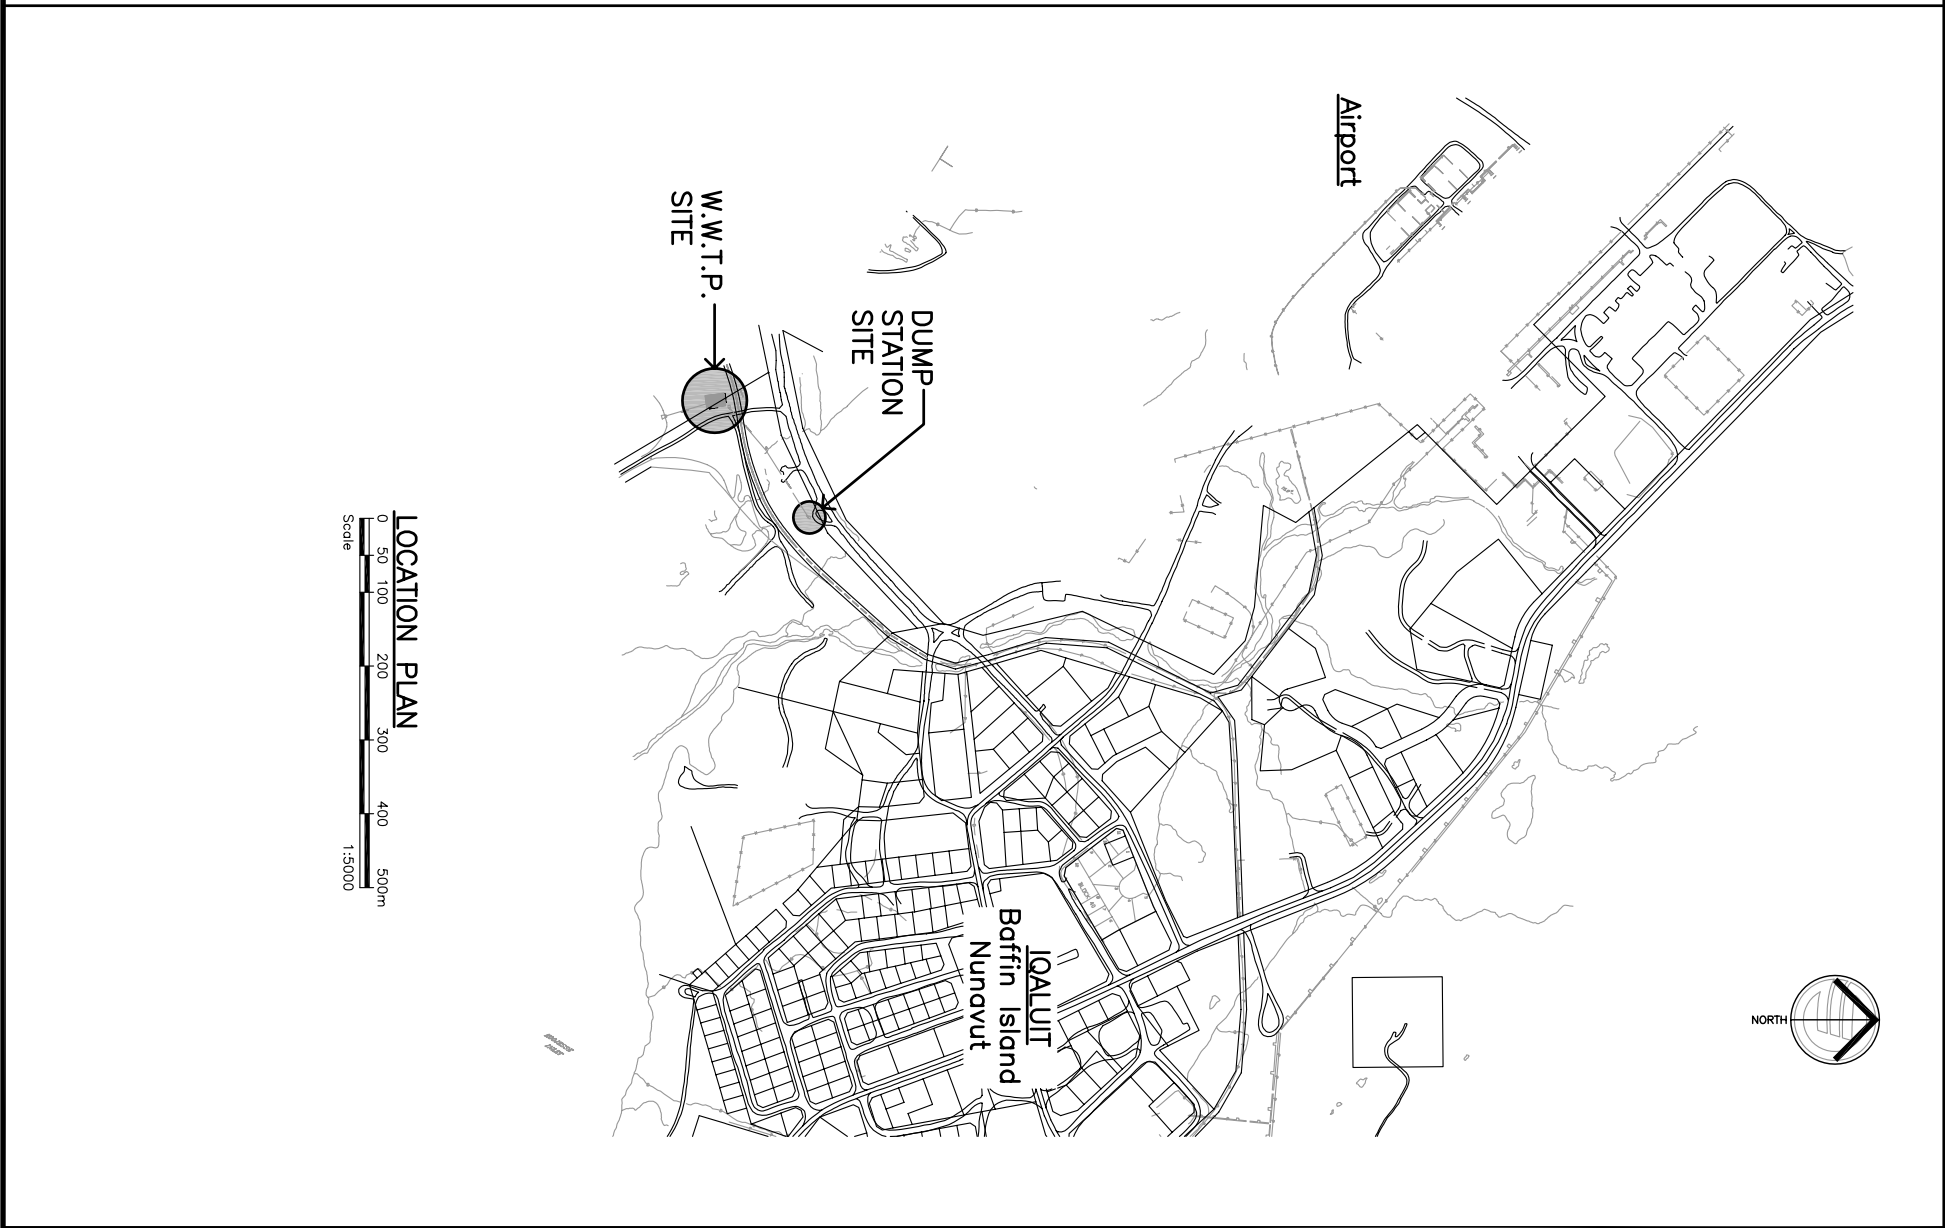


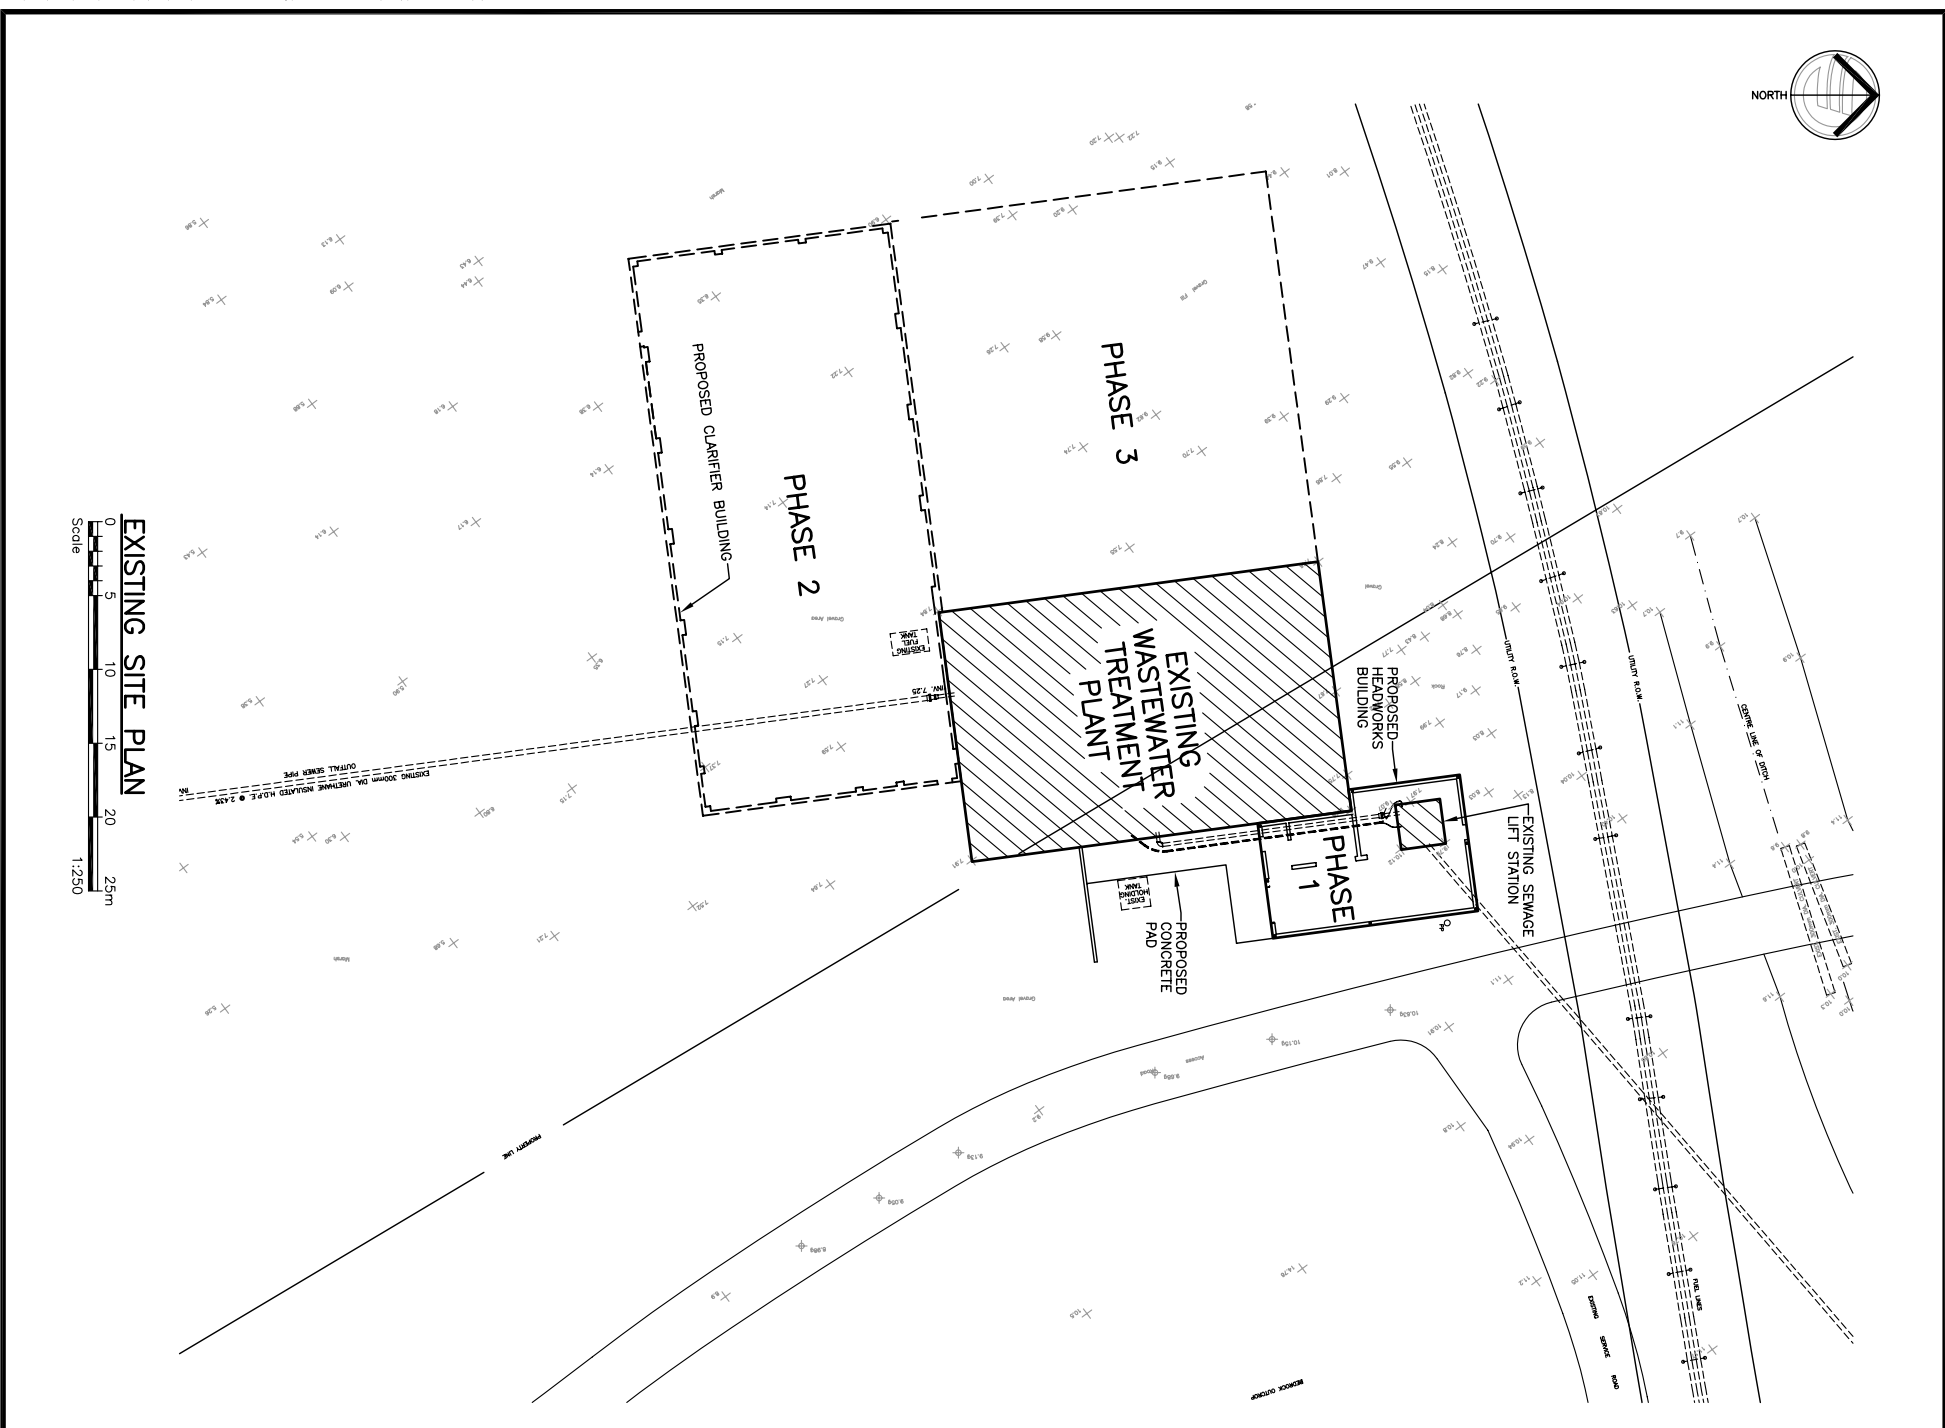

 **EarthTech**
A Tyco International Ltd Company

17203-103rd Avenue
Edmonton, Alberta
T5S 1J4 CANADA

Tel. 780-488-6800
Fax: 780-488-2121
www.earthtech.ca

**PERMIT TO PRACTICE
EARTH TECH (CANADA) INC.**
Original Signature GLENN PROSKO
Original Date 2005-03-10
PERMIT NUMBER: P 005
The Association of Professional Engineers,
Geologists and Geophysicists of the NWT/NL

A circular seal for a Professional Engineer. The outer ring contains the text "REGISTERED PROFESSIONAL ENGINEER" at the top and "N.W. 7/11/01" at the bottom. The center of the seal contains the text "ORIGINALTY SIGNED BY GLENN PROSKO 2005-03-10".

REVISIONS		
No.	Date	Description
0	2005 3/14	ISSUED FOR TENDER

City of Iqaluit
ᐱᓐᓕᓕᓐᓂᓐ

Design	R.H.B./G.A.P.
Drawn	R.J.H.
Approved	
Checked	
Project Title	

CITY OF IQUALUIT
WASTEWATER
TREATMENT PLANT
PHASE 1

LOCATION PLAN and EXISTING SITE PLAN	
Scale	AS NOTED
Project No.	75360
Date	2005-03-09
Drawing No.	C131
Revision	0