

LIQUID PROCESS TRAIN

RAW WASTEWATER PUMPING (3)

*FINE
SCREENING (2)*


POTENTIAL
FUTURE GRIT
REMOVAL (1)

**PRIMARY
TREATMENT**
1 PRIMARY FILTER

BIOLOGICAL
PROCESS (2)
PHASE 2

SECONDARY CLARIFICATION (2)

PHASE 2

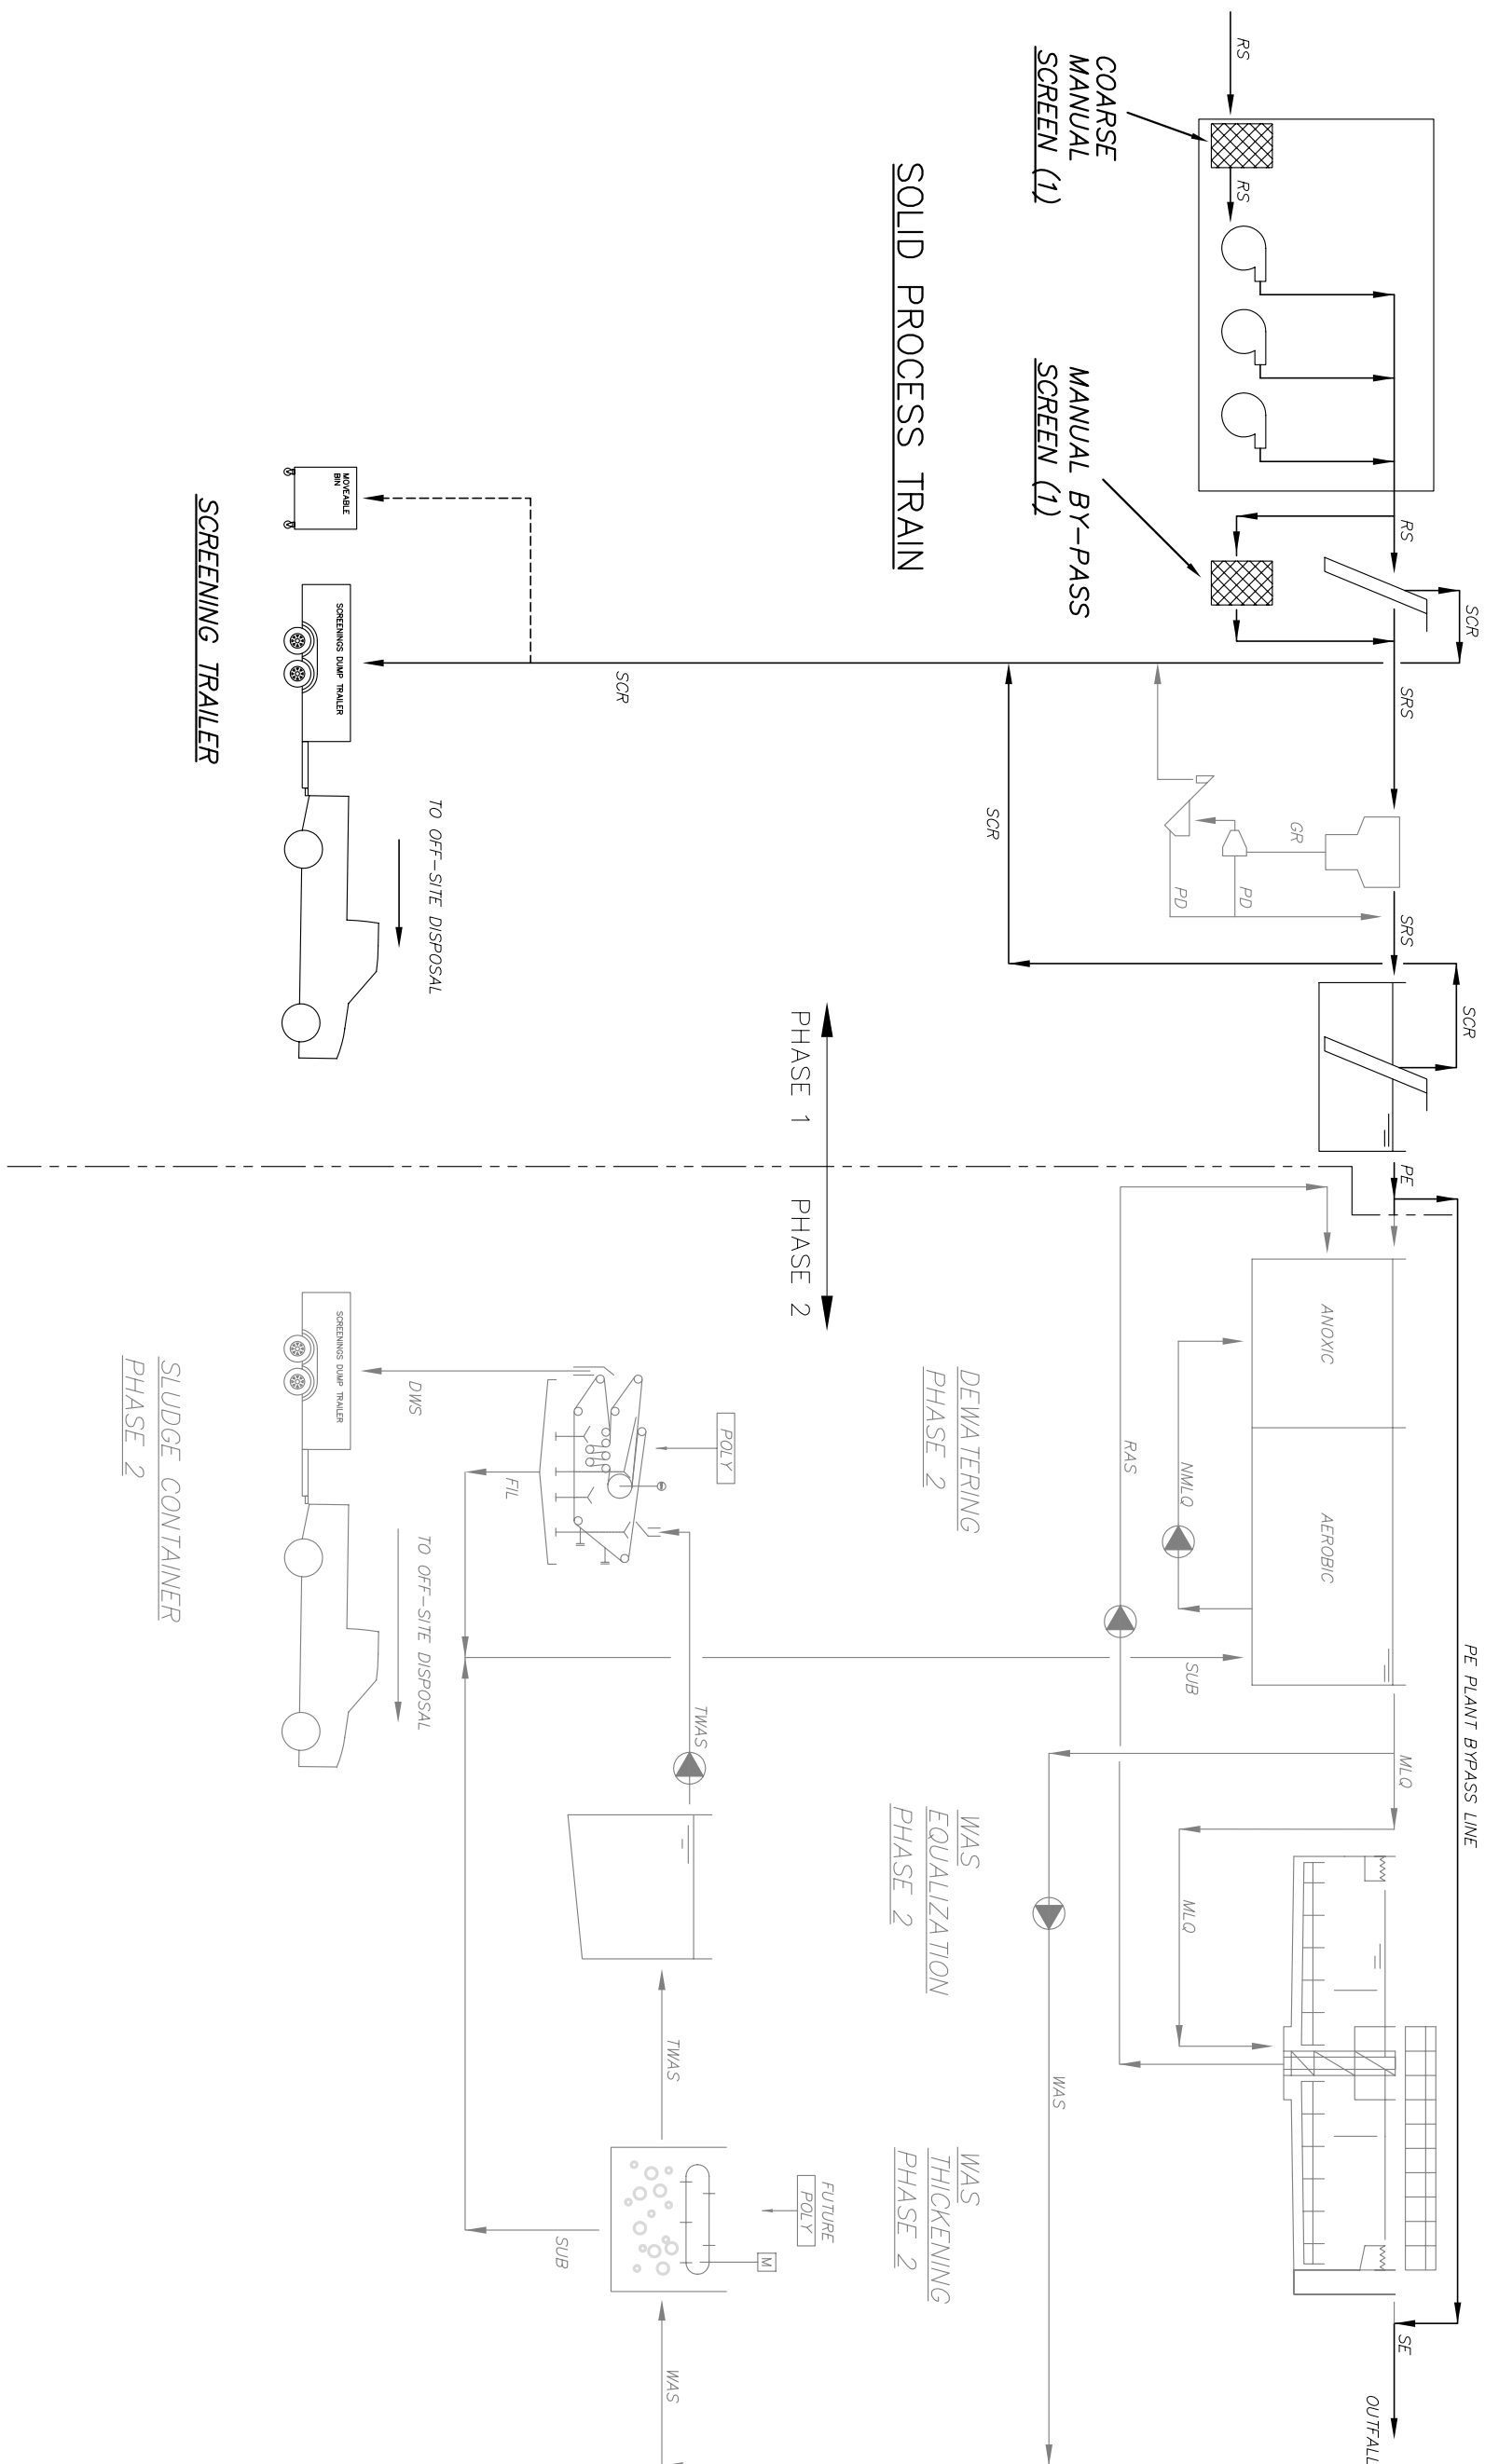

A Tyco International Ltd. Company

17203-103rd Avenue
EDMONTON, ALBERTA
T6S 1J4 CANADA

Tel. 780-488-6600
Fax. 780-488-2112
www.eorthtech.co

**PERMIT TO PRACTICE
EARTH TECH (CANADA) INC.**

Signature _____

Date _____

PERMIT NUMBER: P 005
The Association of Professional Engineers,
Geologists and Geophysicists of the NWT/NM



REVISIONS		
No.	Date	Description
0	2005 03/14	ISSUED FOR TENDER



**CITY of IQUALUIT,
Nunavut**

Design
SNO/RB

RB

Approved	
----------	--

1

Checked	
---------	--

1

Project Title
CITY OF IQUALUIT
WASTEWATER
TREATMENT PLANT
PHASE 1

Drowning Tit

PROCESS FLOW DIAGRAM

Scale

Project No.	Date
-------------	------

Drawing No.	Revision
-------------	----------

PLIN

1