


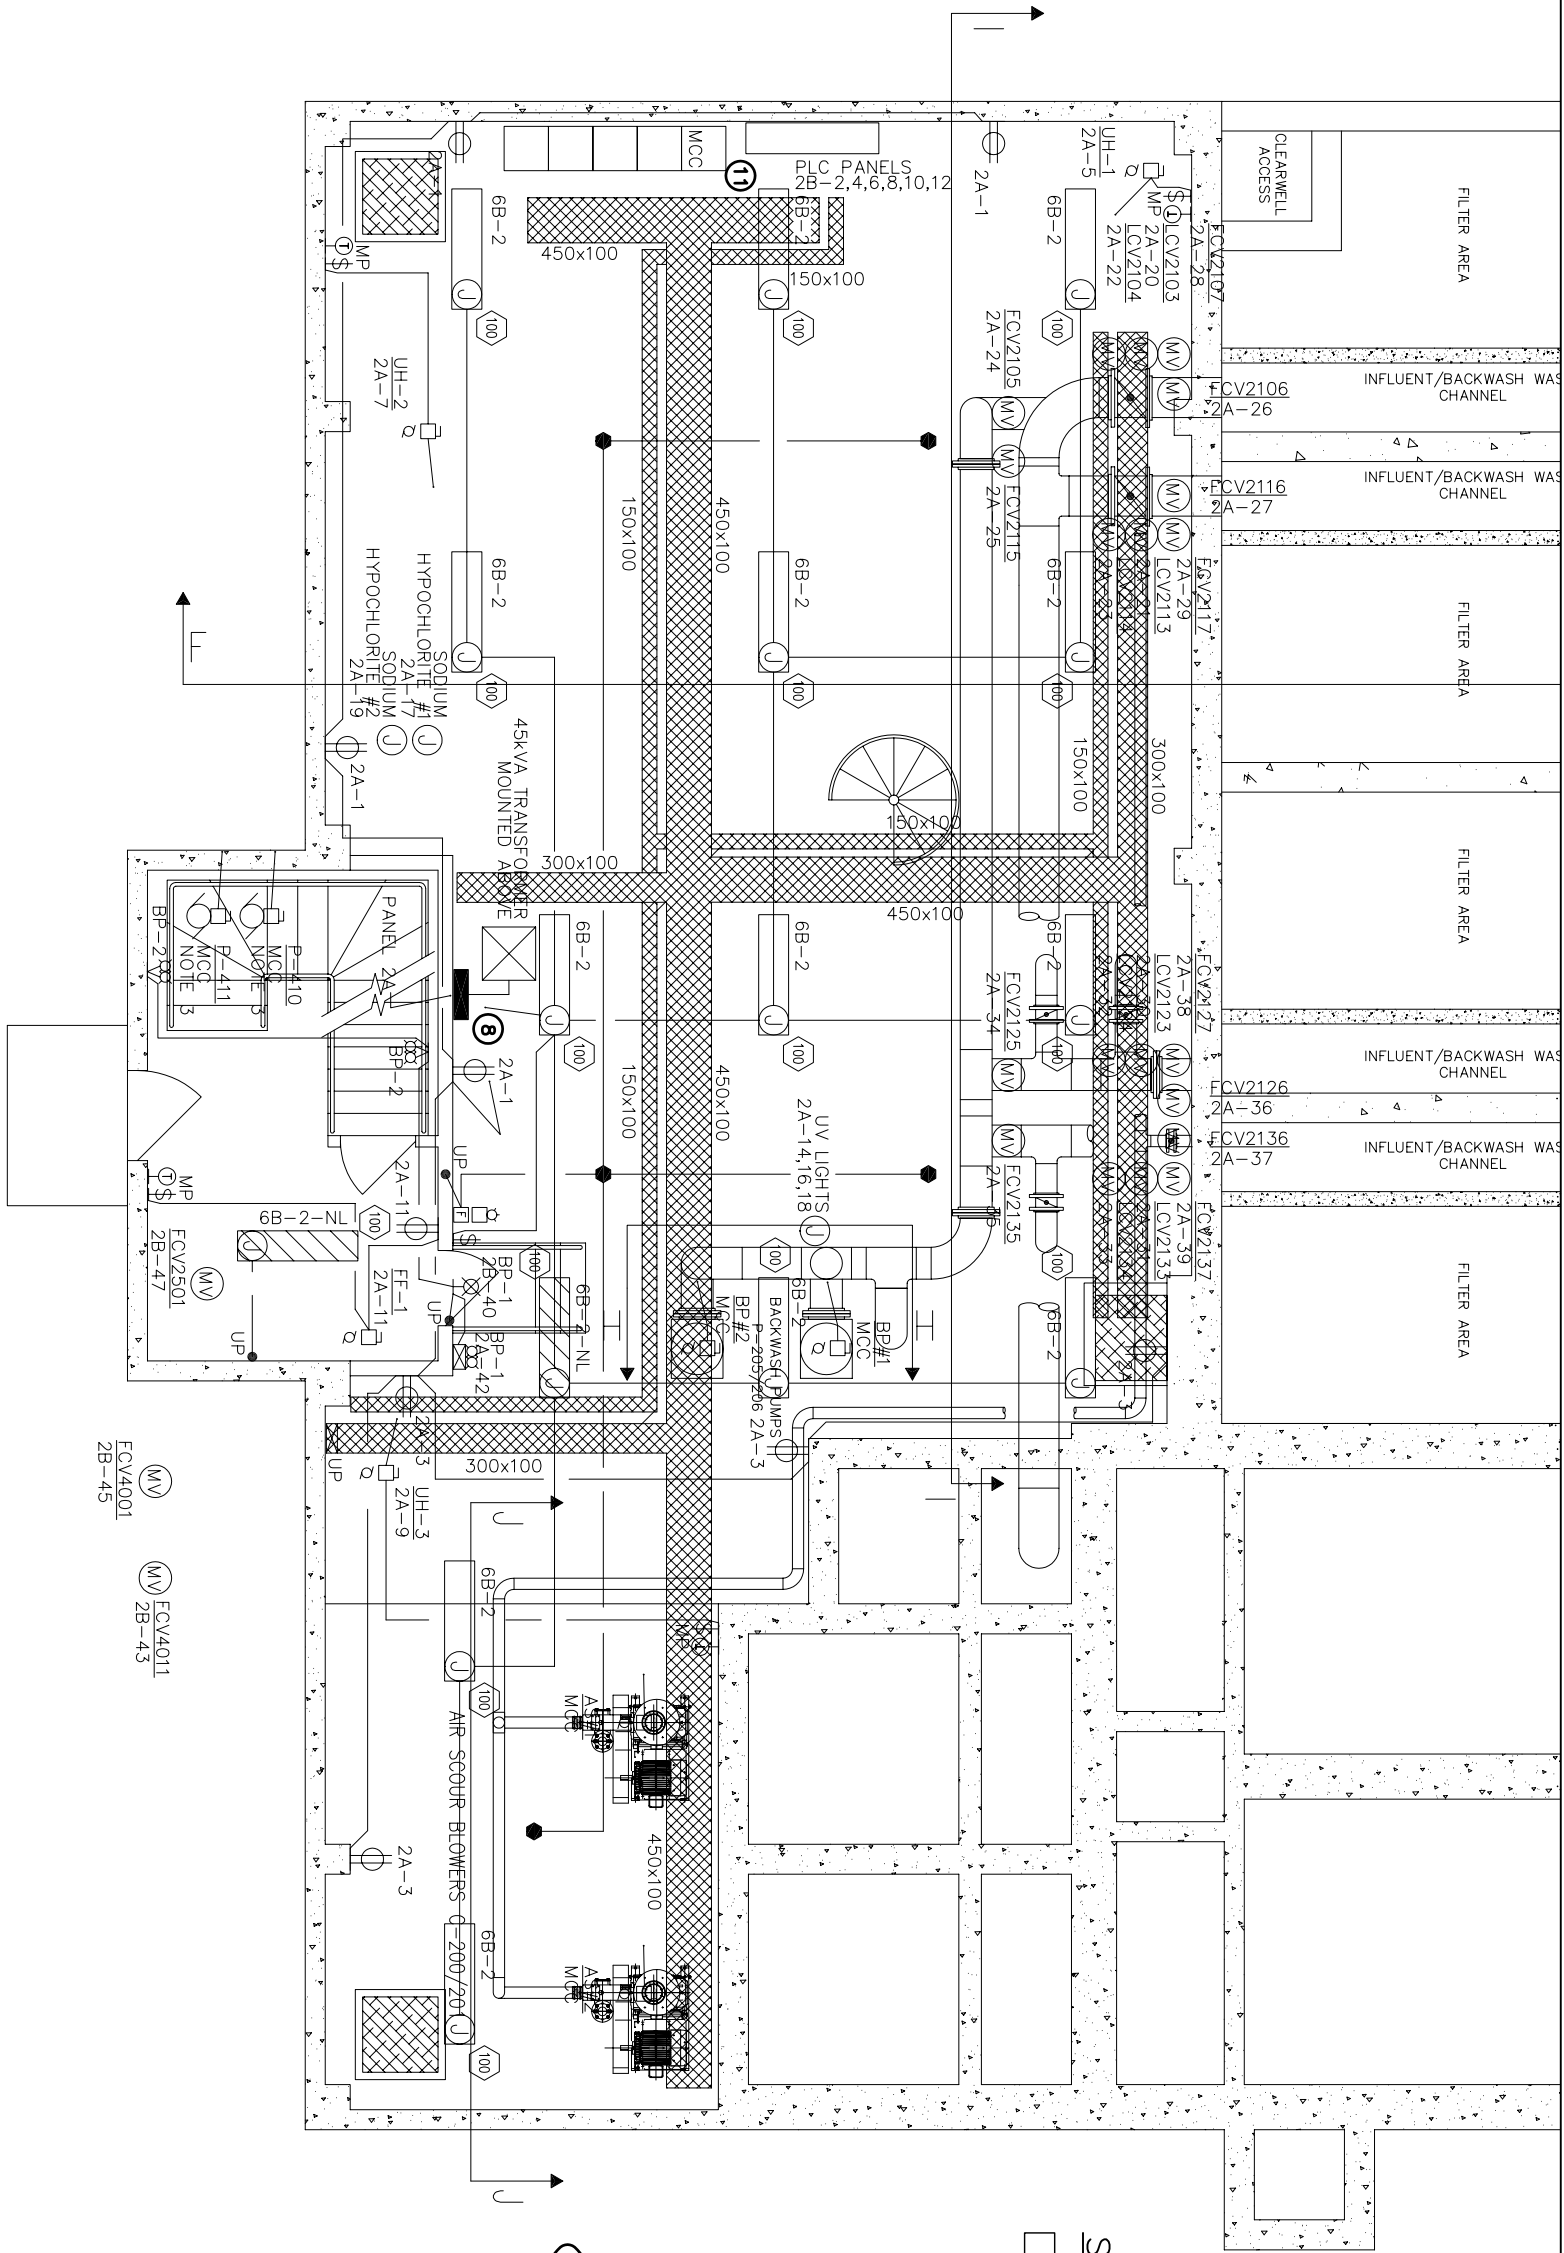

SYMBOL SCHEDULE	
	FLUORESCENT FIXTURE, 4', 2 LAMP ENCLOSED, GASKETTED.
	HID TYPE, HPS EXTERIOR WALL MOUNT FIXTURE
	BATTERY PACK
	REMOTE HEAD
	LUMINAIRE TYPE, SEE DRAWINGS
	LINE VOLTAGE SWITCH
	MOTOR PROTECTION SWITCH, C/W PILOT SWITCH
	TELEPHONE OUTLET
	CABLE OUTLET
	PANEL
	MOTOR ID TAG
	120 VOLT RECEPTACLE
	MOTOR, PUMP DESIGNATION
	LINE VOLTAGE THERMOSTAT
	JUNCTION BOX
	DISCONNECT SWITCH
	FIRE ALARM

POWER & SYSTEMS LOWER FLOOR PLAN

SCALE : NTS