


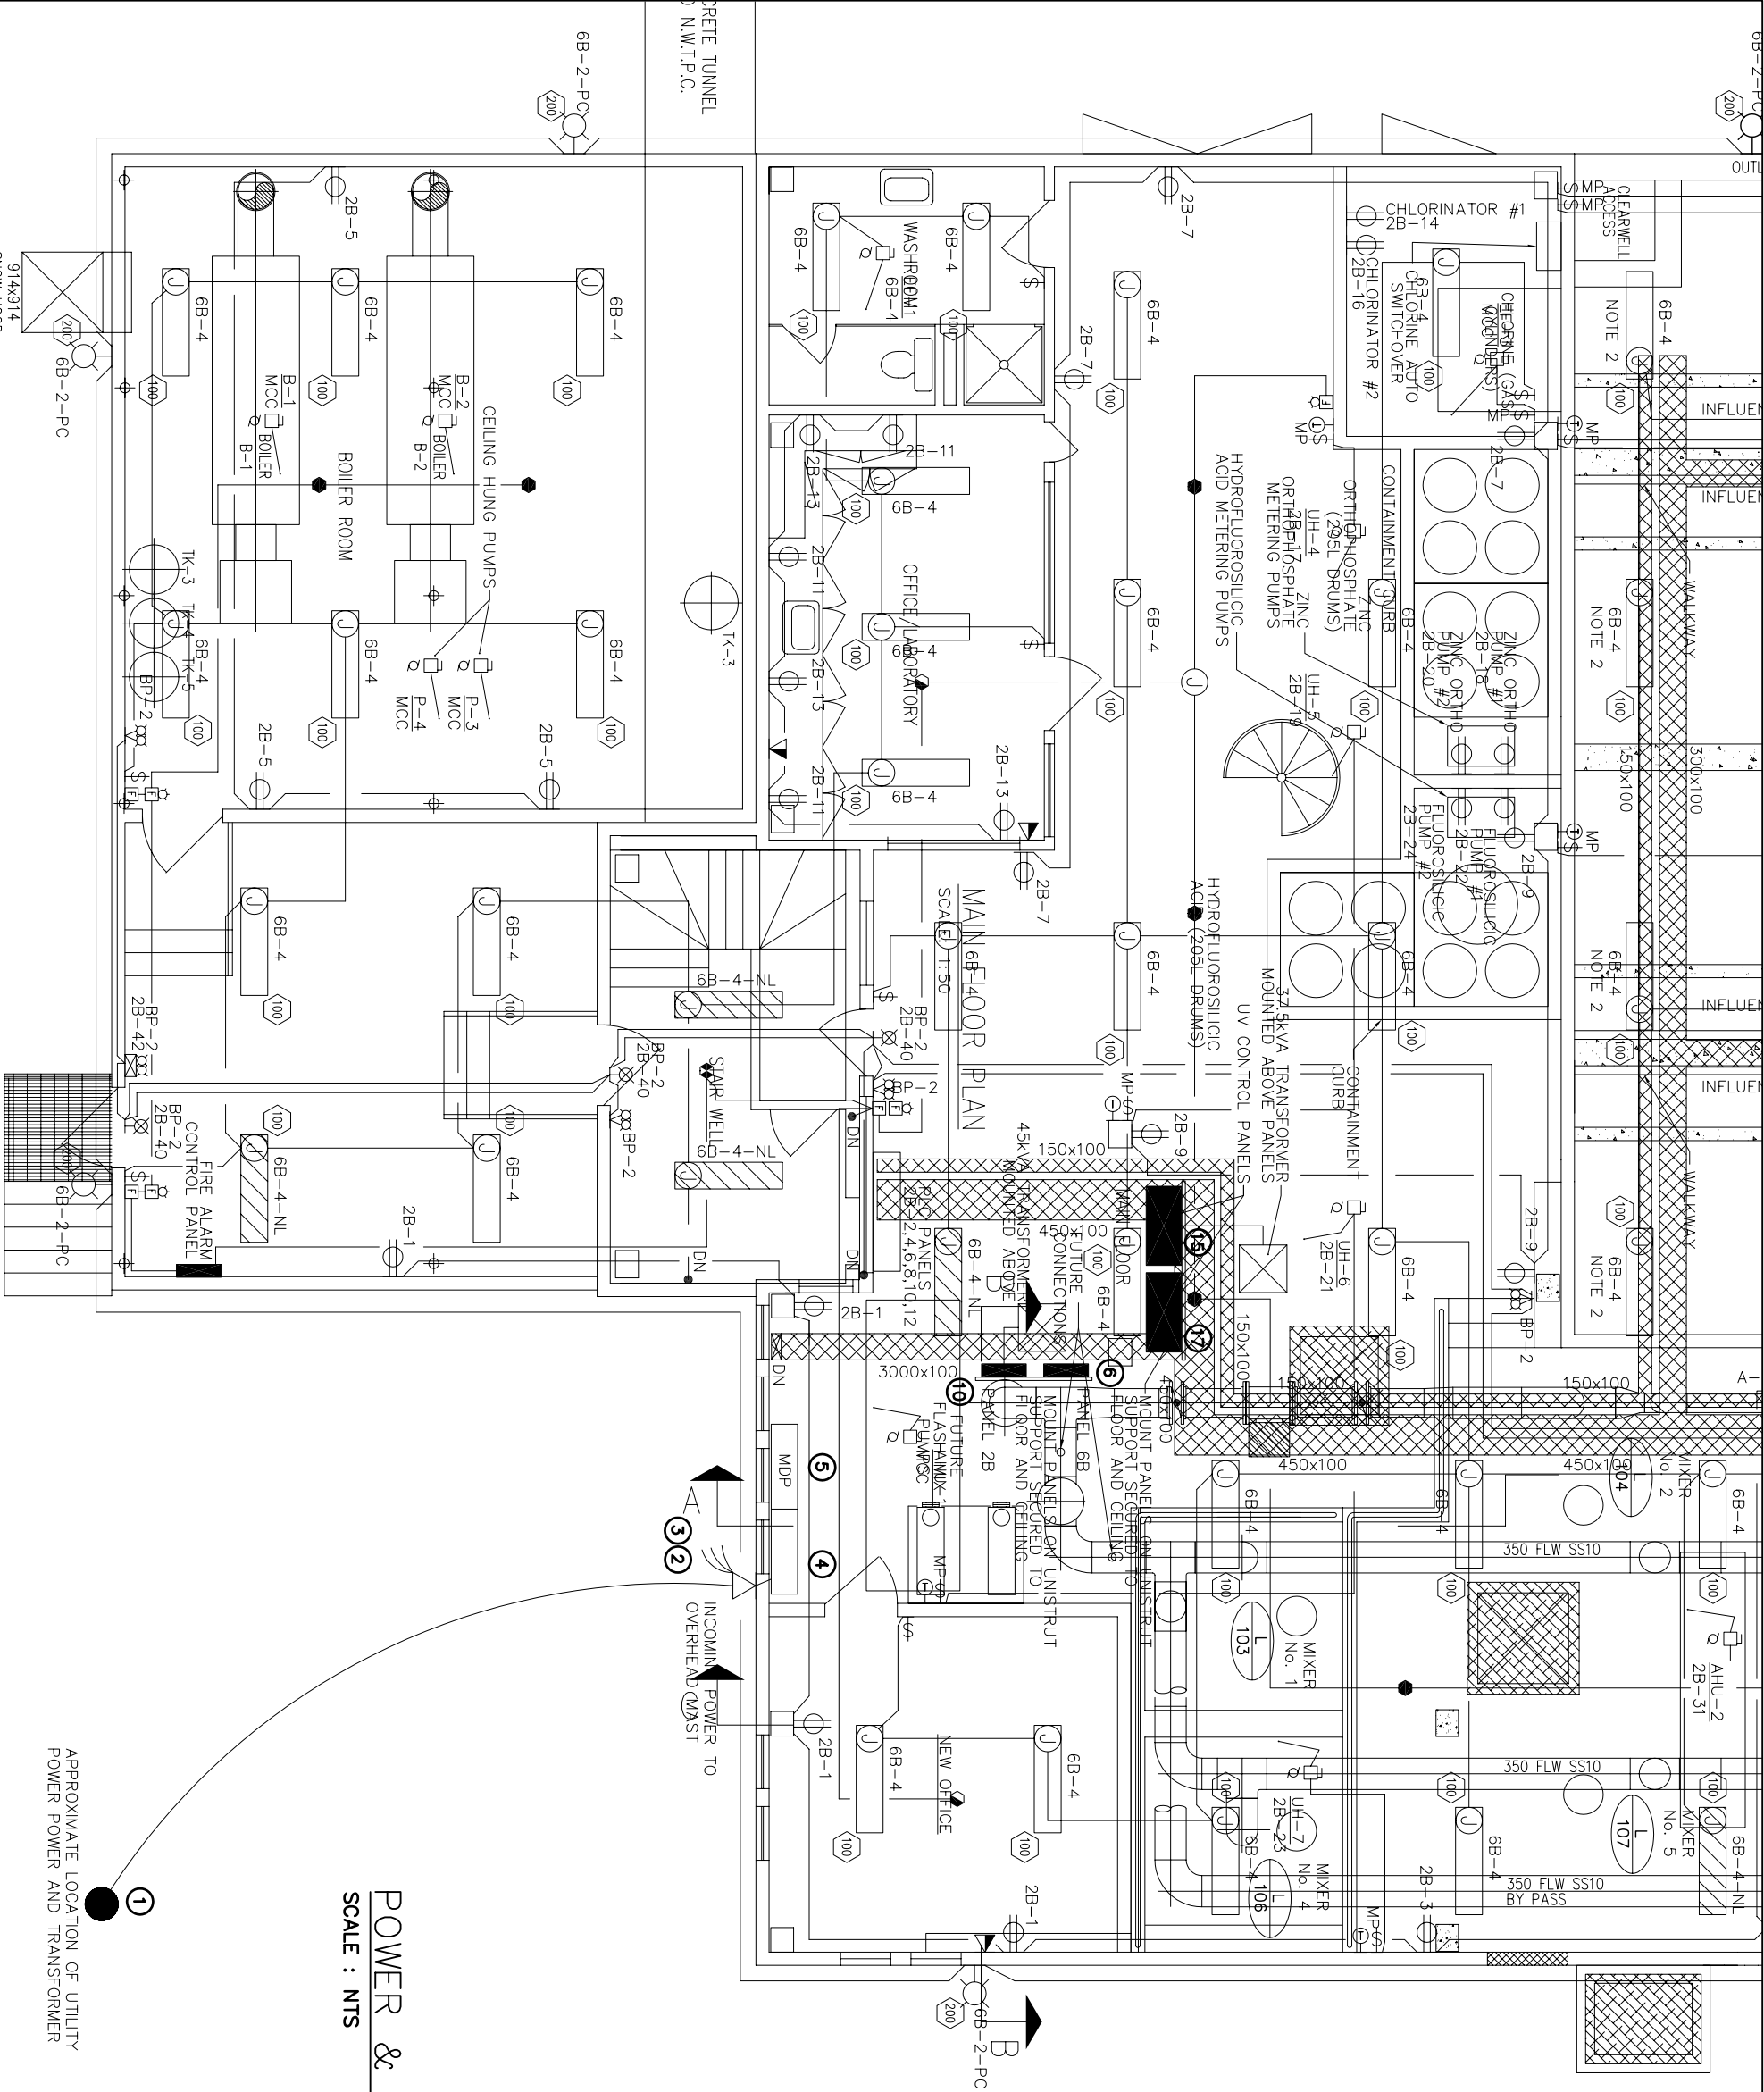

POWER & SYSTEMS UPPER FLOOR PLAN

SCALE : NTS