


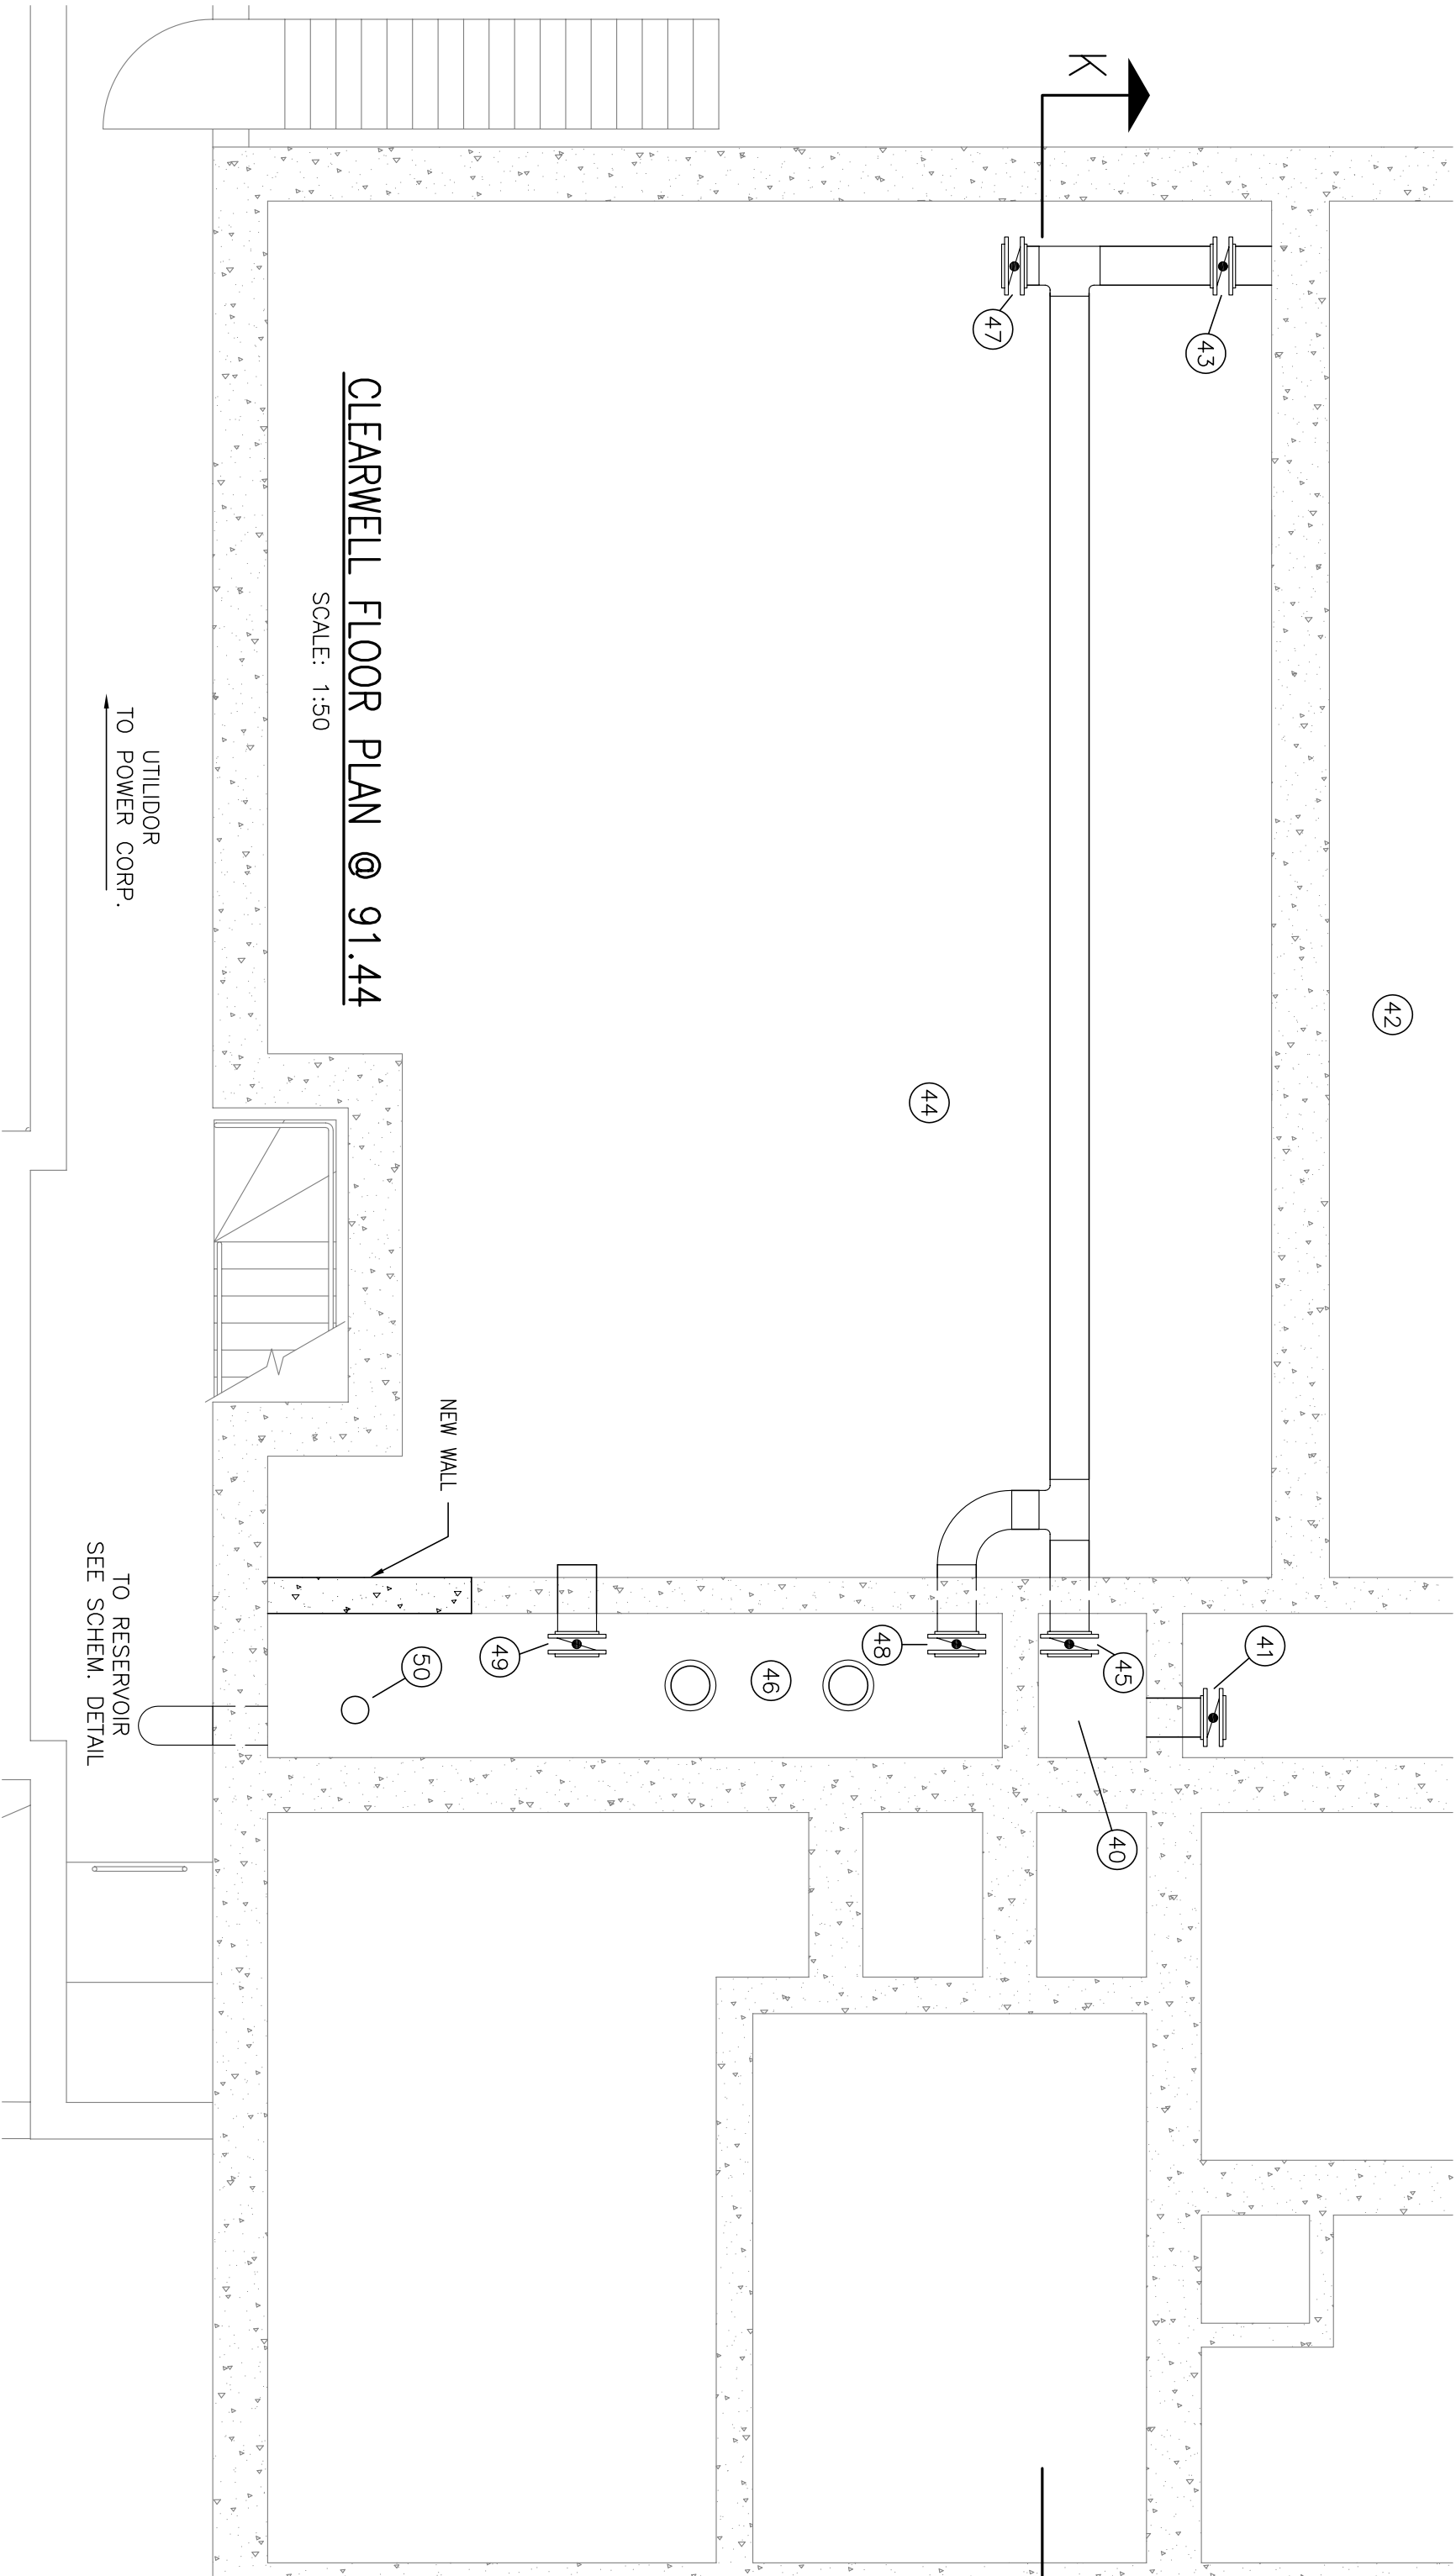

CLEARWELL FLOOR PLAN @ 91.44

SCALE: 1:50

UTILIDOR
TO POWER CORP.

TO RESERVOIR
SEE SCHEM. DETAIL

FILTERED WATER FLOW COMPONENTS

SCALE: N.T.S.



DRAWING

P-4

EARTH TECH

Earth Tech (Canada) Inc.



Edmonton, AB 780-488-6800
Yellowknife, NWT 867-873-6316