



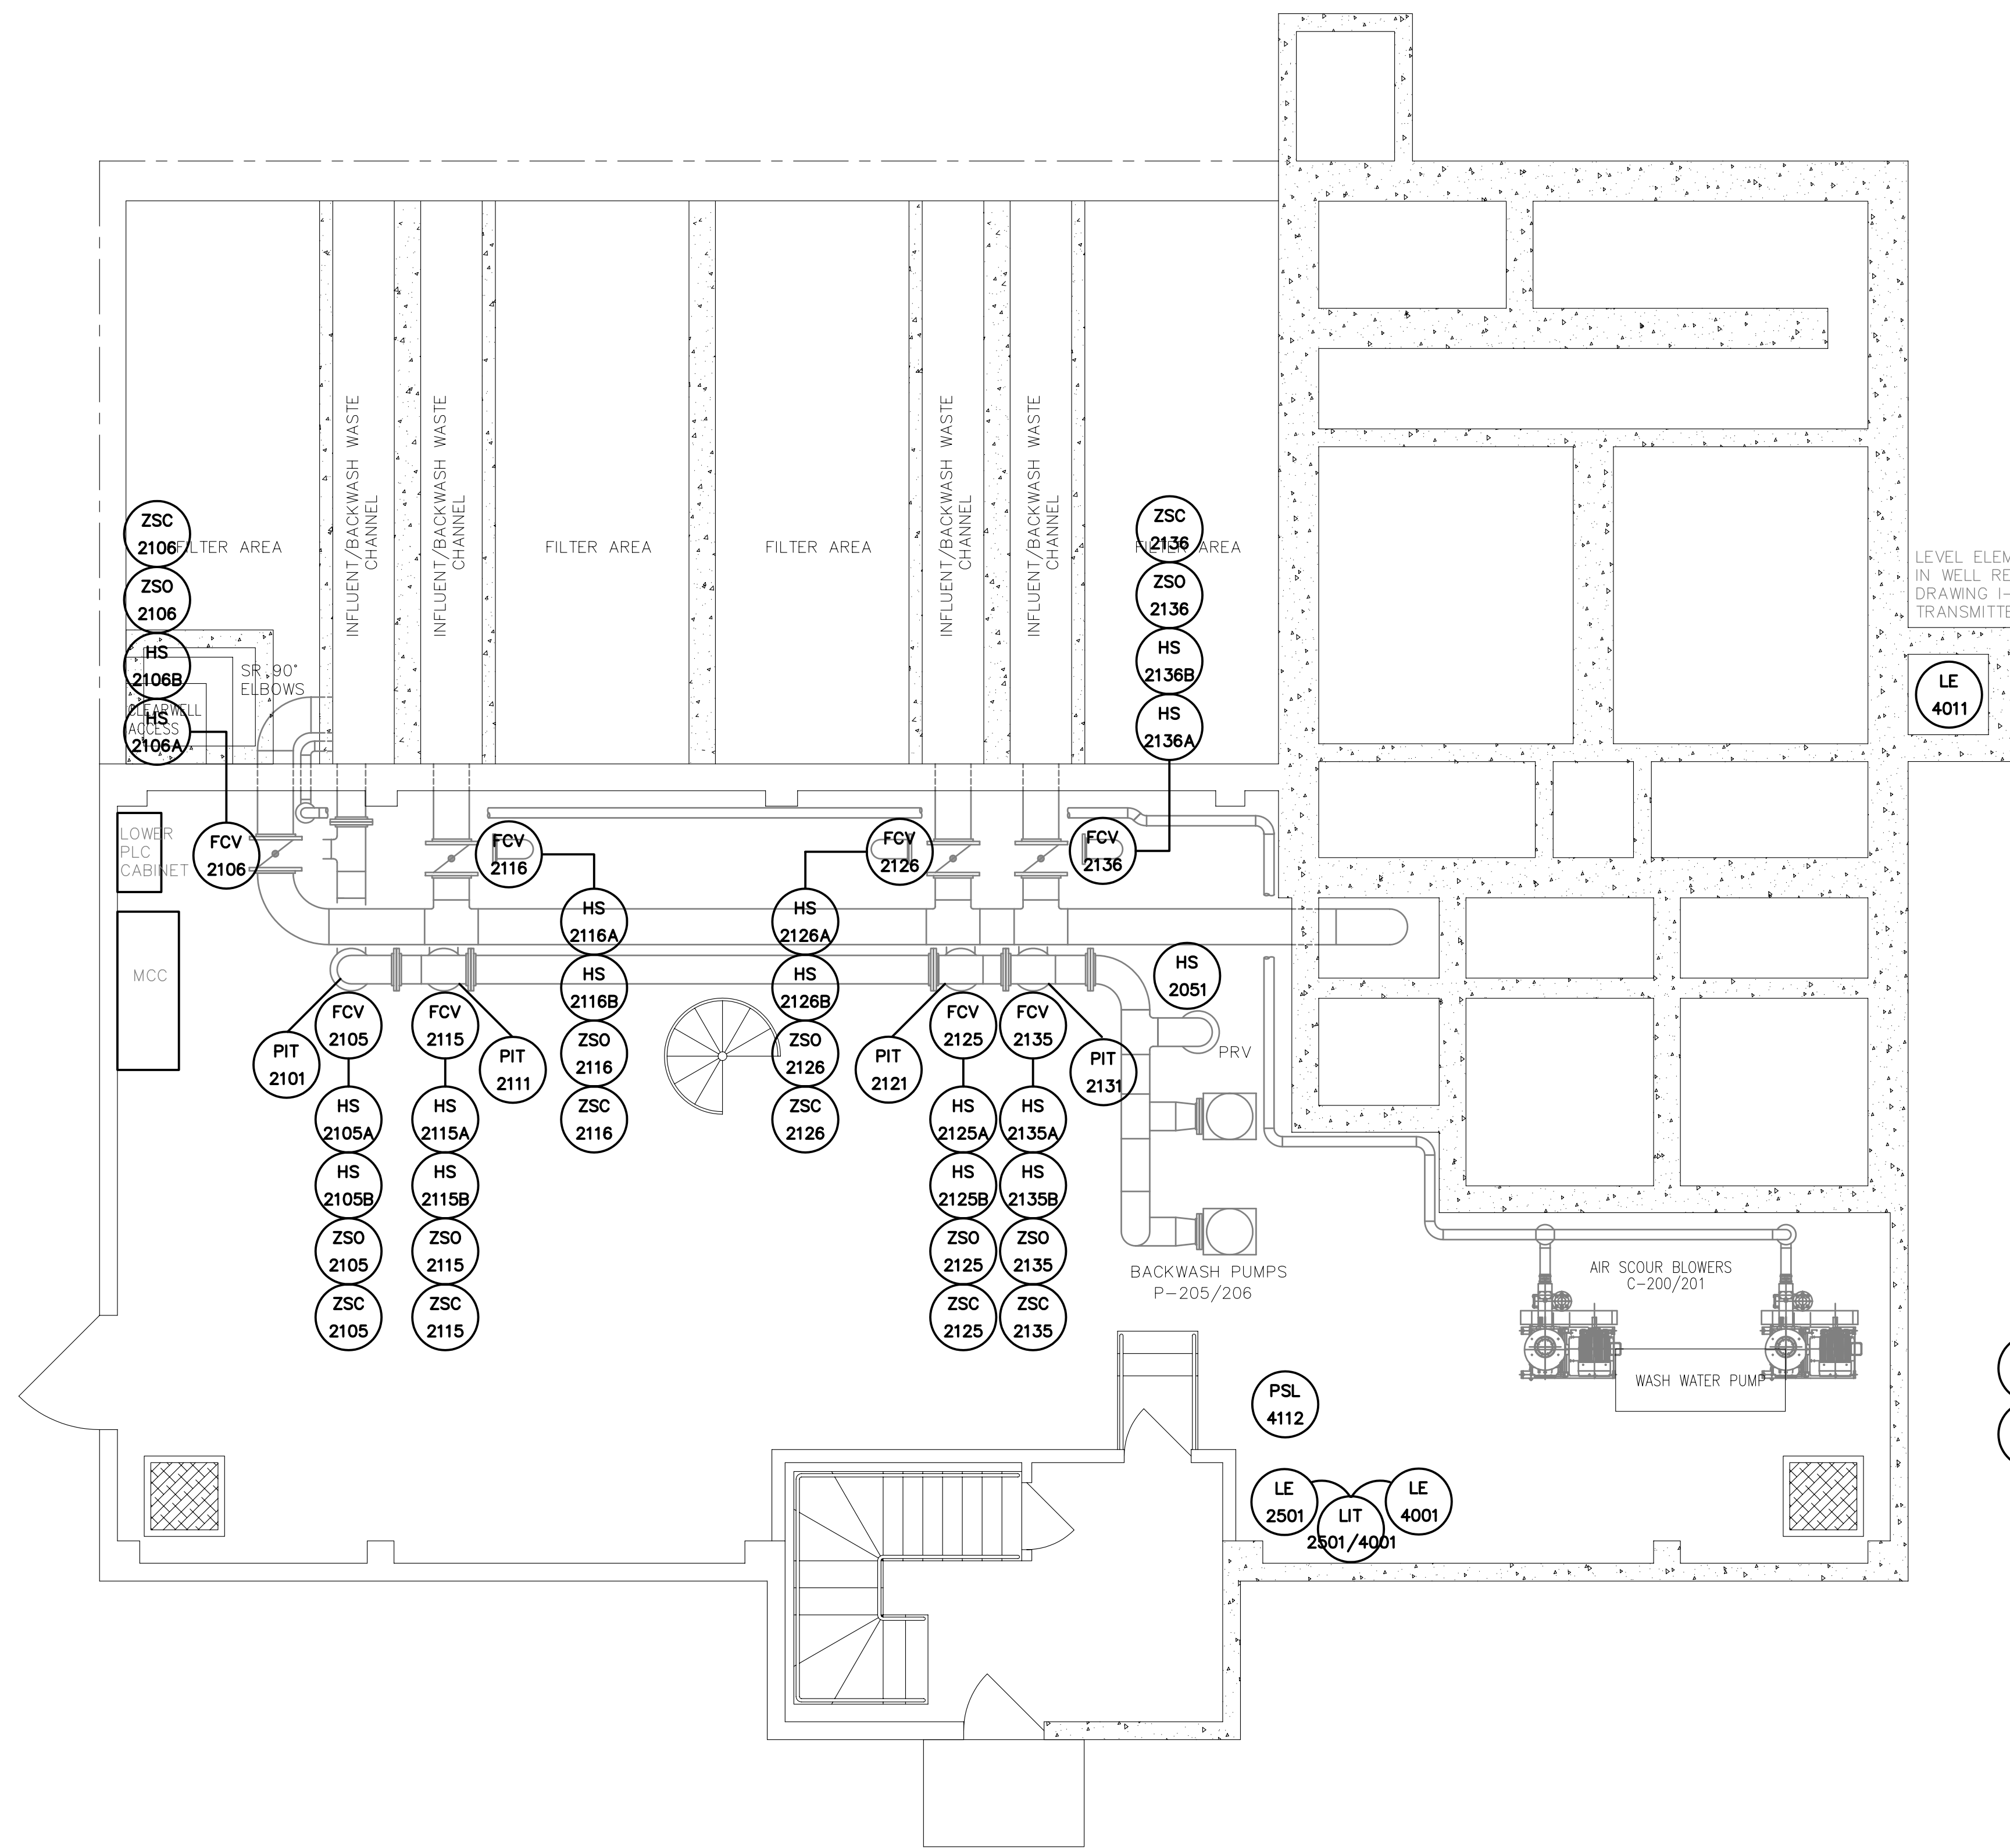

1 PUMPS FLOOR PLAN
SCALE : 1:50

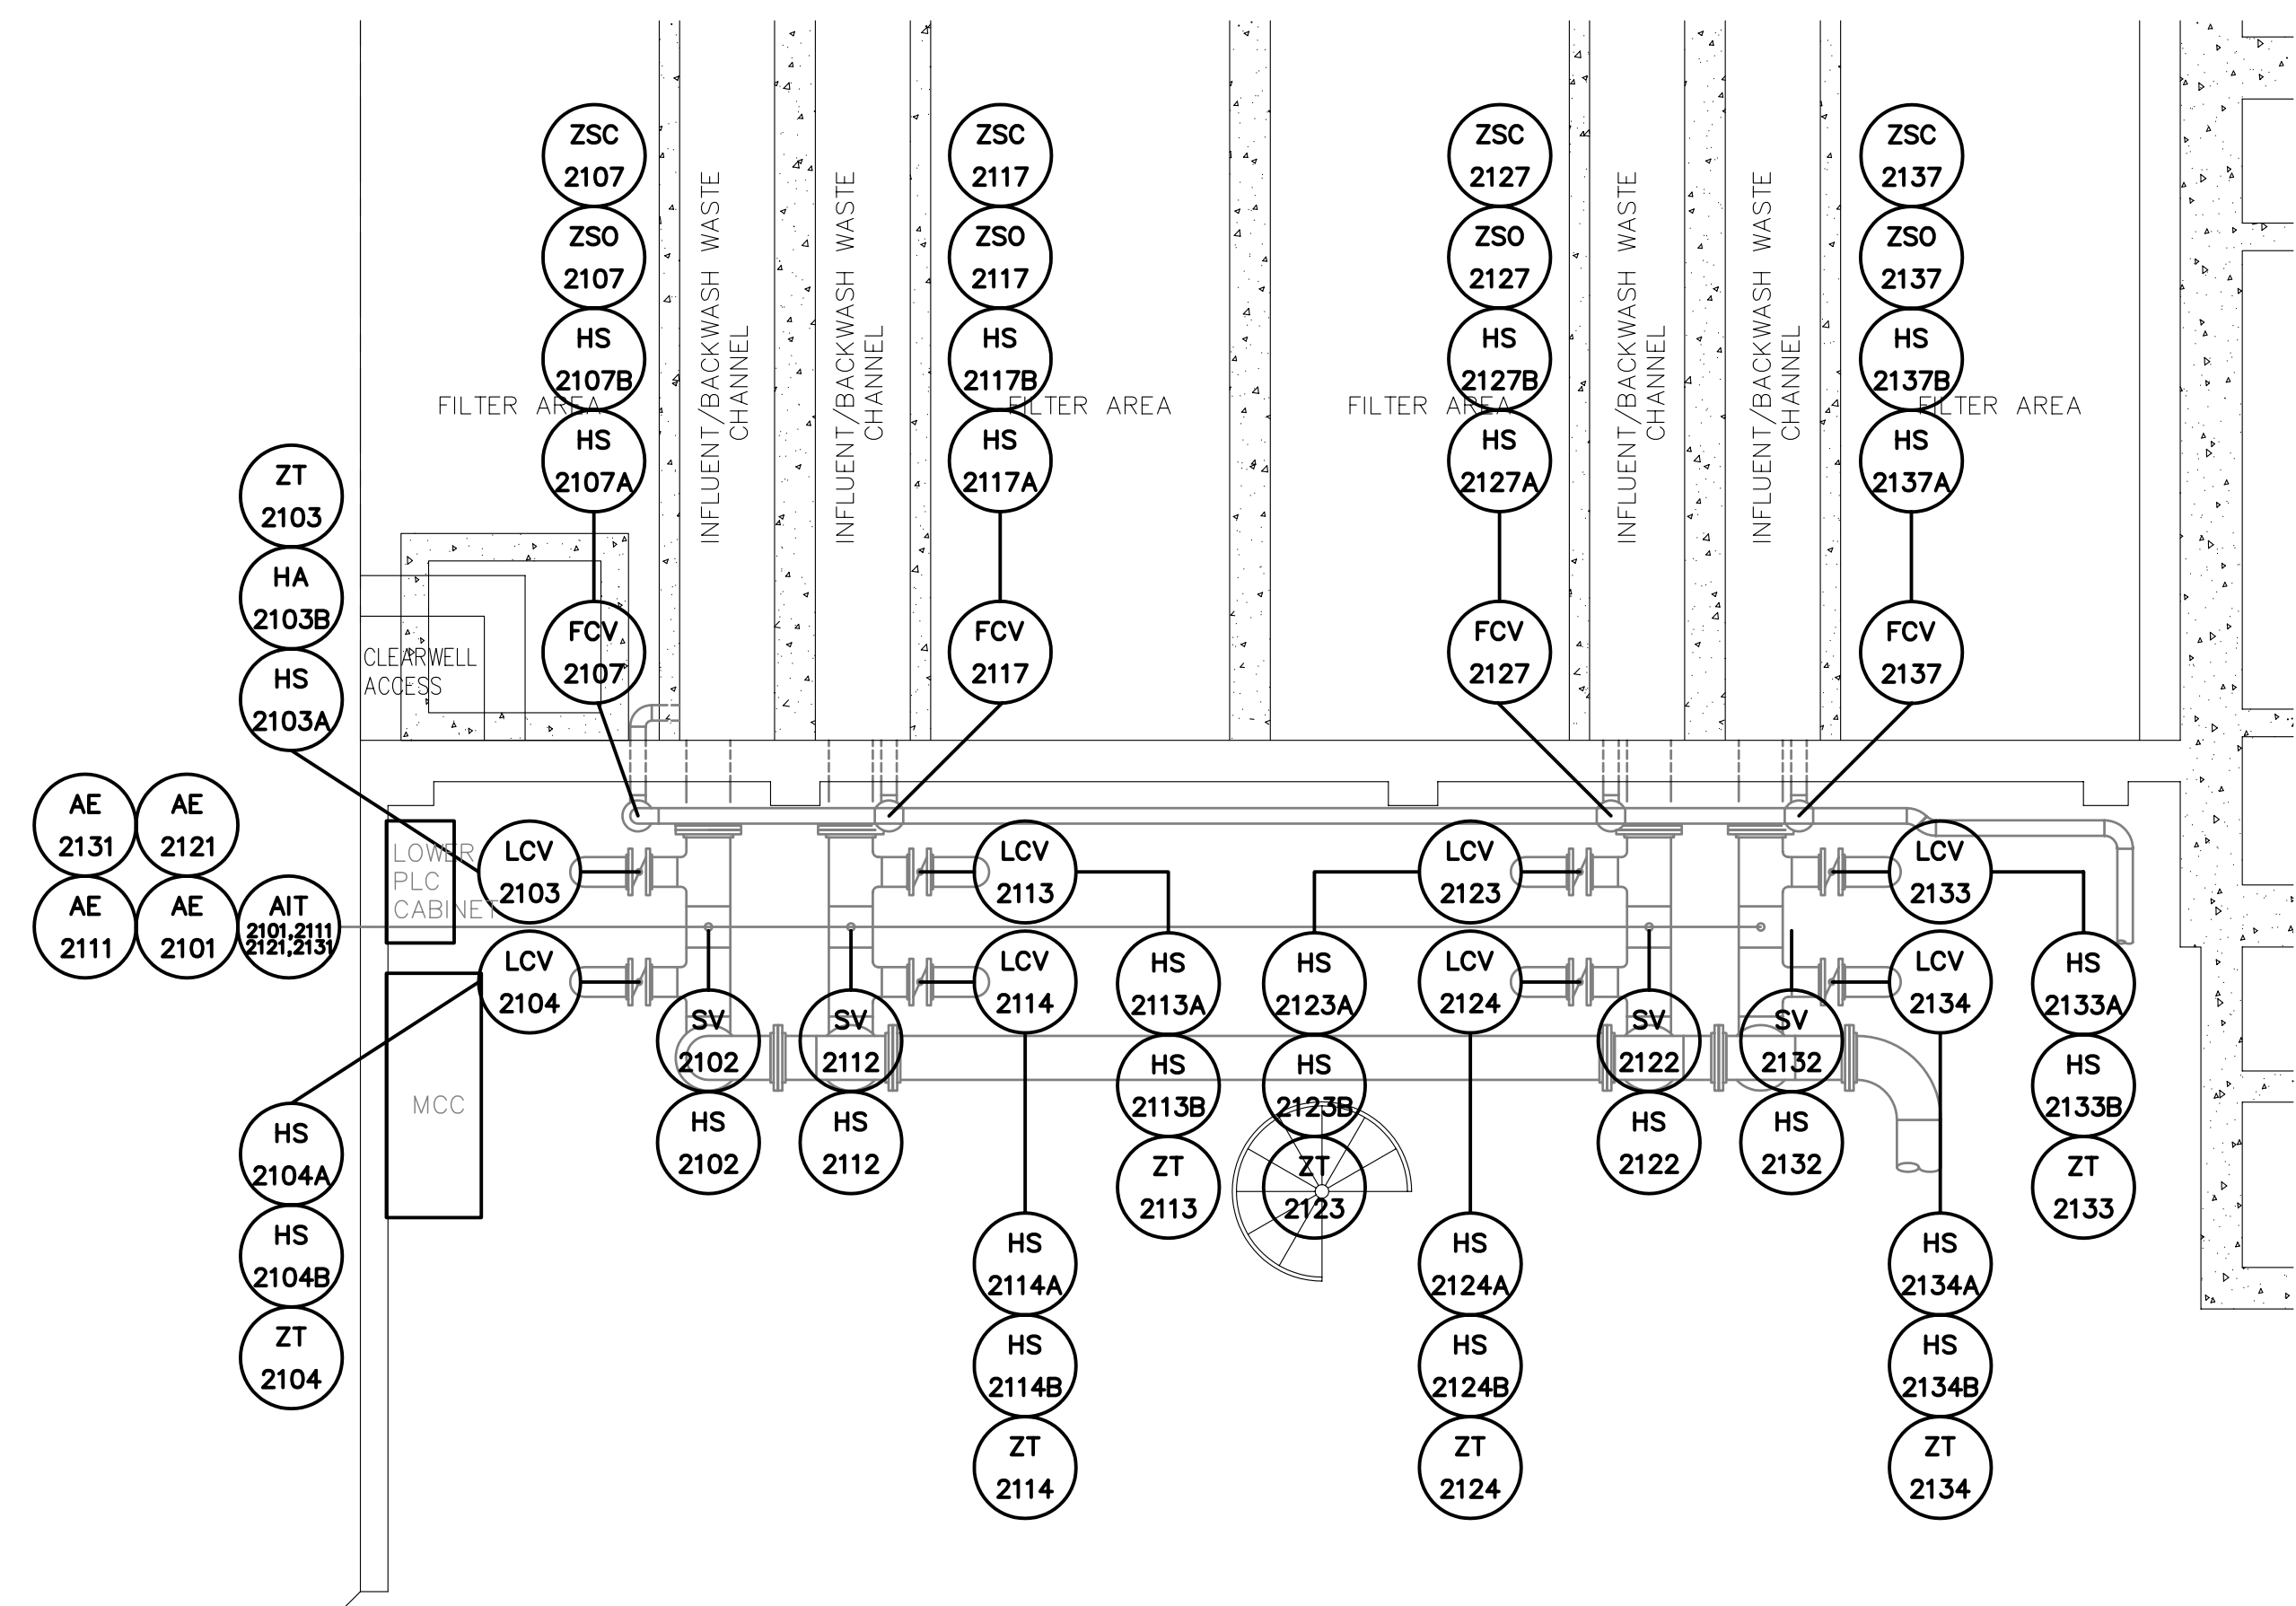

2 PARTIAL PUMPS FLOOR PLAN
SCALE : 1:50


NO.	REVISION	DATE	INITIAL
1	ISSUED FOR CONSTRUCTION	22/04/03	CKW
0	ISSUED FOR TENDER	19/02/03	CKW

Company Permit _____ Engineer Seal _____

RECORD DRAWING
INFORMATION CONTAINED IN THESE DRAWINGS IS AS SUPPLIED BY: SCHENDEL MECHANICAL CONTRACTING LTD. & VECTOR ELECTRIC & CONTROLS. THE COMPLETENESS AND ACCURACY OF THIS RECORD DRAWING IS NOT GUARANTEED. INFORMATION SHOULD BE VERIFIED ON LOCATION BEFORE USE.

INSTRUMENTATION

**PUMPS FLOOR
DEVICE
LOCATIONS**

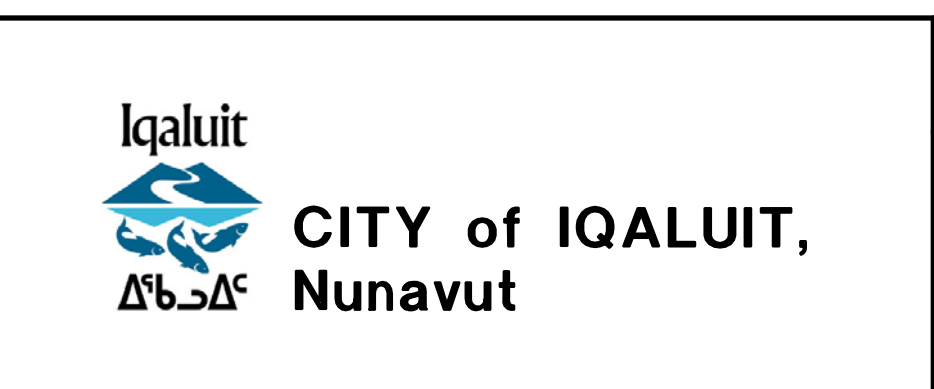

CITY OF IQALUIT

IQALUIT WATER TREATMENT PLANT

EARTH TECH

Earth Tech (Canada) Inc.

DRAWN BY: TDC	SCALE: AS NOTED	DATE: OCT. 2002	SHEET NO.
CHECKED BY: CKW	DWG NO.	REV. 1	CONTRACT 55524