


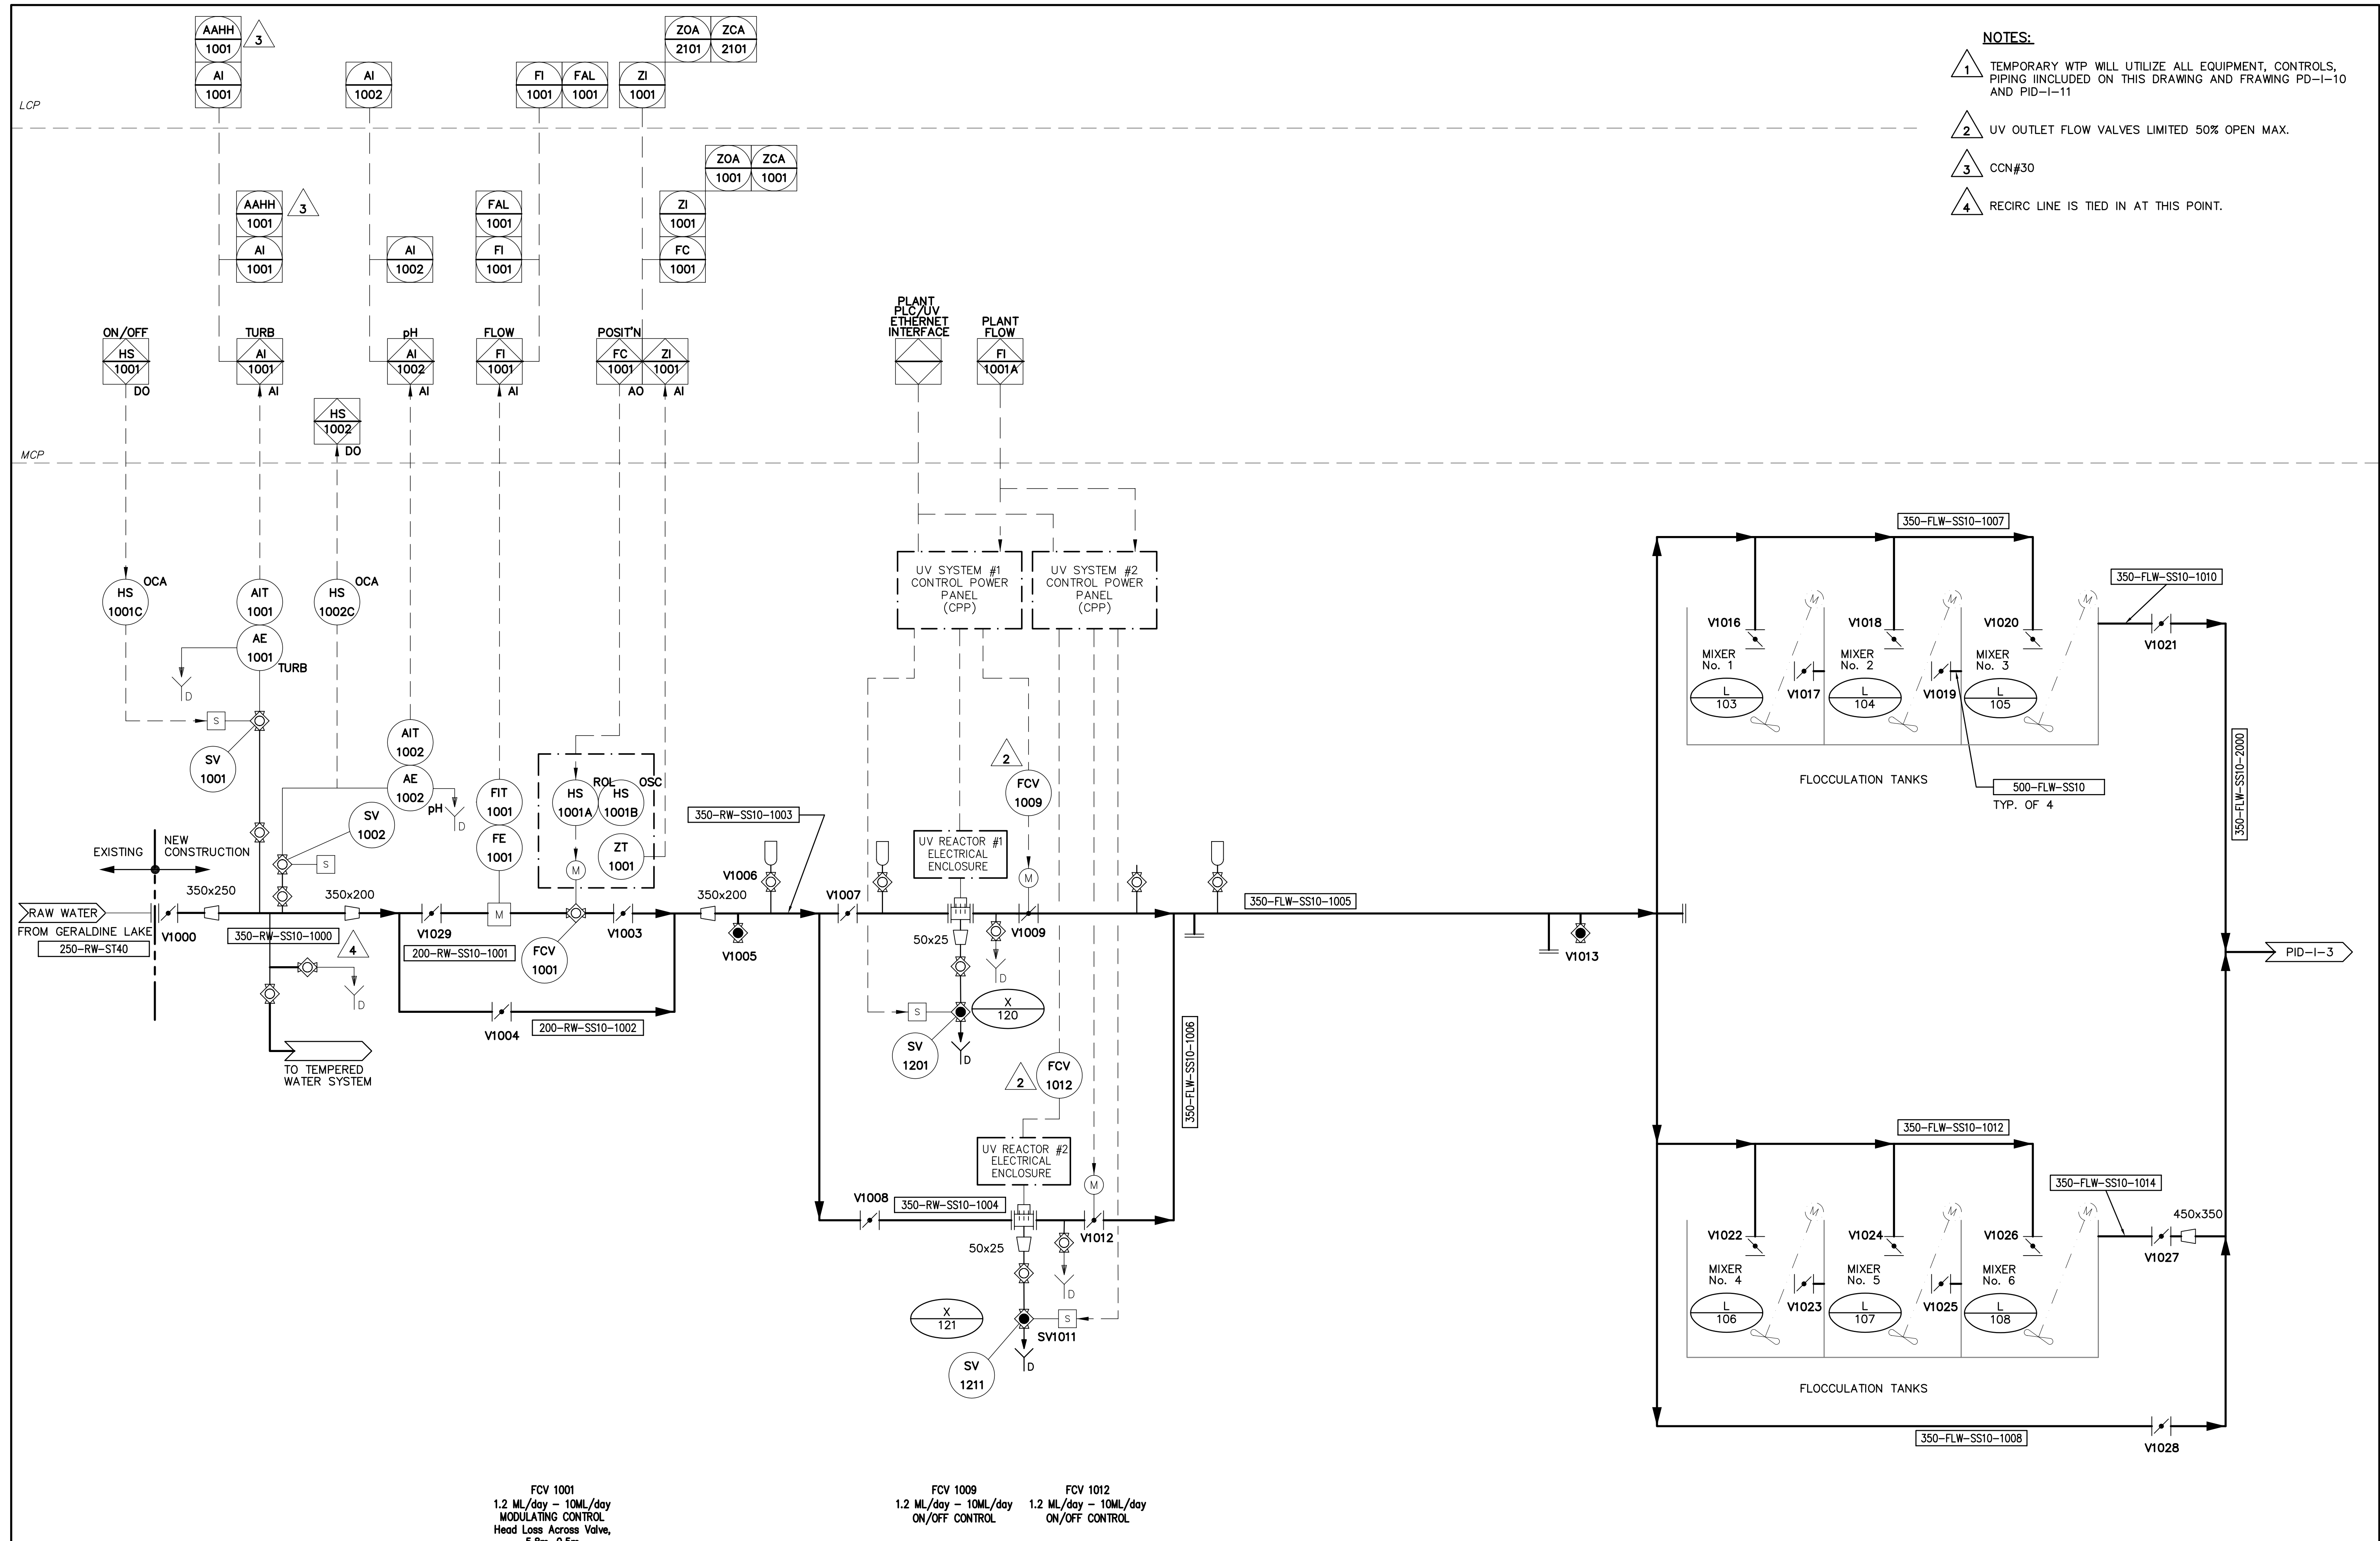

				Company Permit		Engineer Seal		PROCESS & INSTRUMENTATION		CITY OF IQALUIT		EARTH TECH	
				RECORD DRAWING		INFORMATION CONTAINED IN THESE DRAWINGS IS AS SUPPLIED BY: SCHENDEL MECHANICAL CONTRACTING LTD. & VECTOR ELECTRIC & CONTROLS. THE COMPLETENESS AND ACCURACY OF THIS RECORD DRAWING IS NOT GUARANTEED. INFORMATION SHOULD BE VERIFIED ON LOCATION BEFORE USE.		P & ID - PRE-TREATMENT		IQALUIT WATER TREATMENT PLANT		Earth Tech (Canada) Inc. Edmonton, Alberta 780.488.6800	
2				RECORD DRAWING		19/07/04						DRAWN BY: CKW	
1				ISSUED FOR CONSTRUCTION		22/04/03						CHECKED BY: CKW/JVH	
0				ISSUED FOR TENDER		19/02/03						CADD SYSTEM AutoCAD	
NO.				REVISION		DATE		INITIAL		1-2		REV. 2	
												SHEET NO.	
												CONTRACT 55524	