


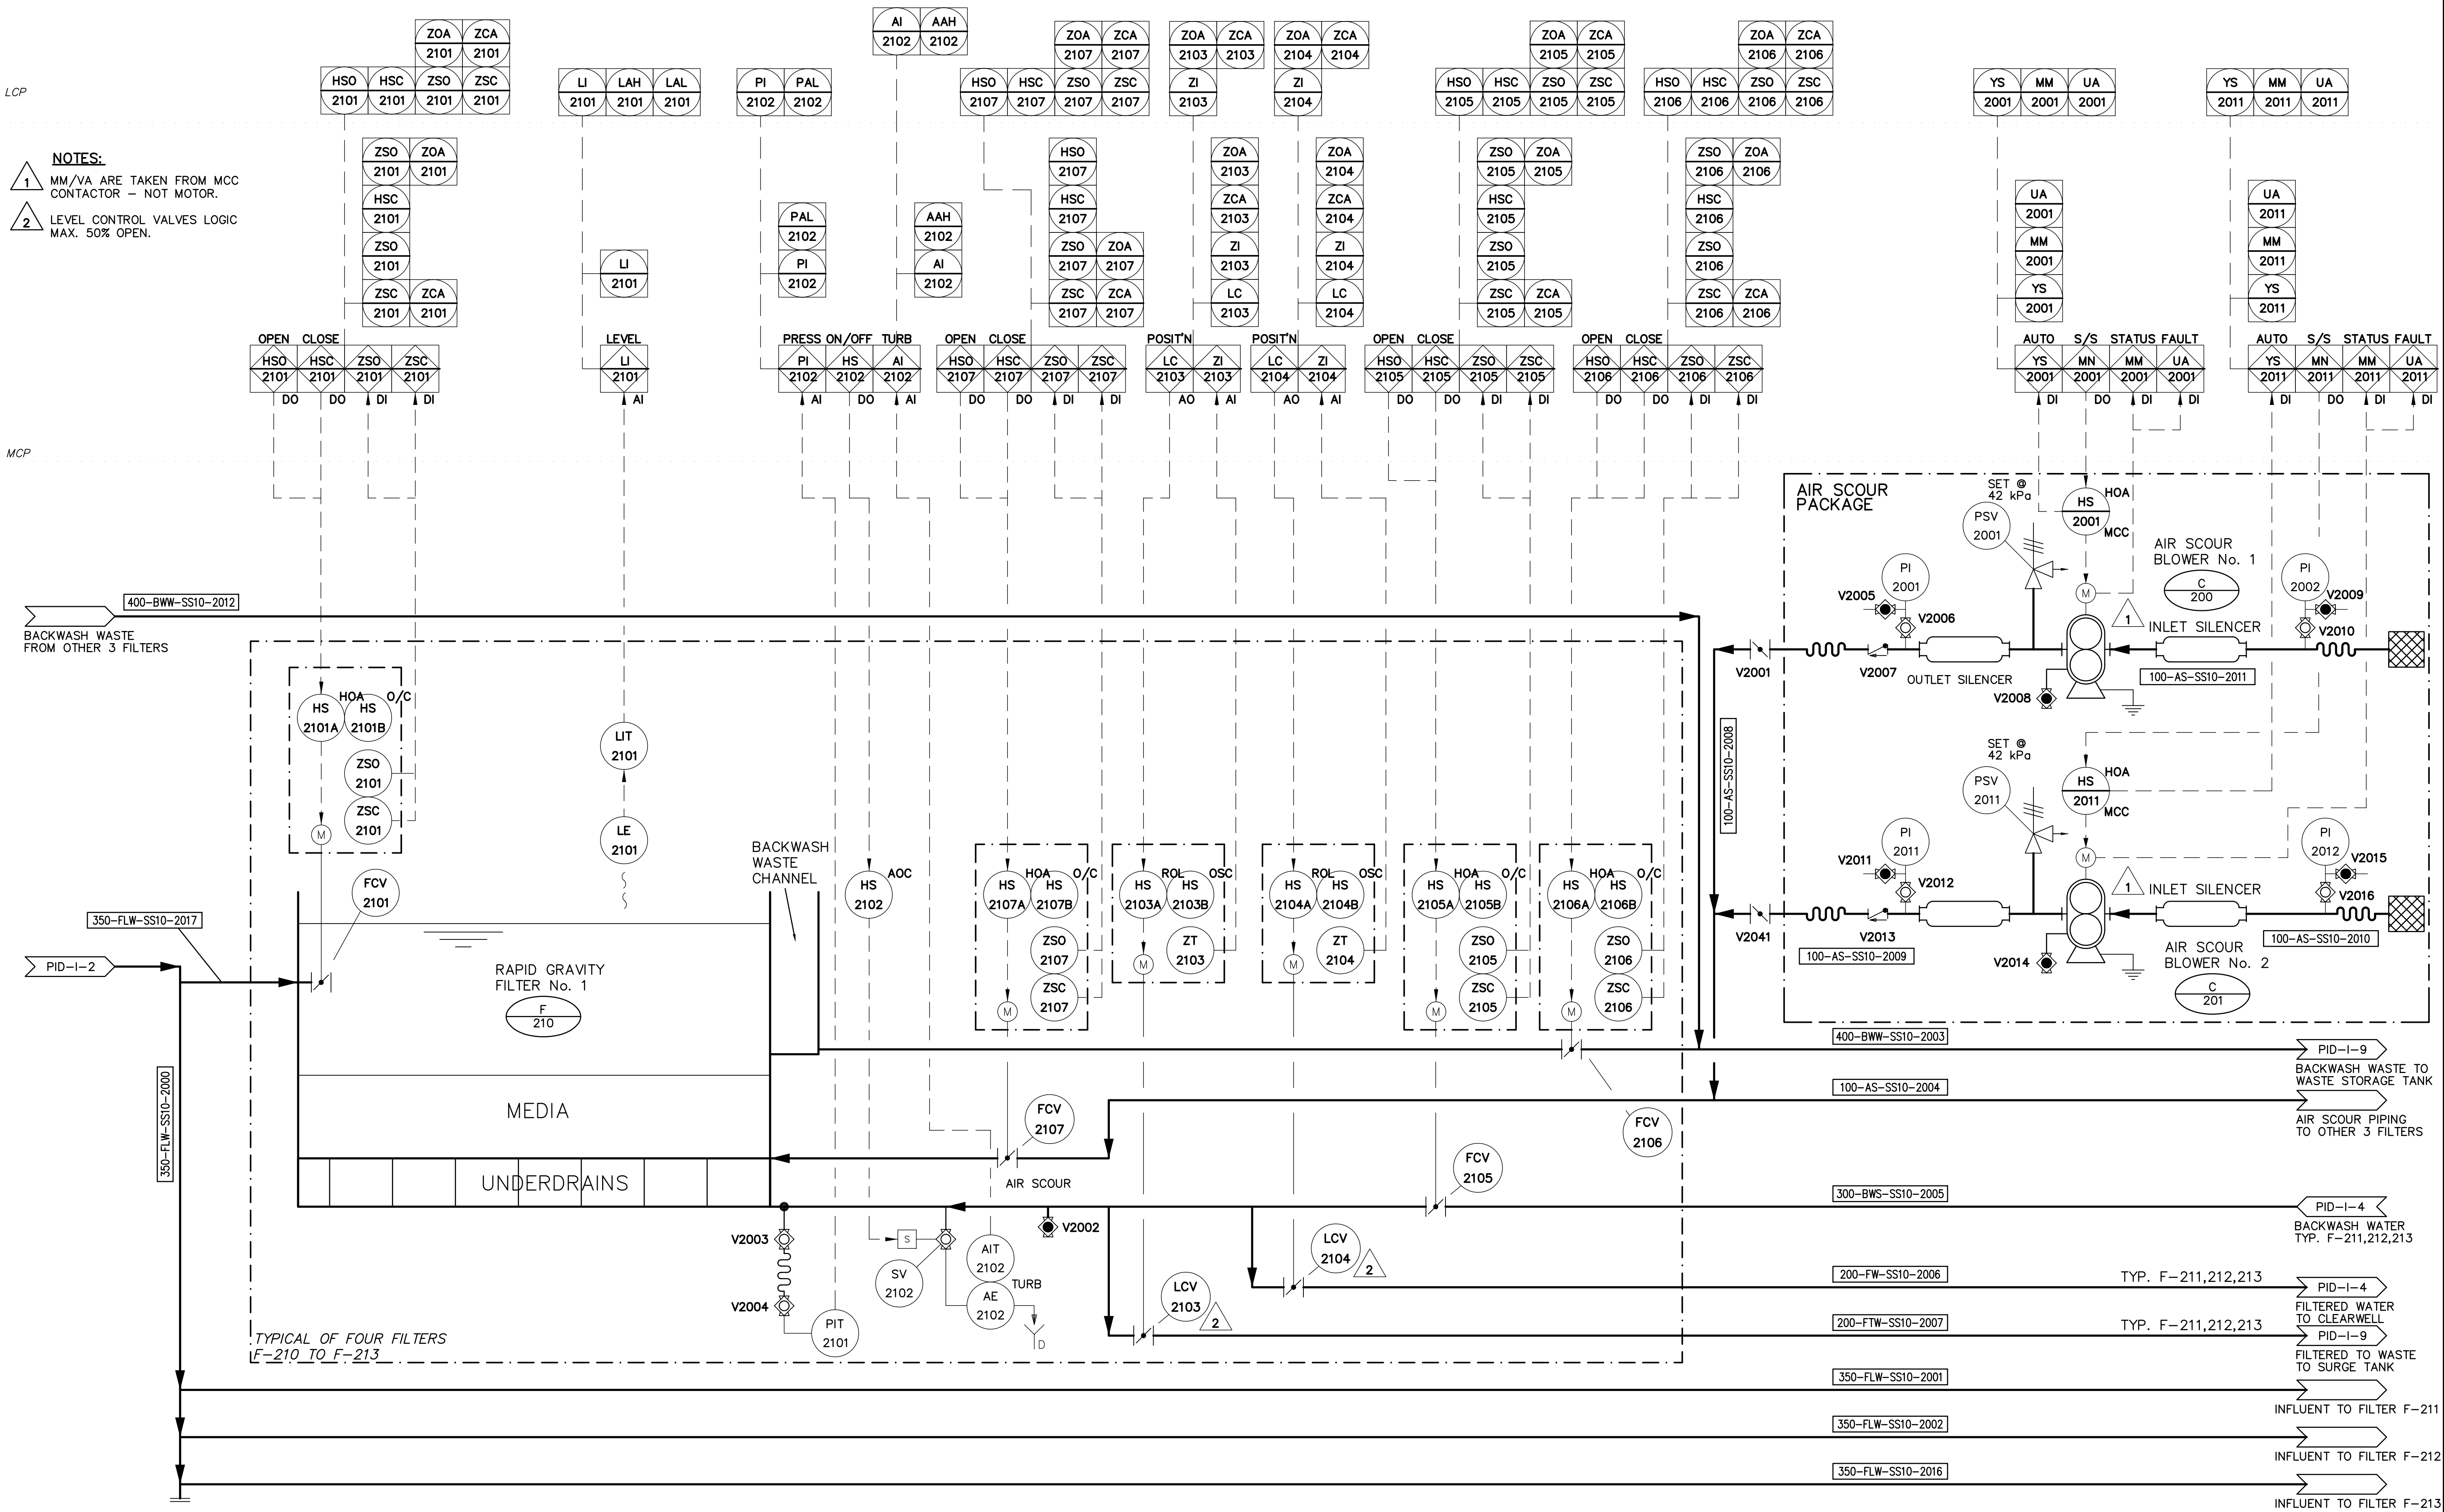

2

RECORD DRAWING

19/07/04

LL/YLC

1

ISSUED FOR CONSTRUCTION

22/04/03

CKW

0

ISSUED FOR TENDER

19/02/03

CKW

NO.

REVISION

DATE

INITIAL

Company Permit

Engineer Seal

RECORD DRAWING

INFORMATION CONTAINED IN THESE DRAWINGS IS AS SUPPLIED BY: SCHENDEL MECHANICAL CONTRACTING LTD. & VECTOR ELECTRIC & CONTROLS. THE COMPLETENESS AND ACCURACY OF THIS RECORD DRAWING IS NOT GUARANTEED. INFORMATION SHOULD BE VERIFIED ON LOCATION BEFORE USE.

PROCESS & INSTRUMENTATION

P & ID - FILTRATION

Iqaluit

CITY of IQALUIT,
Nunavut

CITY OF IQALUIT

IQALUIT WATER TREATMENT PLANT

Earth Tech (Canada) Inc.

DRAWN BY: CKW

CHECKED BY: CKW/JVH

CADD SYSTEM: AutoCAD

SCALE: AS NOTED

DWG NO. 1-3

DATE: FEB. 02/02/03

REV. 2

SHEET NO.

CONTRACT 55524

10/19/04 01:19pm richard.henderson L:\work\55000\55524\03-Report\O&M DISC\PROJECT RECORD DRAWINGS\55524-I 3 Record-July 2004.dwg Layout:1-3