


- NOTES:**
- 1 MM/VA ARE TAKEN FROM MCC CONTACTOR - NOT MOTOR.
 - 2 LEVEL CONTROL VALVES LOGIC MAX. 50% OPEN.

LCP

MCP

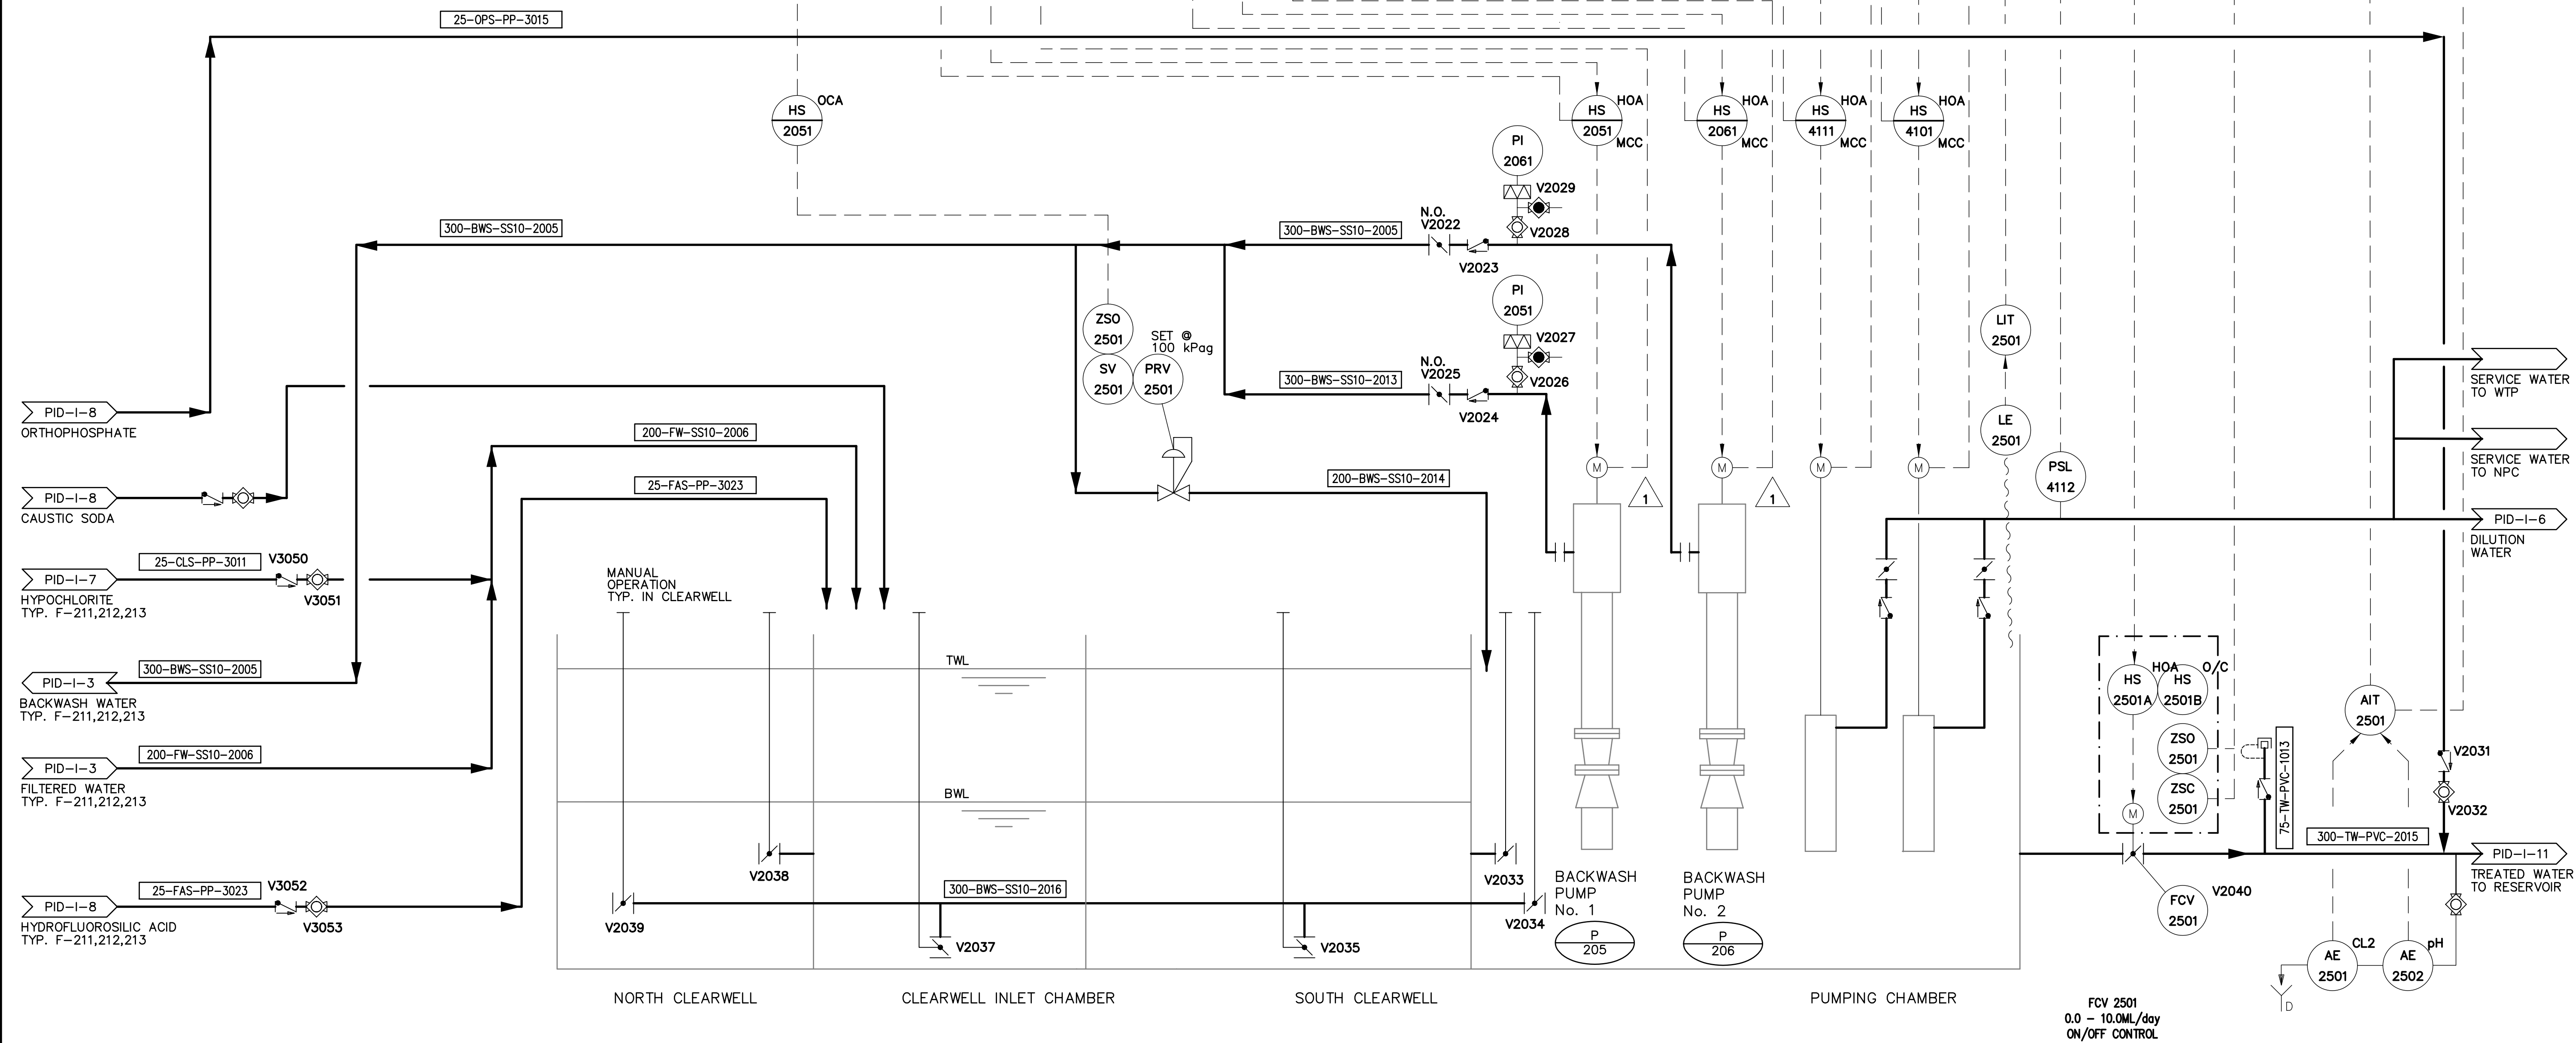

NO.	REVISION	DATE	INITIAL
2	RECORD DRAWING	19/07/04	LL
1	ISSUED FOR CONSTRUCTION	22/04/03	CKW
0	ISSUED FOR TENDER	19/02/03	CKW

Company Permit
Engineer Seal

RECORD DRAWING
INFORMATION CONTAINED IN THESE DRAWINGS IS AS SUPPLIED BY: SCHENDEL MECHANICAL CONTRACTING LTD. & VECTOR ELECTRIC & CONTROLS. THE COMPLETENESS AND ACCURACY OF THIS RECORD DRAWING IS NOT GUARANTEED. INFORMATION SHOULD BE VERIFIED ON LOCATION BEFORE USE.

PROCESS & INSTRUMENTATION

P & ID - CLEARWELL & BACKWASH SUPPLY



CITY OF IQALUIT

IQALUIT WATER TREATMENT PLANT

EARTH TECH

Earth Tech (Canada) Inc.

DRAWN BY: CKW	SCALE: NOT NOTED	DATE: FEB. 02/02/03	SHEET NO.
CHECKED BY: CKW/JVH	DWG NO.	REV. 2	CONTRACT 55524
CADD SYSTEM AutoCAD	1-4		