


LCP

MCP

NOTES:
1 LINES ARE CONNECTED TO MAIN SEWAGE LINE C/W ORIFICE PLATE.

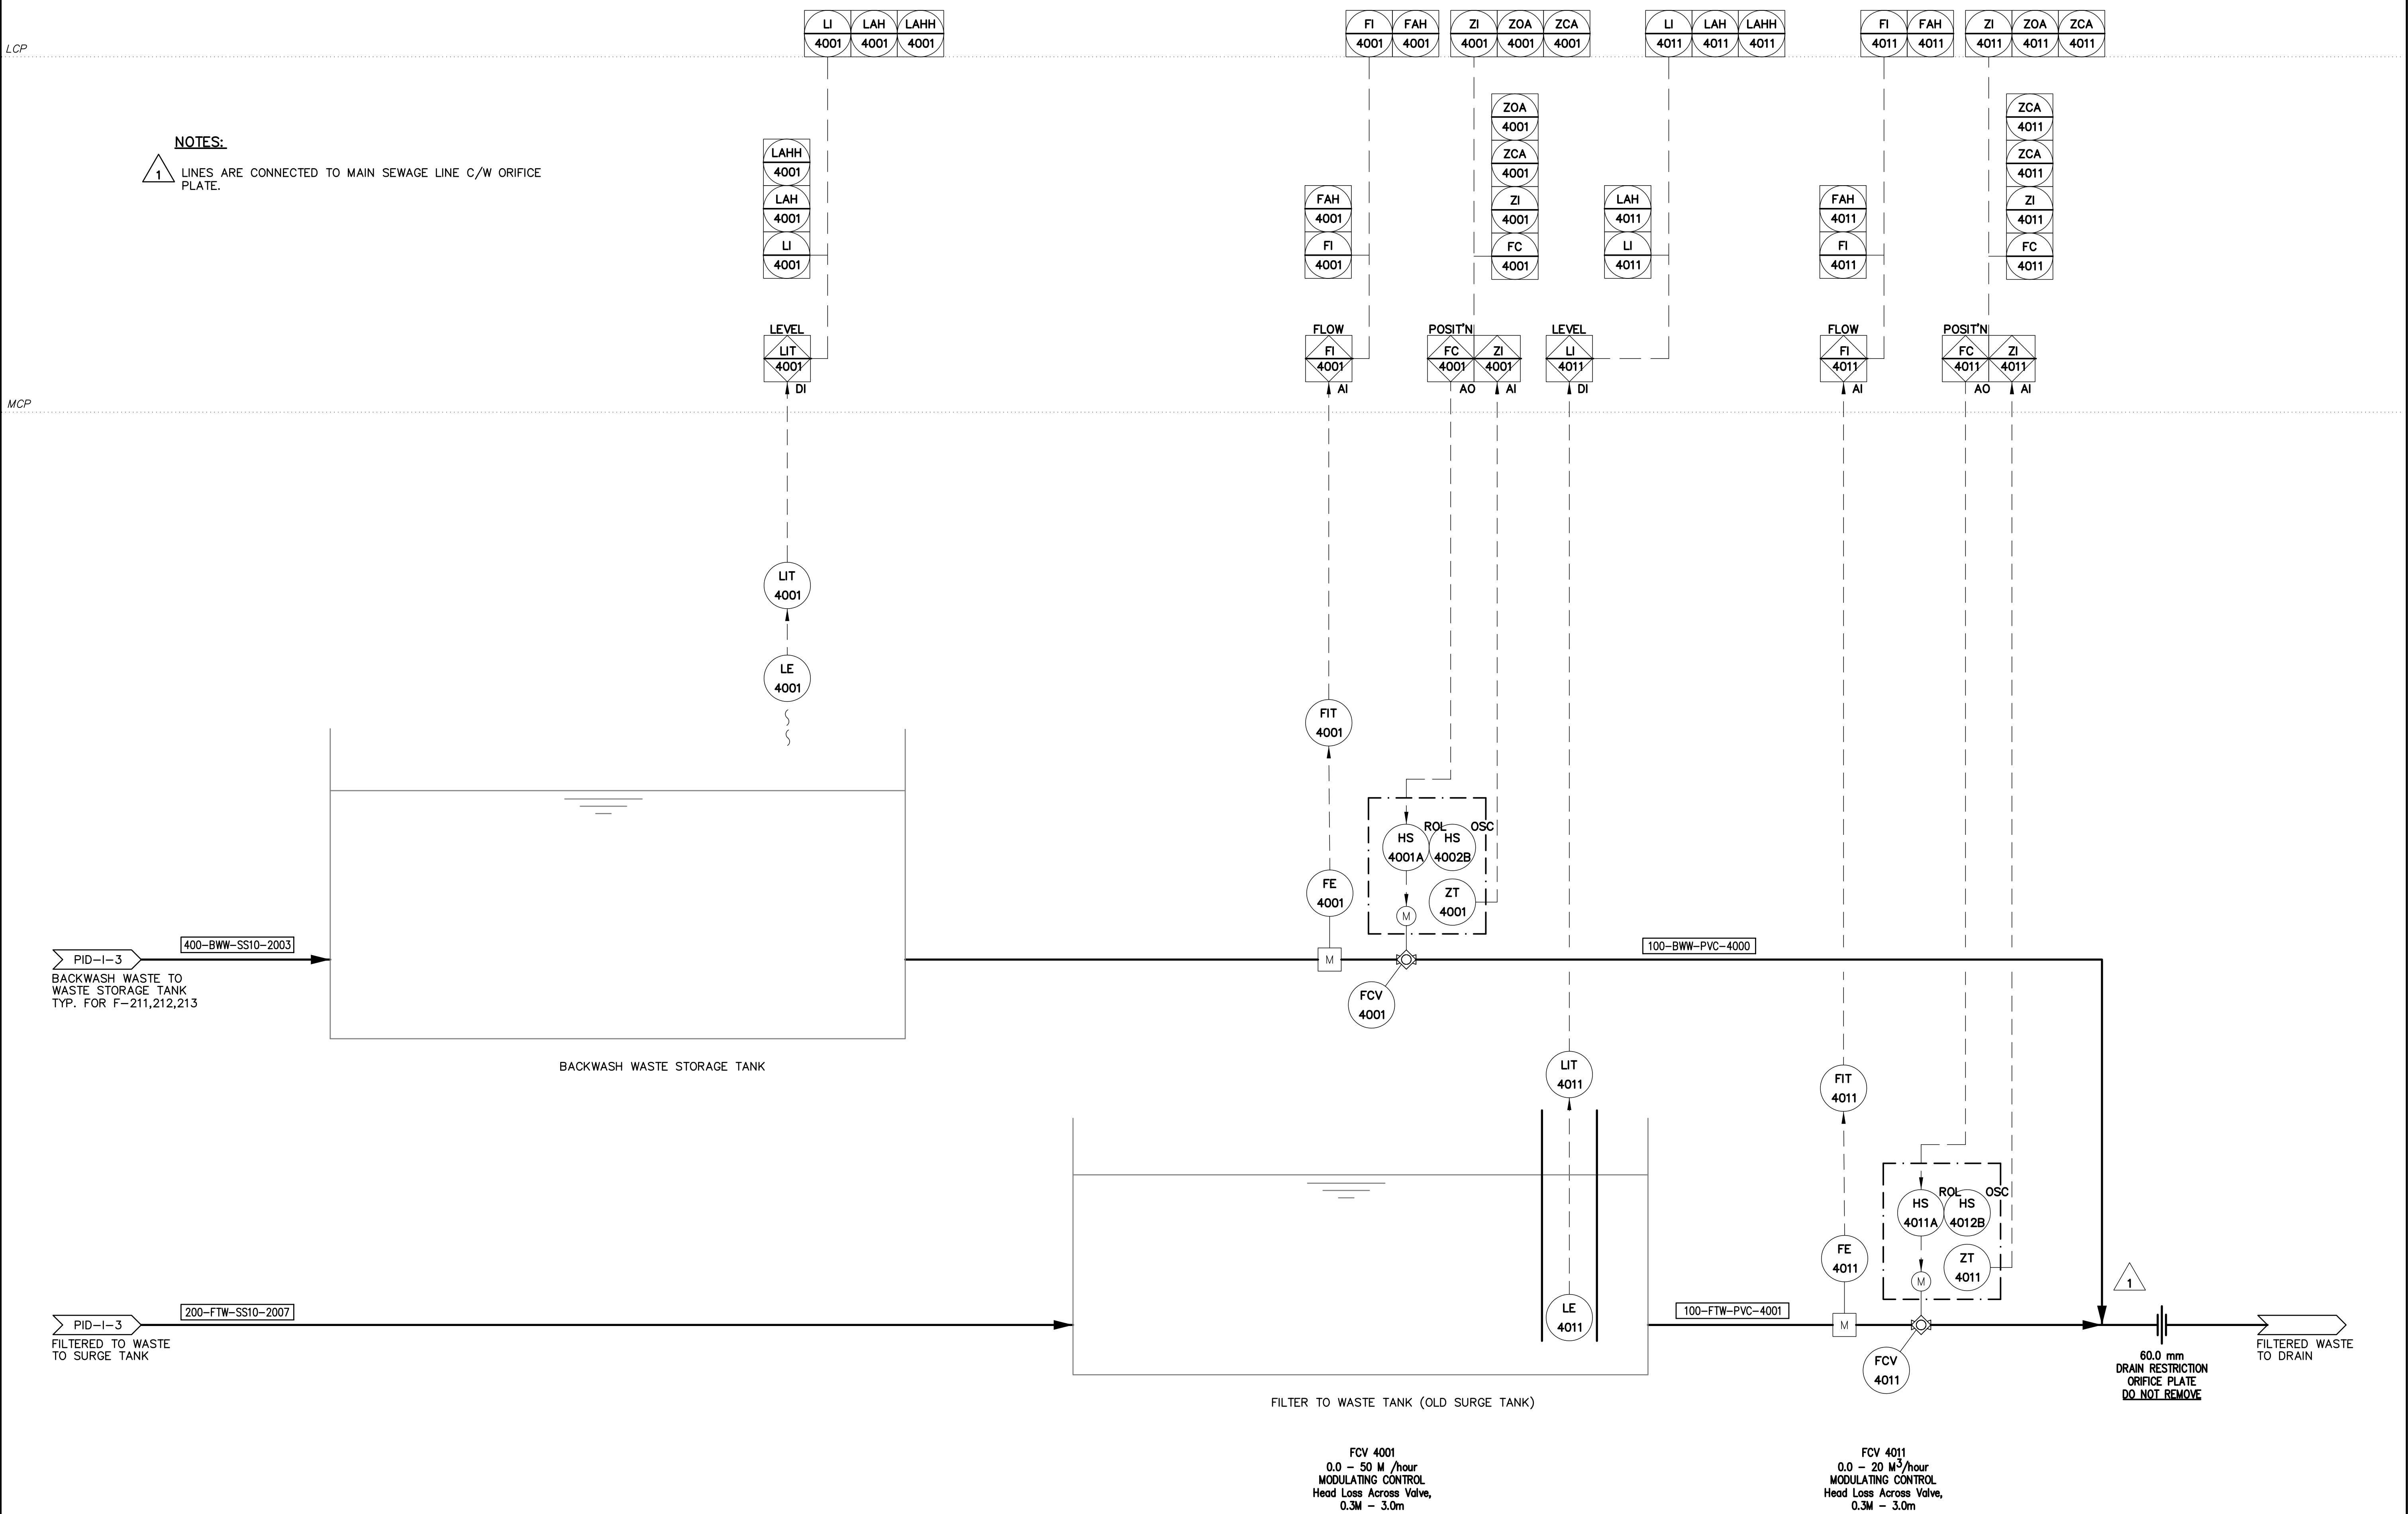

				Company Permit		Engineer Seal		PROCESS & INSTRUMENTATION		CITY OF IQALUIT		EARTH TECH	
				RECORD DRAWING		INFORMATION CONTAINED IN THESE DRAWINGS IS AS SUPPLIED BY: SCHENDEL MECHANICAL CONTRACTING LTD. & VECTOR ELECTRIC & CONTROLS. THE COMPLETENESS AND ACCURACY OF THIS RECORD DRAWING IS NOT GUARANTEED. INFORMATION SHOULD BE VERIFIED ON LOCATION BEFORE USE.		P & ID - FLUORIDE & ORTHOPHOSPHATE SUPPLY		IQALUIT WATER TREATMENT PLANT		Earth Tech (Canada) Inc.	
2	RECORD DRAWING	19/07/04	LL									DRAWN BY: CKW	
1	ISSUED FOR CONSTRUCTION	22/04/03	CKW									CHECKED BY: CKW/JVH	
0	ISSUED FOR TENDER	19/02/03	CKW									SCALE: NOT NOTED	
NO.	REVISION	DATE	INITIAL									DATE: FEB. 02/02/03	
												SHEET NO.	
												CADD SYSTEM AutoCAD	
												REV. 2	
												CONTRACT 55524	