


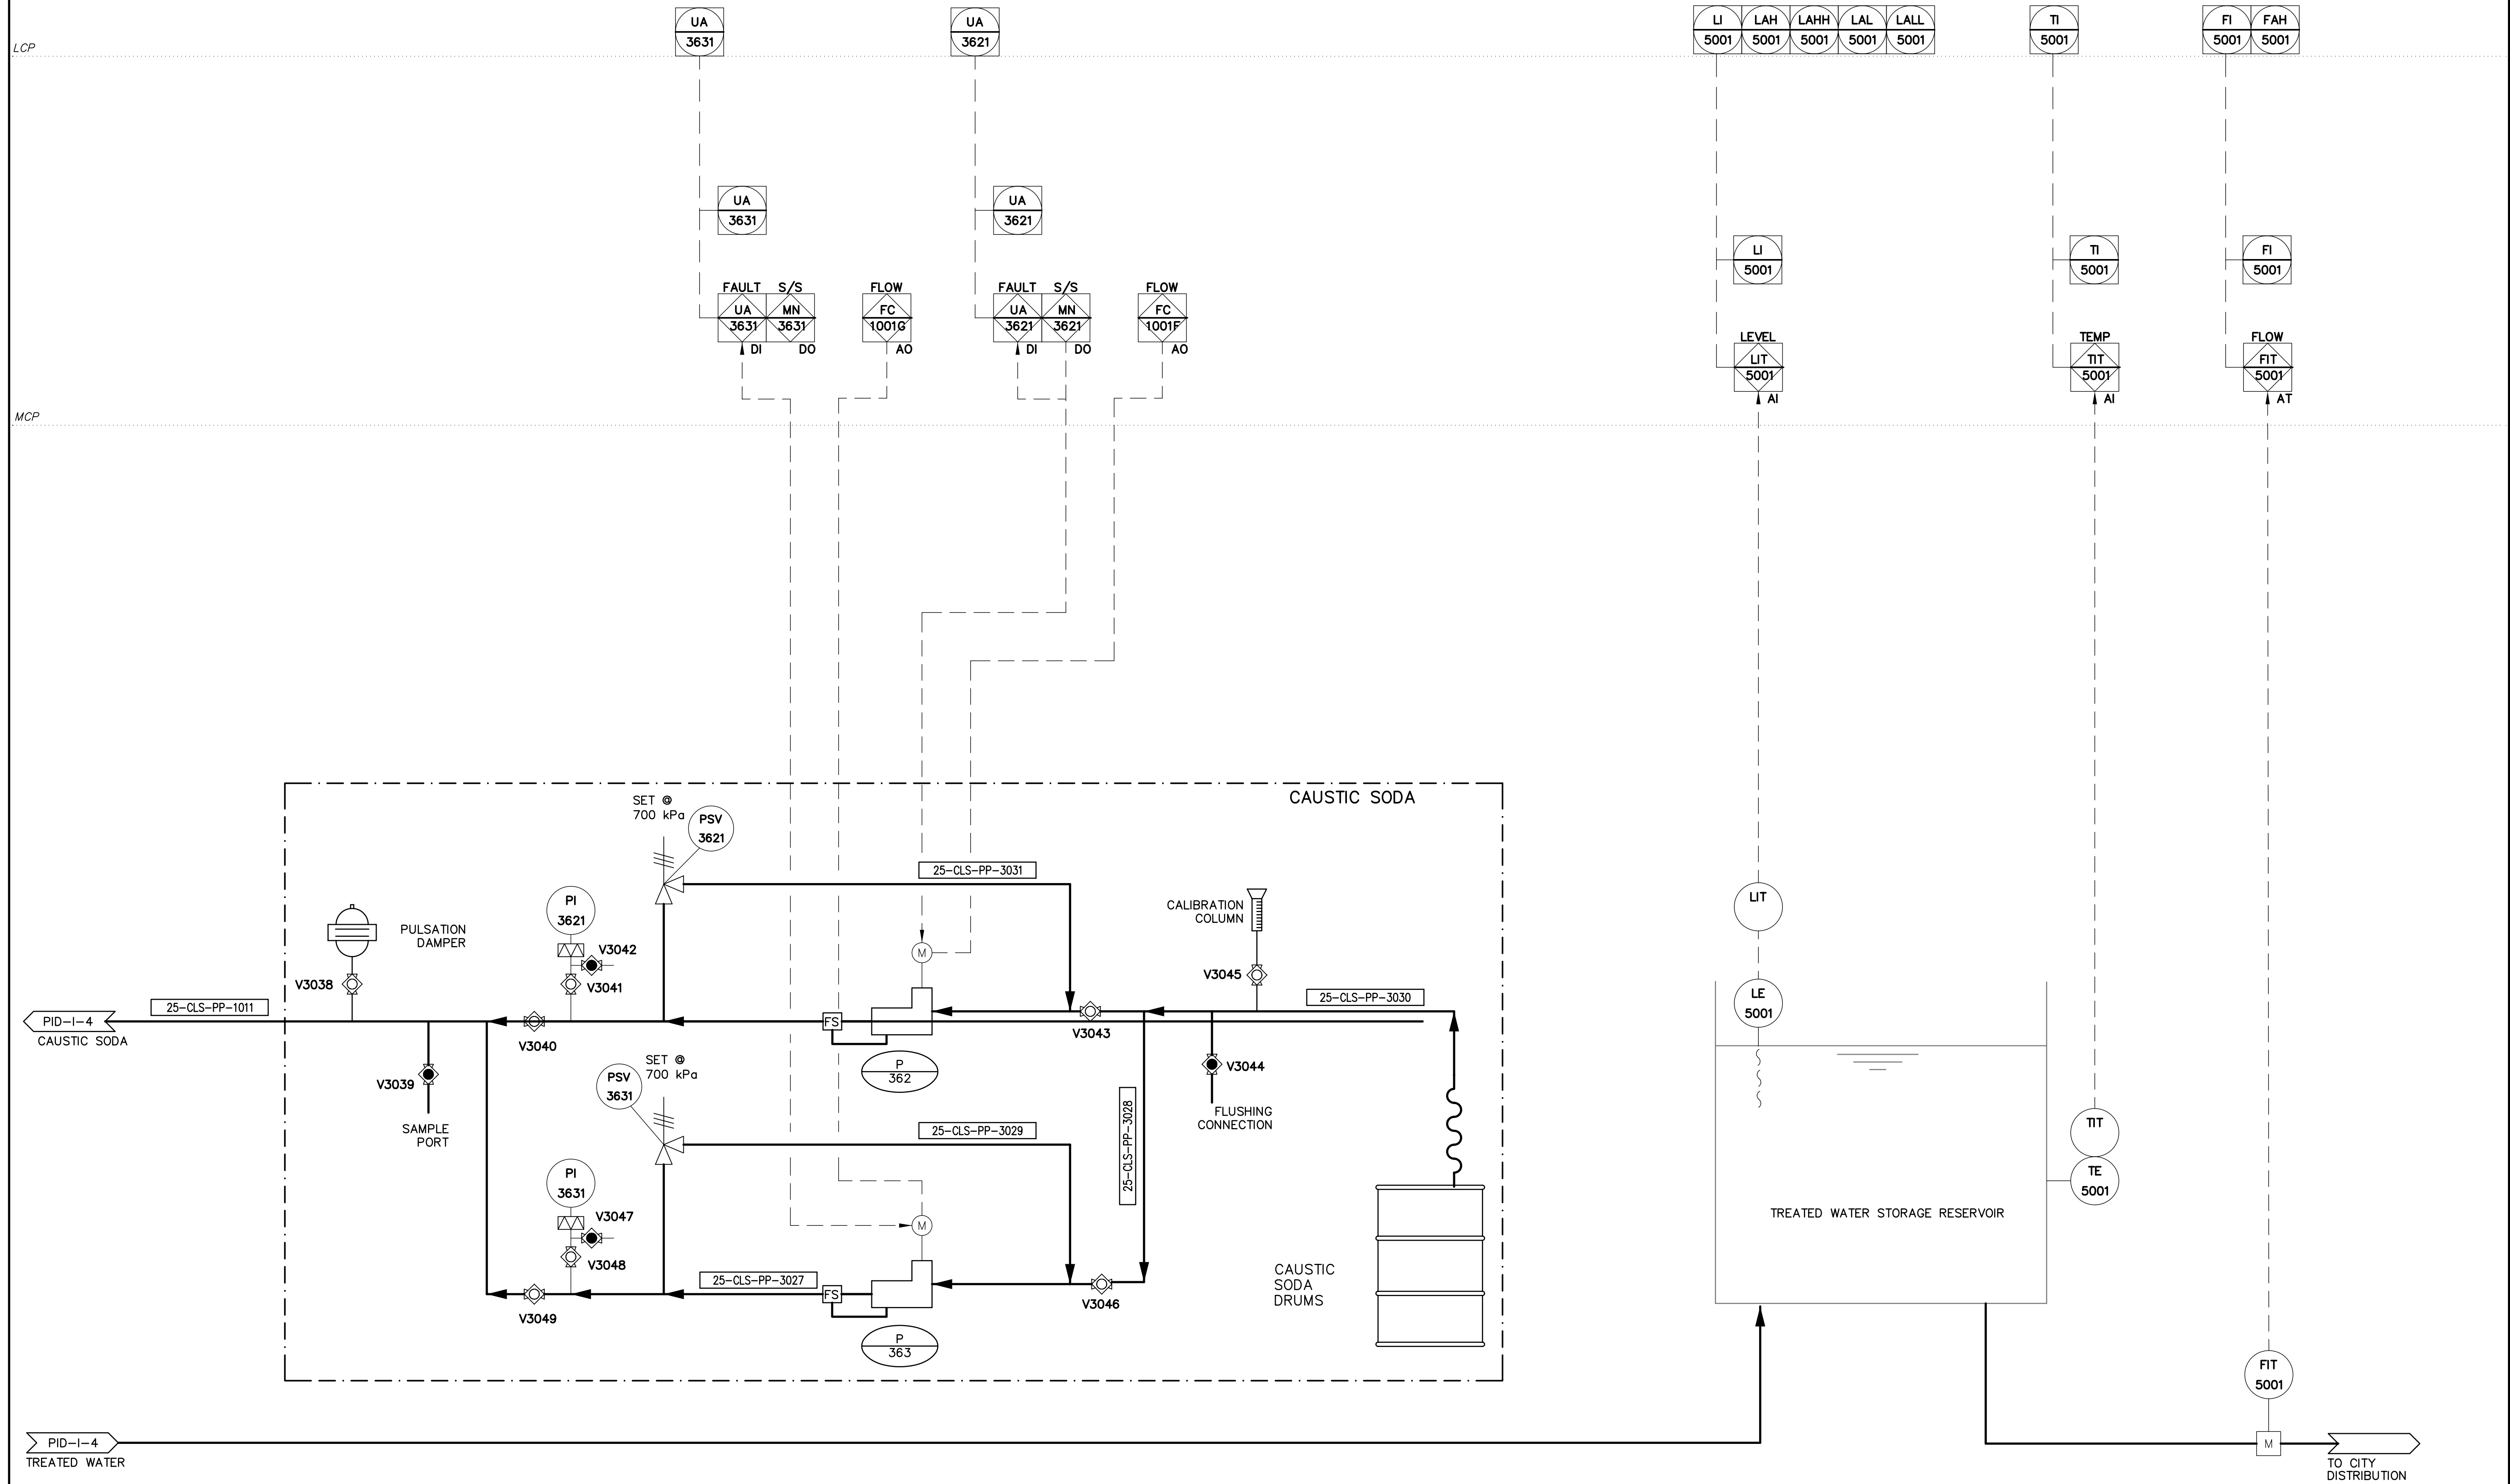

				Company Permit	Engineer Seal	PROCESS & INSTRUMENTATION	 CITY of IQALUIT, Nunavut	CITY of IQALUIT		 EARTHTECH Earth Tech (Canada) Inc. <table><tr><td>DRAWN BY: KWM</td><td>SCALE: N.T.S.</td><td>DATE: OCT. 2002</td><td>SHEET NO.</td></tr><tr><td>CHECKED BY: CKW/JVH</td><td></td><td></td><td></td></tr><tr><td>CADD SYSTEM AutoCAD</td><td>DWG NO. 1-7</td><td>REV. 2</td><td>CONTRACT 55524</td></tr></table>	DRAWN BY: KWM	SCALE: N.T.S.	DATE: OCT. 2002	SHEET NO.	CHECKED BY: CKW/JVH				CADD SYSTEM AutoCAD	DWG NO. 1-7	REV. 2	CONTRACT 55524
DRAWN BY: KWM	SCALE: N.T.S.	DATE: OCT. 2002	SHEET NO.																			
CHECKED BY: CKW/JVH																						
CADD SYSTEM AutoCAD	DWG NO. 1-7	REV. 2	CONTRACT 55524																			
2	RECORD DRAWINGS	11/05/04	LL																			
1	ISSUED FOR CONSTRUCTION	22/04/03	CKW																			
0	ISSUED FOR TENDER	19/02/03	CKW																			
NO.	REVISION	DATE	INITIAL																			

RECORD DRAWING

INFORMATION CONTAINED IN THESE DRAWINGS IS AS SUPPLIED BY:

SCHENDEL MECHANICAL CONTRACTING LTD.

THE COMPLETENESS AND ACCURACY OF THIS RECORD DRAWING IS NOT GUARANTEED.

INFORMATION SHOULD BE VERIFIED AT THE ACTUAL LOCATION BEFORE USE.

P & ID – TEMPORARY CHLORINATION PLANT