


L:\WORK\55000\55524\02A-CAD\WAT\AsBuilts\Instrumentation\55524-L9 Record-Sept 2004.dwg

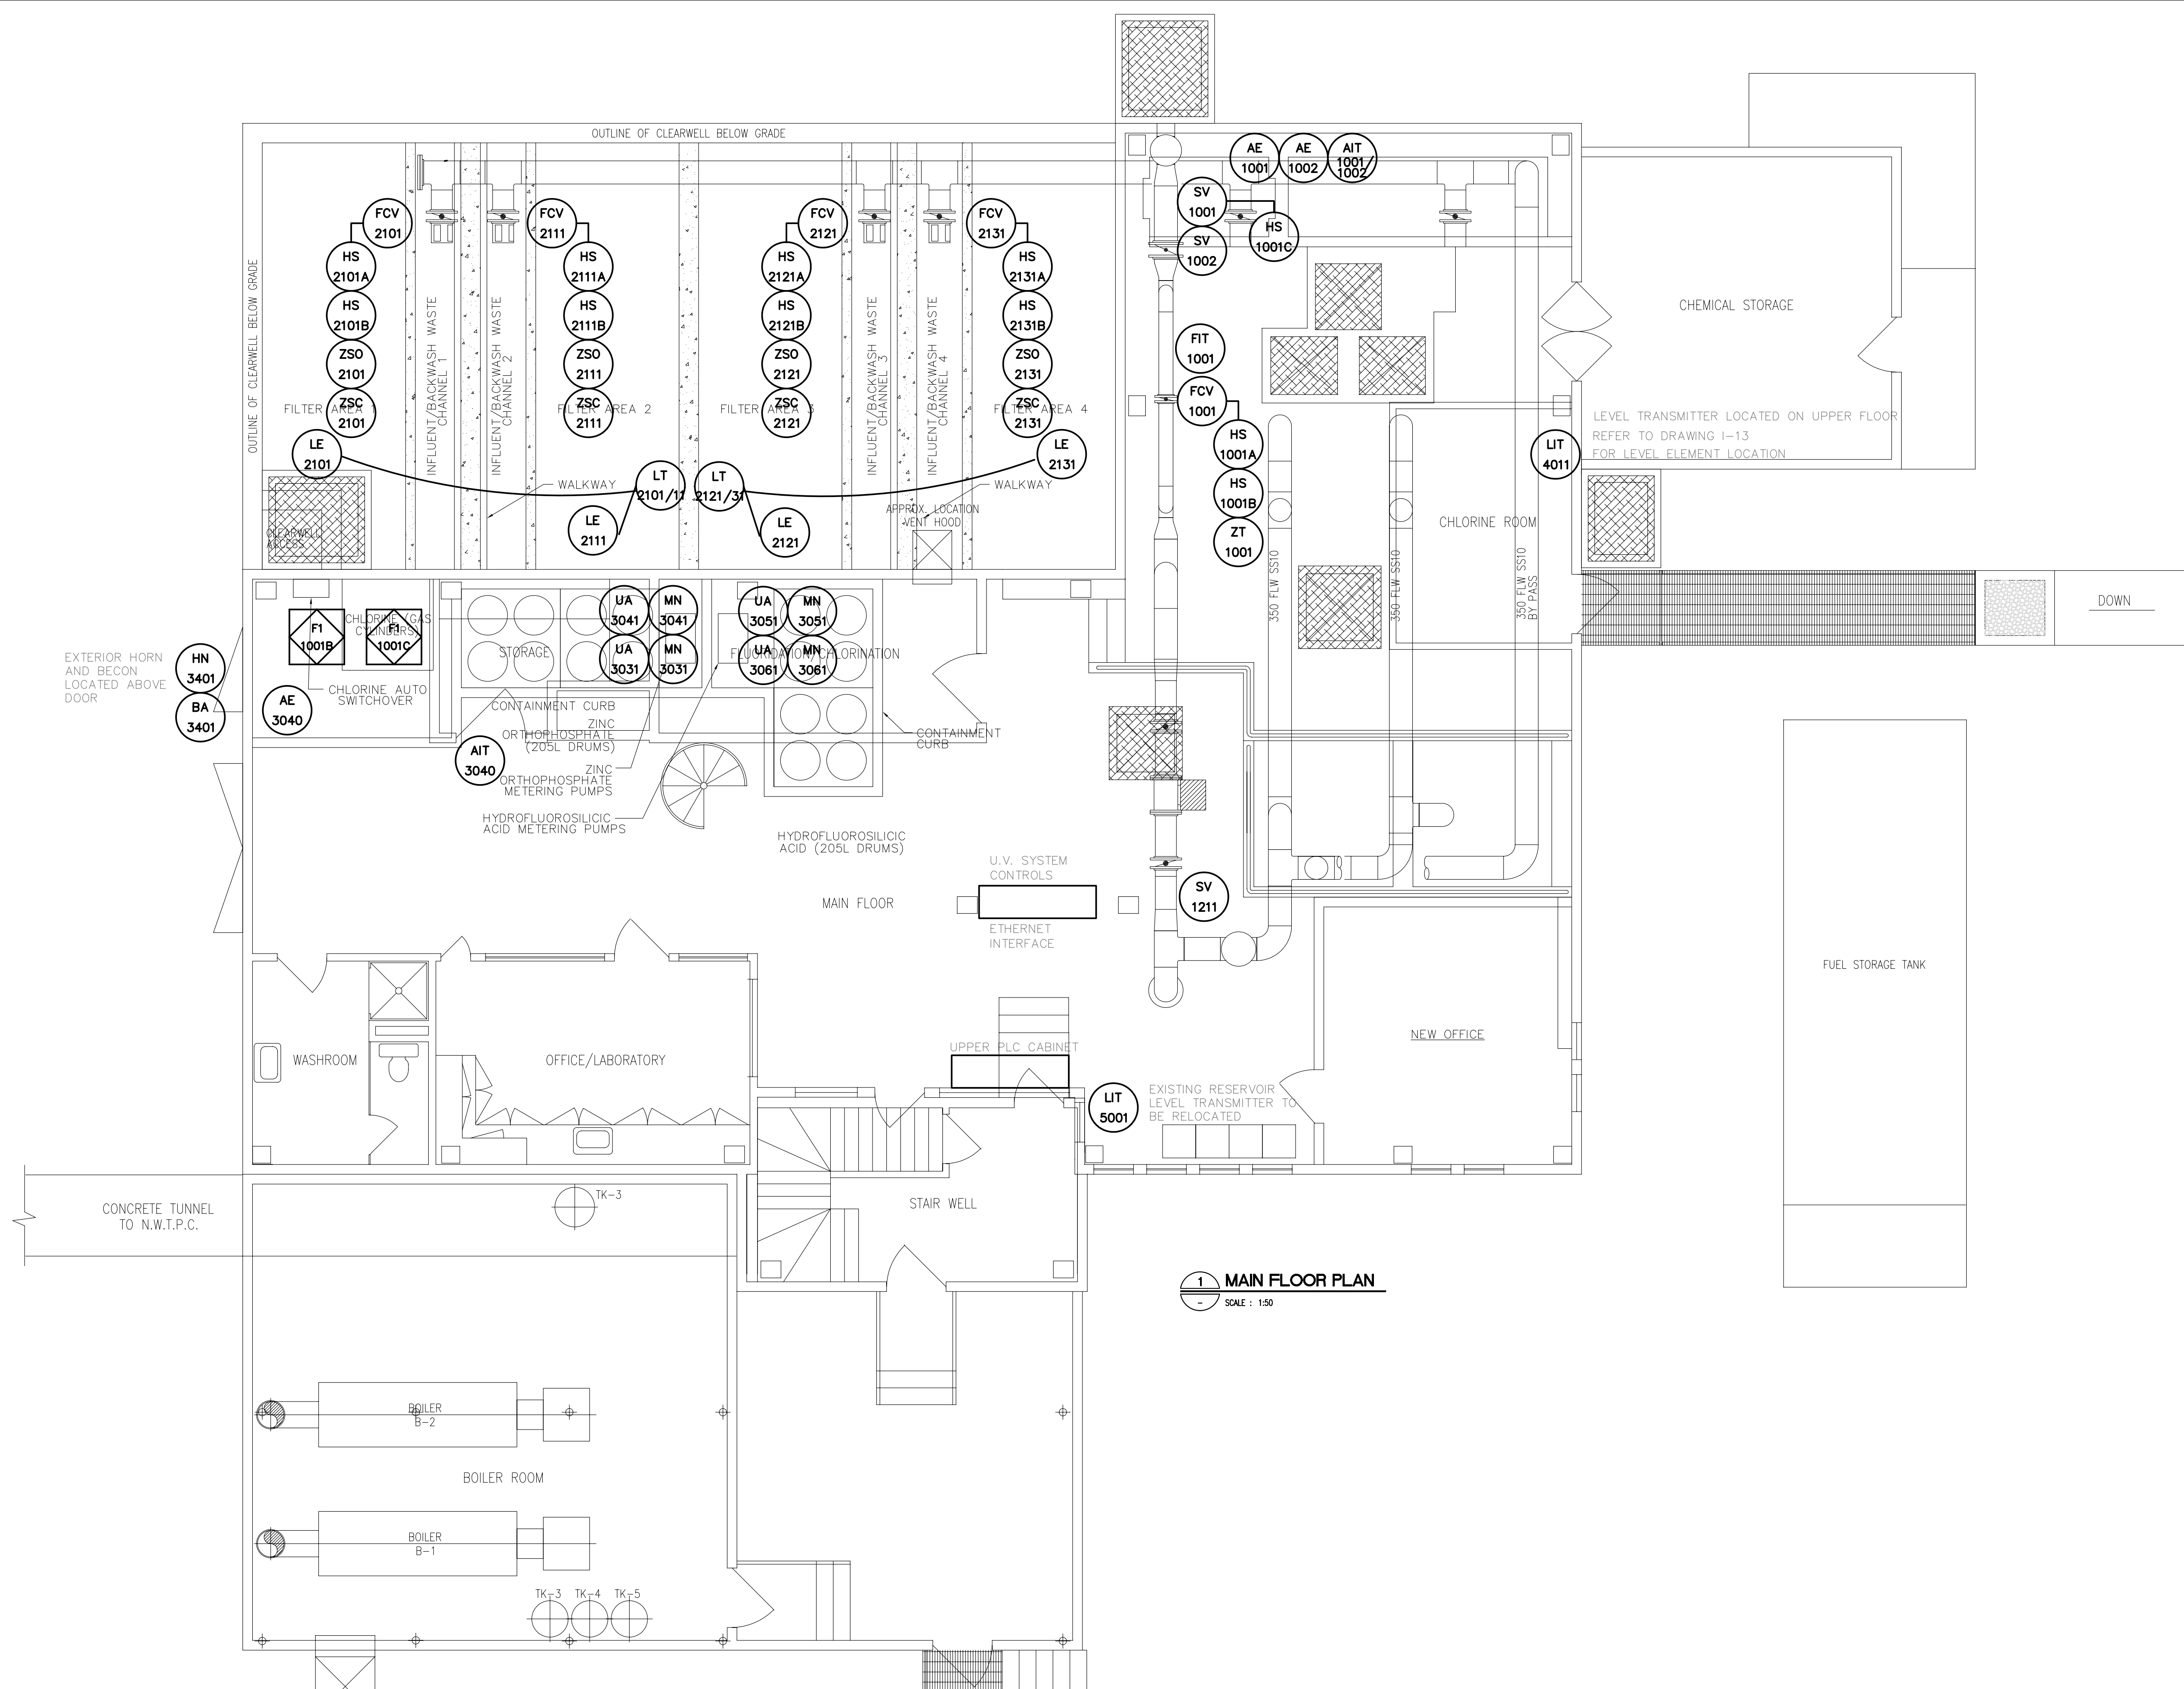

1 MAIN FLOOR PLAN
SCALE : 1:50


NO.	REVISION	DATE	INITIAL
2	RECORD DRAWING	14/09/04	YLC
1	ISSUED FOR CONSTRUCTION	22/04/03	CKW
0	ISSUED FOR TENDER	19/02/03	CKW

Company Permit

Engineer Seal

RECORD DRAWING
INFORMATION CONTAINED IN THESE DRAWINGS IS
AS SUPPLIED BY: SCHEDEL MECHANICAL
CONTRACTING LTD. & VECTOR ELECTRIC &
CONTROLS. THE COMPLETENESS AND ACCURACY
OF THIS RECORD DRAWING IS NOT GUARANTEED.
INFORMATION SHOULD BE VERIFIED ON LOCATION
BEFORE USE.

INSTRUMENTATION
FILTERS FLOOR
DEVICE
LOCATIONS

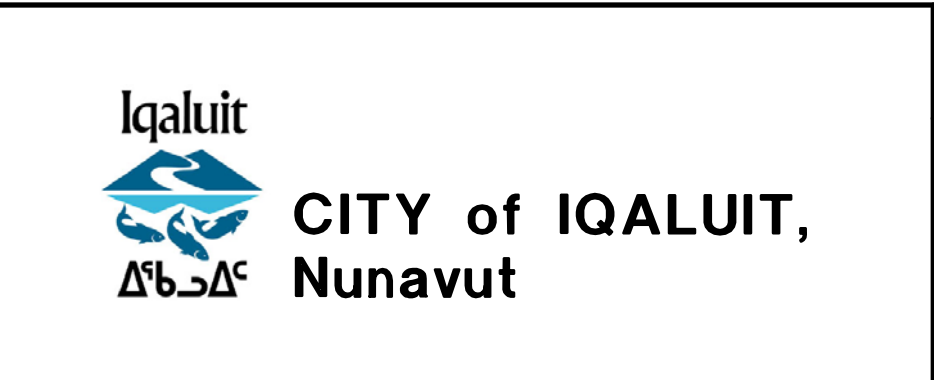

CITY OF IQALUIT
IQALUIT WATER TREATMENT PLANT

EARTH TECH

Earth Tech (Canada) Inc.

DRAWN BY: TDC	SCALE: AS NOTED	DATE: OCT. 2002	SHEET NO.
CHECKED BY: CKW	DWG NO.	REV. 1	CONTRACT 55524

1-9