


ET:55524/Cadd FileA1-PROJ-SHT.dwg/Last Edit: 2004-04-06 (17:00)/Plot Scale: 1:1 (A1)

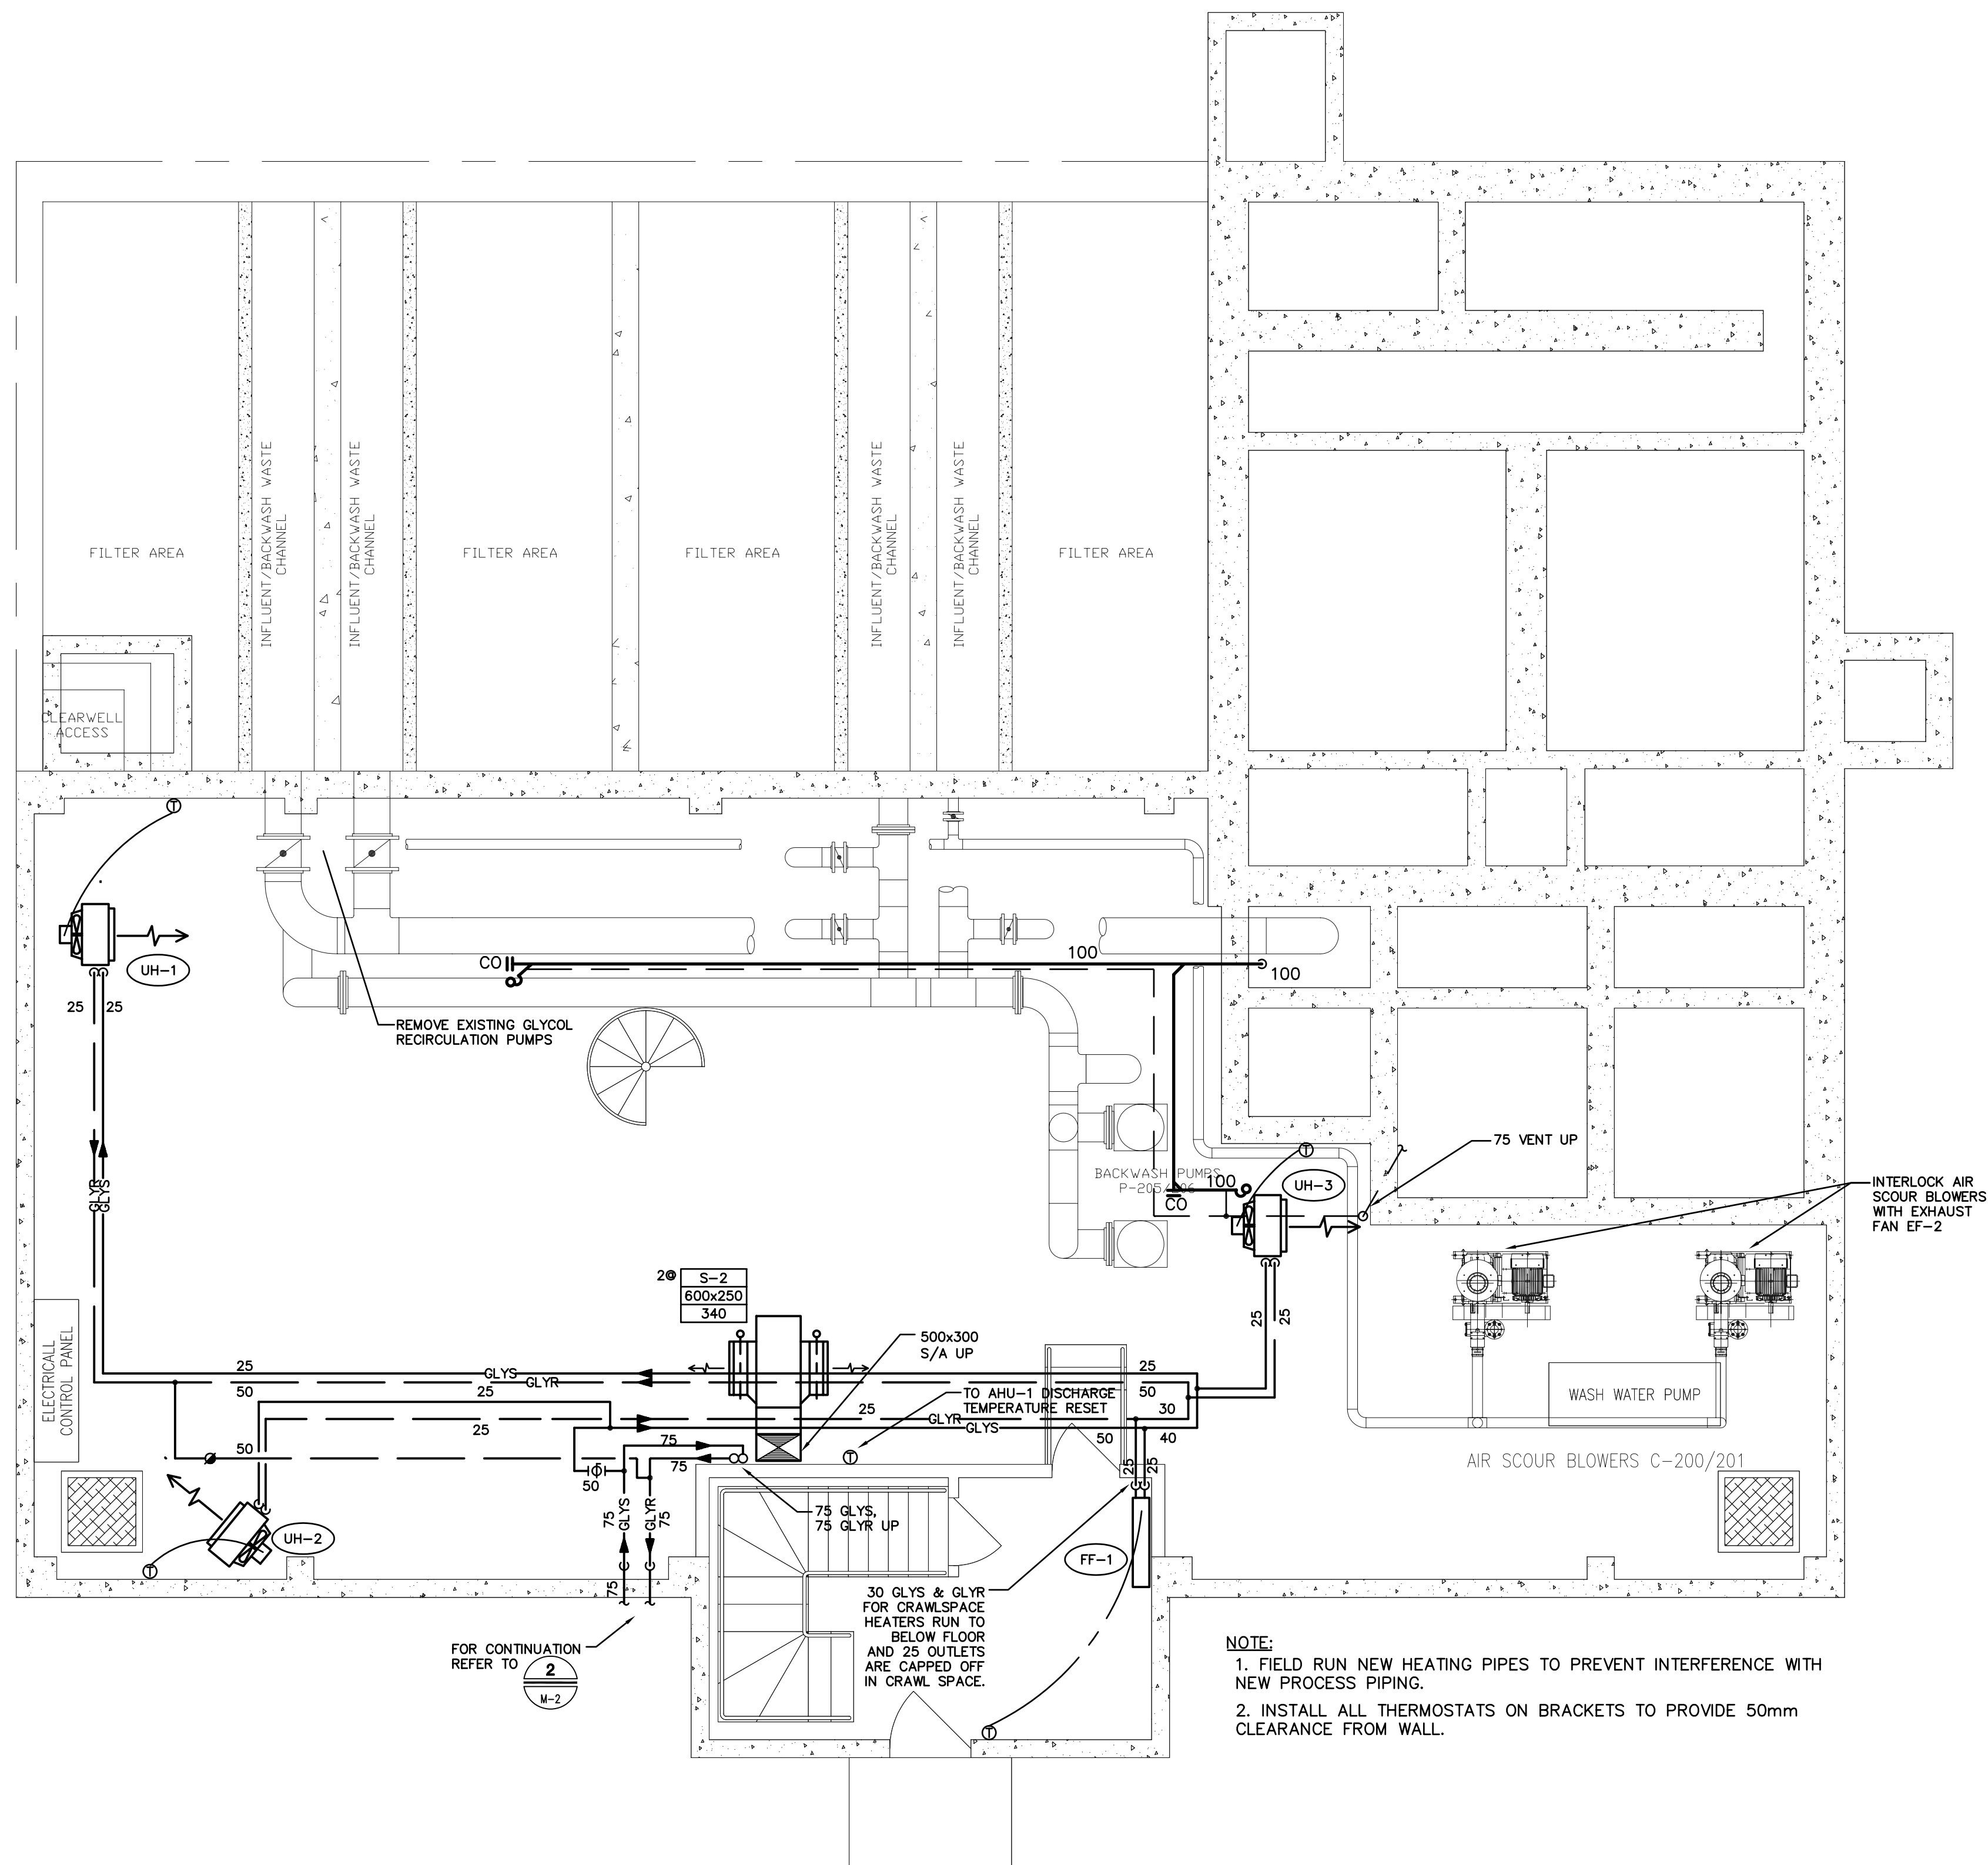

1 LOWER FLOOR - MECHANICAL PLAN
SCALE: 1:50

NO.	REVISION	DATE	INITIAL
2	RECORD DRAIING	23/04/04	IV
1	ISSUED FOR CONSTRUCTION	22/04/03	DBF
0	ISSUED FOR TENDER	19/02/03	DBF

Company Permit	Engineer Seal
RECORD DRAWING	
INFORMATION CONTAINED IN THESE DRAWINGS IS AS SUPPLIED BY SHENDEL MECHANICAL CONTRACTING LTD.	
DATE: MAY 03, 2004	

MECHANICAL
LOWER FLOOR
MECHANICAL LAYOUT



CITY of IQALUIT,
Nunavut

CITY OF IQALUIT

IQALUIT WATER TREATMENT PLANT



Earth Tech (Canada) Inc.

DRAWN BY: E.J.L.	SCALE: AS NOTED	DATE: FEB. 03, 2003	SHEET NO.
CHECKED BY: DBF	DWG NO. M-3	REV. 1	CONTRACT 55524