


DYWIDAG THREADED RODS BELOW EXISTING CONCRETE SLAB REFER TO DETAIL 11/S-7

DYWIDAG ANCHORS

EXIST. CONCRETE THRUST BLOCK. EXACT LOCATION TO BE SITE CONFIRMED.  
EXIST. INSULATED WATER SUPPLY LINE  
EXIST. INSULATED HOT WATER LINE

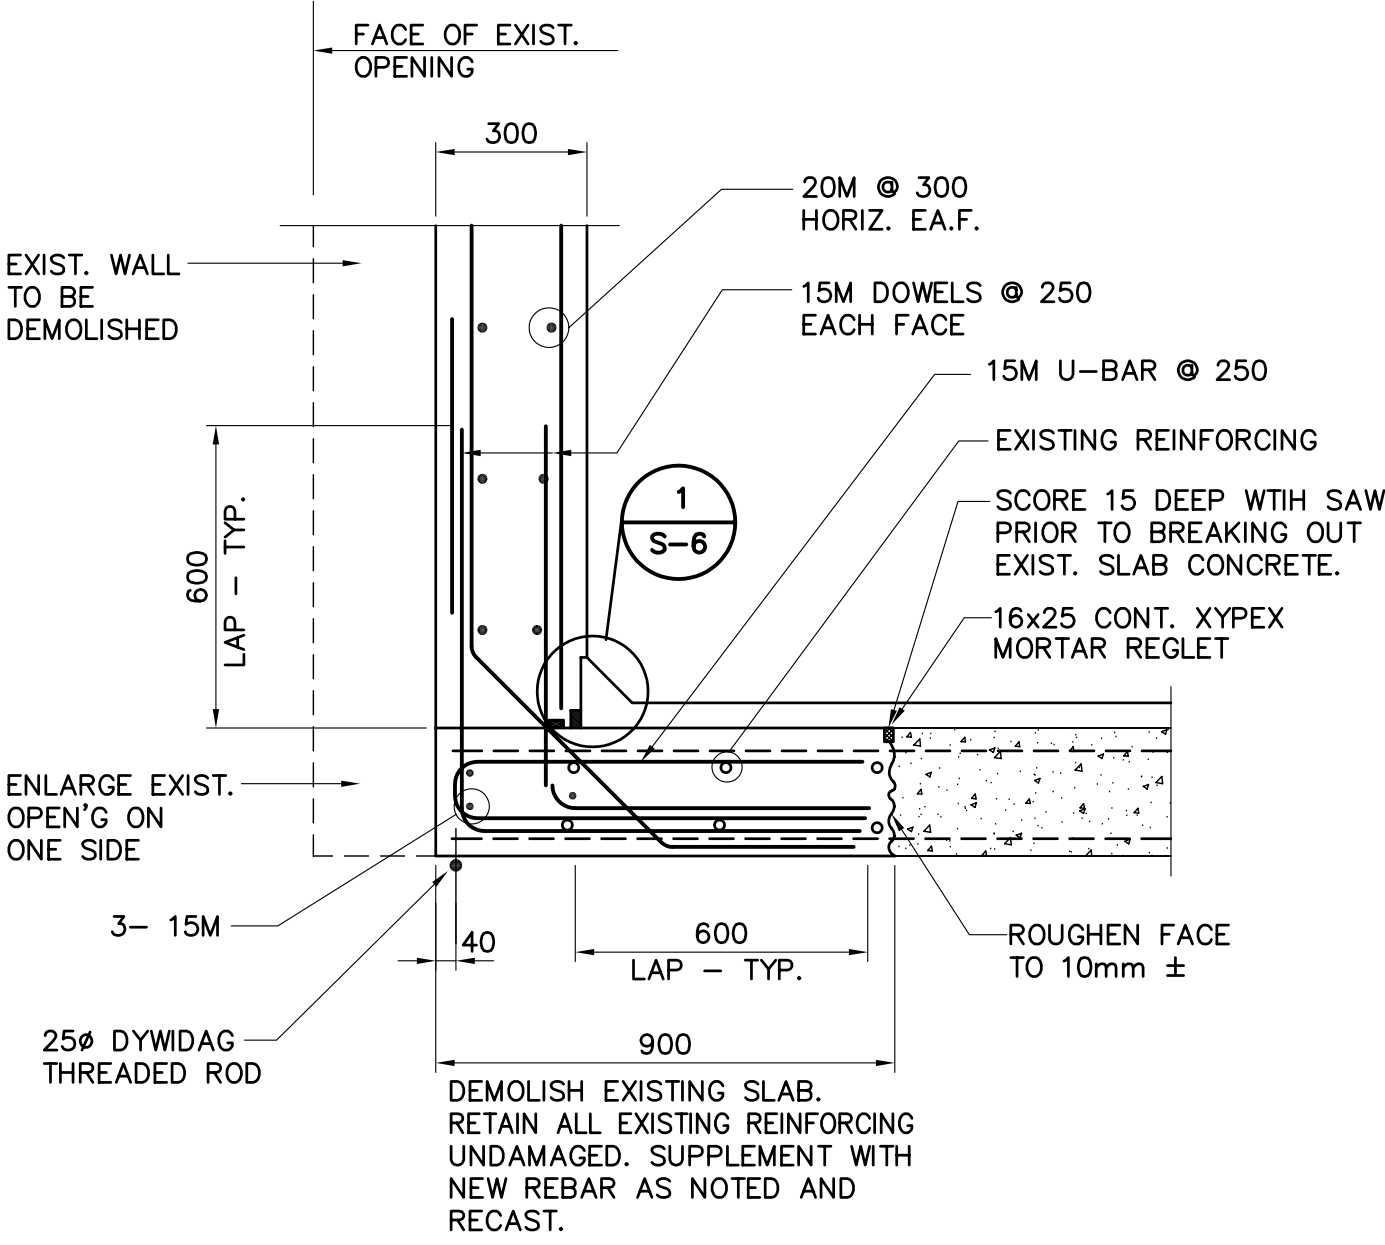

1 SECTION  
S-4 SCALE 1:15

- NOTES:
- REFERENCE : INFORMATION PRESENTED ON THIS DRAWING DESCRIBING EXISTING STRUCTURE FROM CONTRACT NO. CA-62-1-28 DRAWINGS.
  - ALL EXISTING WALLS AND SLABS ARE REINFORCED CONCRETE. REINFORCEMENT NOT INDICATED.
  - REFER TO DEPARTMENT OF PUBLIC WORKS CANADA - WATER TREATMENT AND WATER SUPPLY DRAWINGS FOR FROBISHER BAY N.W.T. CONTRACT NO. CA-62-1-28 FOR DETAILS DESCRIBING EXISTING STRUCTURE.

PLAN - PUMPS FLOOR  
AT ELEVATION 95.402 (313') & AS NOTED  
SCALE: 1:50


| NO. | REVISION                | DATE     | INITIAL |
|-----|-------------------------|----------|---------|
|     | RECORD DRAWING          | 23/04/04 |         |
| 1   | ISSUED FOR CONSTRUCTION | 22/04/03 |         |
| 0   | ISSUED FOR TENDER       | 19/02/03 |         |
| A   | ISSUED FOR FINAL REVIEW | 03/02/03 |         |

Company Permit  
Engineer Seal

**RECORD DRAWING**  
INFORMATION CONTAINED IN THESE DRAWINGS IS AS SUPPLIED BY:  
NINETY NORTH CONSTRUCTION & DEVELOPMENT LTD.  
THE COMPLETENESS AND ACCURACY OF THIS RECORD DRAWING IS NOT GUARANTEED. INFORMATION SHOULD BE VERIFIED AT THE ACTUAL LOCATION BEFORE USE.

STRUCTURAL

PUMPS FLOOR PLAN

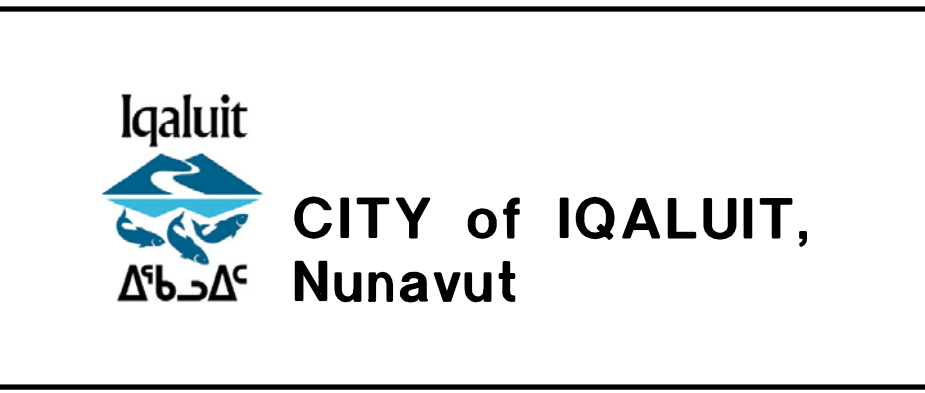

CITY OF IQALUIT

IQALUIT WATER TREATMENT PLANT

**EARTH TECH**

Earth Tech (Canada) Inc.

|                 |                 |                     |                |
|-----------------|-----------------|---------------------|----------------|
| DRAWN BY: BL    | SCALE: AS NOTED | DATE: FEB. 19, 2003 | SHEET NO.      |
| CHECKED BY: GJK | DWG NO. S-4     | REV. 1              | CONTRACT 55524 |