


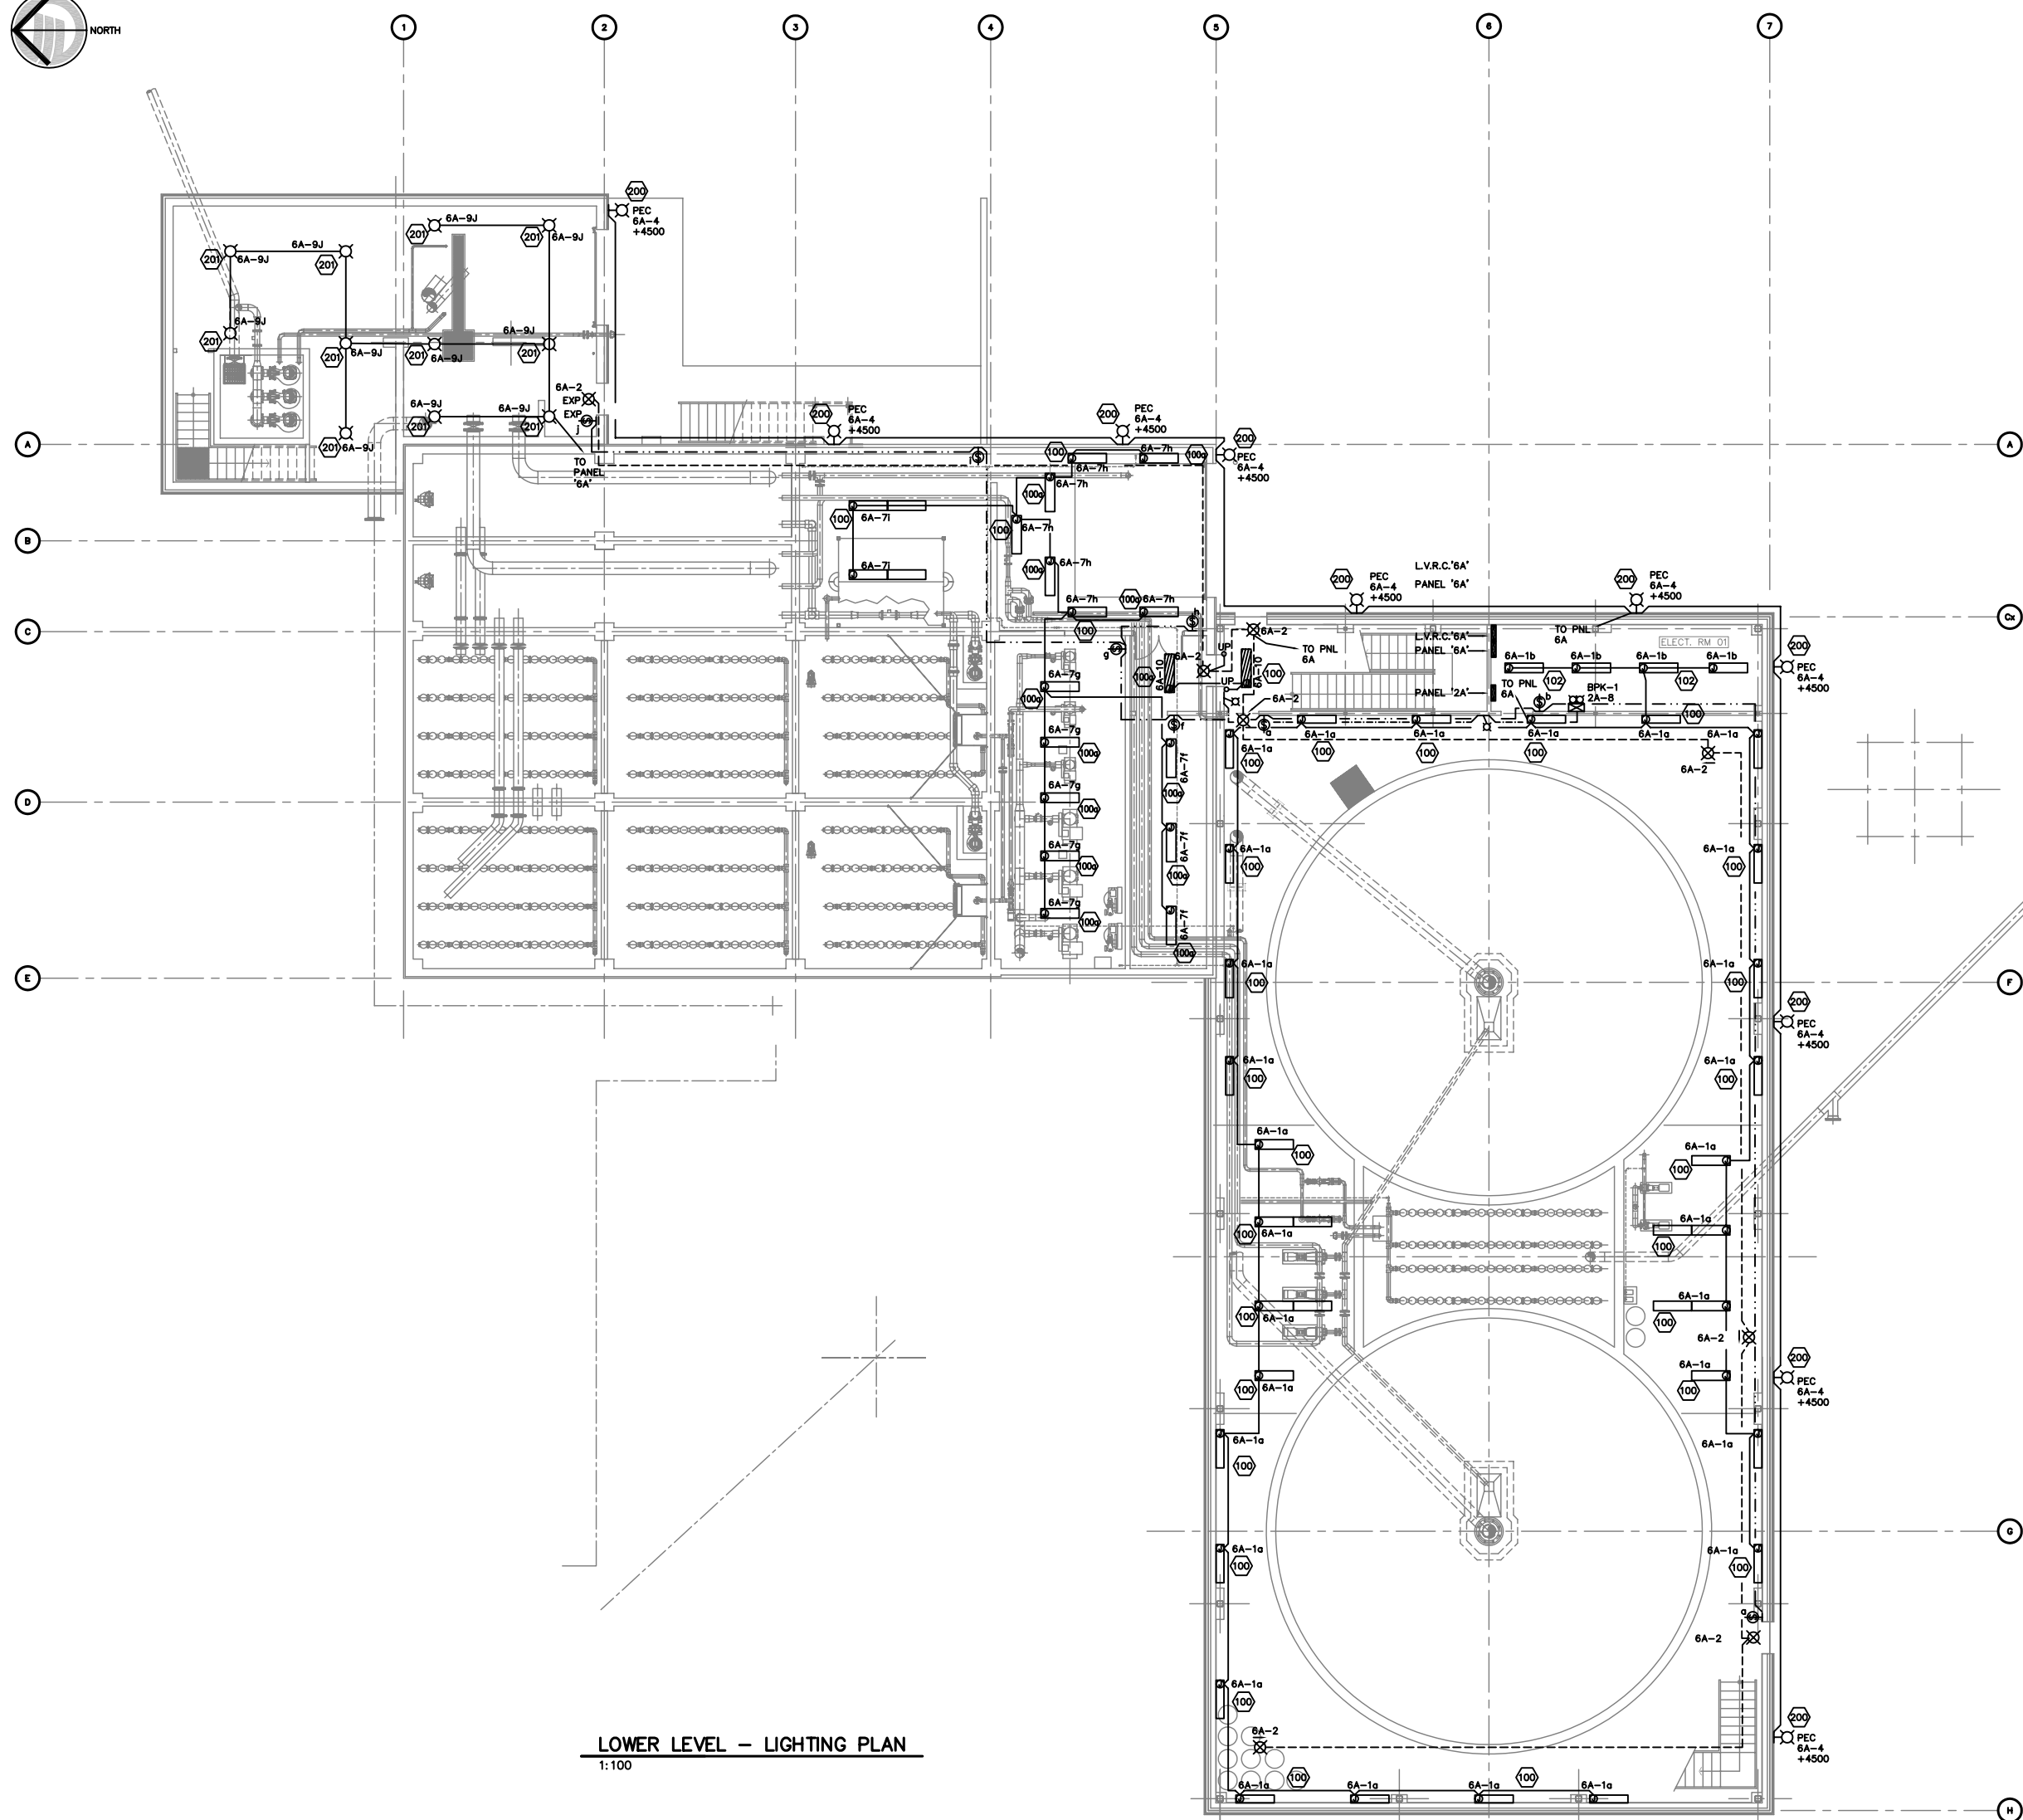

LOWER LEVEL - LIGHTING PLAN
1:100

	LAMP TYPE: 32 WATT, T-8, FLUORESCENT LAMP QTY: 2 MOUNTING: SURFACE HOUSING: HEAVY DUTY SHEET STEEL DIR FORMED BAKED ENAMEL REFLECTOR: NONE LENS: POLYCARBONATE SPECIAL REQUIREMENT: 347V ELECTRONIC BALLAST <i>Products are listed to satisfy minimum standards. For approval of acceptable products, see manufacturer's literature.</i> ACCEPTABLE PRODUCTS: PART No. ACME DUNBAR COOPER THOMAS LITHONIA COLUMBIA LITHONIA LUMINAIRE SCHEDULE TYPE No. 100		LAMP TYPE: 32 WATT, T-8, FLUORESCENT LAMP QTY: 2 MOUNTING: SURFACE HOUSING: HEAVY DUTY SHEET STEEL DIR FORMED BAKED ENAMEL REFLECTOR: NONE LENS: POLYCARBONATE SPECIAL REQUIREMENT: 347V ELECTRONIC BALLAST <i>Products are listed to satisfy minimum standards. For approval of acceptable products, see manufacturer's literature.</i> ACCEPTABLE PRODUCTS: PART No. ACME DUNBAR COOPER THOMAS LITHONIA COLUMBIA LITHONIA LUMINAIRE SCHEDULE TYPE No. 100a
--	--	--	---

	LAMP TYPE: 32 WATT, T-8, FLUORESCENT LAMP QTY: 2 MOUNTING: SURFACE, CEILING HOUSING: COLD ROLLED STEEL, WHITE REFLECTOR: NONE LENS: CLEAR PRISMATIC ACRYLIC DIFFUSER SPECIAL REQUIREMENT: 347 ELECTRONIC BALLAST <i>Products are listed to satisfy minimum standards. For approval of acceptable products, see manufacturer's literature.</i> ACCEPTABLE PRODUCTS: PART No. LITHONIA METALUX COLUMBIA LUMINAIRE SCHEDULE TYPE No. 101		LAMP TYPE: 32 WATT, T-8, FLUORESCENT LAMP QTY: 2 MOUNTING: SUSPENDED CEILING HOUSING: COLD ROLLED STEEL REFLECTOR: SLOTTED - WHITE POWDER PAINT LENS: NONE SPECIAL REQUIREMENT: 347 ELECTRONIC BALLAST <i>Products are listed to satisfy minimum standards. For approval of acceptable products, see manufacturer's literature.</i> ACCEPTABLE PRODUCTS: PART No. LITHONIA METALUX COLUMBIA LITHONIA LUMINAIRE SCHEDULE TYPE No. 102
--	---	--	---

	LAMP TYPE: 32 WATT, T-8, FLUORESCENT LAMP QTY: 2 MOUNTING: SURFACE, CEILING OR WALL HOUSING: STEEL, WHITE ENAMEL REFLECTOR: NONE LENS: OPAL ACRYLIC SPECIAL REQUIREMENT: 347 ELECTRONIC BALLAST <i>Products are listed to satisfy minimum standards. For approval of acceptable products, see manufacturer's literature.</i> ACCEPTABLE PRODUCTS: PART No. LITHONIA METALUX COLUMBIA LUMINAIRE SCHEDULE TYPE No. 103
--	--

	LAMP TYPE: 150 WATT, HIGH PRESSURE SODIUM LAMP QTY: 1 MOUNTING: SURFACE, WALL HOUSING: WEATHER RESISTANT DIE CAST ALUMINUM REFLECTOR: SPECULAR ALZAK ALUMINUM LENS: MOLDED PRISMATIC SHOCK RESISTANT GLASS SPECIAL REQUIREMENT: C/W WIRE GUARD: CLASS I, DIV II OPTION: QUARTZ LAMP, RESTRIKE <i>Products are listed to satisfy minimum standards. For approval of acceptable products, see manufacturer's literature.</i> ACCEPTABLE PRODUCTS: PART No. COOPER HOLPHANE LITHONIA KEPCO LUMINAIRE SCHEDULE TYPE No. 200		LAMP TYPE: 175 WATT, METAL HALIDE LAMP QTY: 1 MOUNTING: ROD SUSPENDED, CEILING HOUSING: CAST FERROUS ALLOY, COATED REFLECTOR: ALUMINUM LENS: CLEAR HEAT RESISTANT GLOBE SPECIAL REQUIREMENT: C/W WIRE GUARD: CLASS I, DIV II OPTION: QUARTZ LAMP, RESTRIKE <i>Products are listed to satisfy minimum standards. For approval of acceptable products, see manufacturer's literature.</i> ACCEPTABLE PRODUCTS: PART No. APPLETON CROUSE HINDS LUMINAIRE SCHEDULE TYPE No. 201
--	---	--	---

	LAMP TYPE: 175 WATT, METAL HALIDE LAMP QTY: 1 MOUNTING: STANCHION MOUNT HOUSING: CAST FERROUS ALLOY, COATED REFLECTOR: ALUMINUM LENS: CLEAR HEAT RESISTANT GLOBE SPECIAL REQUIREMENT: C/W WIRE GUARD: CLASS I, DIV II OPTION: QUARTZ LAMP, RESTRIKE <i>Products are listed to satisfy minimum standards. For approval of acceptable products, see manufacturer's literature.</i> ACCEPTABLE PRODUCTS: PART No. APPLETON CROUSE HINDS LUMINAIRE SCHEDULE TYPE No. 202		LAMP TYPE: 175 WATT, METAL HALIDE LAMP QTY: 1 MOUNTING: SURFACE SUSPENDED HOUSING: DIE CAST ALUMINUM REFLECTOR: ENCLOSED INJECTION MOLDED, ACRYLIC LENS: UV STABILIZED DROP LENS SPECIAL REQUIREMENT: 347 VOLT QUARTZ LAMP RESTRIKE ON 10% OF QUANTITY OF FIXTURES <i>Products are listed to satisfy minimum standards. For approval of acceptable products, see manufacturer's literature.</i> ACCEPTABLE PRODUCTS: PART No. LITHONIA HUBBELL LUMINAIRE SCHEDULE TYPE No. 203
--	--	--	---

A	2004 OCT 15	ISSUED FOR 95% REVIEW
No.	Date	Description

REVISIONS

Design: WA
Drawn: YLC
Approved: Chief
Director: Project Title

CITY OF IQALUIT
WASTEWATER
TREATMENT PLANT

Drawing Title:
ELECTRICAL
LOWER LEVEL LIGHTING
PLAN & LUMINAIRE SCH.

Scale: AS SHOWN
Project No.: 75360
Date: SEPT 2004
Drawing No.: E3.01
Revision: A