


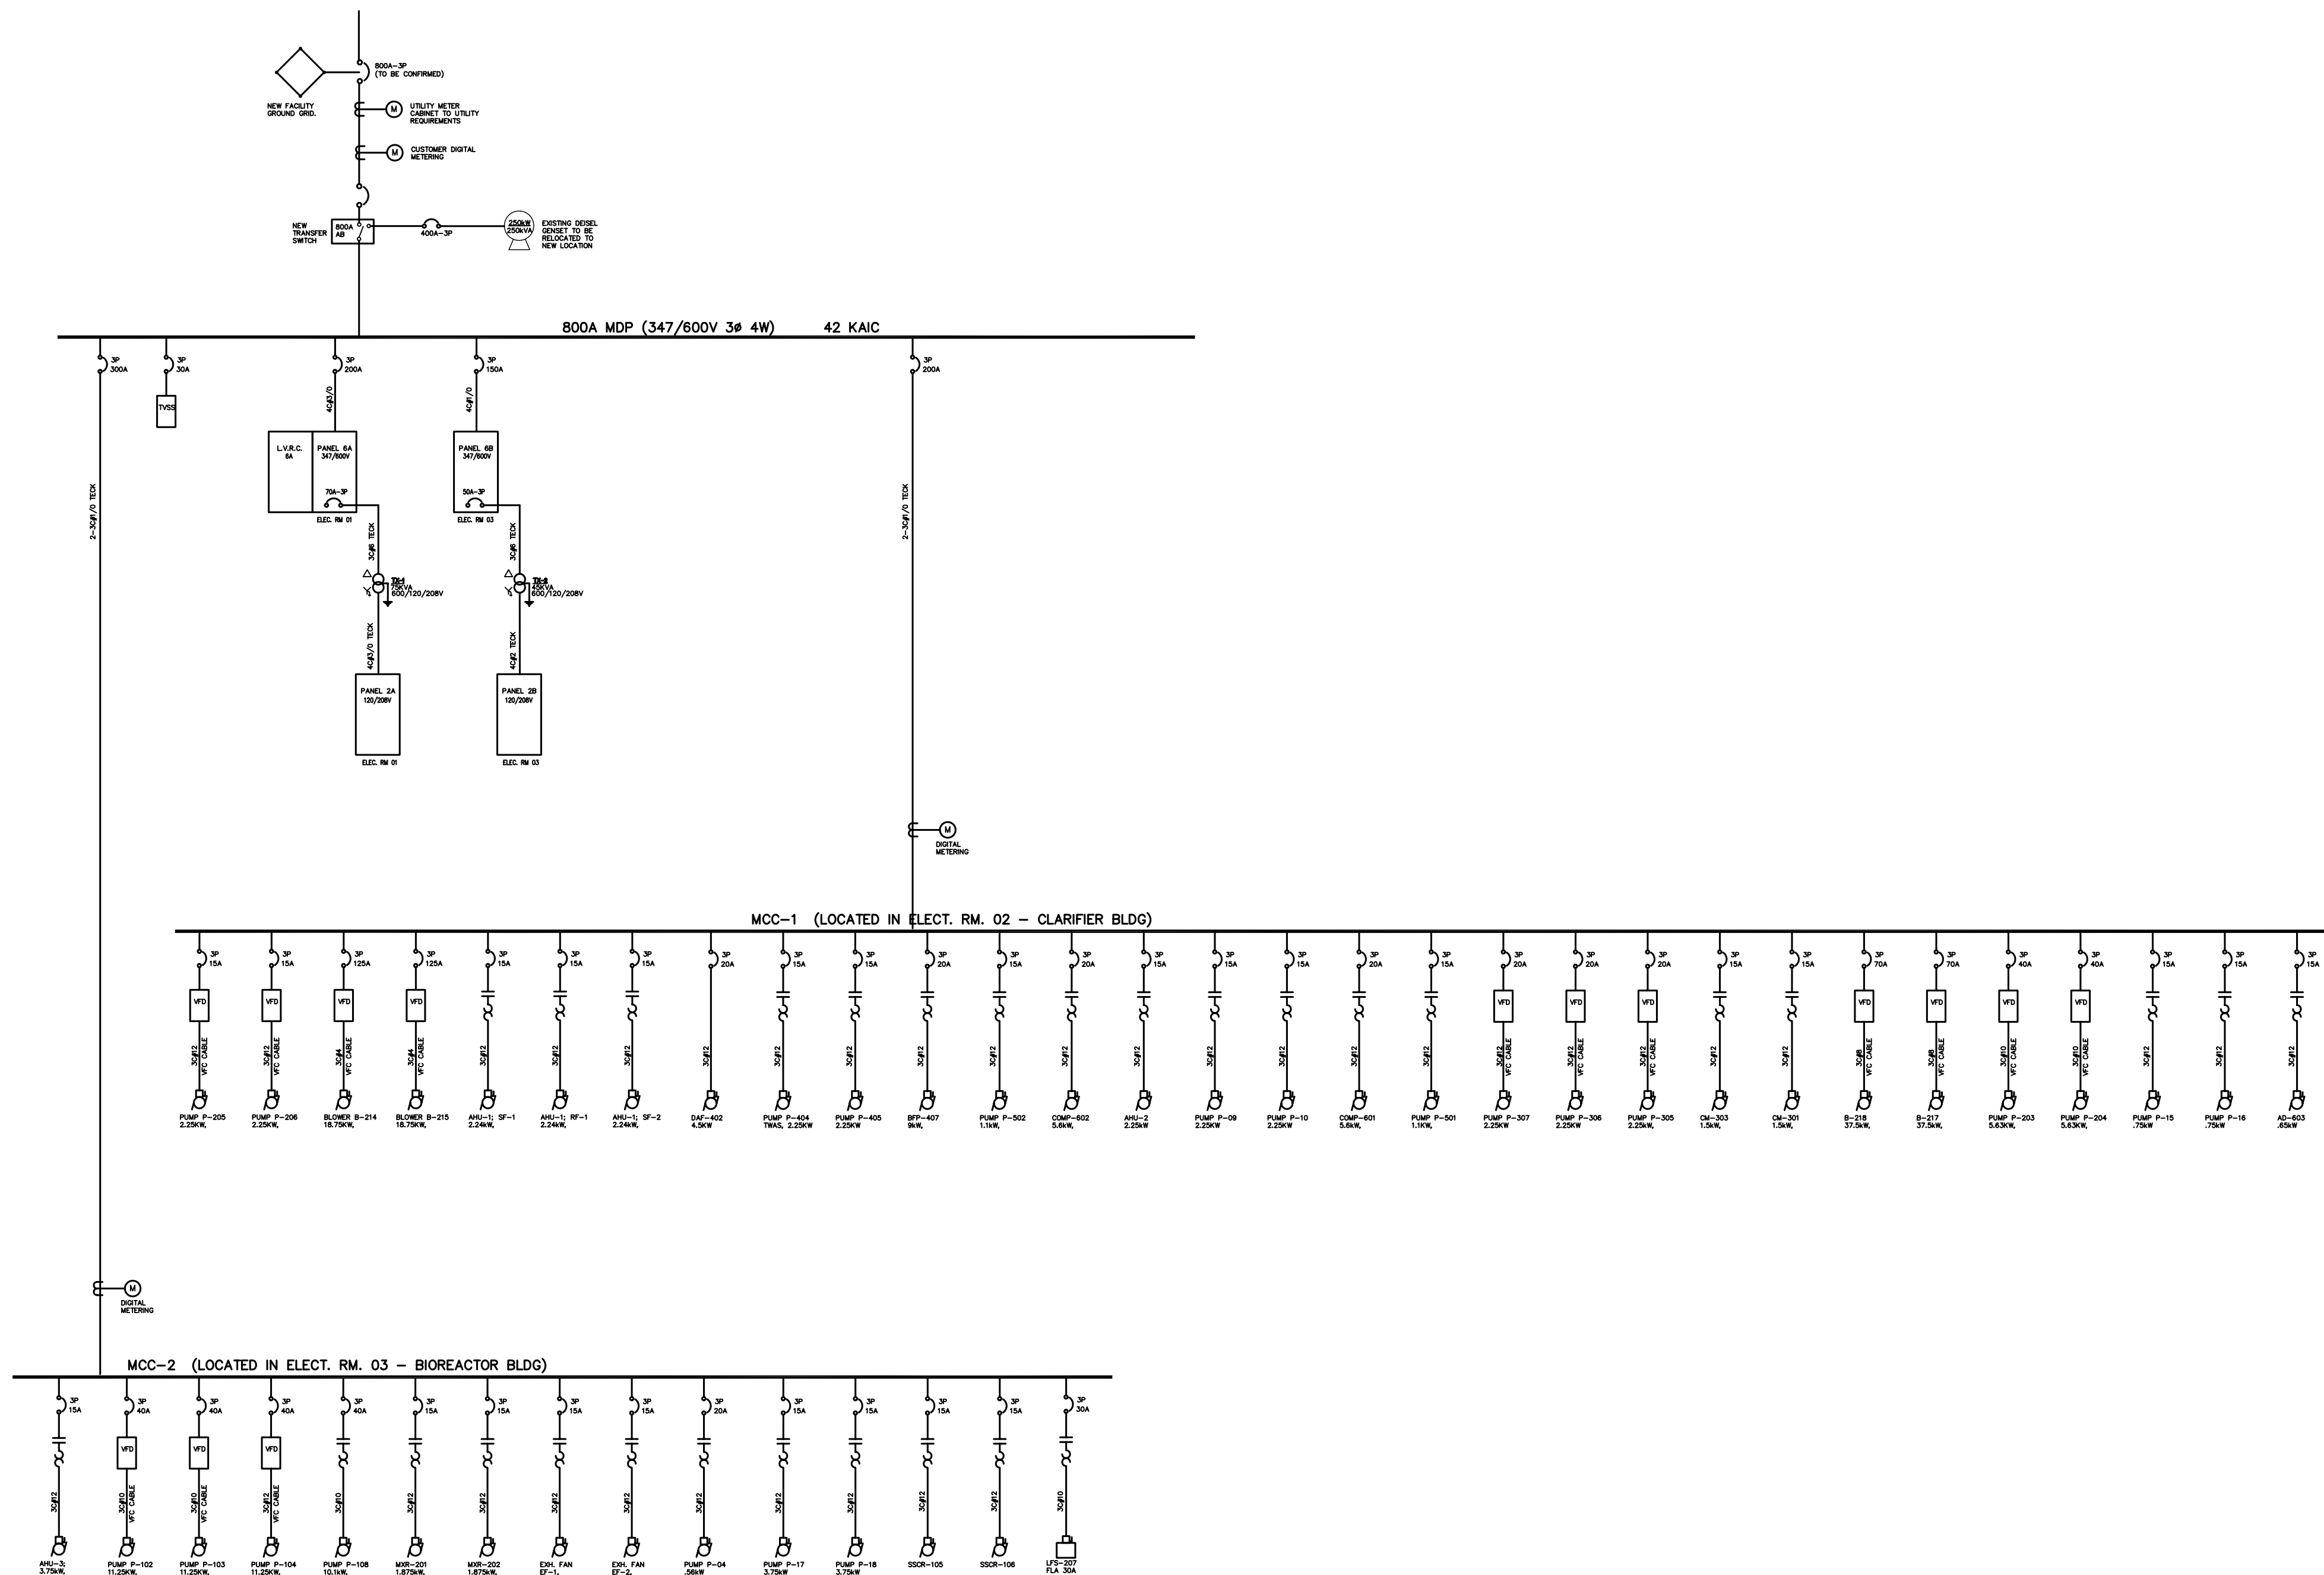

ELECTRICAL SINGLE LINE DIAGRAM
N.T.S.

PRELIMINARY
Not For Construction

OCT.15.2004

A	2004 OCT 15	ISSUED FOR 95% REVIEW
No.	Date	Description

REVISIONS			
-----------	--	--	--

Iqaluit
**CITY of IQALUIT,**
Nunavut

Design	WA
Drawn	YLC
Approved	
Chief	

Director

Project Title

CITY OF IQALUIT
WASTEWATER
TREATMENT PLANT

Drawing Title

**ELECTRICAL
SINGLE LINE
DIAGRAM**

Scale AS SHOWN	
Project No. 75360	Date SEPT 200
Drawing No. E4.01	Revision A