


NOTES:

1. EXISTING SCREW SCREENS AND BYPASS CHANNEL ARE TO BE RELOCATED TO THE NEW HEADWORKS BUILDING.

2. EXISTING VALVES AND PIPING TO BE RELOCATED.

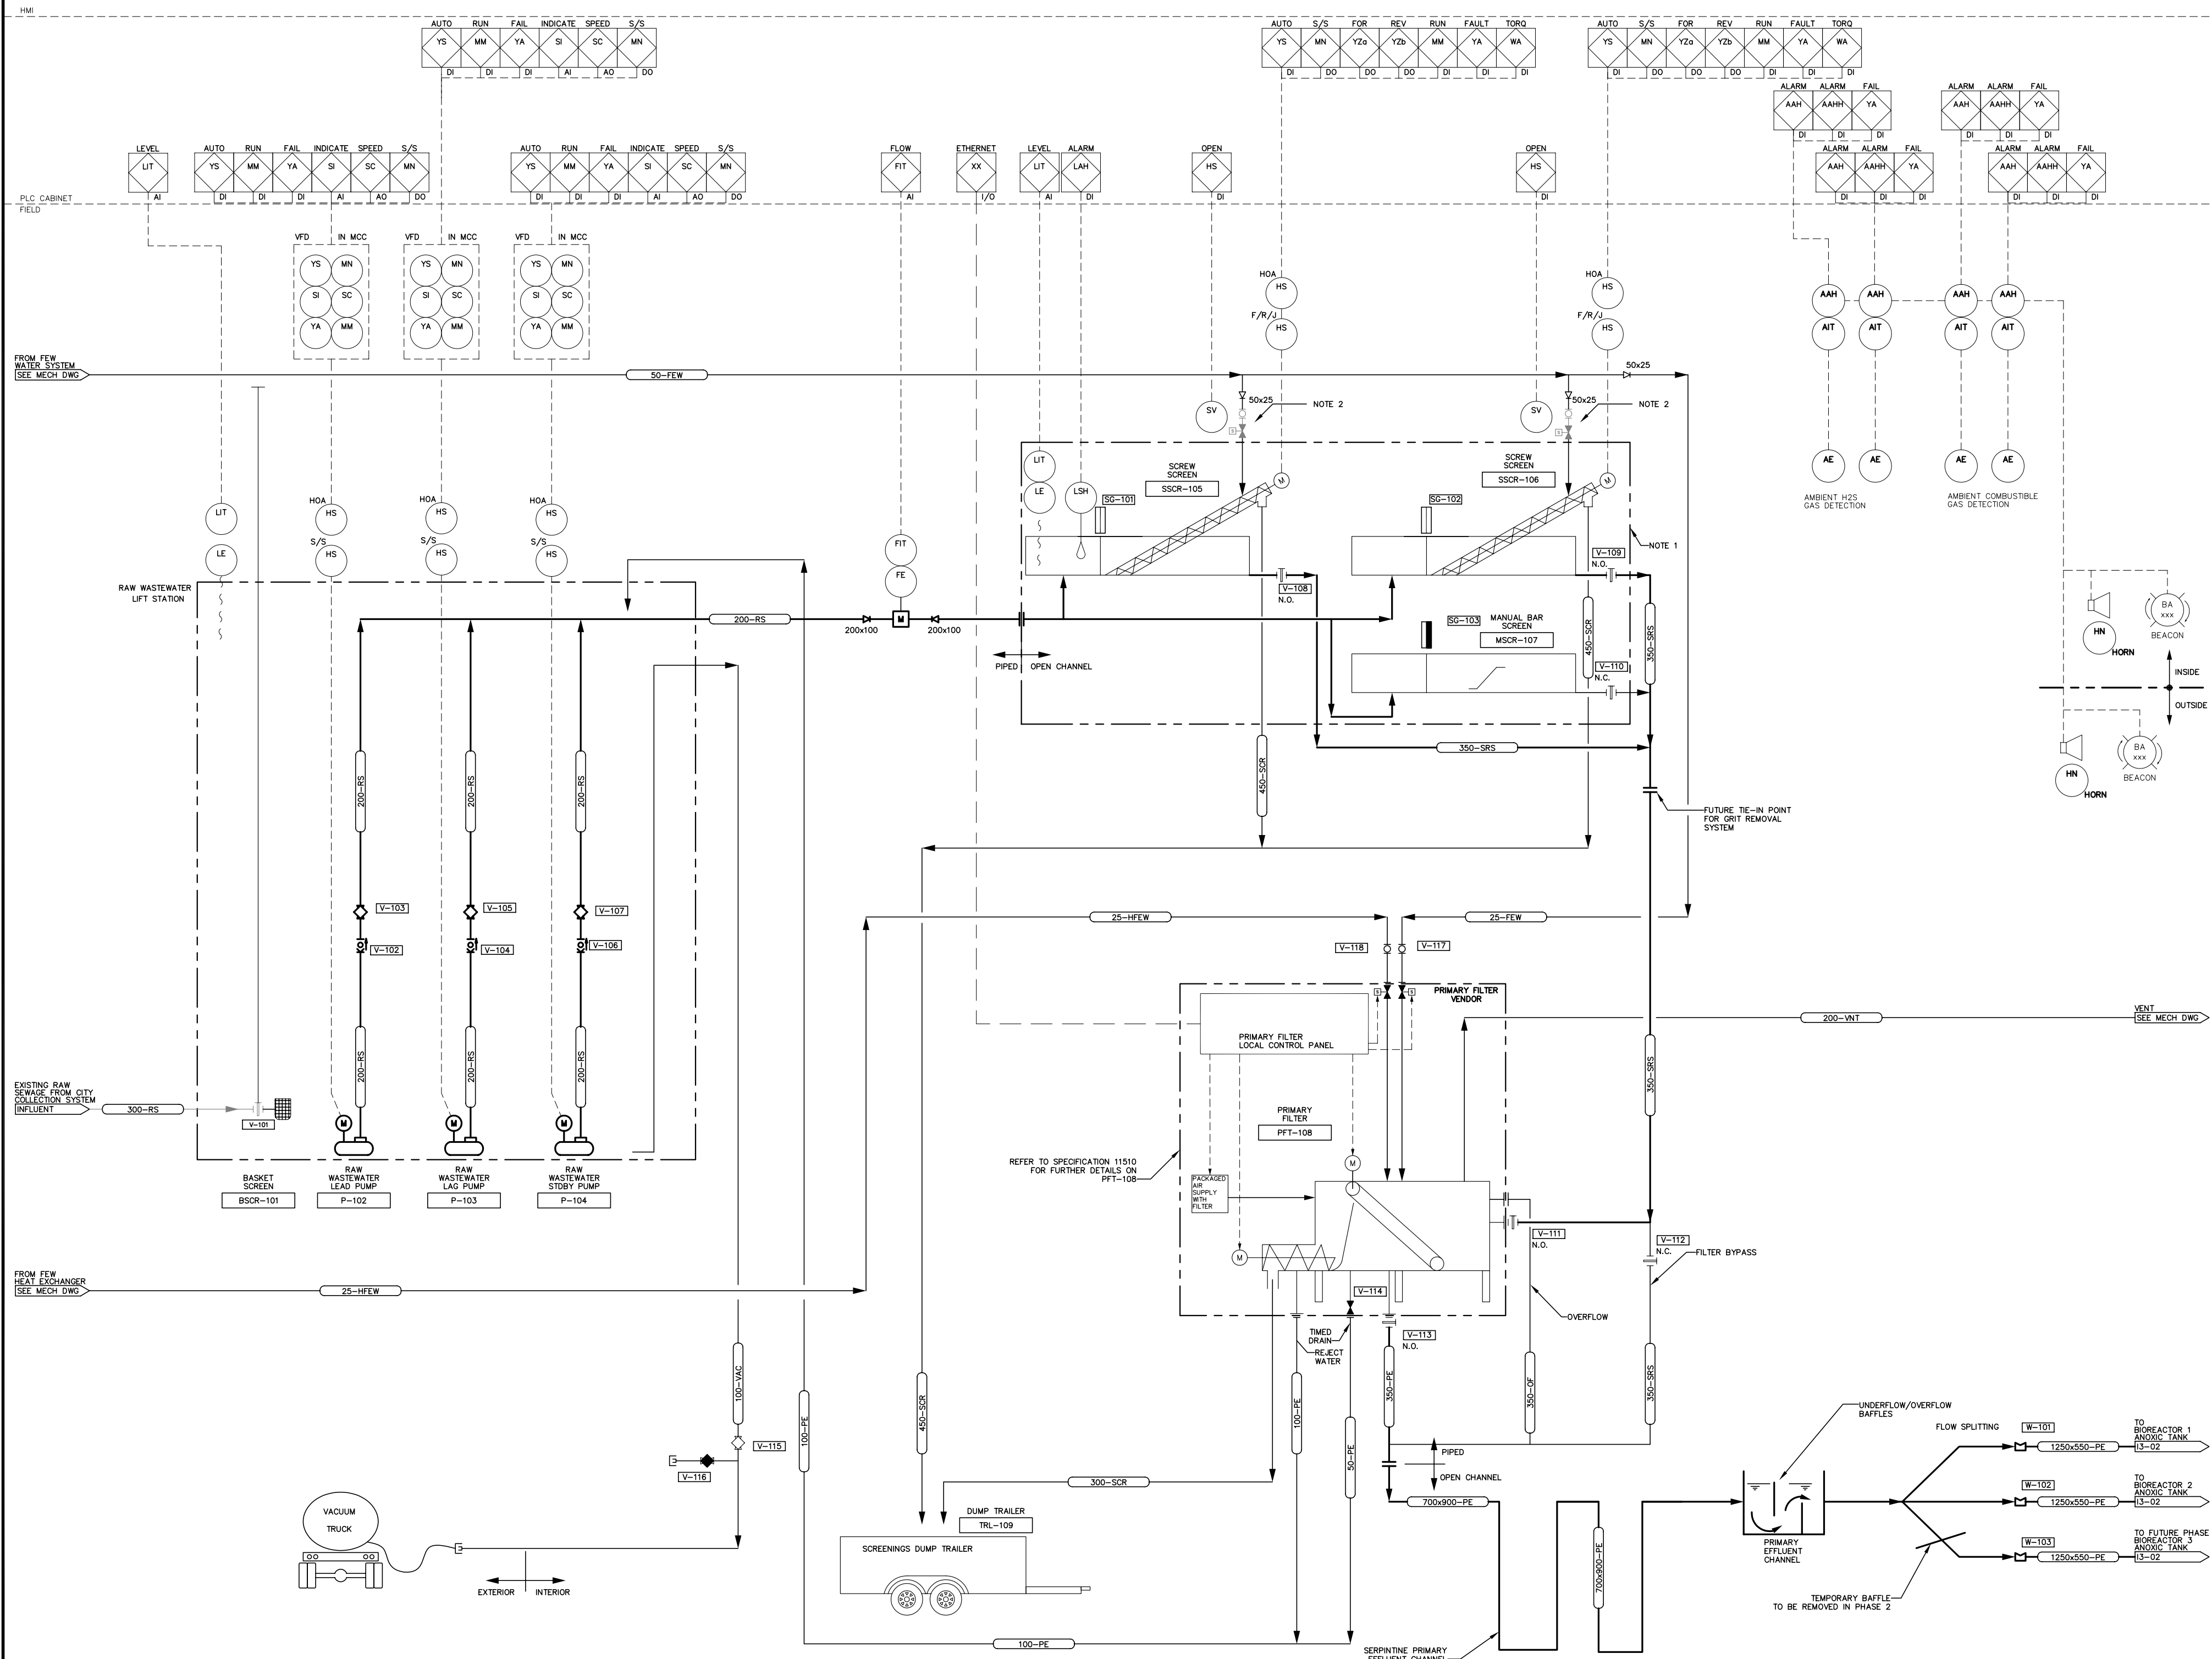

PRELIMINARY
Not For Construction
OCT.15.2004

No.	Date	Description
B	2004 10/15	ISSUED FOR 95% CLIENT REVIEW
A	2004 08/13	ISSUED FOR 50% CLIENT REVIEW

REVISIONS



Design: SNS/TDC
Drawn: DKB
Approved: Chief
Director: Project Title

CITY OF IQALUIT
WASTEWATER
TREATMENT PLANT

Drawing Title:
RAW WASTEWATER
PUMPING STATION
& HEADWORKS
P&ID

Scale: NONE
Project No.: 75360
Date: 07/07/04
Drawing No.: 13-01
Revision: B