


- NOTES:**
1. MATERIAL ON SITE, REQUIRED TO BE INSTALLED.
 2. PIPE IS EXISTING AND INSTALLED.
 3. PROCESS AIR IS SUPPLIED BY ONE 300 DIA. HEADER PIPE TO BOTH BIOREACTORS. REFER TO THE PROCESS LAYOUT DRAWINGS FOR CLARITY. ALL PROCESS AIR PIPING IS TO BE INSULATED FROM THE BIOREACTORS TO THE BLOWERS.
 4. EXISTING MIXERS ARE TO BE INSTALLED.
 5. EXISTING DISSOLVED OXYGEN PROBES TO BE INSTALLED.

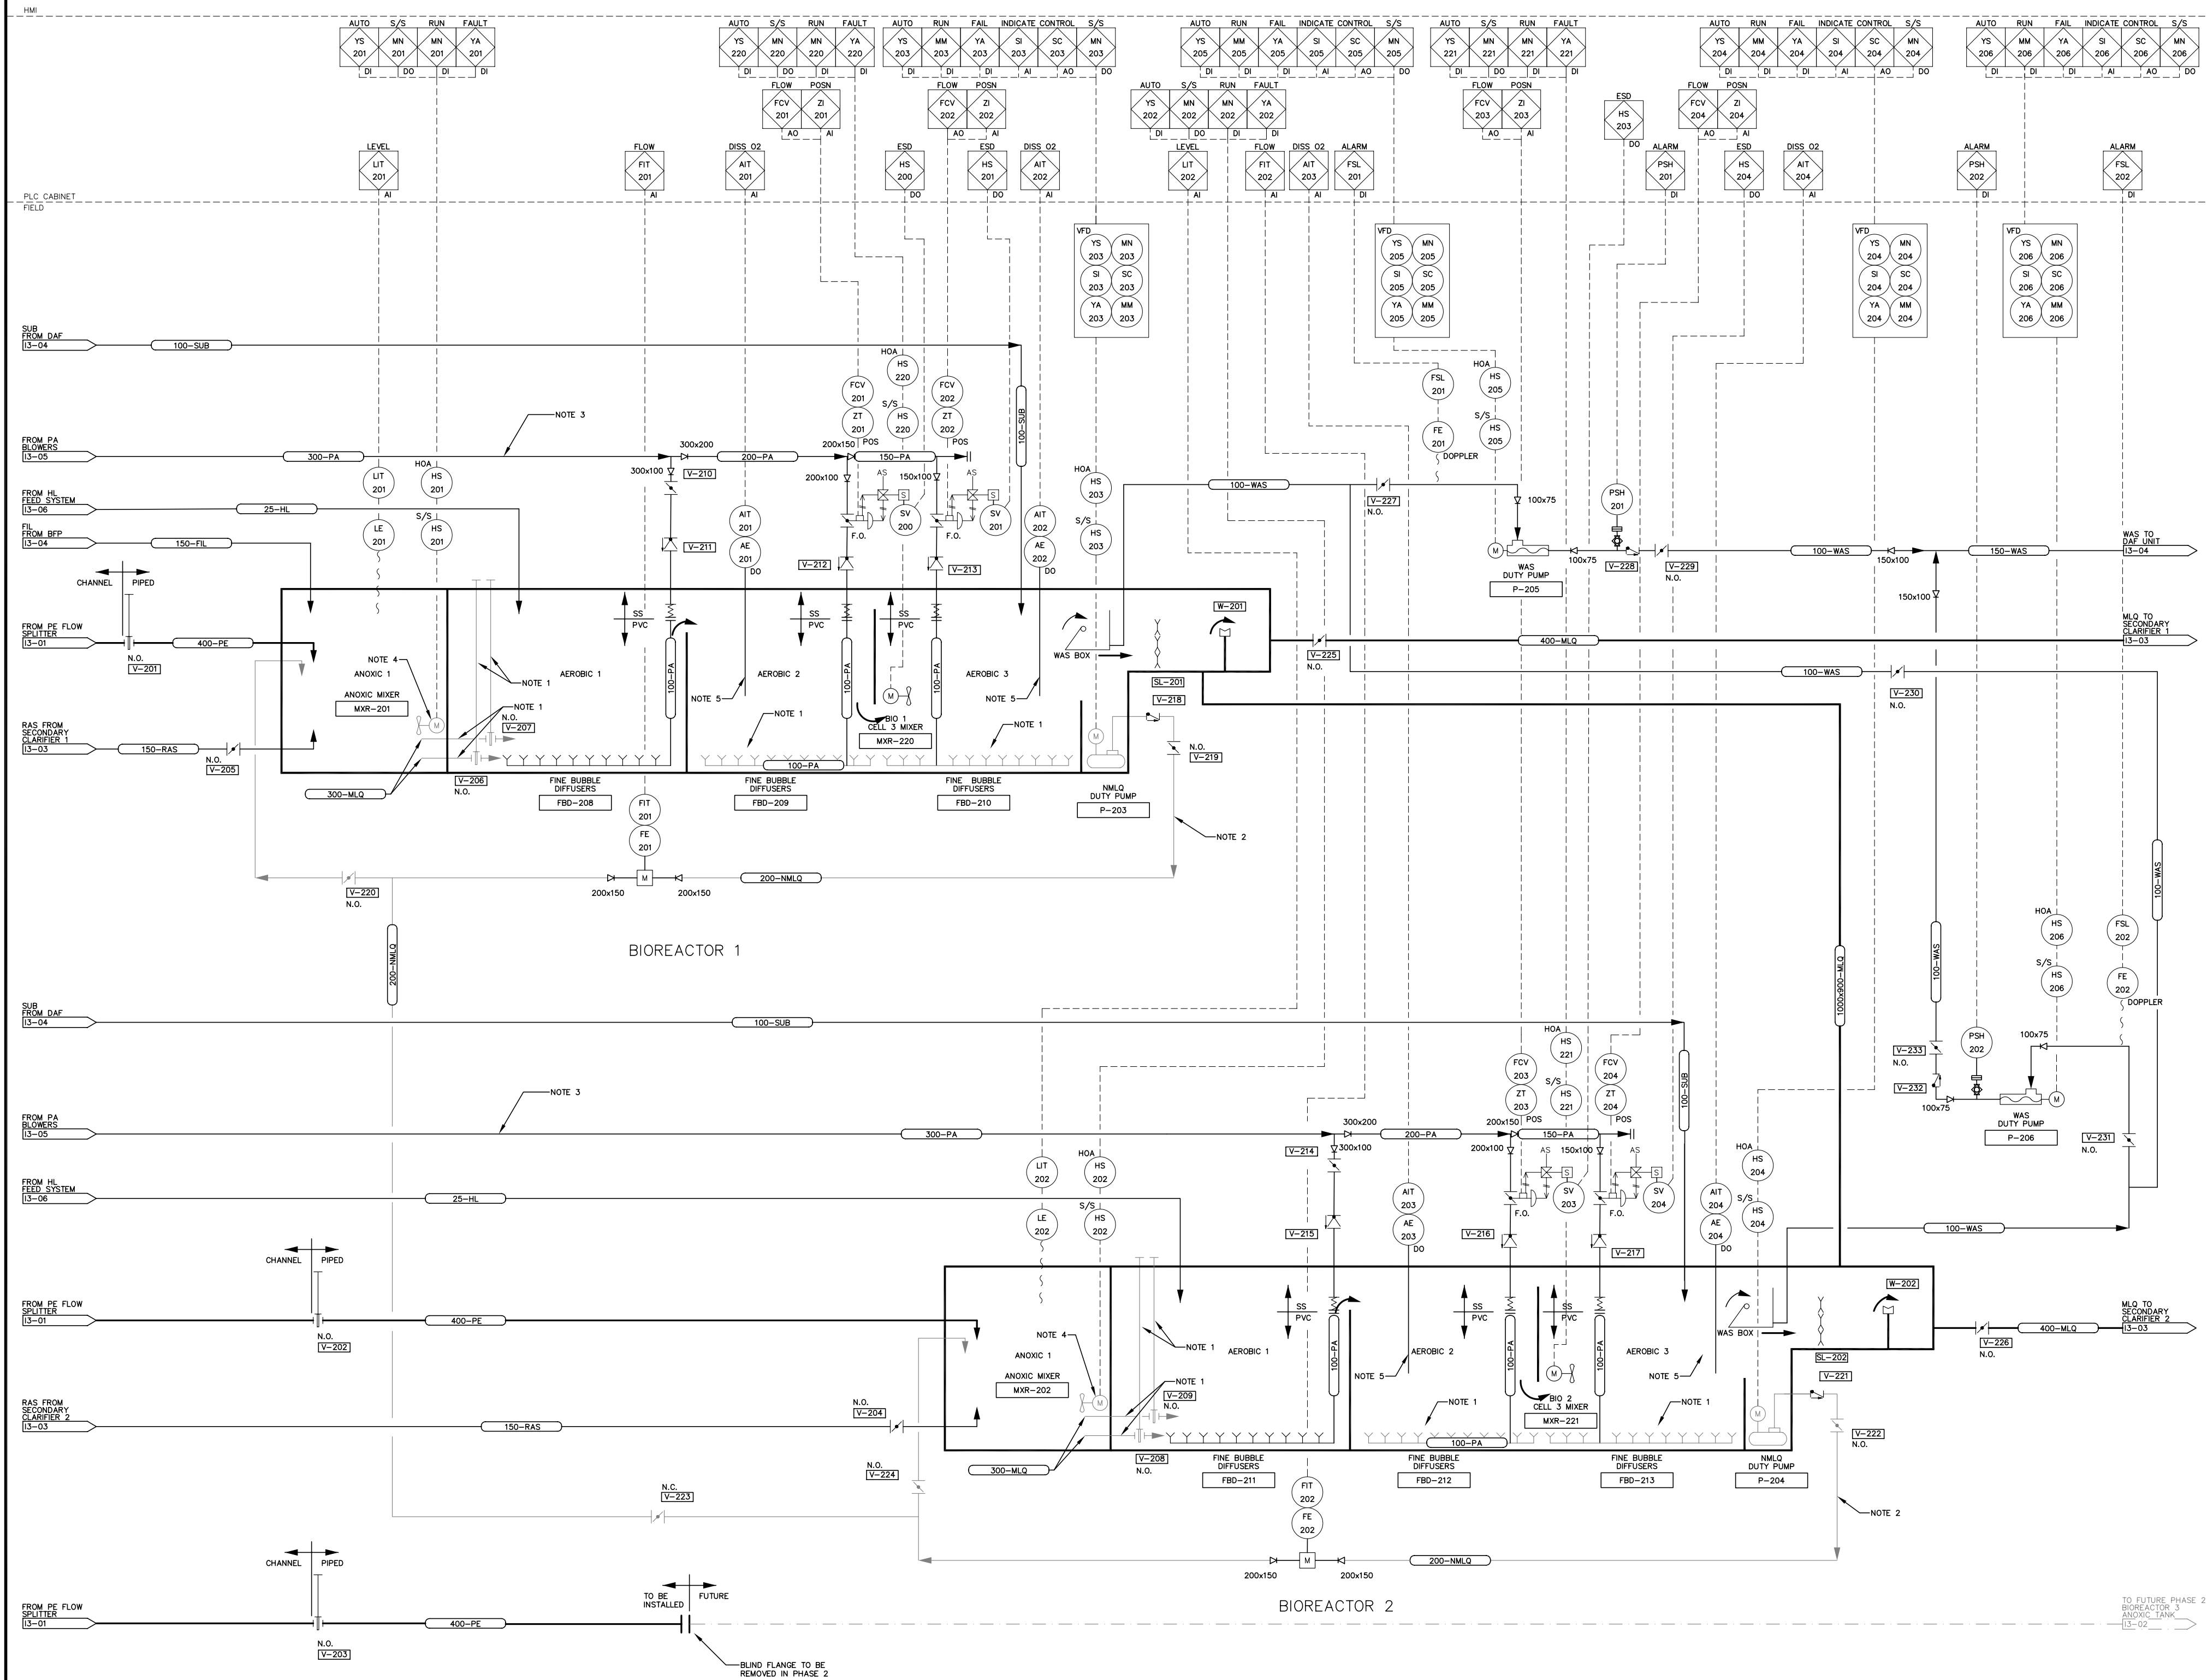

PRELIMINARY
Not For Construction
OCT.15.2004

No.	Date	Description
B	2004/10/15	ISSUED FOR 95% CLIENT REVIEW
A	2004/08/13	ISSUED FOR 50% CLIENT REVIEW

REVISIONS



Design: SNS/TDC
Drawn: DKB
Approved: Chief

Director
Project Title

**CITY OF IQALUIT
WASTEWATER
TREATMENT PLANT**

Drawing Title
**BIOREACTORS 1 & 2
P&ID**

Scale: NONE
Project No.: 75360
Date: 08/07/04
Drawing No.: **13-02**
Revision: **B**