


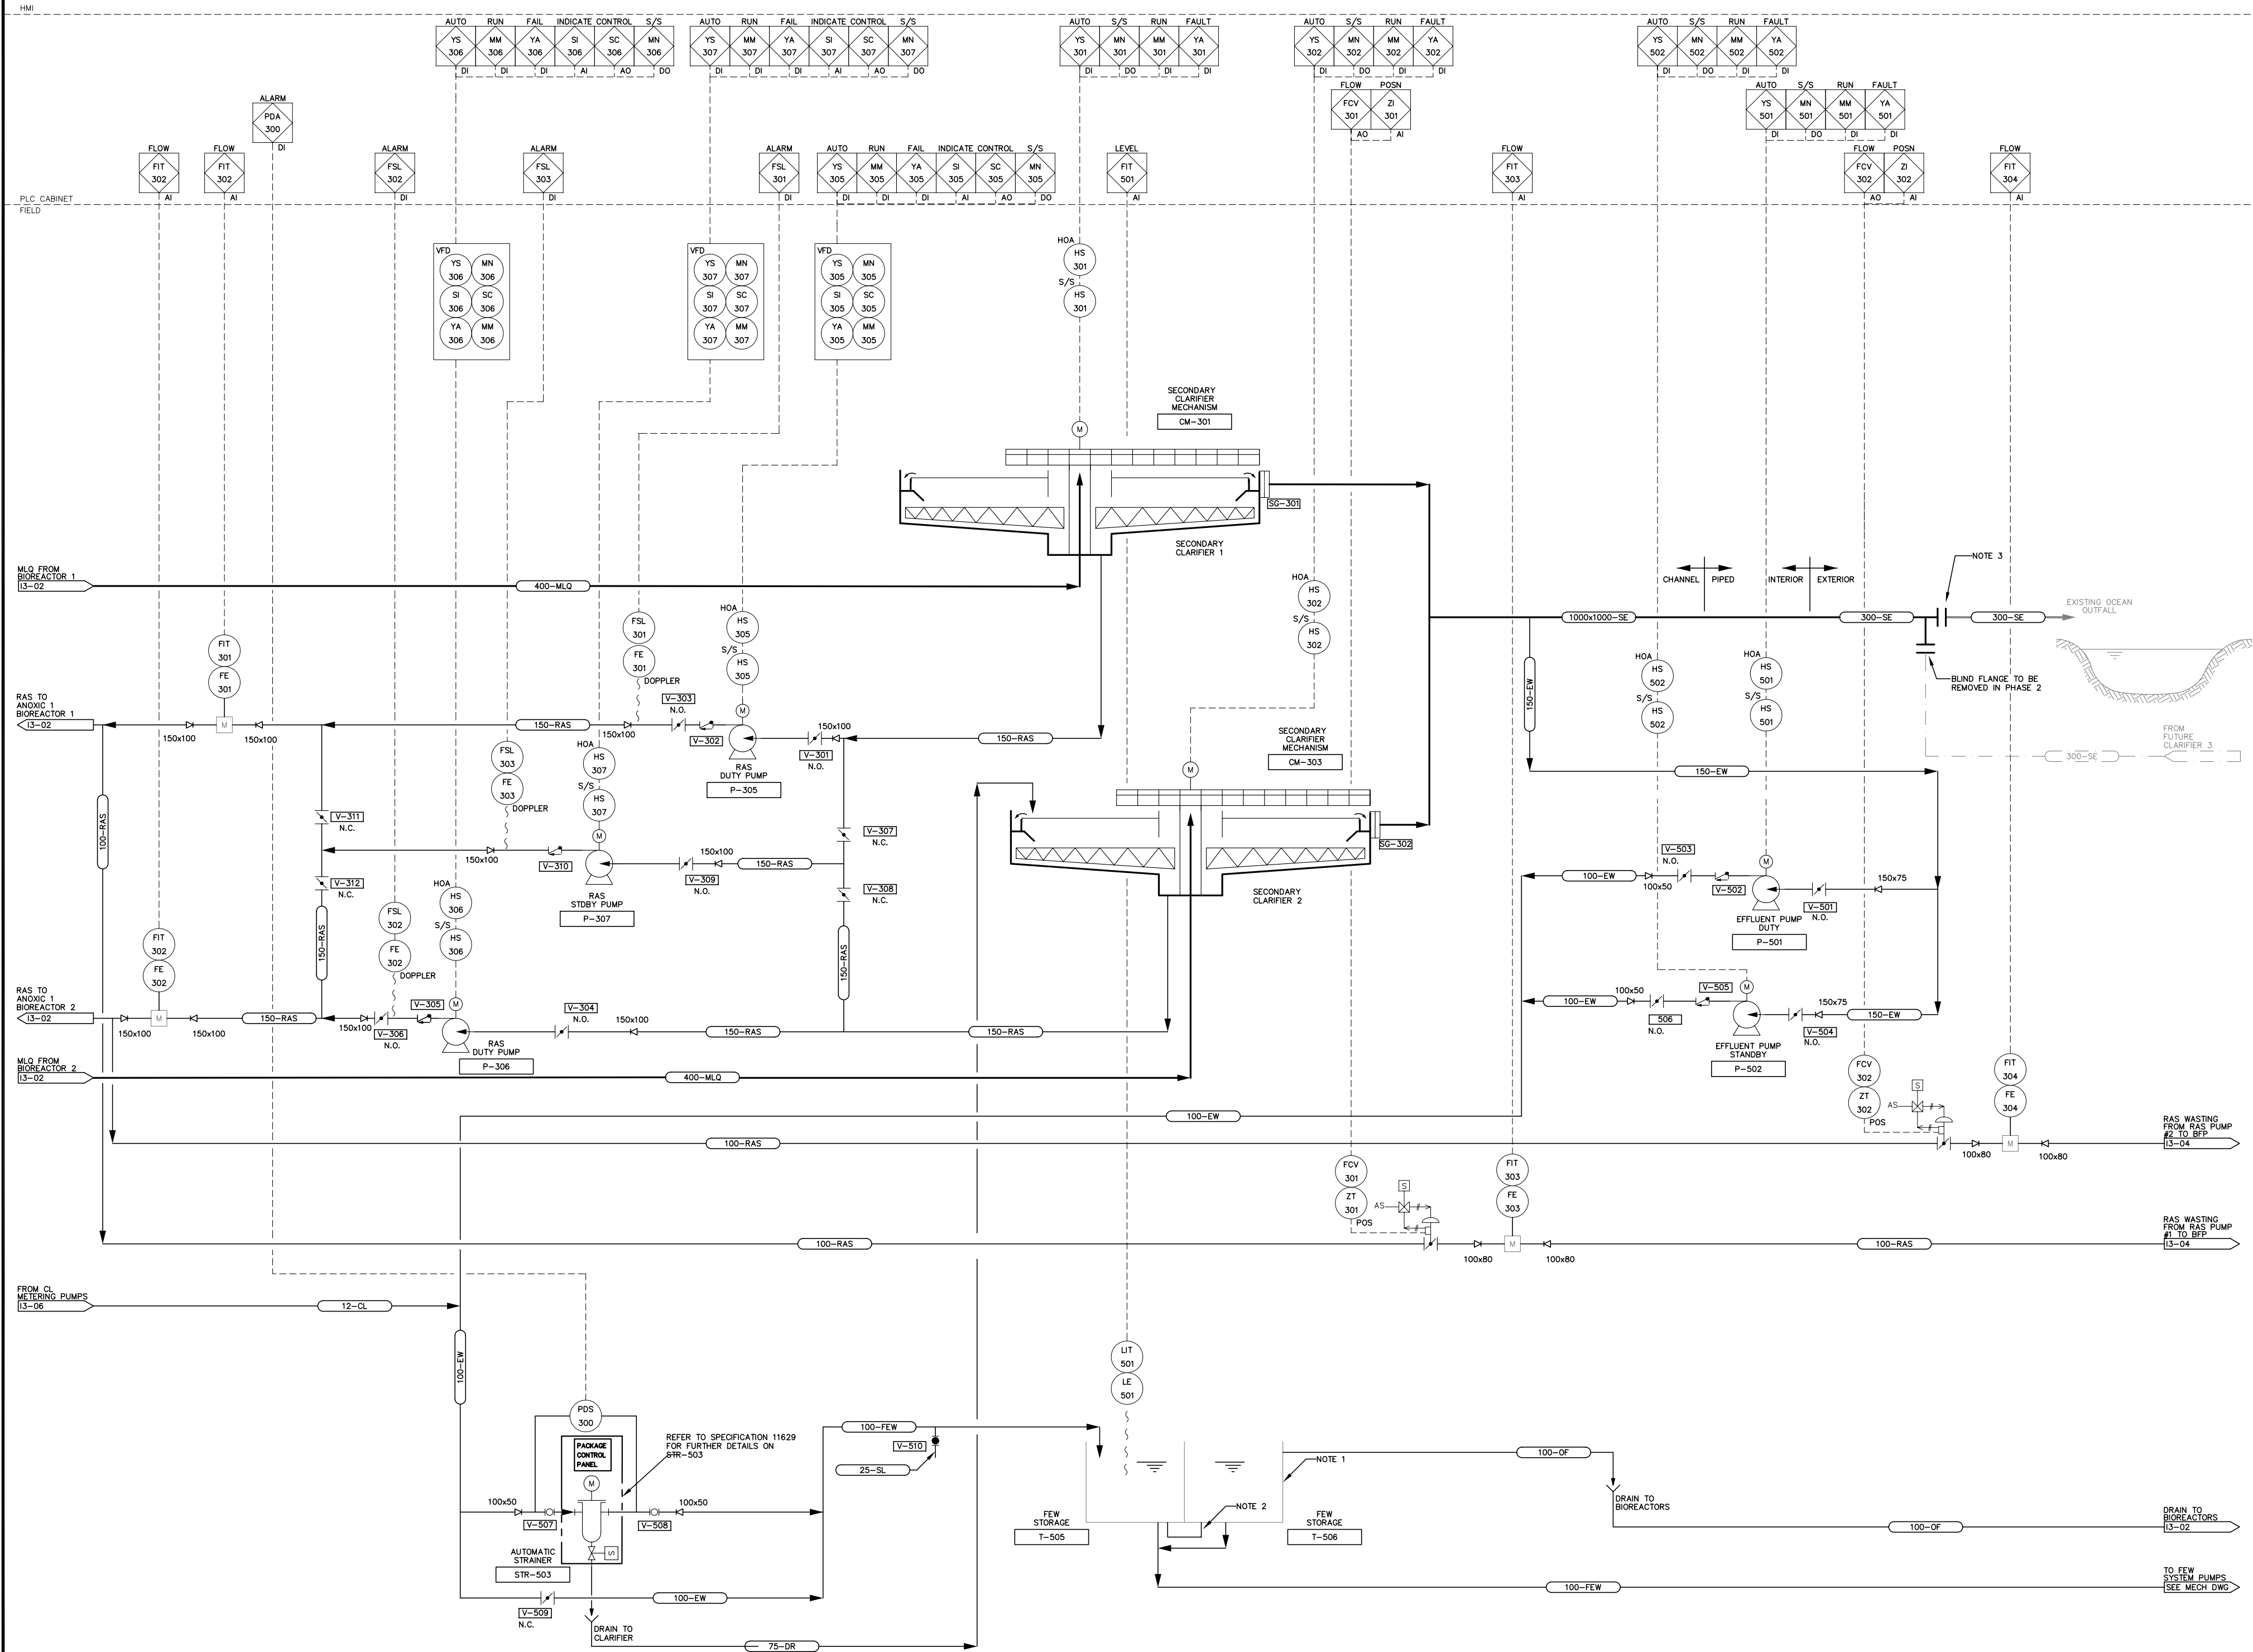

- NOTES:
1. REUSE THE EXISTING STAINLESS STEEL TANKS.
 2. NEW 150 DIA. PIPING TO BALANCE THE WATER LEVELS BETWEEN TANKS.
 3. TIE IN TO THE EXISTING OUTFALL PIPING.

PRELIMINARY
Not For Construction
OCT.15.2004

No.	Date	Description
B	2004/10/15	ISSUED FOR 95% CLIENT REVIEW
A	2004/08/13	ISSUED FOR 50% CLIENT REVIEW

REVISIONS



Design: SNS/TDC
Drawn: DKB
Approved: Chief
Director: Project Title

CITY OF IQALUIT
WASTEWATER
TREATMENT PLANT

Drawing Title:
CLARIFIERS & EFFLUENT WATER SYSTEMS P&ID

Scale: NONE
Project No.: 75360
Date: 08/07/04
Drawing No.: 13-03
Revision: B