


- NOTES:
1. ENSURE THAT THE TWAS VENT OUTLET ELEVATION IS HIGHER THEN THE DAF WATER LEVEL ELEVATION.
 2. REUSE/RELOCATE THE EXISTING PROGRESSIVE CAVITY PUMP TO THE NEW LOCATION.
 3. INSTALL THE EXISTING FINE BUBBLE DIFFUSERS IN THE TWAS TANK AND MODIFY AS NECESSARY.

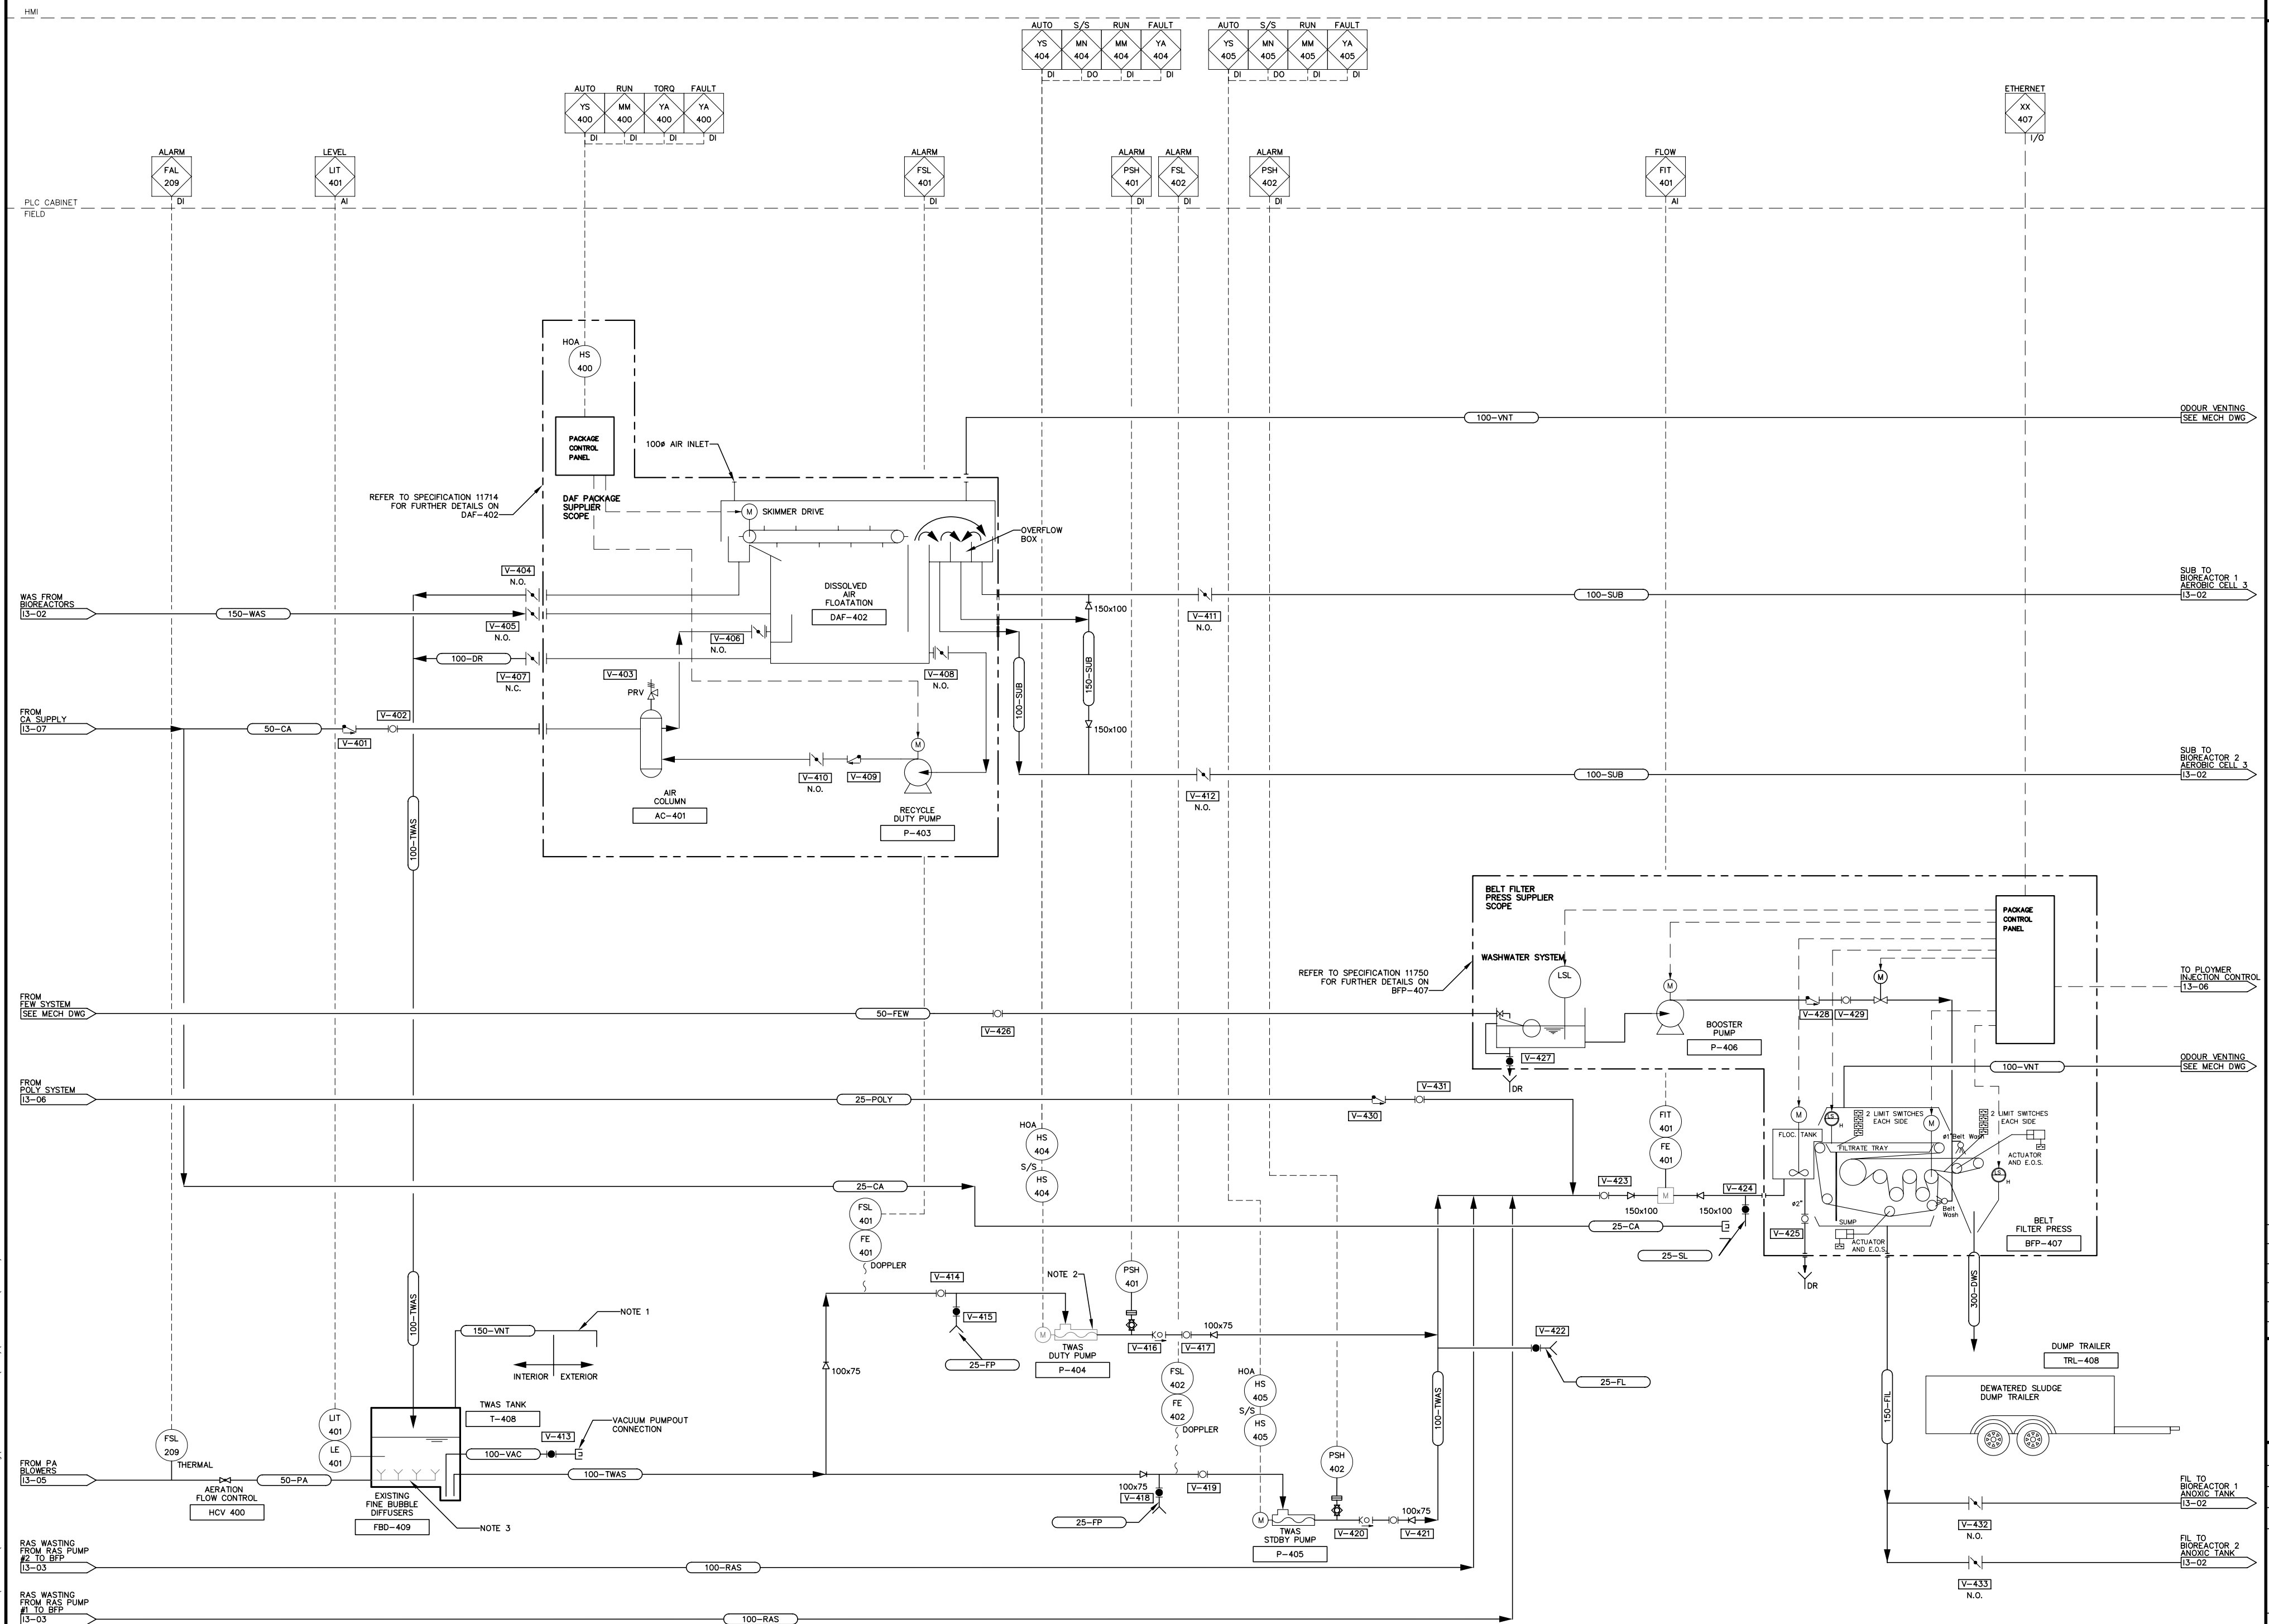

PRELIMINARY
Not For Construction
OCT.15.2004

No.	Date	Description
B	2004 10/15	ISSUED FOR 95% REVIEW
A	2004 08/13	ISSUED FOR 50% REVIEW

REVISIONS



Design: SNS/TDC
Drawn: DKB
Approved: Chief
Director: Project Title

**CITY OF IQALUIT
WASTEWATER
TREATMENT PLANT**

Drawing Title:
**DAF, TWAS
& BFP
P&ID**

Scale: NONE
Project No.: 75360
Date: 08/07/04
Drawing No.: 13-04
Revision: B