


- NOTES:
1. PIPING AND EQUIPMENT EXISTING AND INSTALLED.
 2. ALL NEW INSULATED DUCT CONNECTED TO THE INDIVIDUAL BLOWER INTAKES. THE INDIVIDUAL DUCTS TO BE CONNECTED TO THE NEW INTAKE LOUVER. SEE MECHANICAL DRAWINGS FOR DETAILS.
 3. ALL EXPOSED PROCESS AIR PIPING IS TO BE INSULATED.

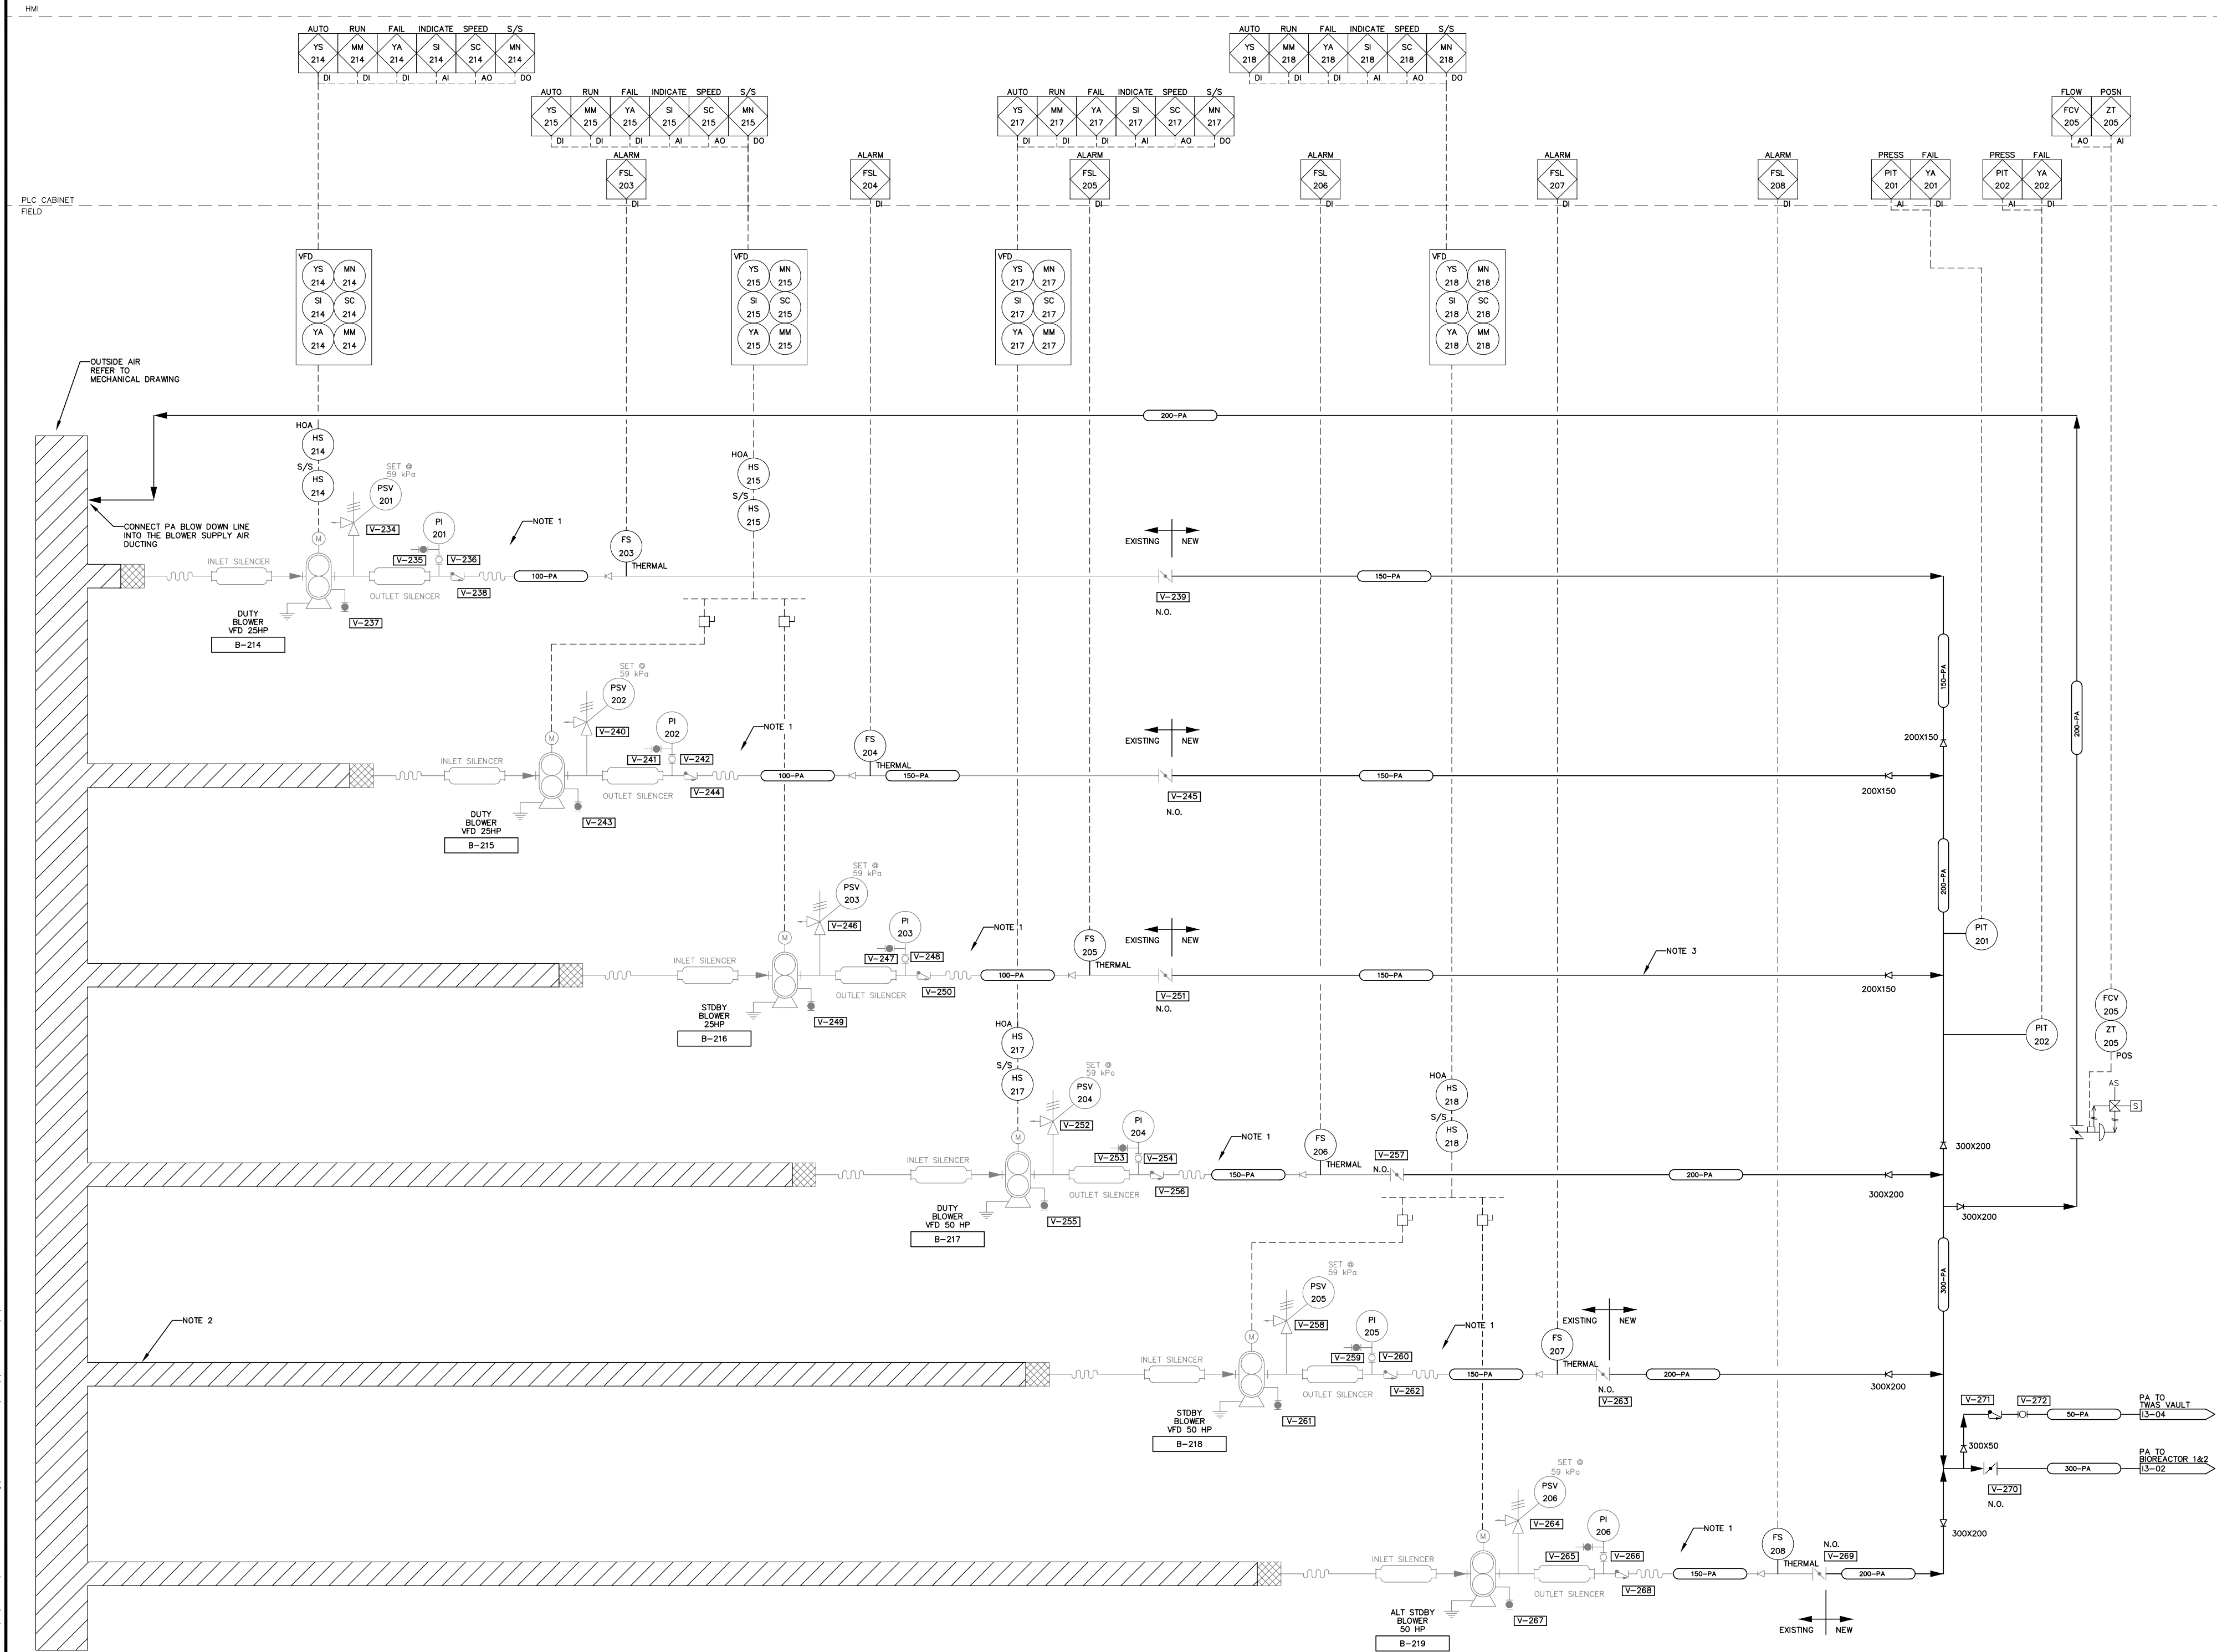

PRELIMINARY
Not For Construction
OCT.15.2004

No.	Date	Description
B	2004/10/15	ISSUED FOR 95% CLIENT REVIEW
A	2004/08/13	ISSUED FOR 50% CLIENT REVIEW

REVISIONS



Design: SNS/TDC
Drawn: DKB
Approved: Chief
Director: Project Title

CITY OF IQALUIT
WASTEWATER
TREATMENT PLANT

Drawing Title
PROCESS AIR
BLOWERS
P&ID

Scale: NONE
Project No.: 75360
Date: 29/07/04
Drawing No.: 13-05
Revision: B