


HMI

PLC CABINET
FIELD

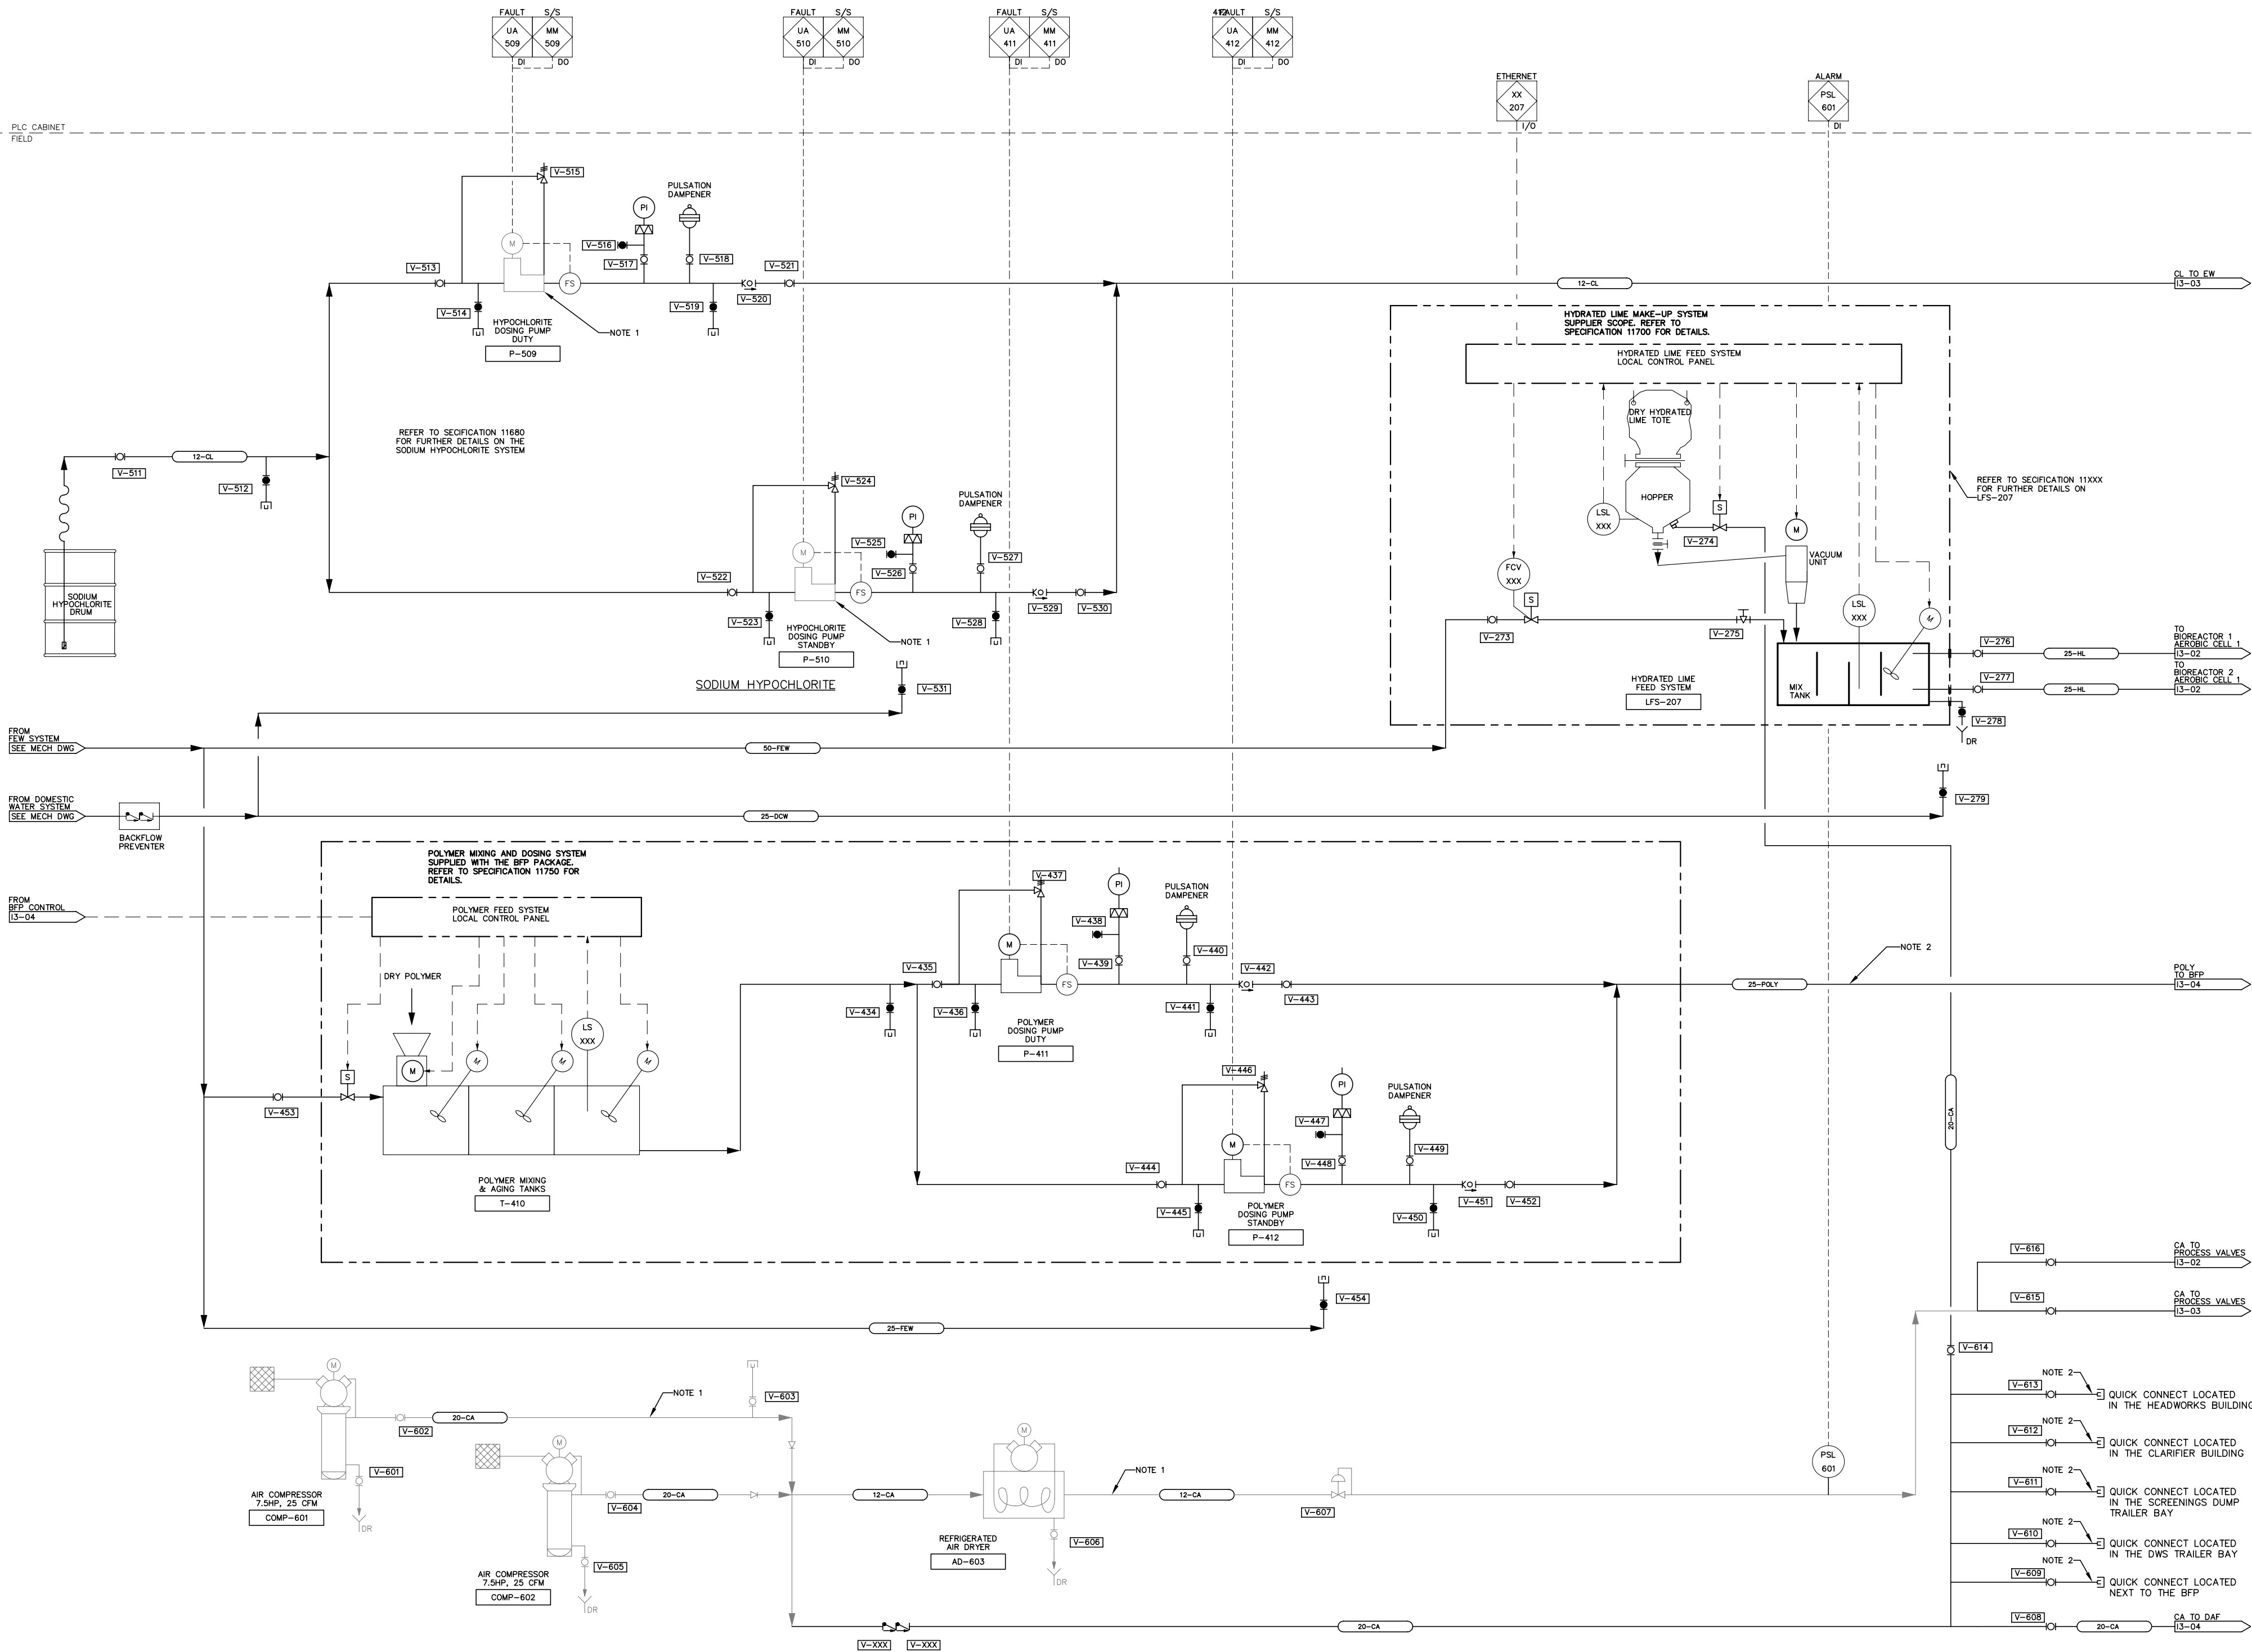

NOTES:
1. REUSE/RELOCATE EXISTING SODIUM HYPOCHLORITE METERING PUMPS.
2. PIPING IS SUPPLIED BY THE CONTRACTOR.

PRELIMINARY
Not For Construction
OCT.15.2004

No.	Date	Description
B	2004 10/15	ISSUED FOR 95% CLIENT REVIEW
A	2004 08/13	ISSUED FOR 50% CLIENT REVIEW

REVISIONS



Design: SNS/DC
Drawn: DKB
Approved: Chief
Director: Project Title

**CITY OF IQALUIT
WASTEWATER
TREATMENT PLANT**

Drawing Title:
**LIME, CHLORINE &
POLYMER CHEMICALS
& SERVICE AIR
P&ID**

Scale: NONE
Project No.: 75360
Date: 29/07/04
Drawing No.: 13-06
Revision: B