

1 MAIN FLOOR PLAN
SCALE: 1:150

REVISION:				REVISION:			
REV	DATE	DESCRIPTION	BY	REV	DATE	DESCRIPTION	BY
A	2021/11/18	ISSUED FOR CONSTRUCTION	C.G.				

SEAL:

PERMIT TO PRACTICE
WSP Canada Inc.
Signature: *J.M. RAK-BANVILLE*
Date: November 18, 2021
PERMIT NUMBER: P407
NT/NU Association of Professional Engineers and Geoscientists

DISCLAIMER:
THIS DRAWING AND DESIGN IS COPYRIGHT PROTECTED WHICH SHALL NOT BE USED, REPRODUCED OR REVISED WITHOUT WRITTEN PERMISSION BY WSP. THE CONTRACTOR SHALL CHECK AND VERIFY ALL DIMENSIONS AND UTILITY LOCATIONS AND REPORT ALL ERRORS AND OMISSIONS PRIOR TO COMMENCING WORK.

COPYRIGHT
J.R.B.

ORIGINAL SCALE:	DATE:
SCALE	2021/11/18
DESIGNED BY:	
C.G.	
ASSISTED BY:	
I.M.	
DRAWN BY:	
V.A.A.	
MODIFIED BY:	
V.A.A.	
APPROVED BY:	
J.R.B.	
DISCIPLINE:	
INFRASTRUCTURE	

WSP Canada Inc.
1600 Buffalo Place, Winnipeg, Manitoba R3T 6B8
T 204-477-6650 | www.wsp.com

 
PROJECT NUMBER: 201-09487-00

CLIENT:

IQUALUIT WATER TREATMENT PLANT UPGRADE
City of Iqaluit, Nunavut

CLIENT REF: # -


TITLE:		PROJECT:	
MAIN FLOOR PLAN		IQUALUIT WATER EMERGENCY	
DRAWING NUMBER:		REV.	
P-101		A	



SCALE : 1:50



SCALE : 1:50

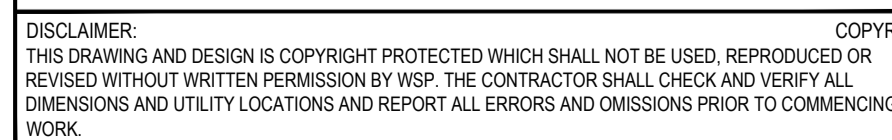

PROTECTED WHICH SHALL NOT BE USED, REPRODUCED OR
 UP, THE CONTRACTOR SHALL CHECK AND VERIFY ALL
 RT ALL ERRORS AND OMISSIONS PRIOR TO COMMENCING

DATE: 2021/11/18

IF THIS BAR IS NOT 25mm LONG, ADJUST YOUR PLOTTING SCALE.

25mm

PROJECT NUMBER: 201-09487-00

CLIENT REF. #:

FILTER FLOOR LEVEL



IQALUIT WATER EMERGENCY

DRAWING NUMBER

P-102

REV.

C:\Users\jbanville\OneDrive\Documents\2021\11\18\10:04 AM
PLOTTED: 2021/11/18 10:04 AM
FILE: c:\users\jbanville\OneDrive\Documents\2021\11\18\10:04 AM\project\15\chase\qualit\qualit.dwg

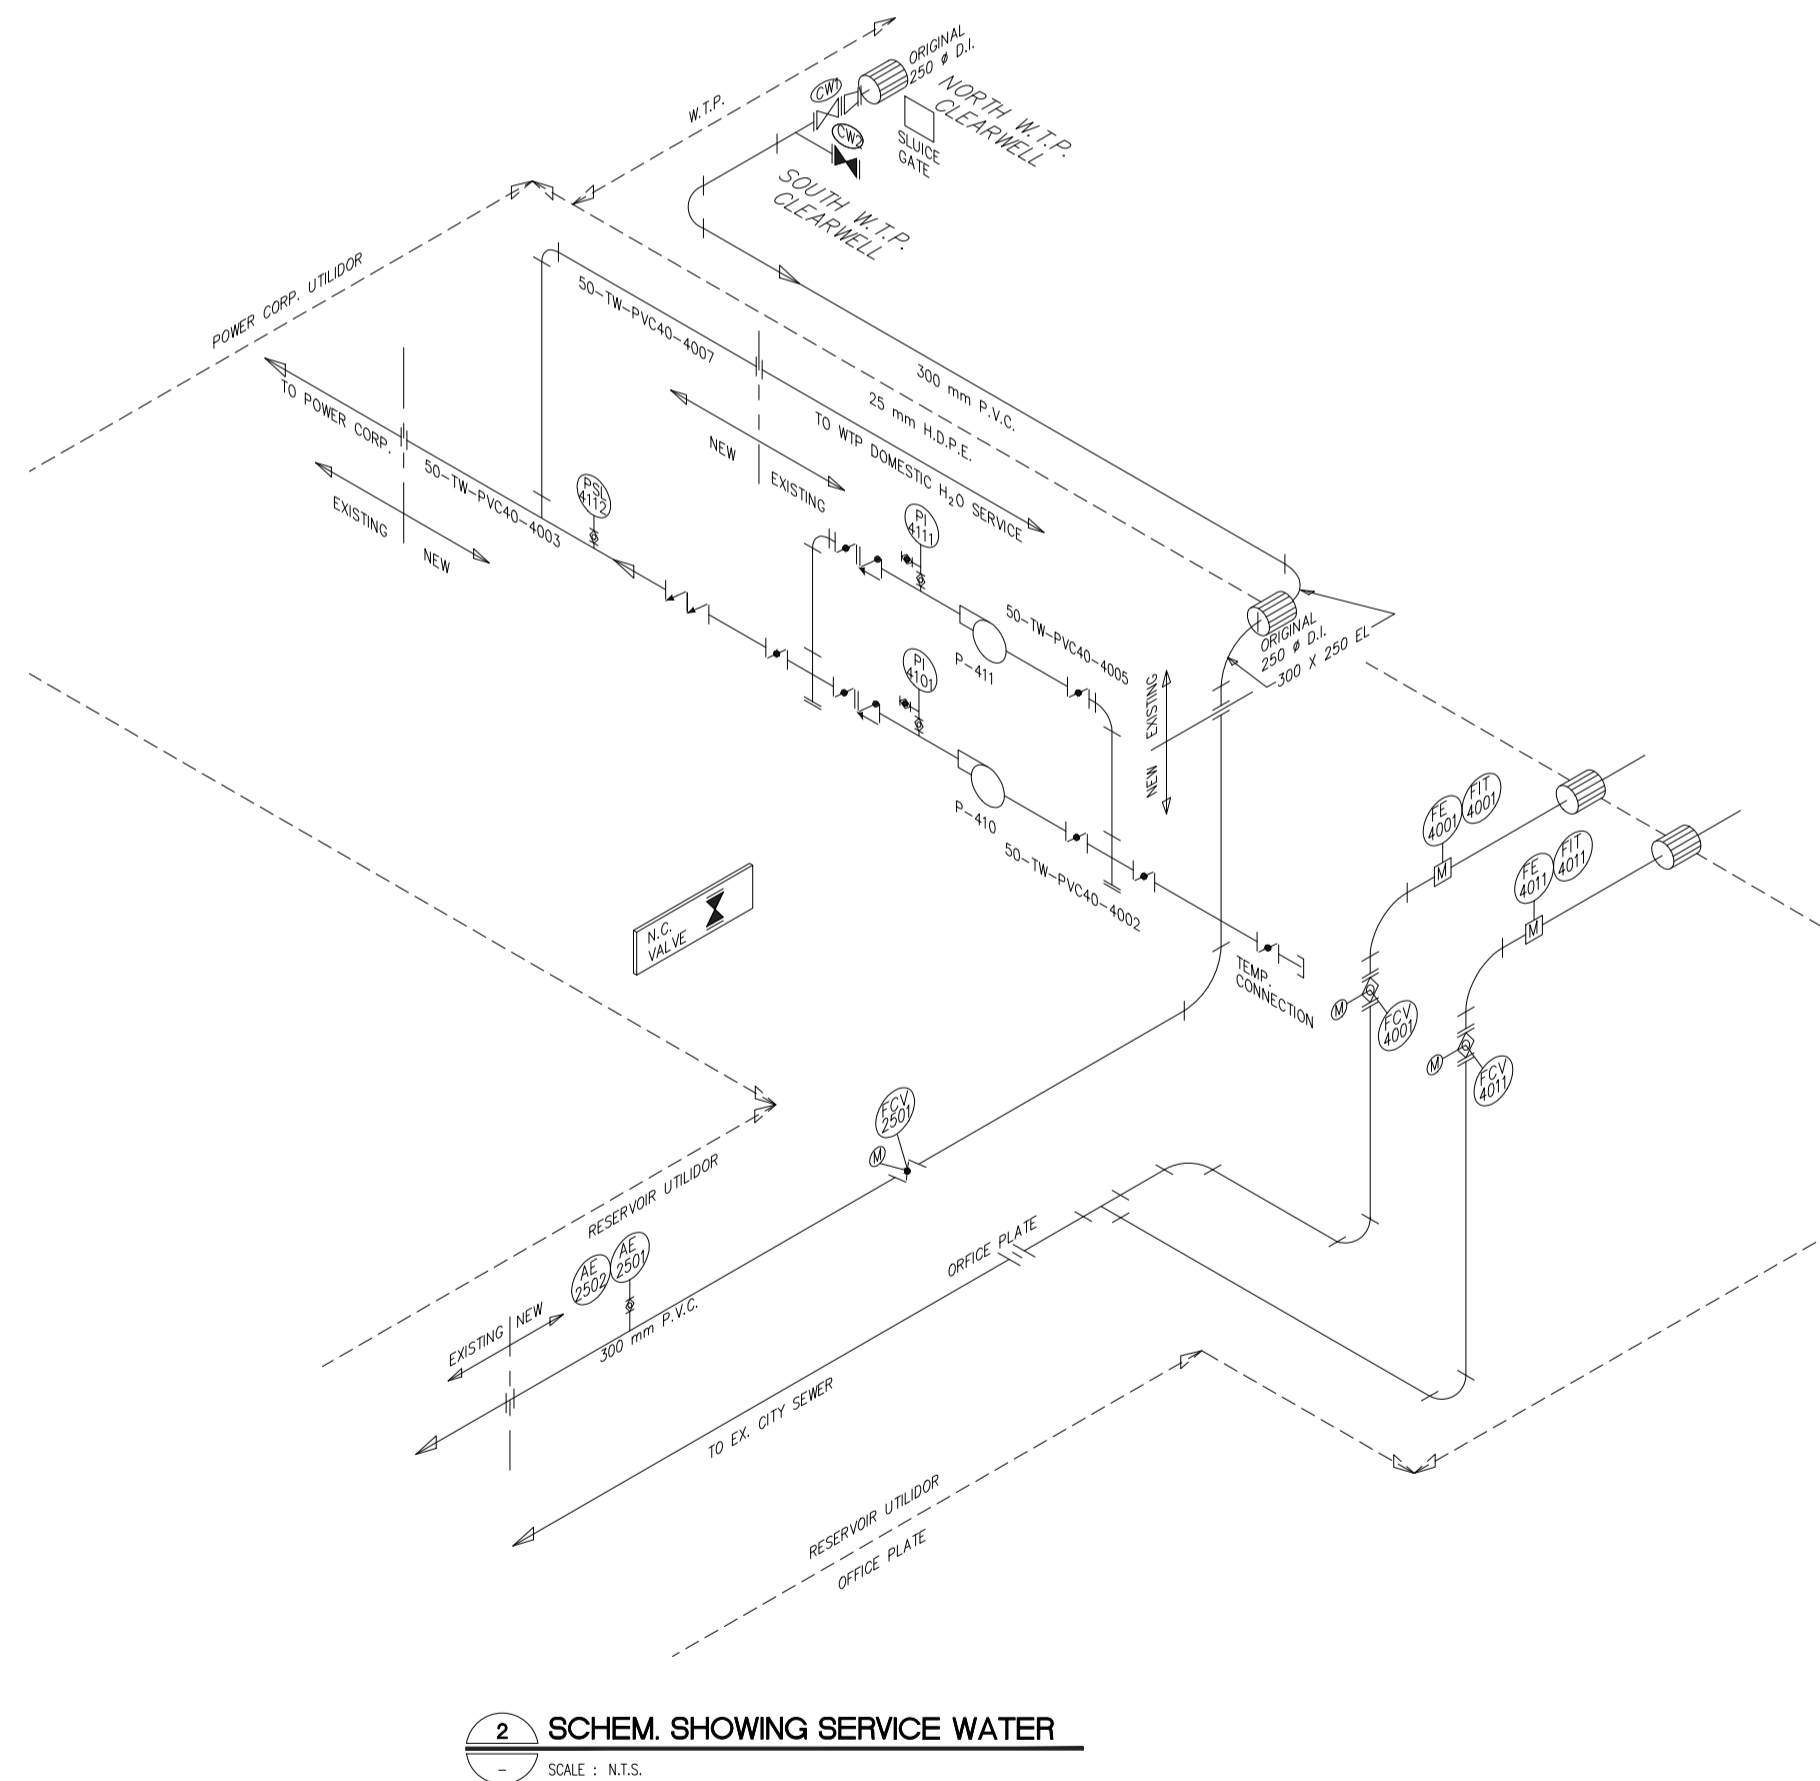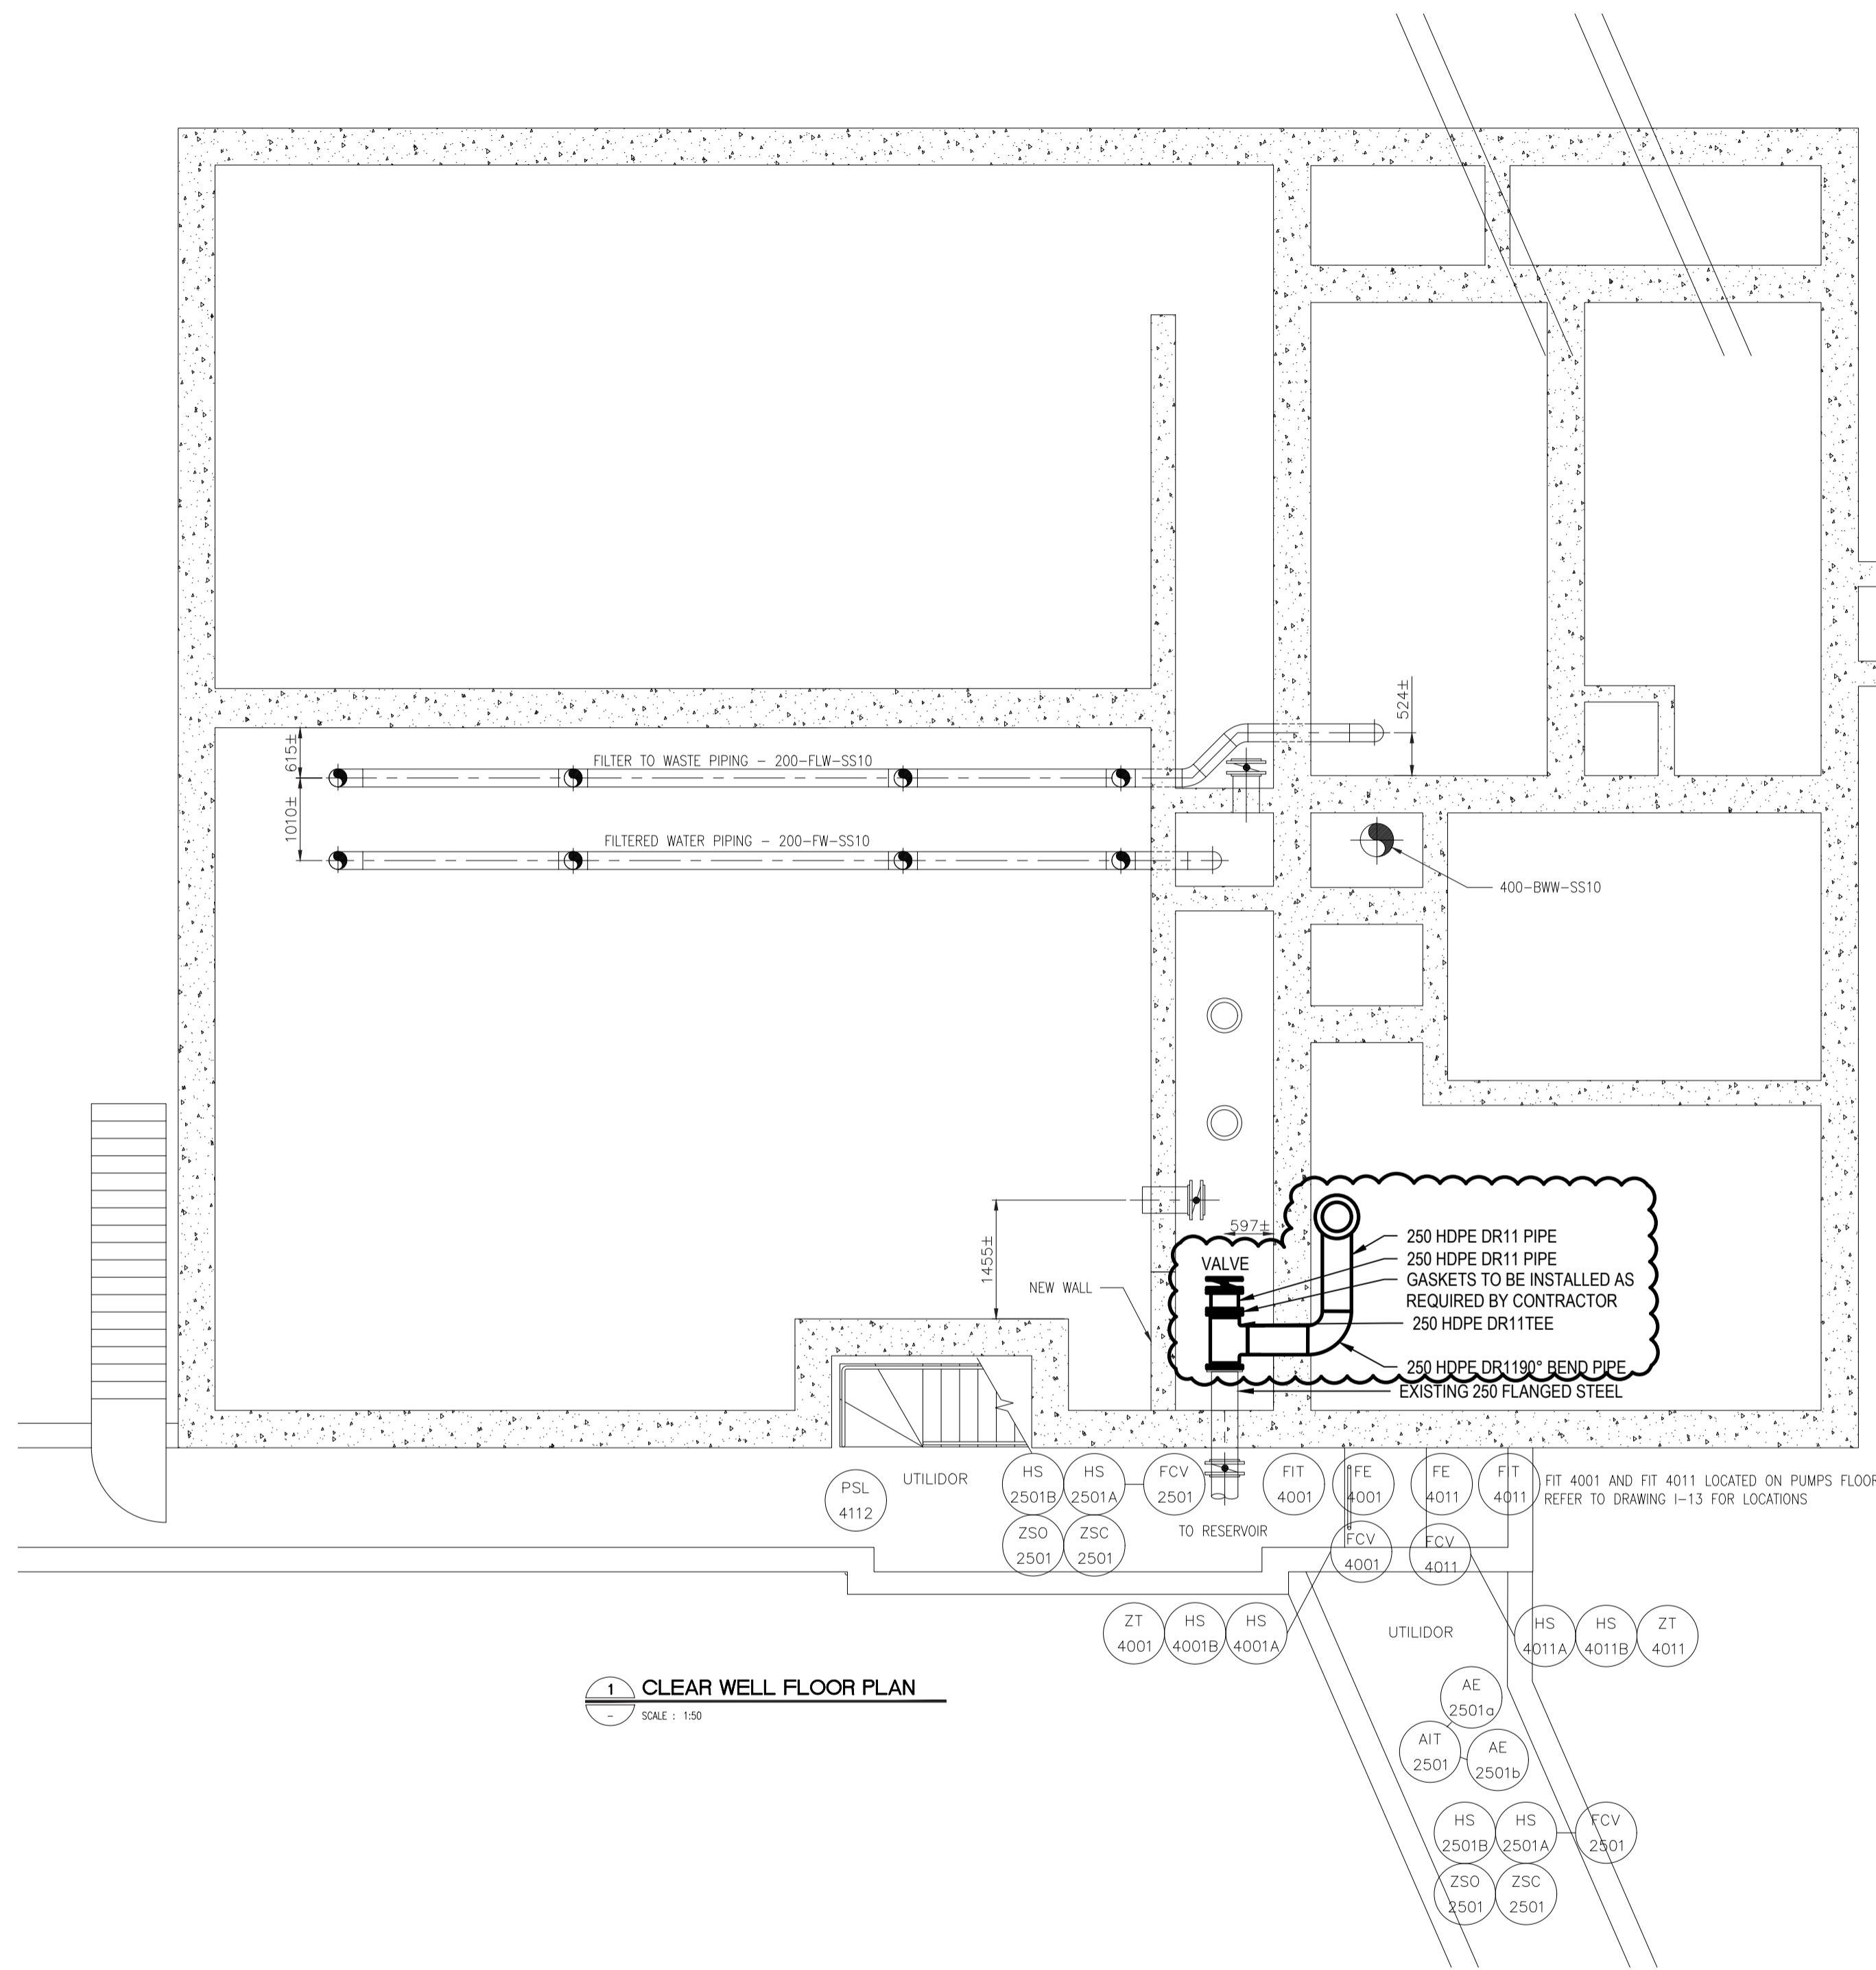

REVISION:				REVISION:			
REV	DATE	DESCRIPTION	BY	REV	DATE	DESCRIPTION	BY
A	2021/11/18	ISSUED FOR CONSTRUCTION	C.G.				

SEAL:

PERMIT TO PRACTICE

WSP Canada Inc.

Signature: *J.M. RAK-BANVILLE*

Date: November 18, 2021

PERMIT NUMBER: P407

NT/NU Association of Professional Engineers and Geoscientists

DISCLAIMER:

THIS DRAWING AND DESIGN IS COPYRIGHT PROTECTED WHICH SHALL NOT BE USED, REPRODUCED OR REVISED WITHOUT WRITTEN PERMISSION BY WSP. THE CONTRACTOR SHALL CHECK AND VERIFY ALL DIMENSIONS AND UTILITY LOCATIONS AND REPORT ALL ERRORS AND OMISSIONS PRIOR TO COMMENCING WORK.

ORIGINAL SCALE:

SCALE

DESIGNED BY:

C.G.

ASSISTED BY:

I.M.

DRAWN BY:

V.A.A

MODIFIED BY:

V.A.A

APPROVED BY:

J.R.-B.

DISCIPLINE:

INFRASTRUCTURE

DATE:

2021/11/18

IF THIS BAR IS NOT 25mm LONG, ADJUST YOUR PLOTTING SCALE.

WSP Canada Inc.
1600 Buffalo Place, Winnipeg, Manitoba R3T 6B8
T 204-477-6650 | www.wsp.com

CLIENT:

IQALUIT WATER TREATMENT PLANT UPGRADE
City of Iqaluit, Nunavut

PROJECT NUMBER: 201-09487-00

CLIENT REF. #: -

TITLE:

UNUSED FILTERED WATER TANK (1962)

PROJECT:



IQALUIT WATER EMERGENCY

 
DRAWING NUMBER:

P-103

REV:

A

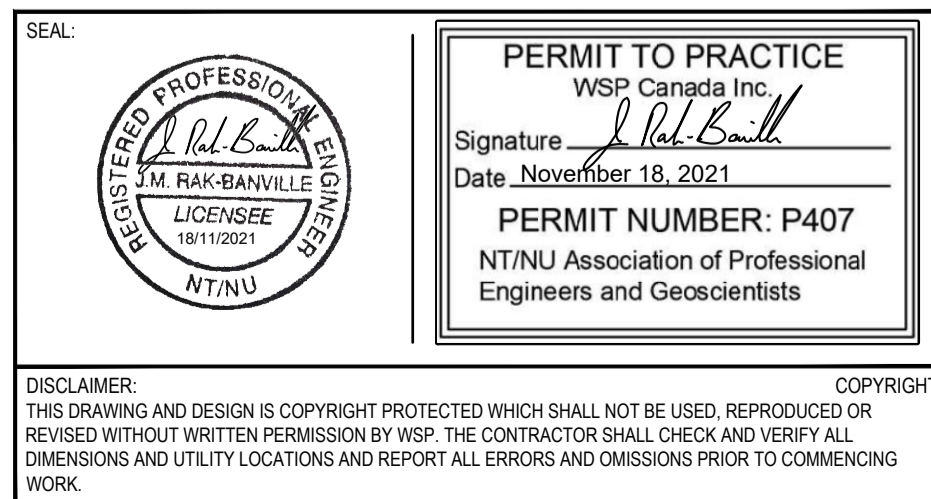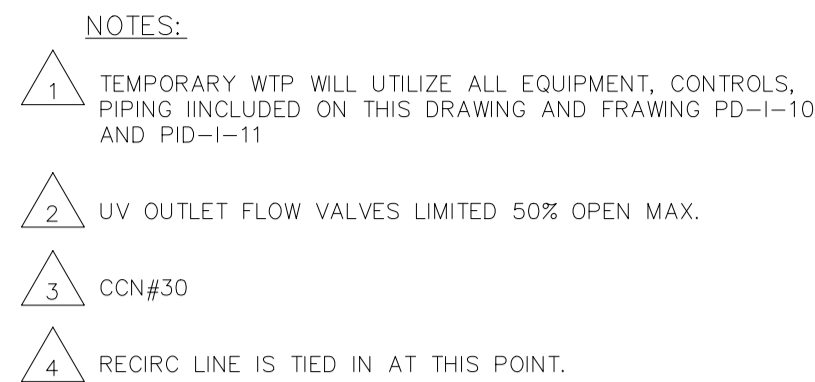

ORIGINAL SCALE	DATE
SCALE	2021/11/18
DESIGNED BY:	
C.G.	
ASSISTED BY:	
I.M.	
DRAWN BY:	
V.A.A	
MODIFIED BY:	
V.A.A.	
APPROVED BY:	
J.R.-B.	
DISCIPLINE: INFRASTRUCTURE	IF THIS BAR IS NOT 25mm LONG, ADJUST YOUR PLOTTING SCALE. 

WSP

WSP Canada Inc.
1600 Buffalo Place, Winnipeg, Manitoba R3T 6B8
T 204-477-6650 | www.wsp.com

PROJECT NUMBER: 201-09487-00

CLIENT:

Iqaluit



**IQALUIT WATER TREATMENT PLANT
UPGRADE**

City of Iqaluit, Nunavut

CLIENT REF. #:

TITLE: PID 1

PROJECT:	
IQALUIT WATER EMERGENCY	
DRAWING NUMBER:	REV:
P-104	A

