


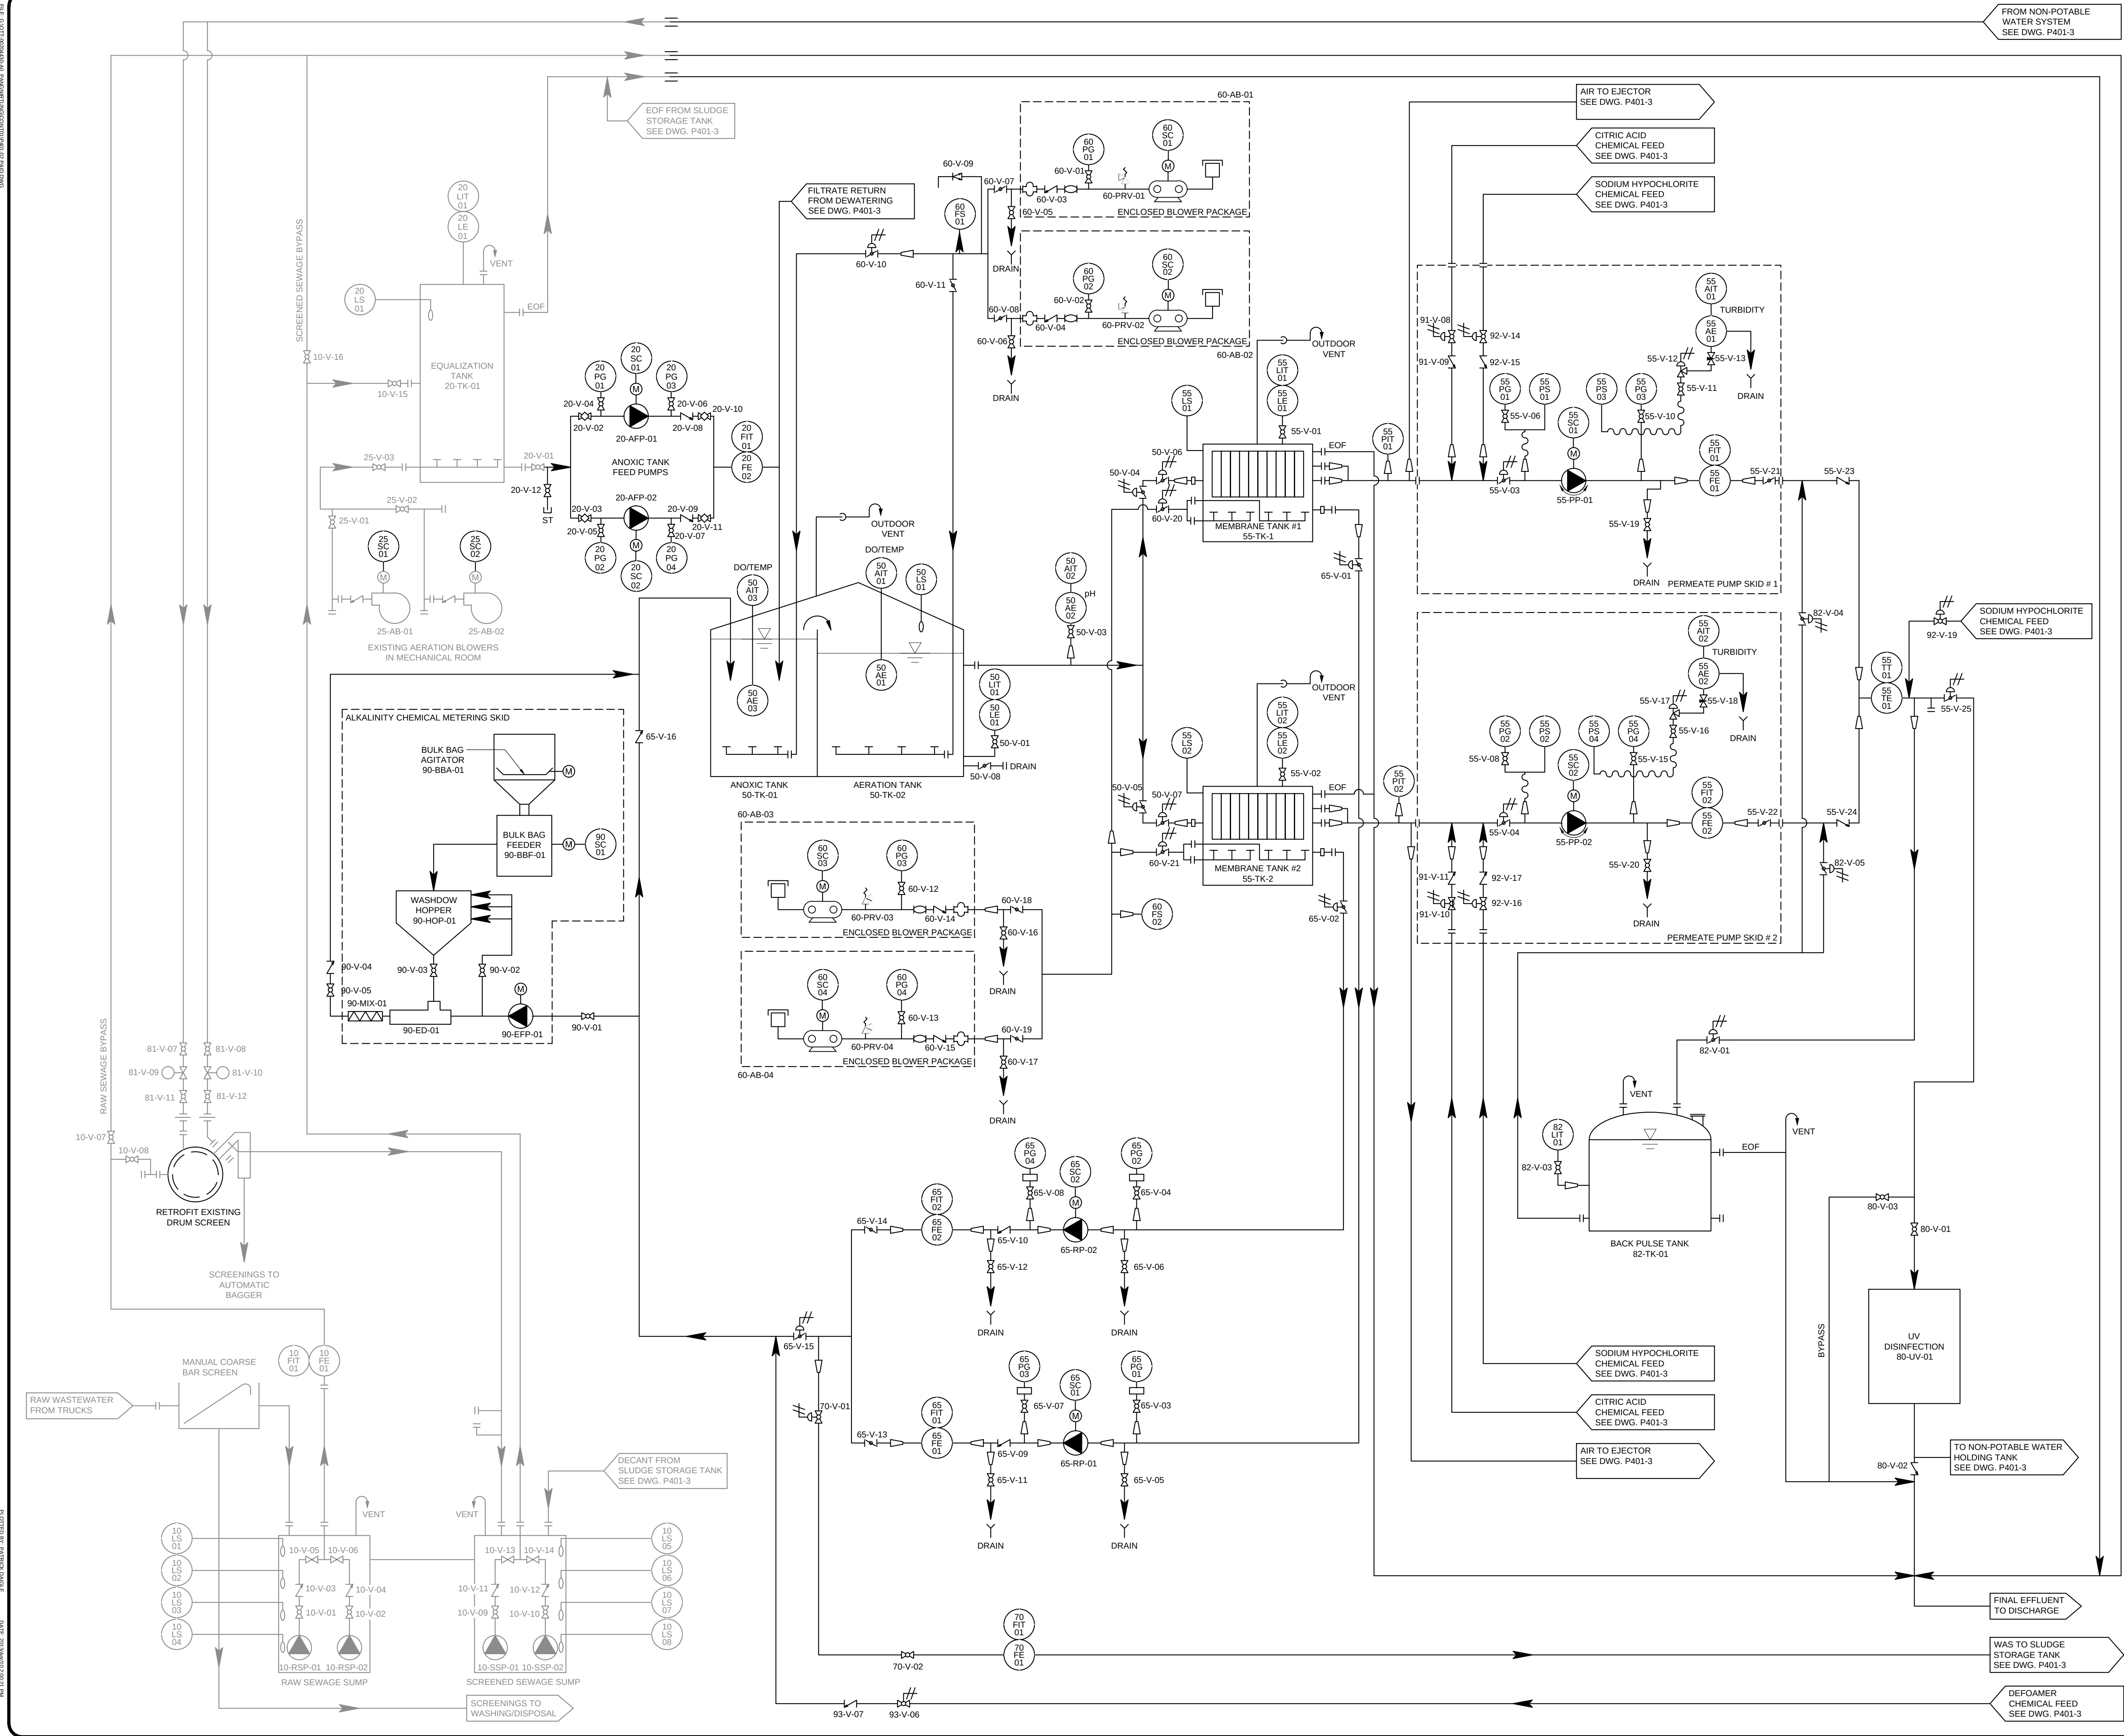

No.	Issue	Date
1	60% REVIEW SUBMISSION	2013-MAR-08
2	ISSUED FOR TENDER	2013-APR-10

No.	Revision	Ckd. By	Date

FOR INFORMATION ONLY

	Const. North
	Drawn By: ARL/MCO
	Dwg. Standards Ckd. By: PD
	Designed By: DFB
Date Printed	Dwg. Design Ckd. By: SAO

exp Services Inc.
 t: +1.613.688.1899 | f: +1.613.225.7330
 2650 Queensview Drive, Unit 100
 Ottawa, ON K2B 8H6
 CANADA
www.exp.com

• BUILDINGS • EARTH & ENVIRONMENT • ENERGY •
 • INDUSTRIAL • INFRASTRUCTURE • SUSTAINABILITY •

Project Title
WASTE WATER TREATMENT PLANT UPGRADE PANGNIRTUNG, NU

Dwg. Title
PROCESS AND INSTRUMENTATION DIAGRAM (P&ID)

Project No. **OTT-00204430-A0**
 Dwg. No. **P401-2** Rev. No. **0**
 Scale
NOT TO SCALE
 This drawing is not to be scaled